



**GENERAL NOTES**

- DO NOT SCALE THIS DRAWING. WORK ONLY TO FIGURED DIMENSIONS.
- FOR ALL RELEVANT NOTES, REFER TO STRUCTURAL AND CIVIL ENGINEERING PERFORMANCE SPECIFICATION.
- ANY DISCREPANCIES ARE TO BE REPORTED TO PINNACLE CONSULTING ENGINEERS IMMEDIATELY.
- THIS DRAWING IS TO BE READ IN CONJUNCTION WITH ALL OTHER RELEVANT ENGINEERS, ARCHITECTS AND SUB-CONTRACTORS DRAWINGS AND DETAILS.

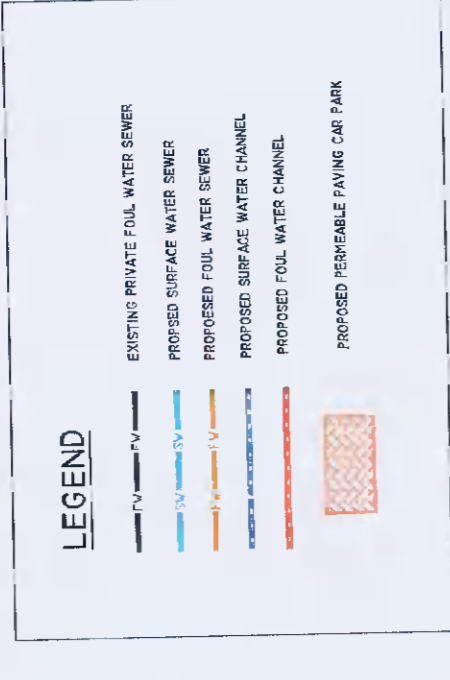

CONTINUE 0200

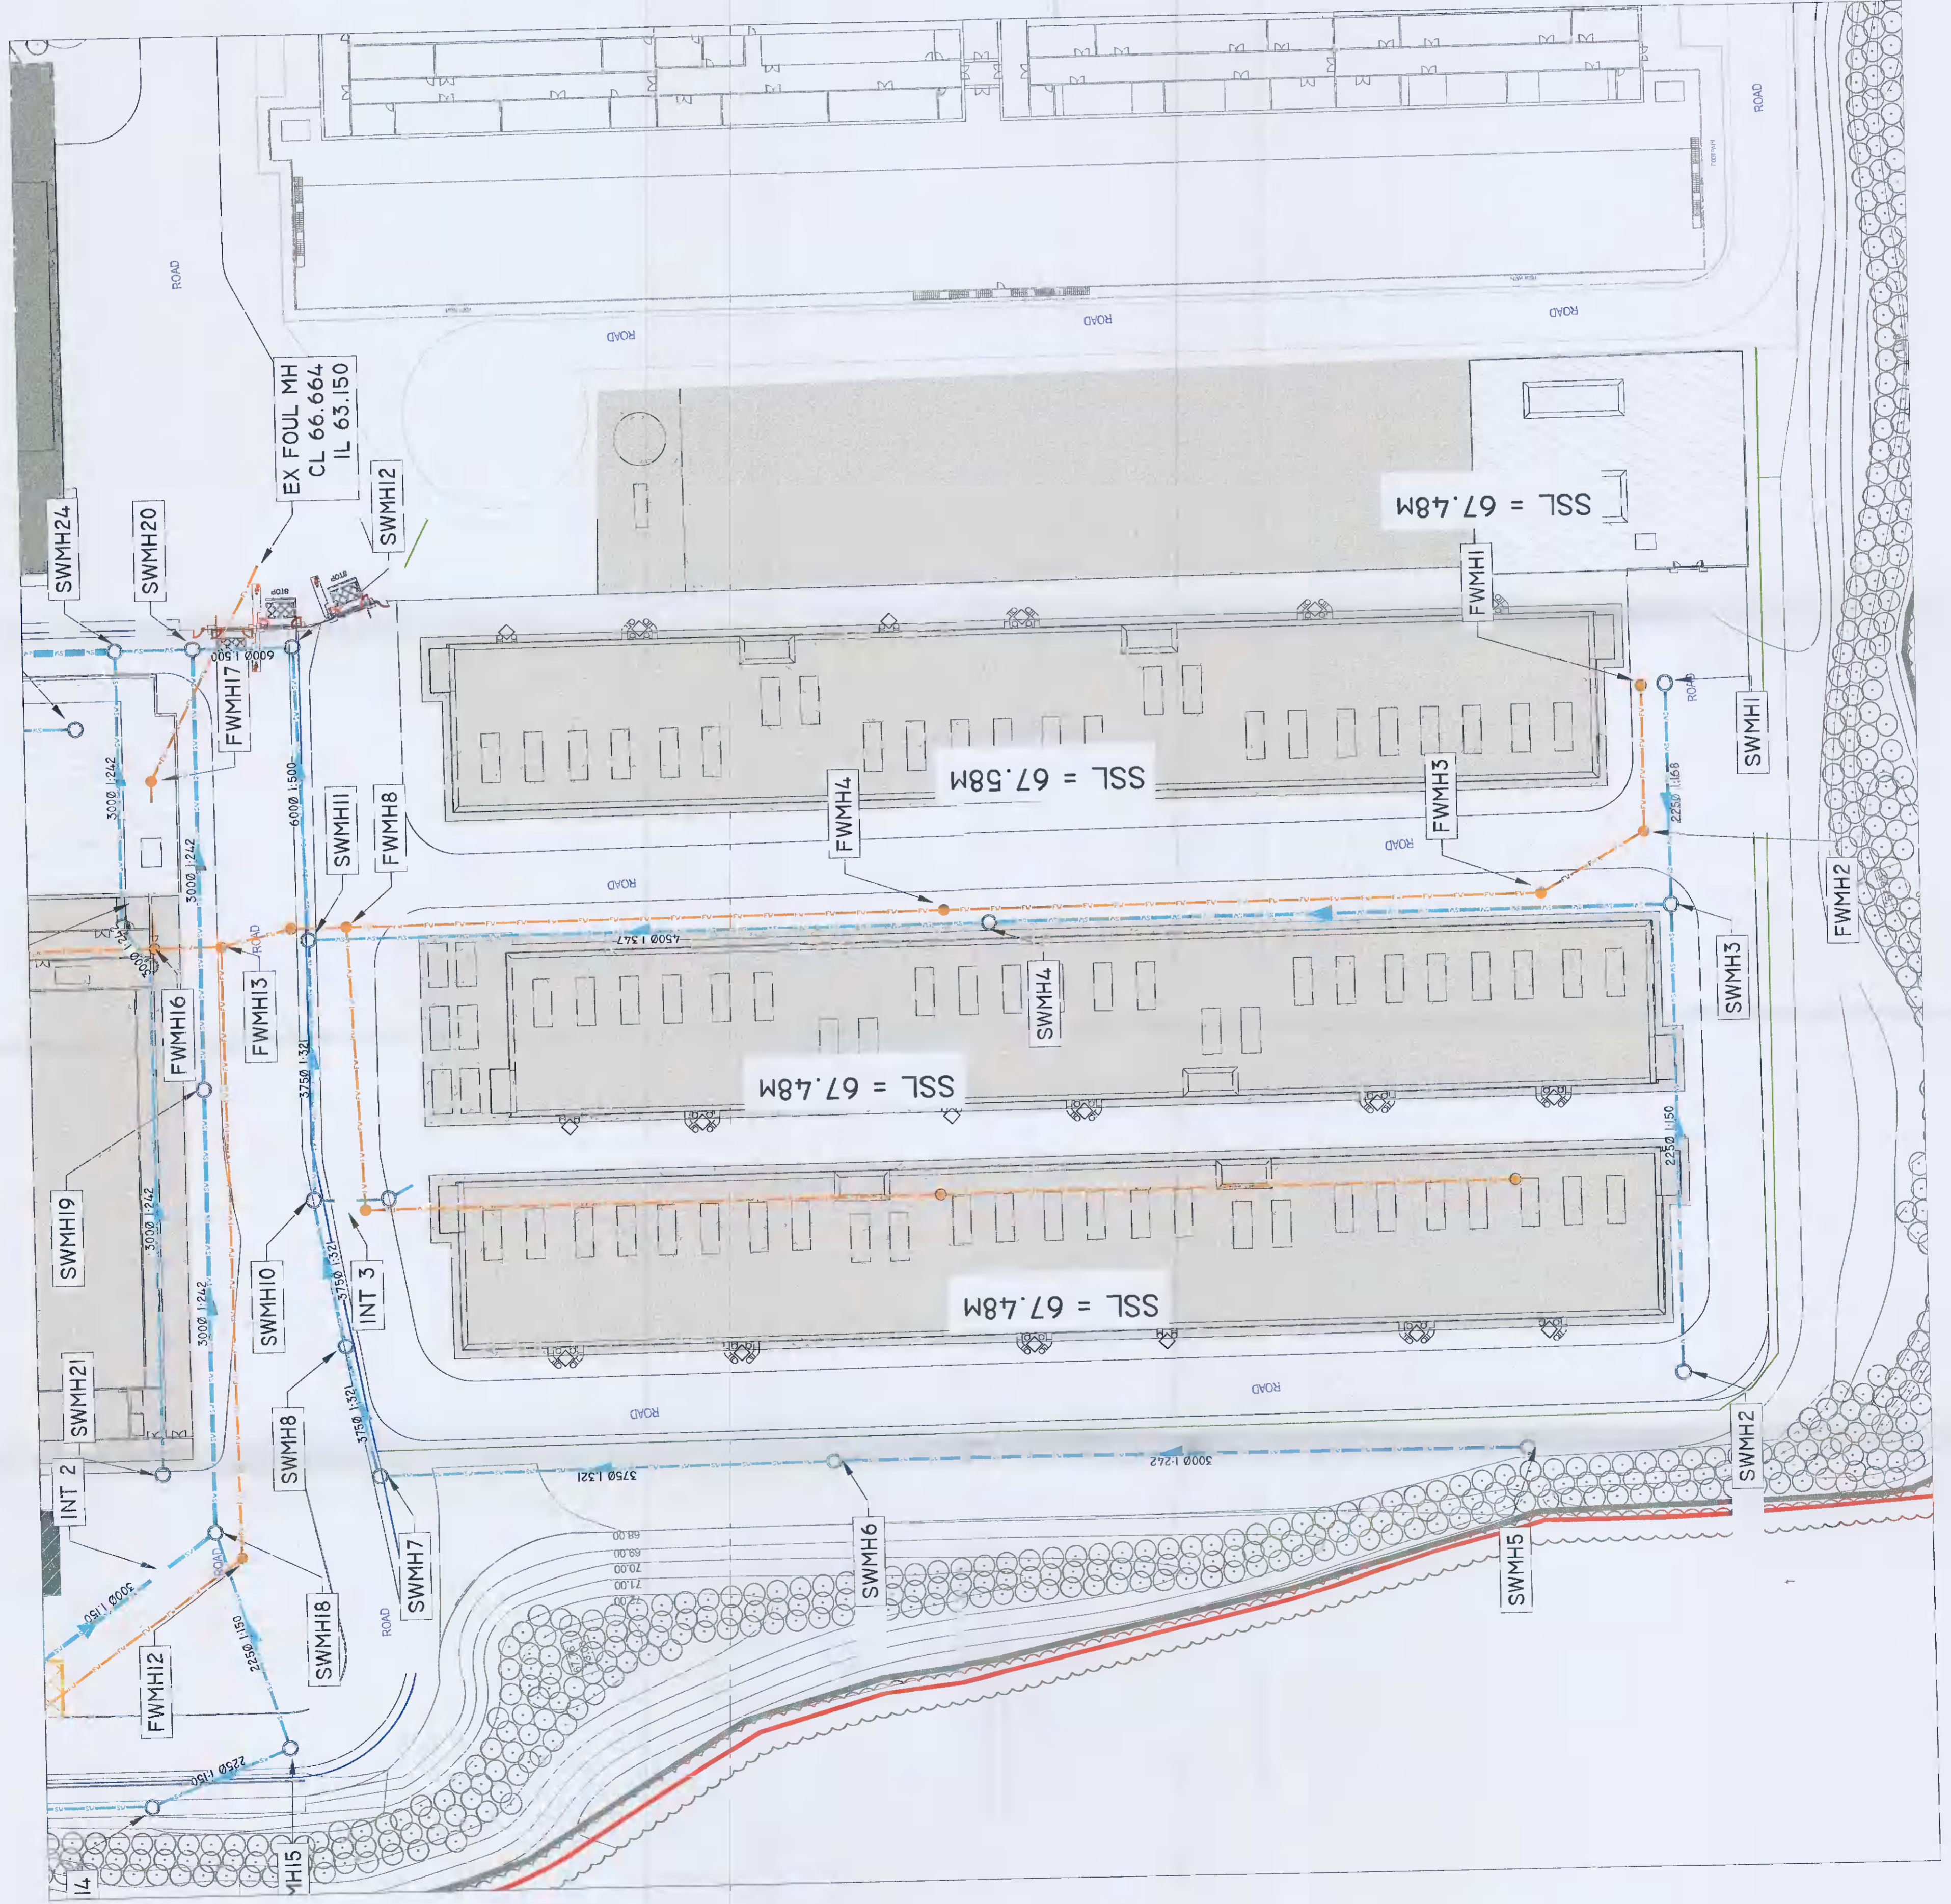

REV	DESCRIPTION	BY	CHK	DATE

CLIENT  
**EDGECONNEX**

PROJECT  
**EDCDUB05  
& GAS PLANT**

DRAWING TITLE  
**DRAINAGE LAYOUT  
DATA CENTRE**

**PINNACLE**  
CONSULTING ENGINEERS

GROSSBECK COURT,  
DUN LAOGHAIRE,  
COUNTY DUBLIN,  
IRELAND.  
WELLYN GARDEN CITY | NORWICH | LONDON | THE HAGUE  
TELEPHONE: +353 1 231 1041

DRAWING STATUS			
SCALE @ AI	DATE	DRAWN BY	CHECKED
1:500	DEC '20	JM	JKM
Dwg No		Revision	
PIN-05-ZZ-DR-C-0201		P01	

REF: P20103  
COPYRIGHT PINNACLE