



**ATTENUATION TANK PLAN**  
SCALE 1:50

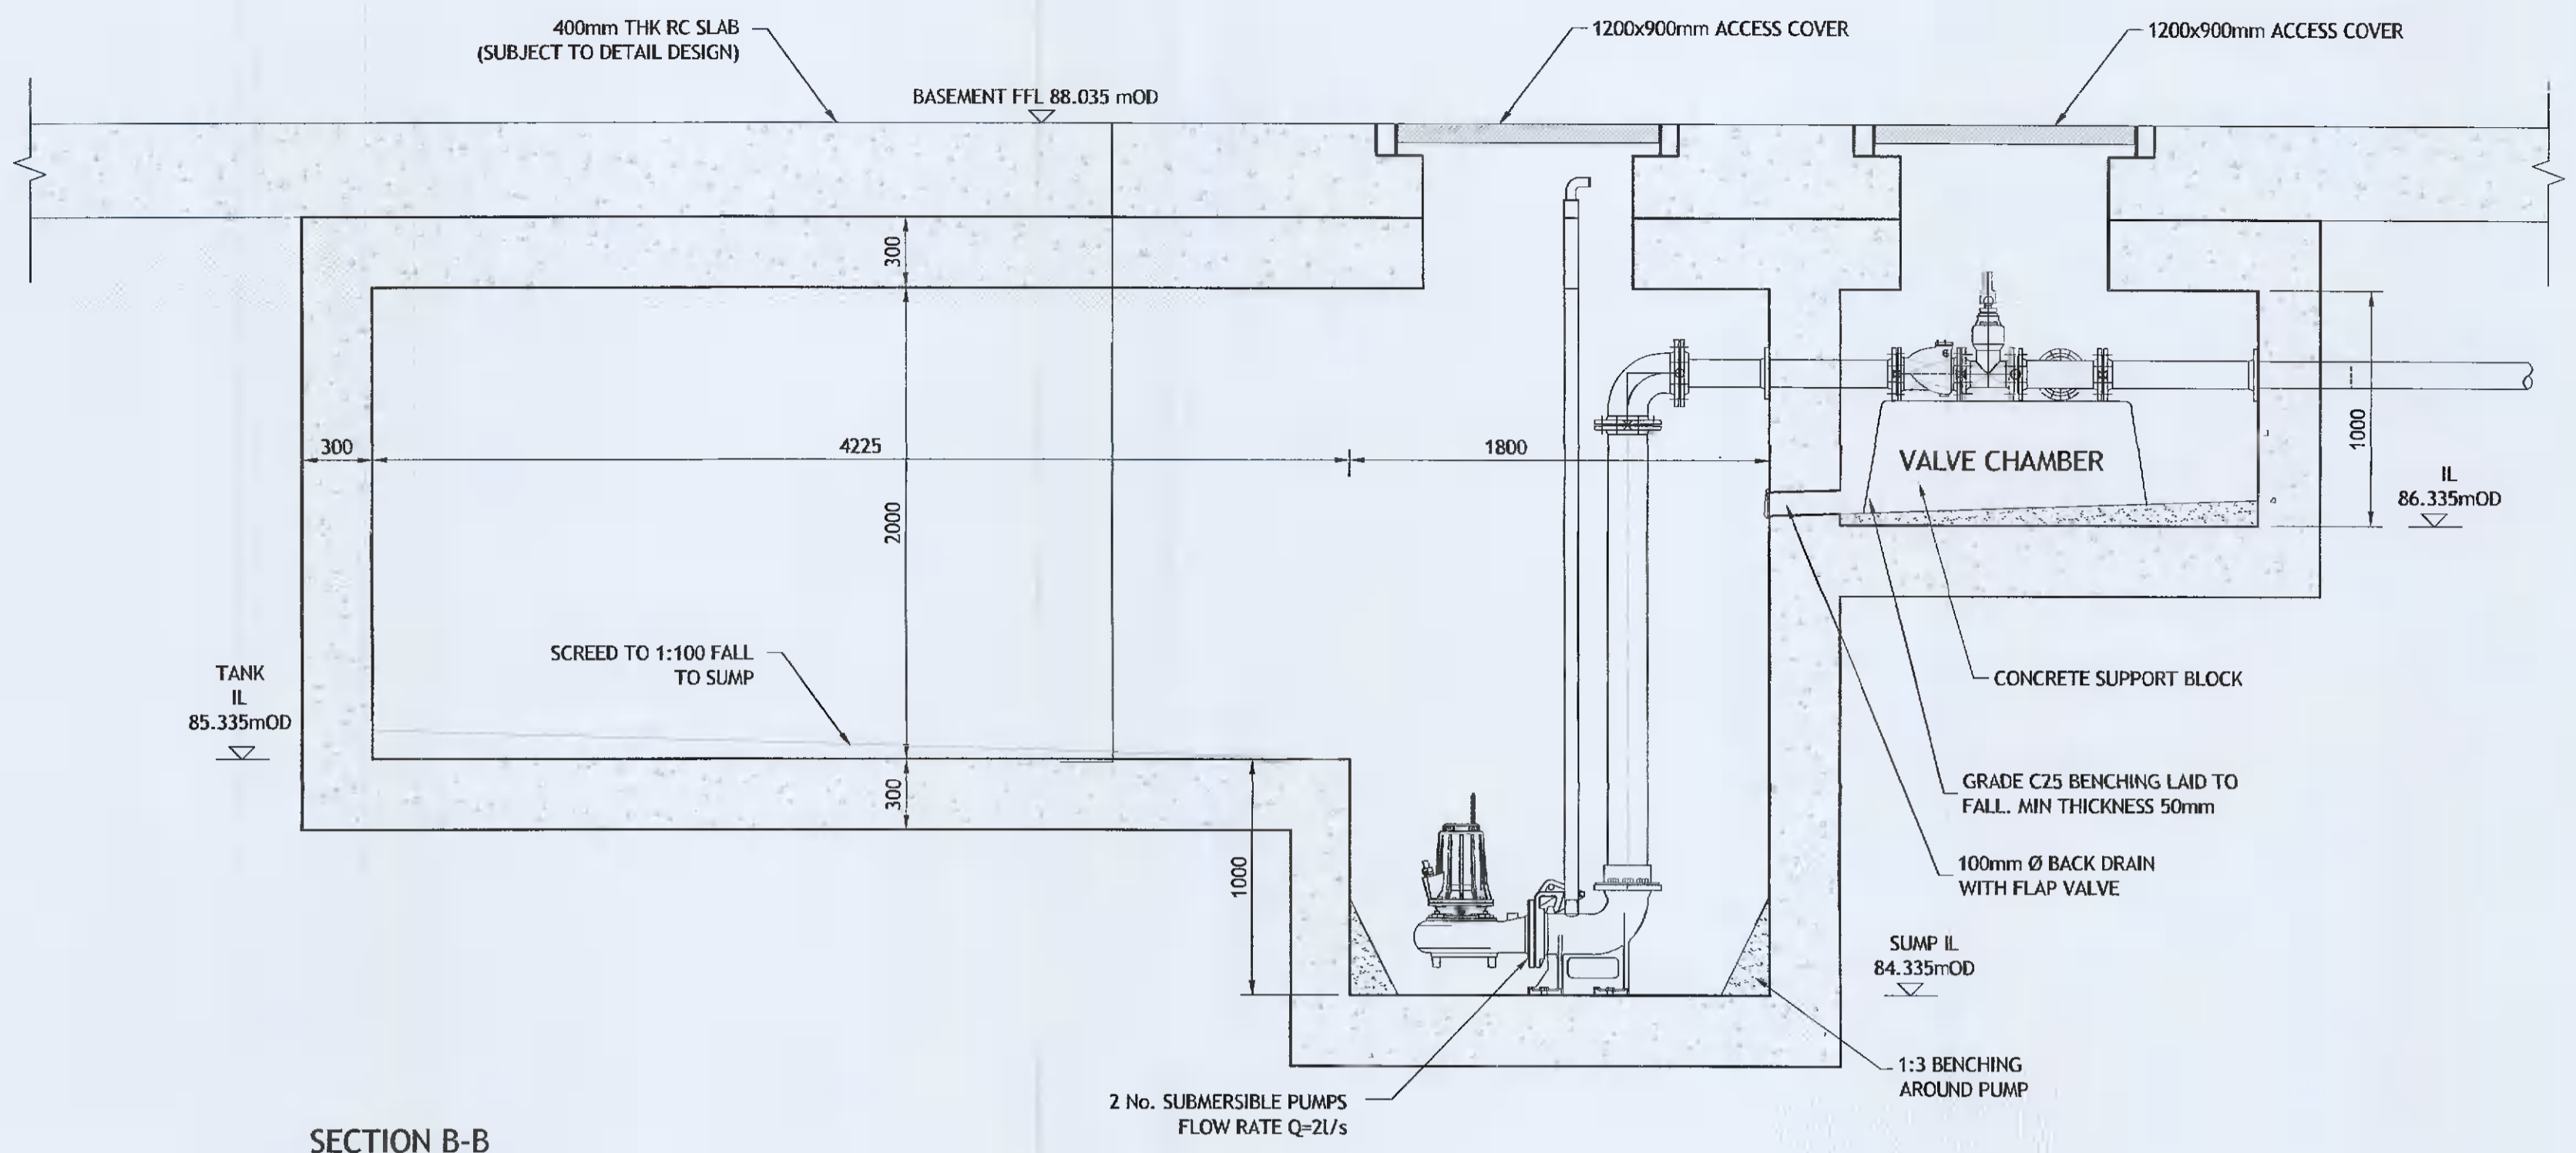

**SECTION B-B**  
SCALE 1:25

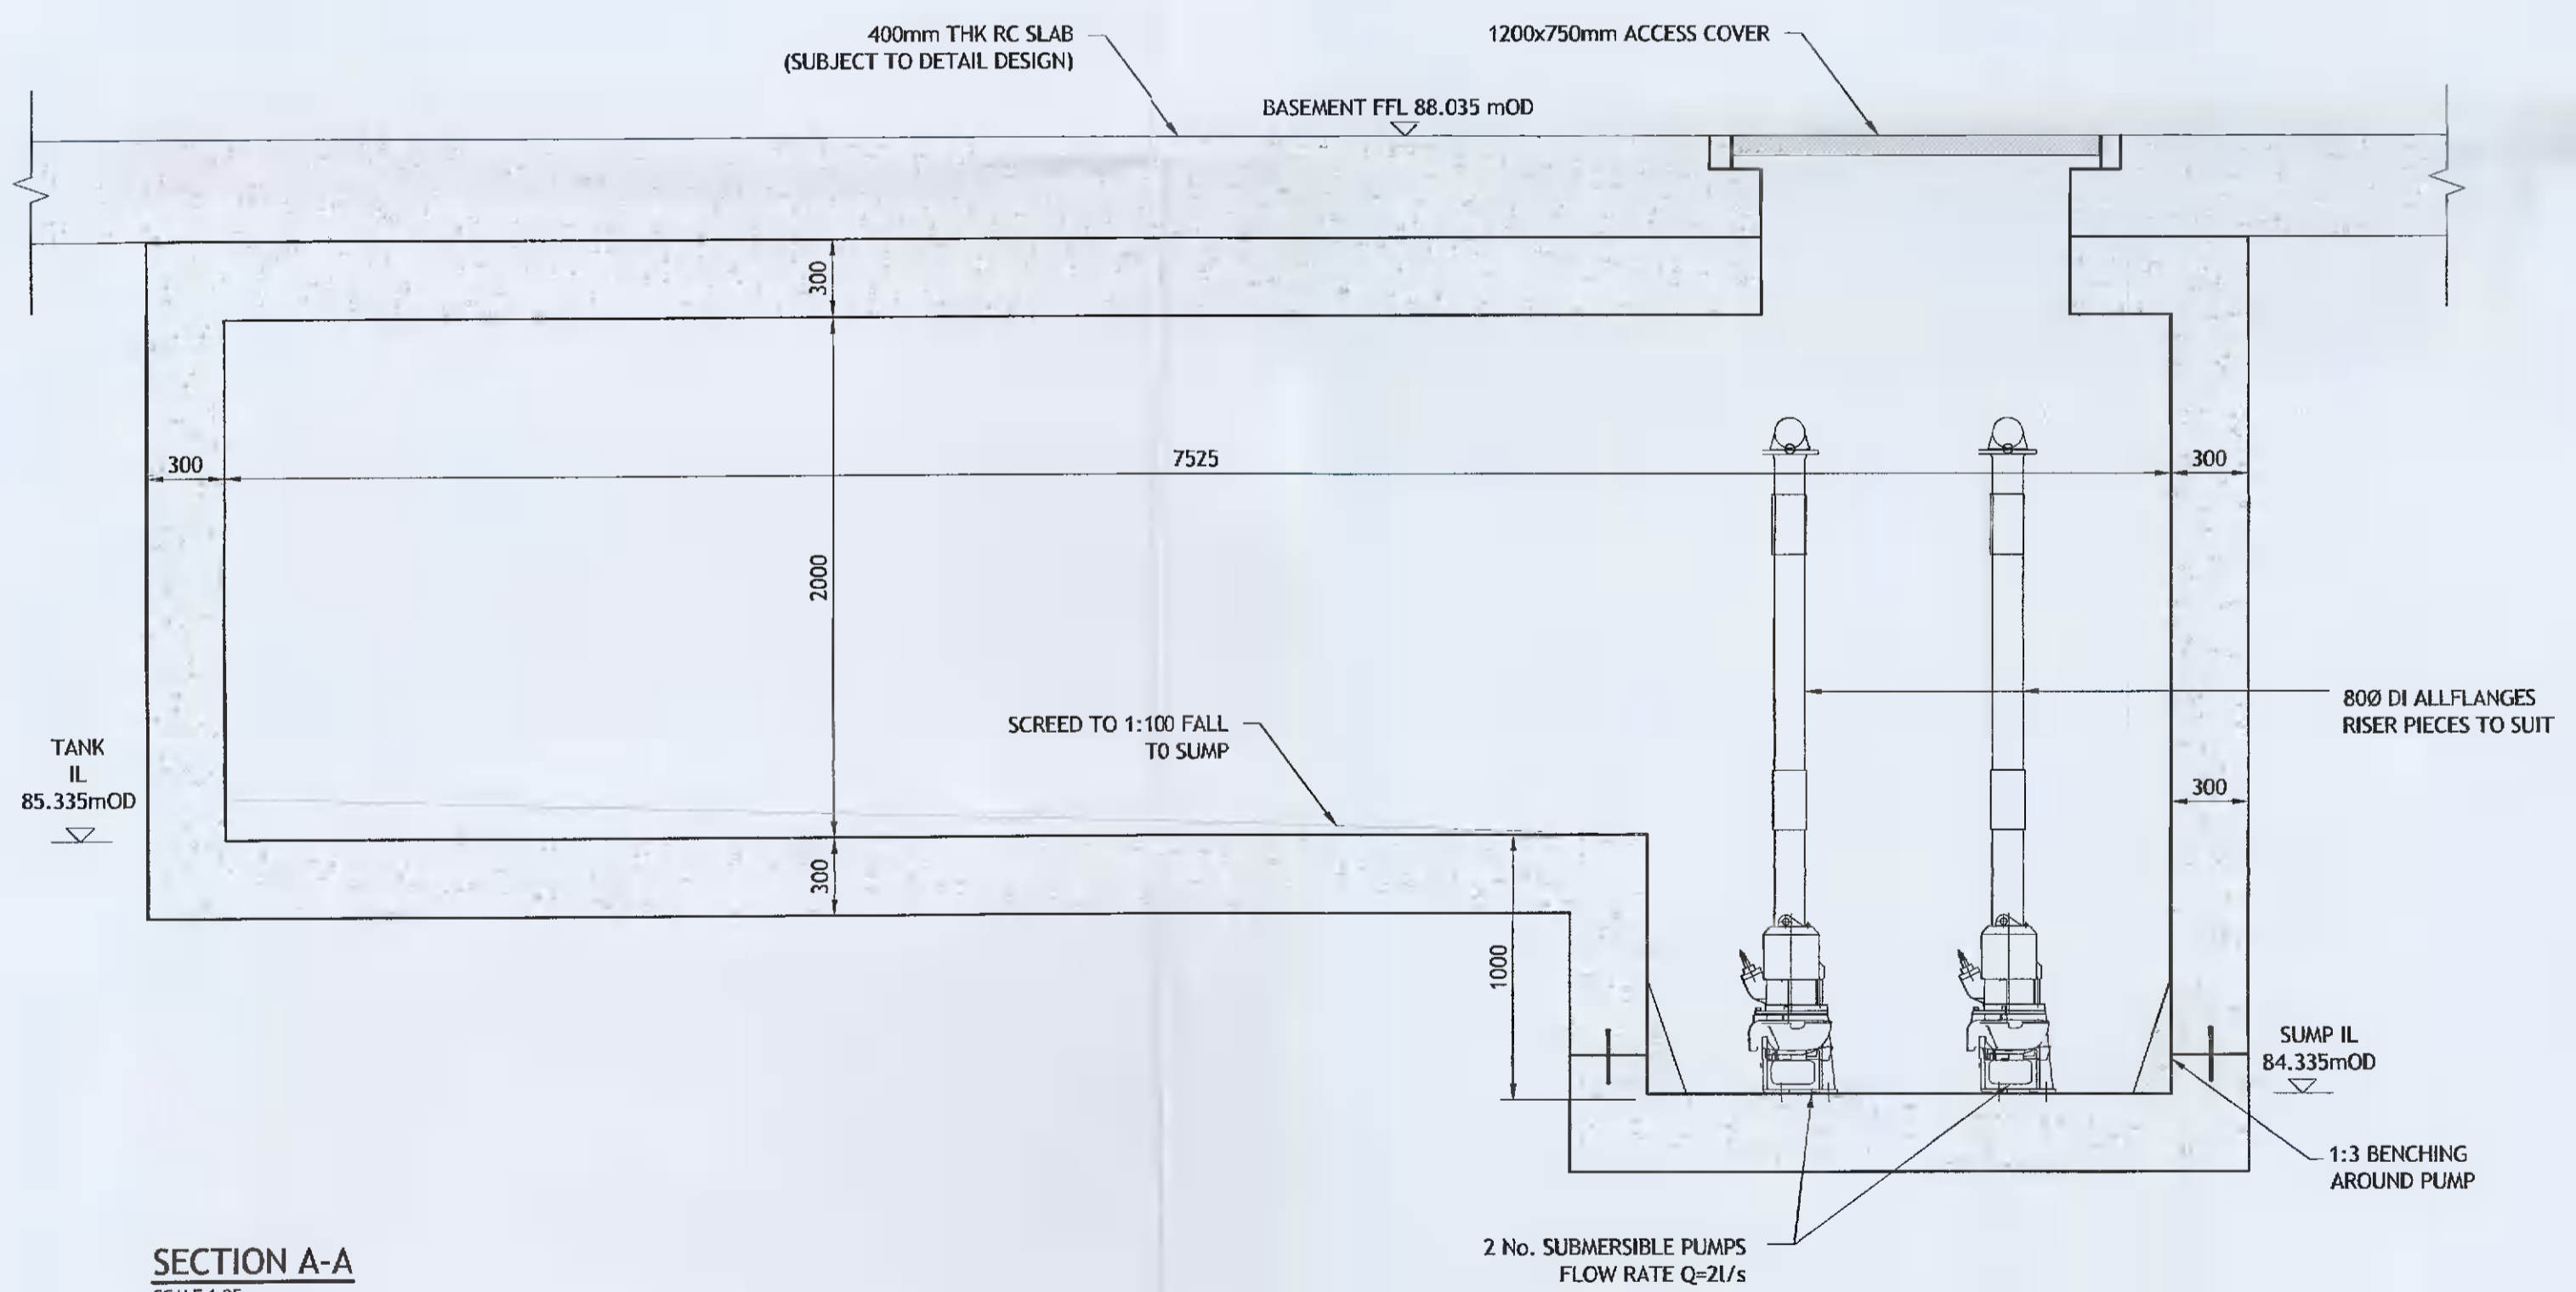

**SECTION A-A**  
SCALE 1:25

**PROPRIETARY PRODUCT NAMES, MANUFACTURER'S NAMES, SUPPLIERS NAMES, NATIONAL STANDARDS**

WHERE A SPECIFICATION OR A DESCRIPTION OF A PRODUCT OR ELEMENT OF WORK INCLUDES A SPECIFIC MAKE OR SOURCE SUCH AS A PRODUCT NAME OR MANUFACTURER'S NAME OR A SUPPLIER'S NAME, OR A NATIONAL STANDARD, THE SPECIFICATION OR DESCRIPTION SHALL BE DEEMED TO BE ACCOMPANIED BY THE WORDS "OR EQUIVALENT" NOTWITHSTANDING THAT THESE EXACT WORDS MAY NOT IN FACT ACCOMPANY THE NAME OR STANDARD. THIS ALSO APPLIES WHERE THE NAME OR STANDARD IS ACCOMPANIED BY OTHER WORDS SUCH AS "OR EQUAL APPROVED" OR SUCH-LIKE PHRASES.

- NOTES:**
- REFER TO DRAWING NO. 202253-PUNCH-XX-XX-DR-C-0100 FOR GROUND FLOOR DRAINAGE LAYOUT.
  - REFER TO DRAWING NO. 202253-PUNCH-XX-XX-DR-C-0101 FOR BASEMENT DRAINAGE LAYOUT.

**PUNCH Consulting Engineers**



Rev	Amendment	By	Date	Rev	Amendment	By	Date	Client:
CD1	PLANNING ISSUE	IBS	14/05/2021					

**PUNCH**  
consulting engineers

Dublin | Limerick | Cork | Galway | Glasgow  
Carmegie House Library Road,  
Dun Laoghaire, Co. Dublin, A96 C7W7  
t: 01 271 2200 | w: punchconsulting.com

Project: GREENHILLS ROAD DEVELOPMENT, TALLAGHT, DUBLIN 24			
Title: ATTENUATION TANK DETAILS			
Drawn: IBS	Date Drawn: MARCH 2021	Technician Check: IBS	Engineer Check: MR
Project: 202253	Approved: 202253-PUNCH-XX-XX-M2-C-0500	Drawing Status: AD PLANNING	Revised By: CD1
Scale: 1:200	Drawn: 202253-PUNCH-XX-XX-DR-C-0500	Revised: CD1	