
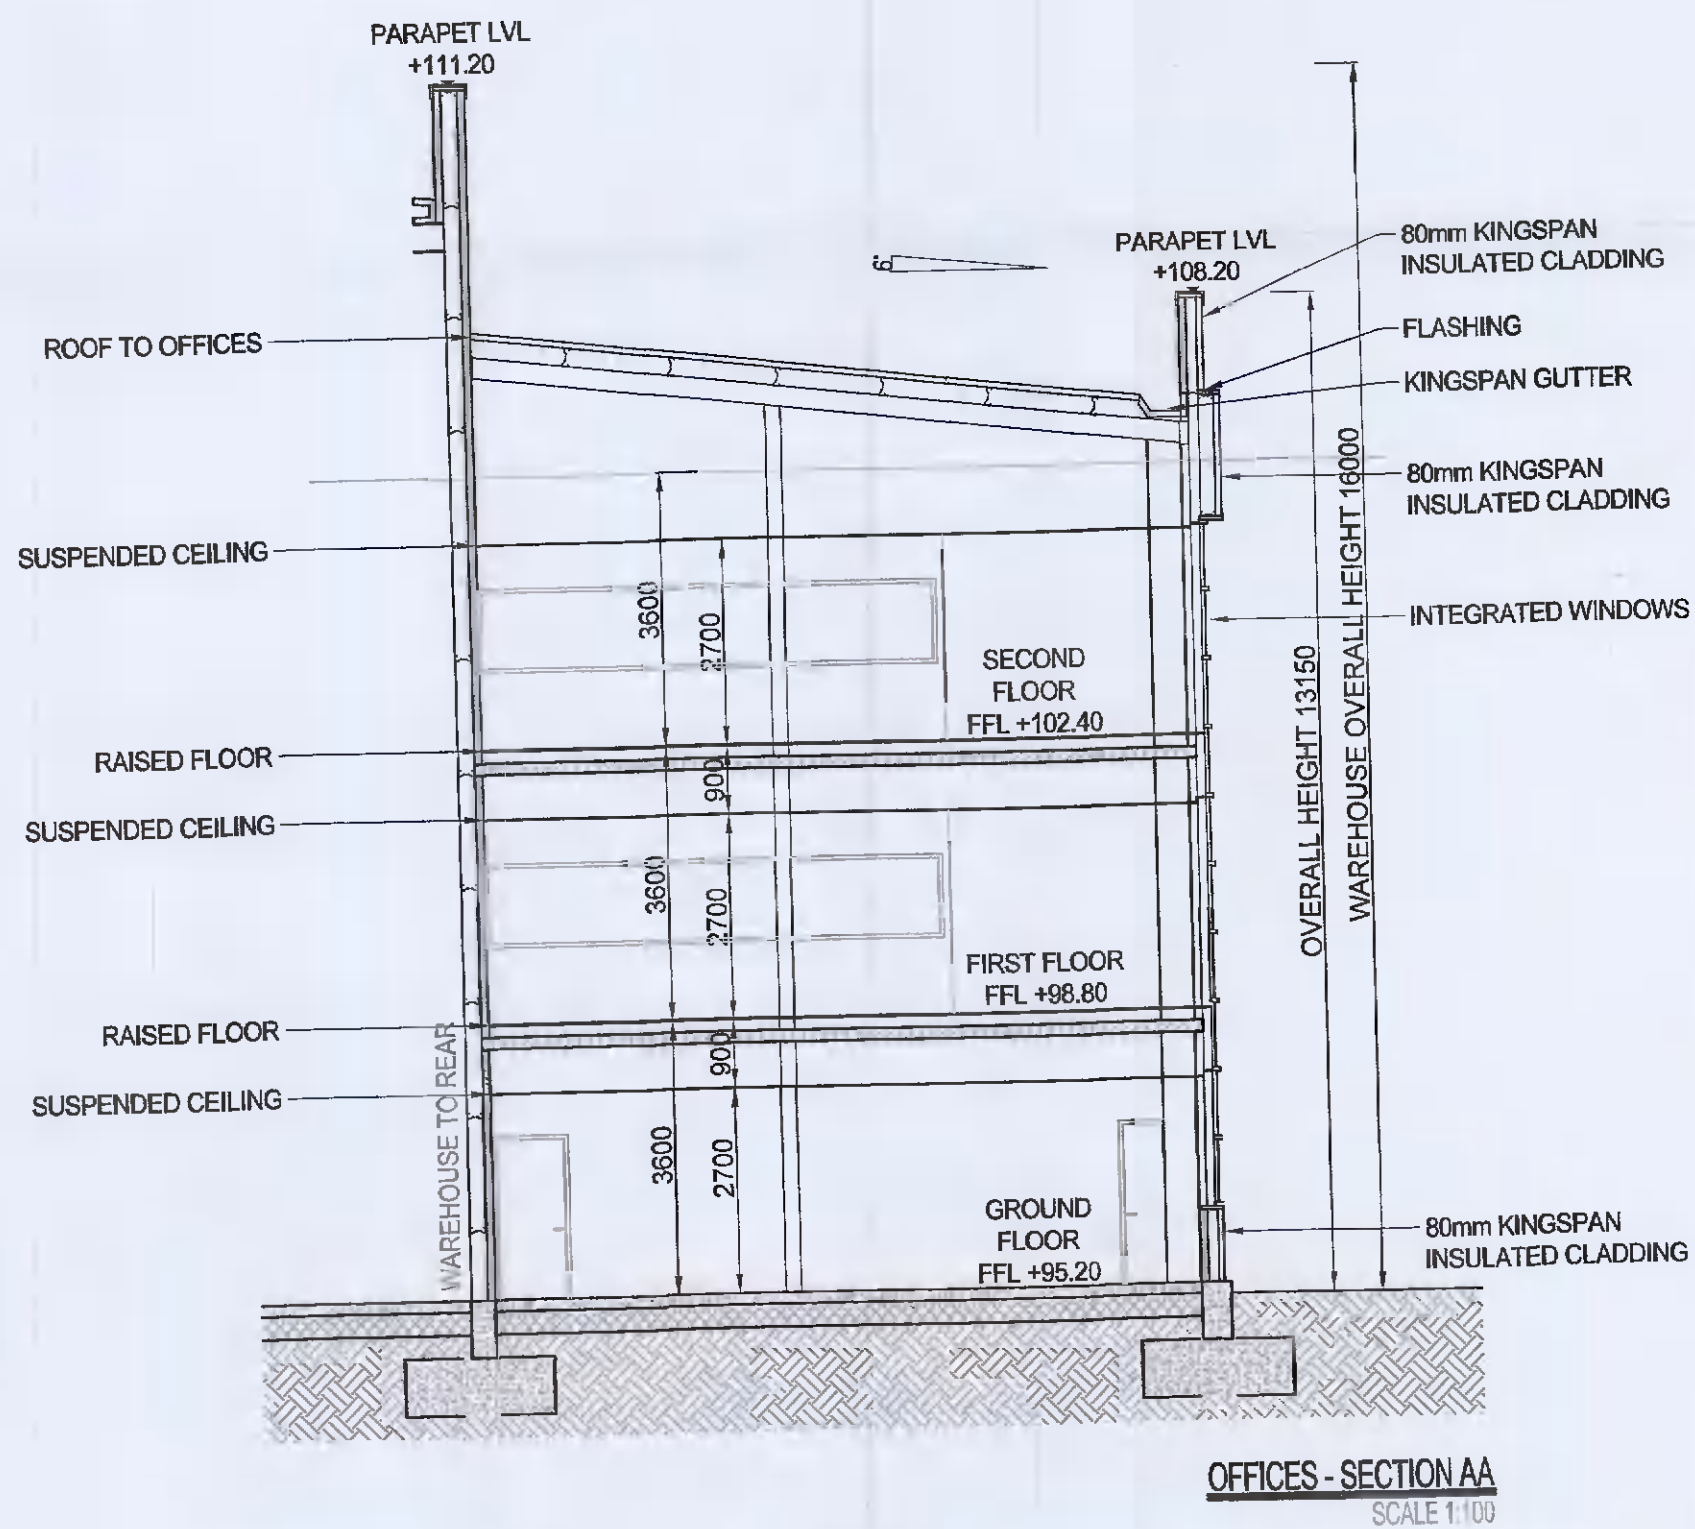
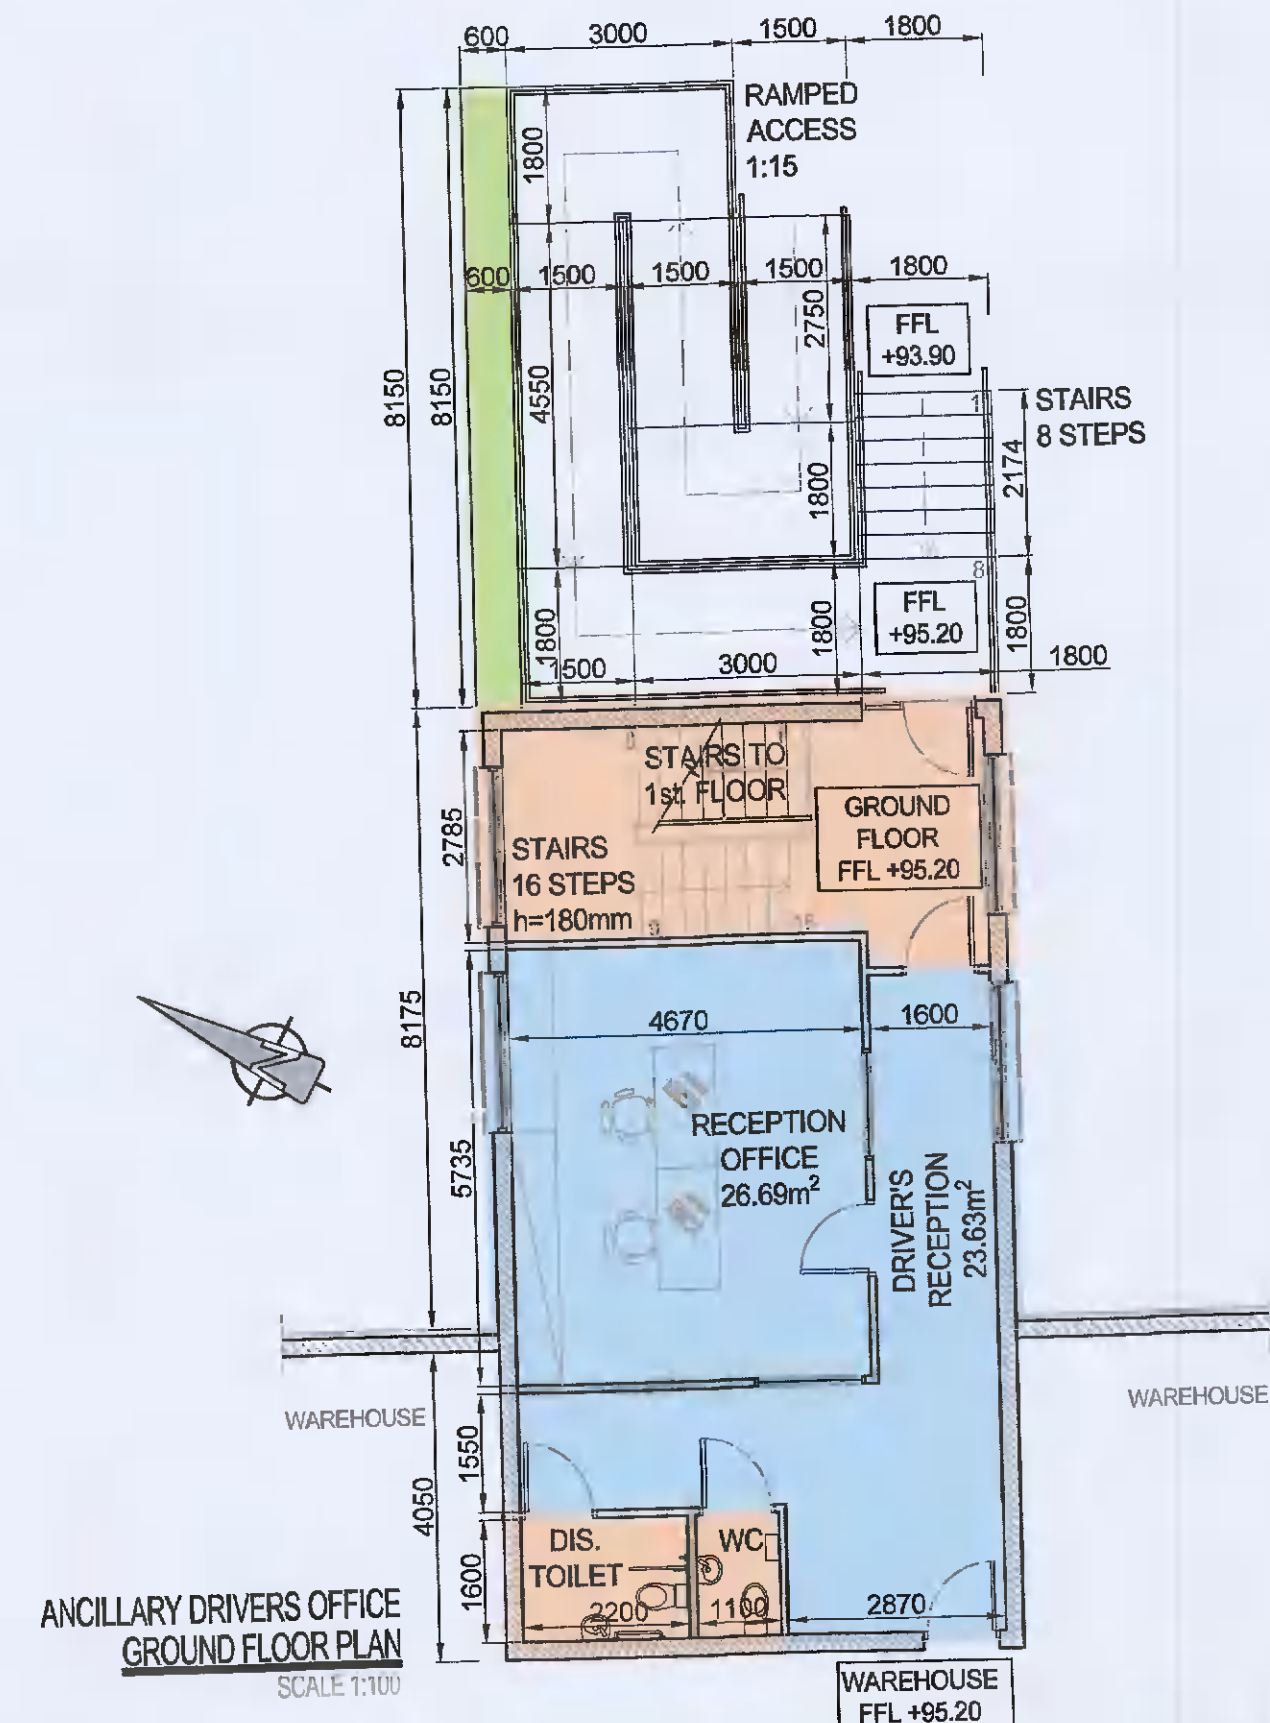
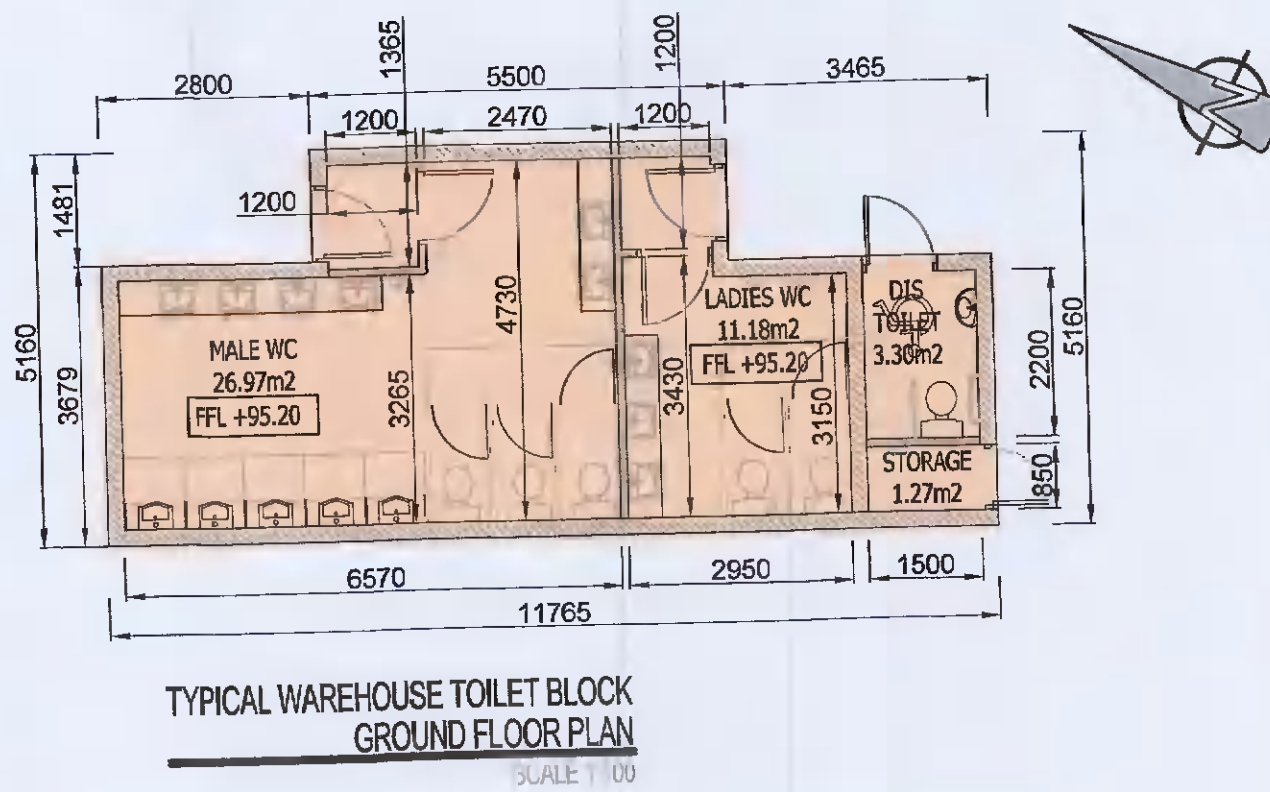


A2

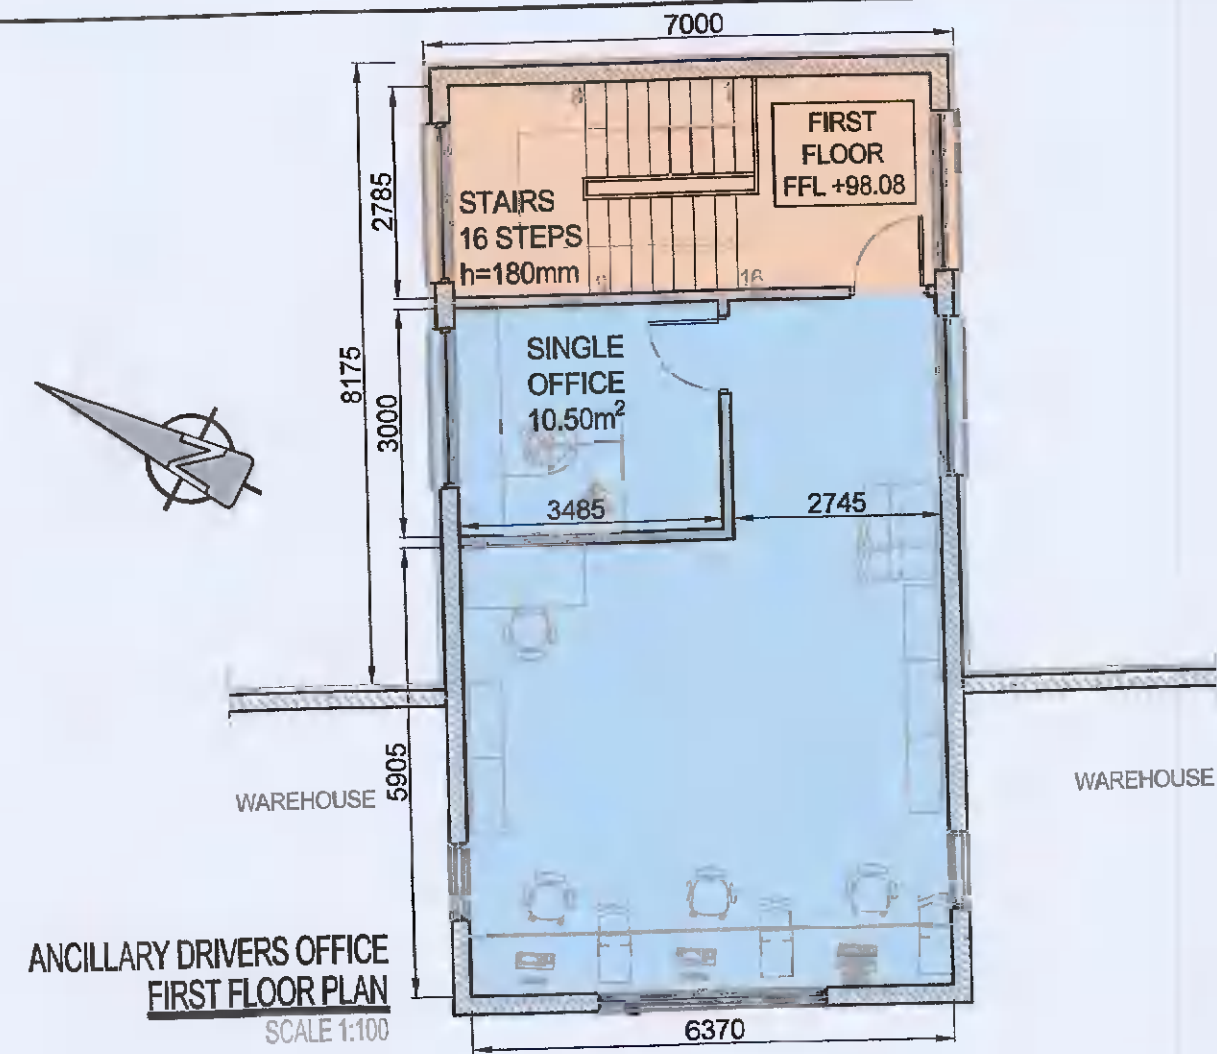

PL1	18/05/2021	TK	PK	PK	ISSUED FOR PLANNING
Mark	Date	By	Chk.	App.	Revision
Drawing Status					
PLANNING					
Job Title					
WAREHOUSE DEVELOPMENT AT SITE R, JORDANSTOWN ROAD, AERODROME BUSINESS PARK RATHCOOLE, CO. DUBLIN					
Drawing Title					
ANCILLARY DRIVERS OFFICE & WAREHOUSE TOILET BLOCK FLOOR PLANS & SECTION A-A					
Architect/Client					
EXETER IRELAND PROPERTY IV C LIMITED					
KAVANAGH BURKE CONSULTING ENGINEERS					
Tel. 01 - 450 0694		Unit G3, Calmount Pk.			
Fax. 01 - 426 4340		Ballymount, Dublin 12.			
Email: pkavanagh@kavanaghburke.ie					
Dim	TK	Checked	PK	Approved	PK
Scales as shown				Date 18/05/2021	
Job No. D1693		Drawing No. GA-A05		Rev. PL1	