


HOUSE TYPE D3



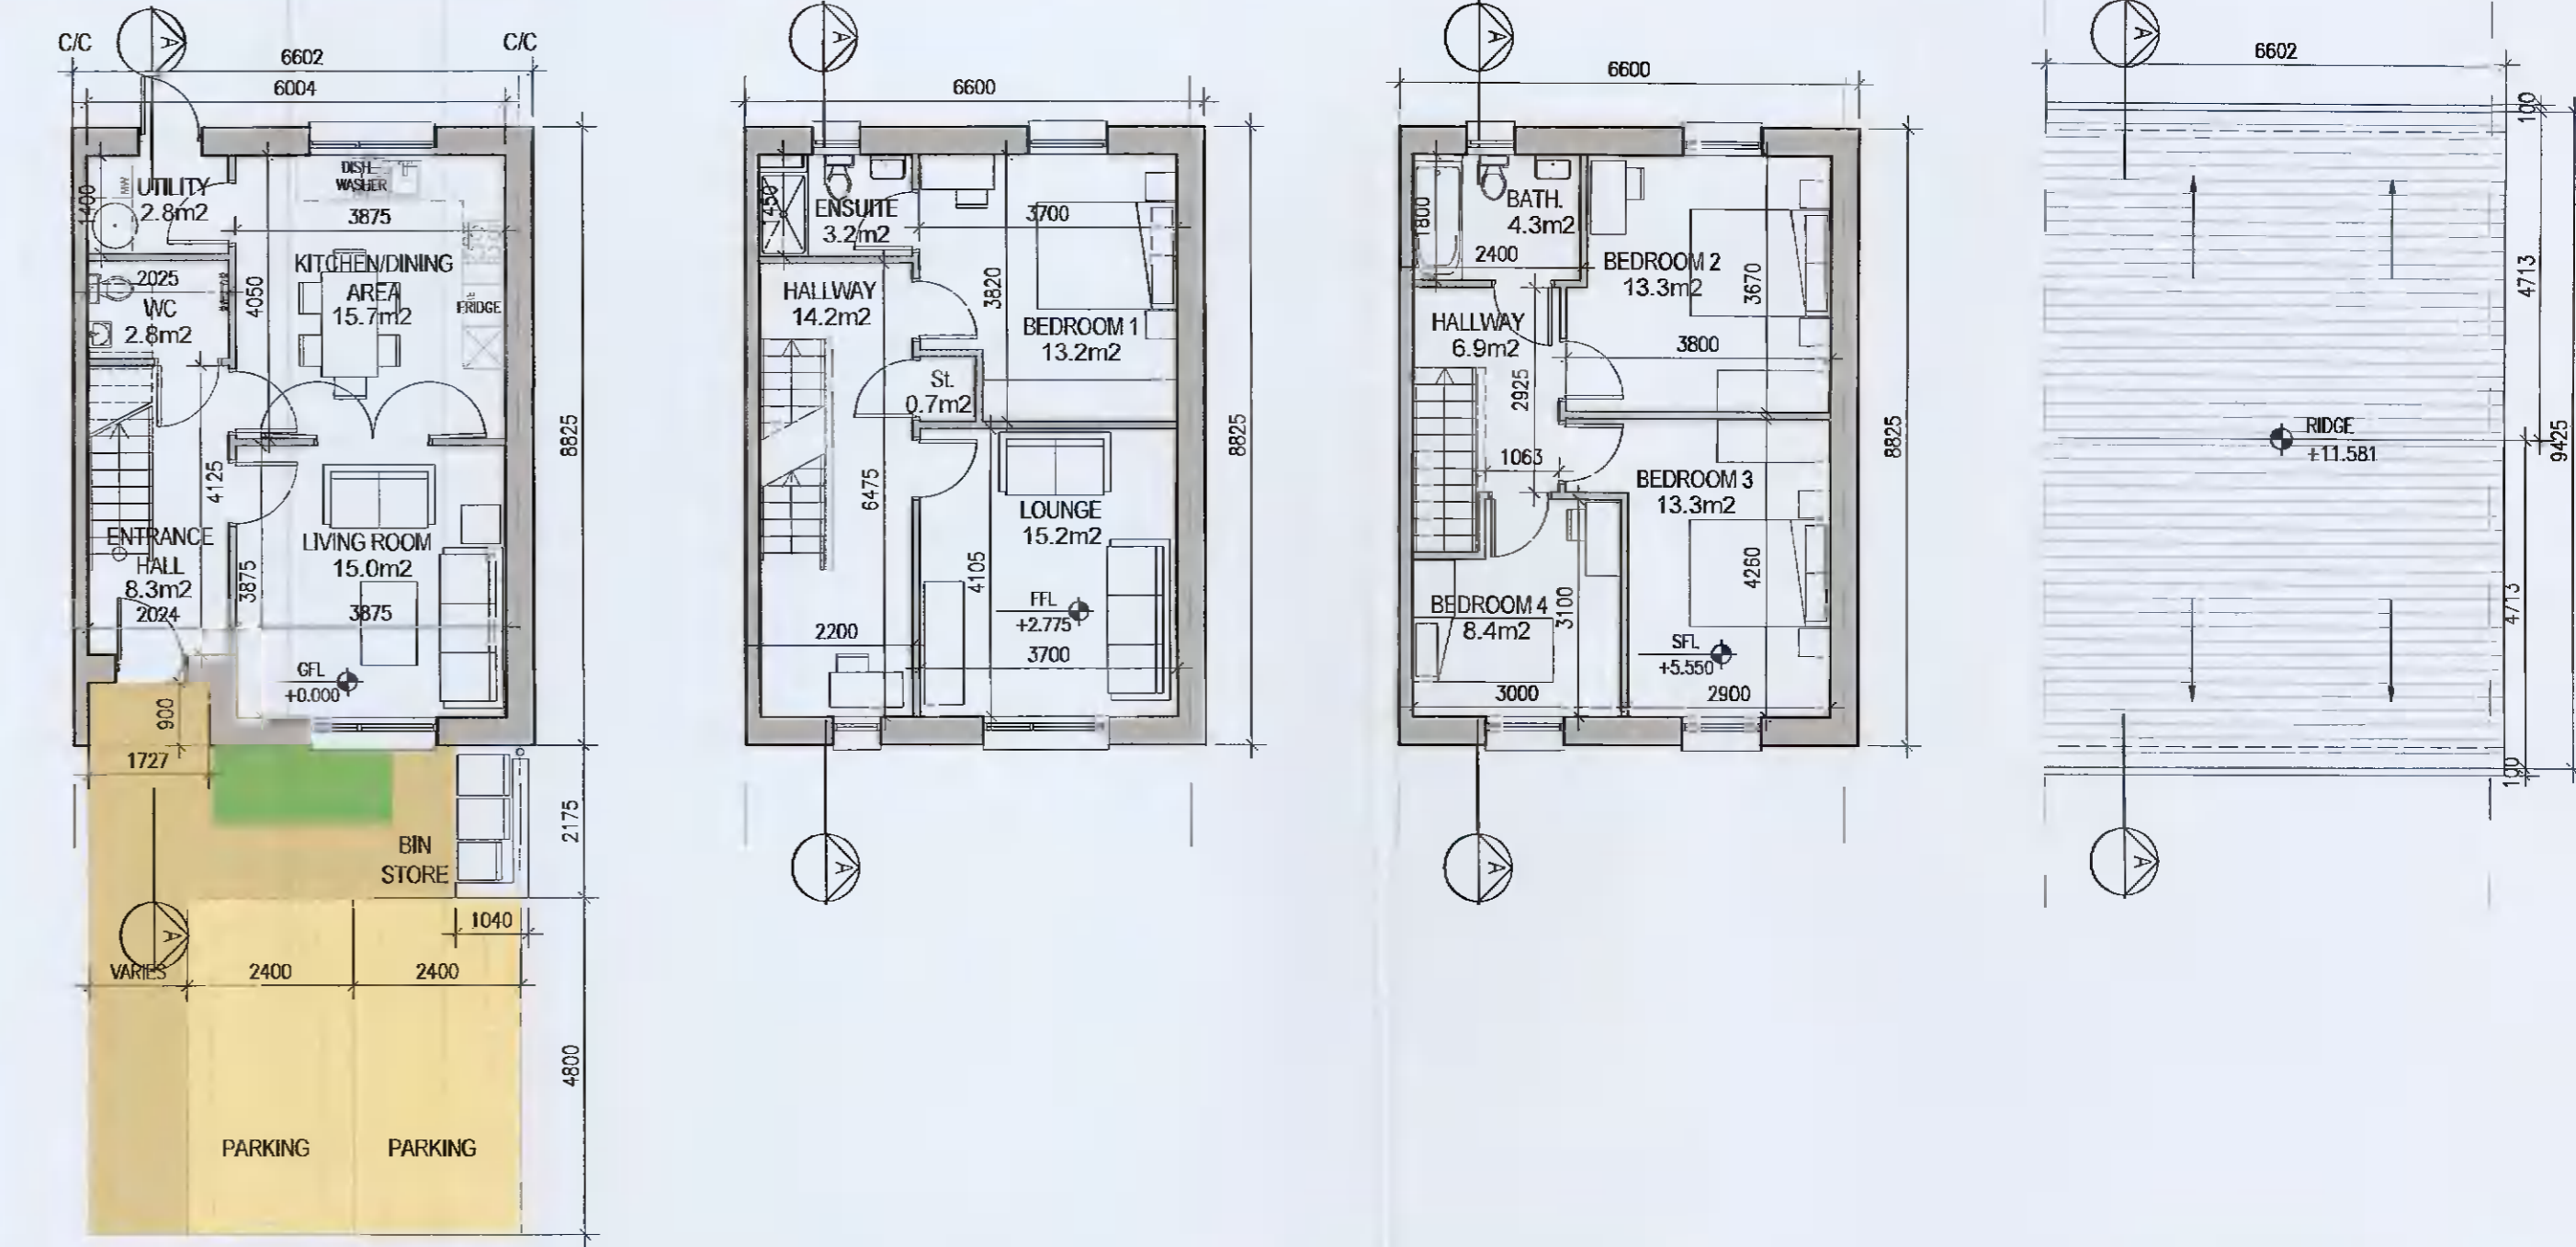


01 Ground Floor Plan 1:100@A1 | 02 First Floor Plan 1:100@A1 | 03 Second Floor Plan 1:100@A1 | 04 Roof Floor Plan 1:100@A1

HOUSE TYPE D3 [HANDED]



05 Ground Floor Plan 1:100@A1 | 06 First Floor Plan 1:100@A1 | 07 Second Floor Plan 1:100@A1 | 08 Roof Floor Plan 1:100@A1

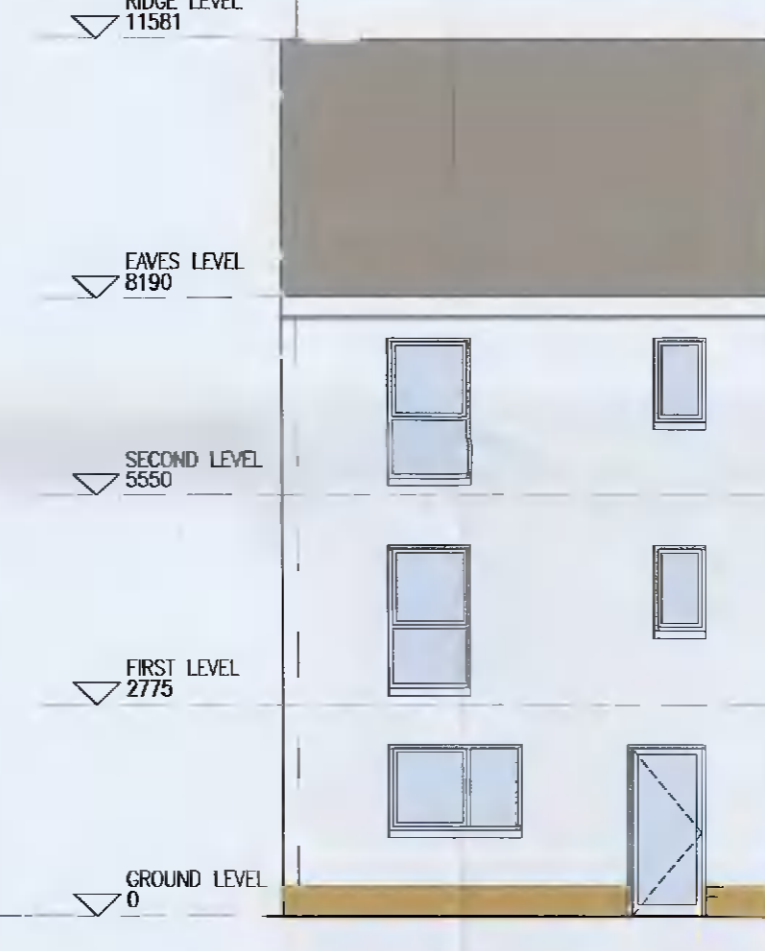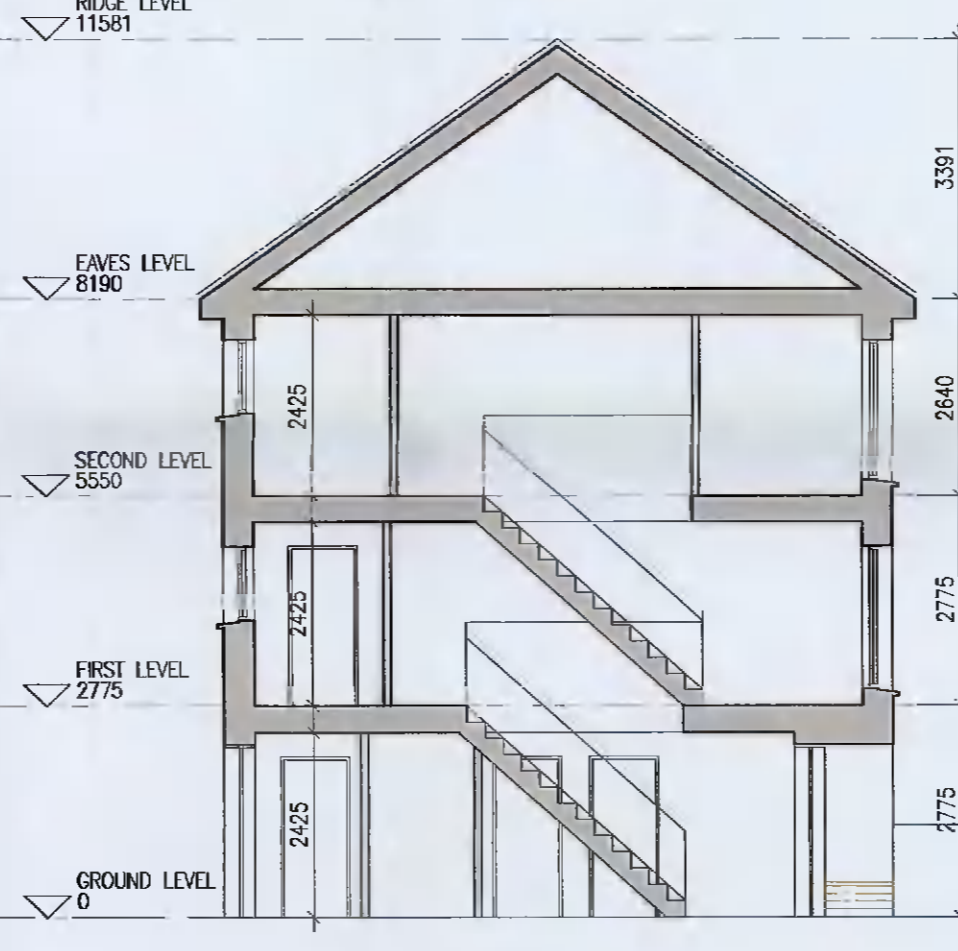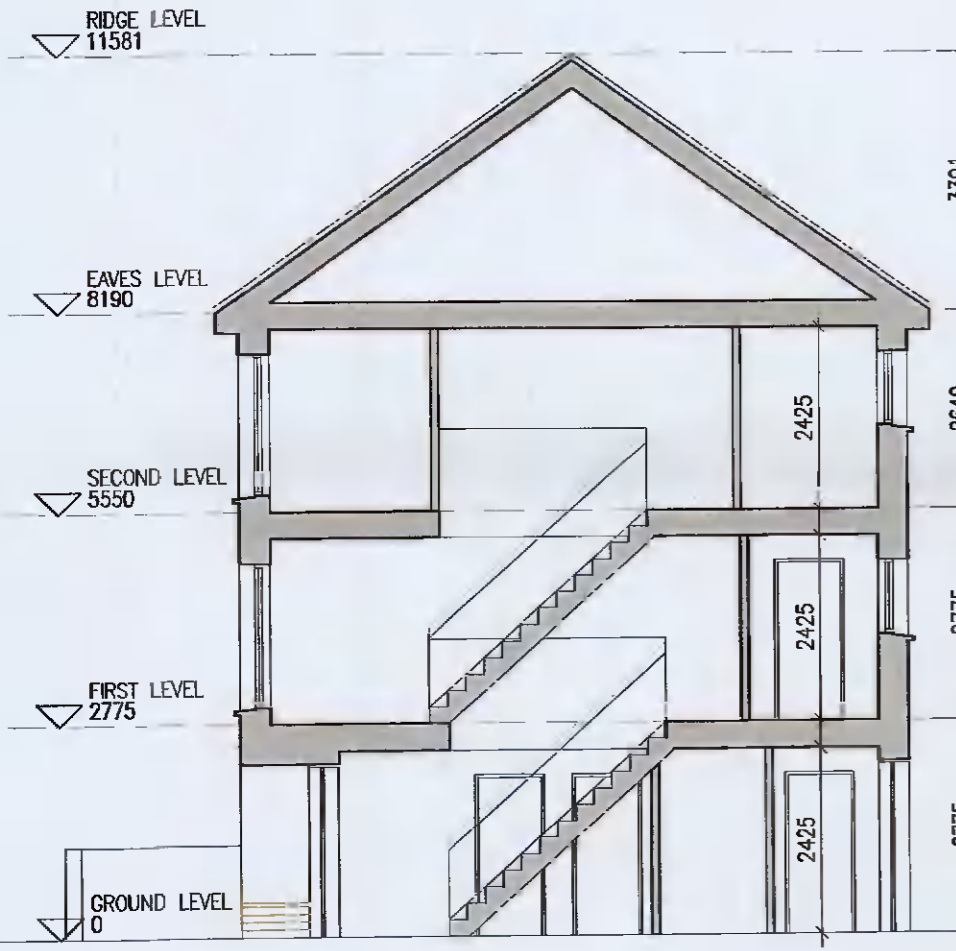

09 Section A-A 1:100@A1

10 Front Elevation 1:100@A1

11 Rear Elevation 1:100@A1

12 Section A-A 1:100@A1

13 Front Elevation 1:100@A1


14 Rear Elevation 1:100@A1



KEY PLAN [NTS]



15 Gable Elevation 1:100@A1

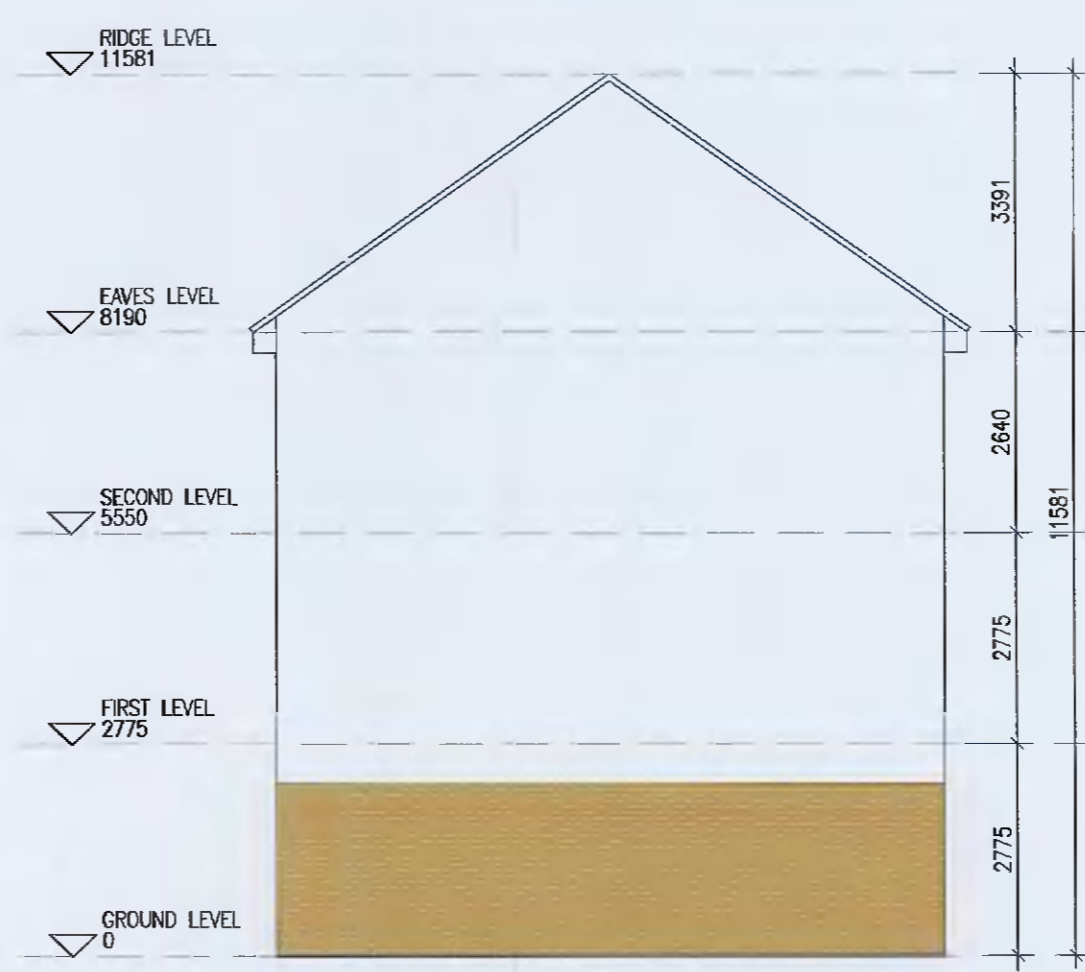

16 Gable Elevation 1:100@A1

HOUSE TYPE D3

Ground floor area	46.1m ²
First floor area	48.1m ²
Second floor area	48.1m ²
Total Floor Area (4-bed unit):	142.3m²

EXTERNAL FINISHES

WALLS: PAINTED SAND / CEMENT RENDER OR PROPRIETARY PRECOLOURED RENDER FINISH. SELECTED BRICKWORK WHERE INDICATED ON DRAWINGS.

WINDOWS: SELECTED PROPRIETARY DOUBLE / TRIPLE GLAZED WINDOW SYSTEM WITH FRAMES TO APPROVED COLOUR. OBTAINED GLAZING TO BATHROOMS AND EN-SUITES.

DOORS: SELECTED PROPRIETARY DOORS AND GLAZED SIDE SCREENS TO APPROVED COLOUR.

RAINWATER GOODS: uPVC OR POWDER COATED METAL GUTTERS AND RAINWATER PIPES TO SELECTED COLOUR.

MAIN ROOF: CONCRETE ROOF TILES IN SELECTED COLOUR.

LOW LEVEL PROJECTION: ZINC CANOPY TO ENTRANCE OF UNITS.

OTHER ITEMS: uPVC OR POWDER COATED METAL FASCIA, SOFFITS AND BARGE BOARDS PAINTED. MILDSTEEL RAILINGS AND BALUSTRADES.

UNIT TYPE KEY

Unit Type	Unit Level (Duplex only)
F1	X
1	1

Finishes/Roof (if variations occur)

FINISHES

Z- Plain white render
 Y- Brick
 X- Plain white render with grey brick areas
 V/W- Plain white render with brick areas

DUPLEX - Relates to front & rear elevations
HOUSES - Relates to front elevation (*)

ROOF FORM

A1Y- Asymmetrical roof
 D1V- Gable roof with hip roof intersection
 D1W- Gable roof

Note: refer to site layout (6259-P-003) for location of unit types and unit type drawings (6259-P-100/ 200 series) for details

*A2, an exception, relates to the rear elevation

Notes

- Copyright Reserved
- Work to figure dimensions only. Do not scale drawing.
- The contractor is responsible for checking all levels and dimensions on site and shall refer all discrepancies to the Architect.
- Where appropriate, for details of c.c. structure, or mechanical and electrical details, see Engineers drawings.
- Proprietary items shall be fixed in strict accordance with manufacturers instructions.
- Sizes of proprietary items shall be checked with manufacturer.
- The contractor shall be responsible for the coordination of structure, finishes and services.

Issue Status

Progress	
Planning Application	
Fire Cert	
Disability Cert	
Tender	
Construction	
As Built	

No.	Date	Revision	Initials
01	12.04.2021	Preliminary issue for comment	BKD
02	20.05.2021	ISSUED FOR PLANNING	BKD

Project

Aderrig Phase 2 Adamstown SDZ Residential Development

Drawing Title: House Type D3 [End Terrace] [Handed/Non-Handed] Plans, Elevations, Sect.

Drawing No: 6259-P-117

Scale: 1:100@A1 | Rev: 02 | Drawn: BKD | Date: 12.04.2021