



1 Block Plan 1
P301 1:200 @ A1

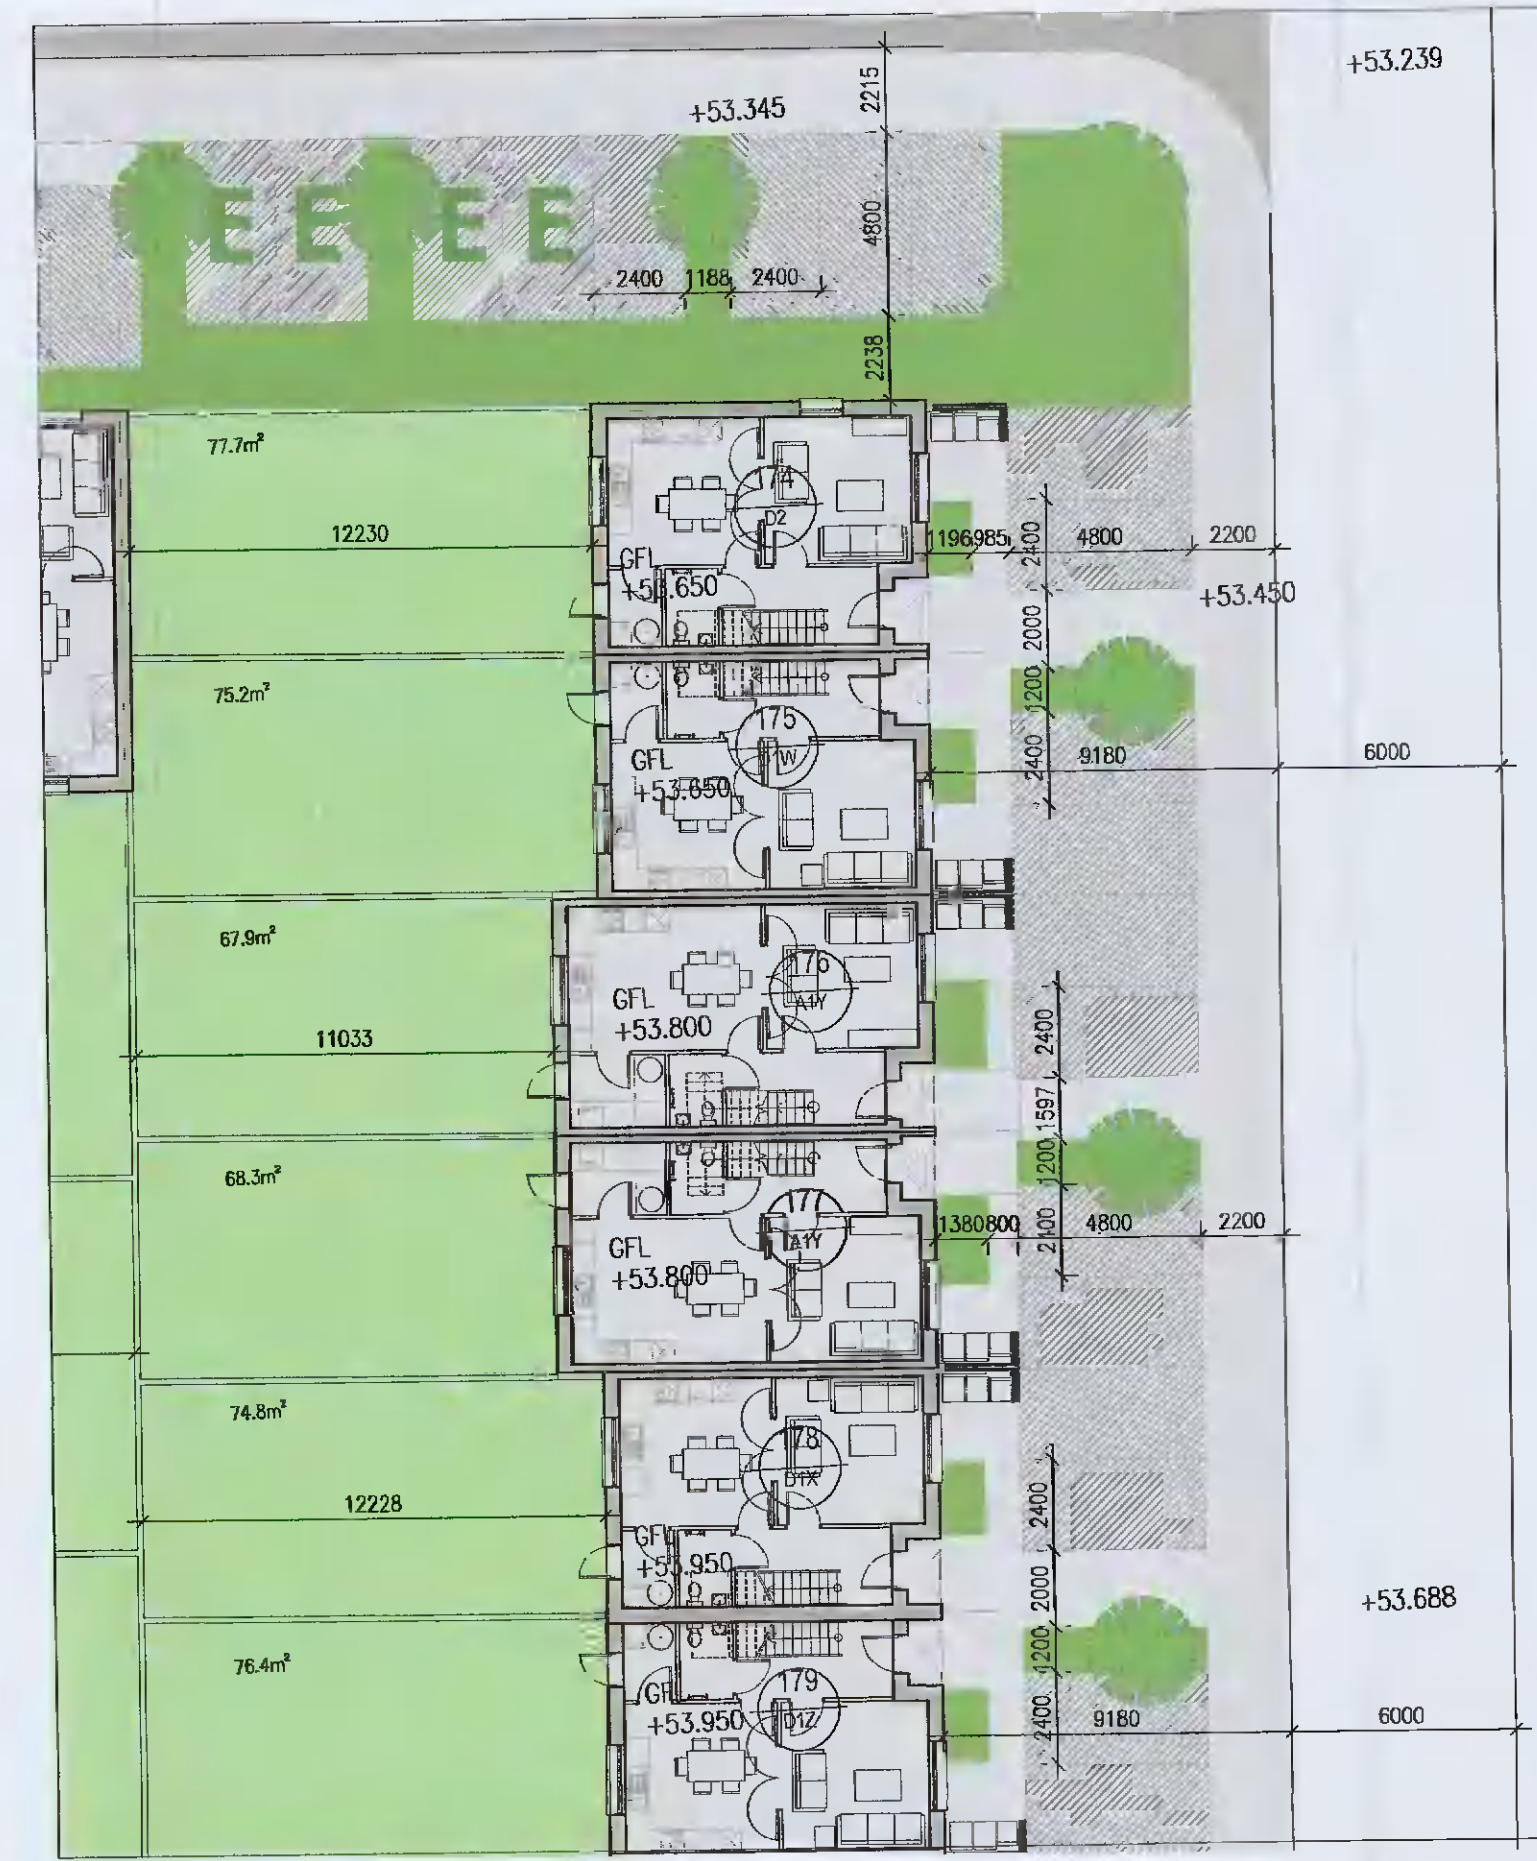

2 Block Plan 2
P301 1:200 @ A1

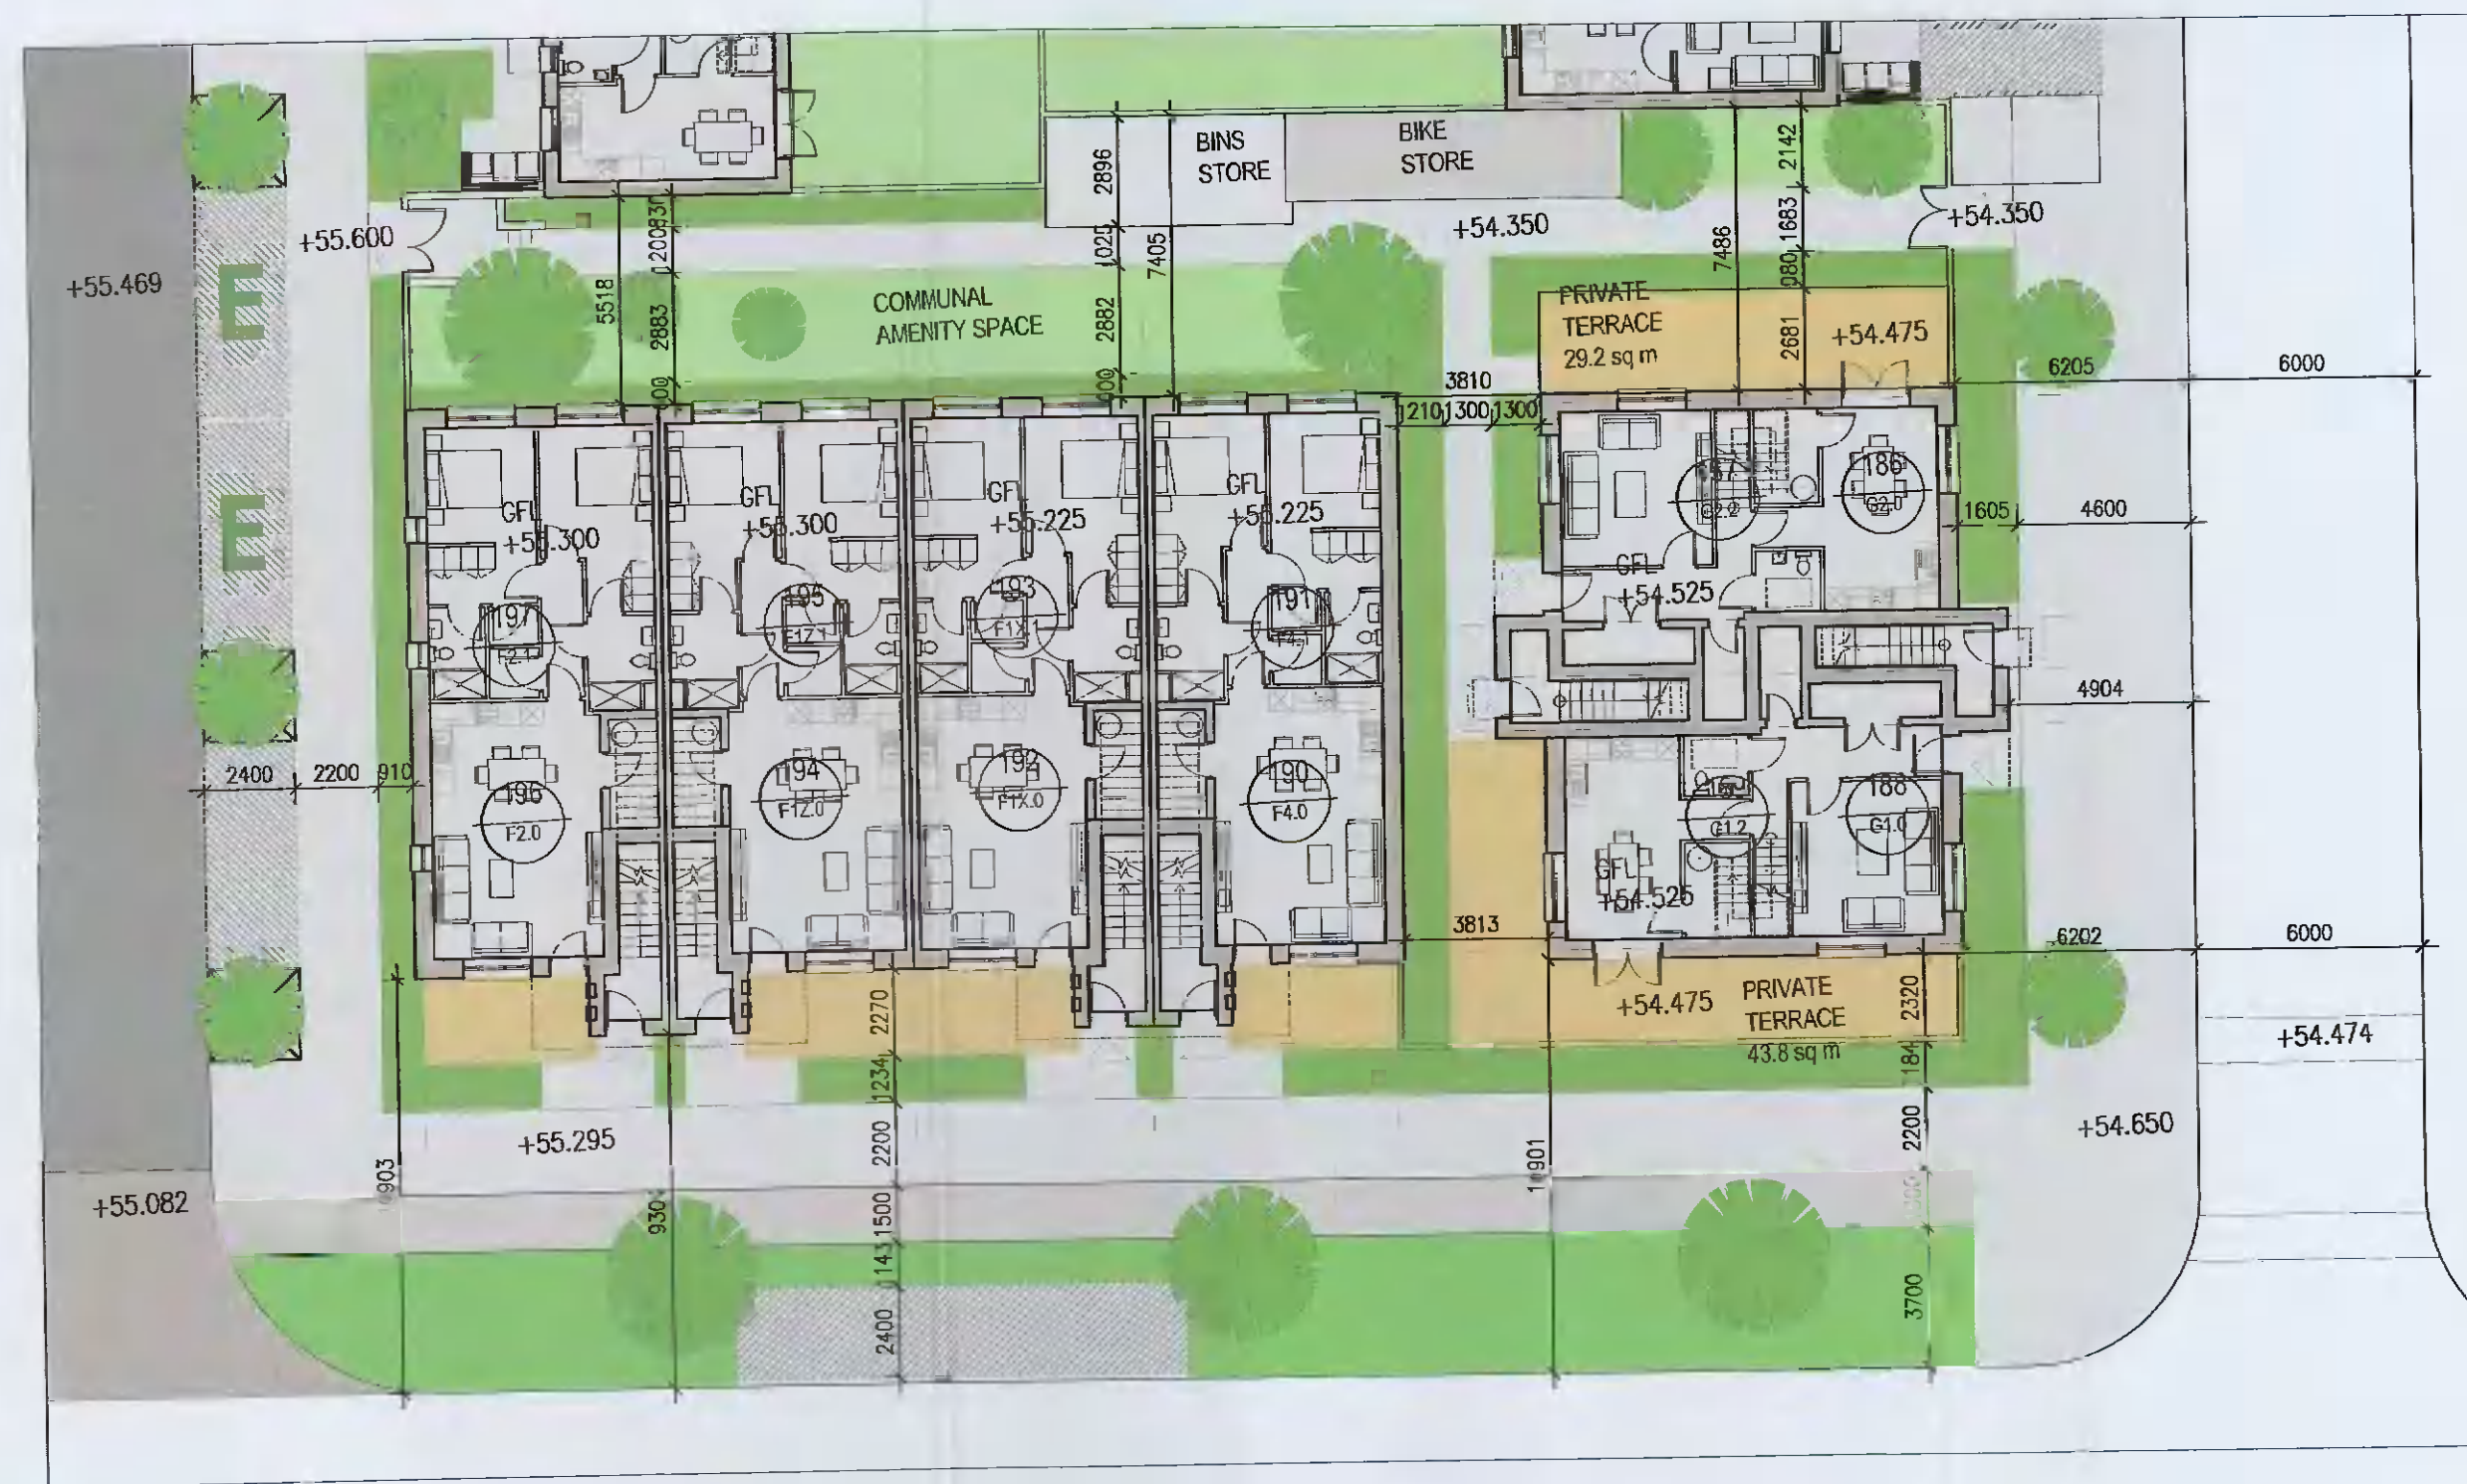

3 Block Plan 3
P301 1:200 @ A1



4 Block Plan 4
P301 1:200 @ A1



00 Keyplan
Not to scale

- Notes
1. Copyright Reserved
 2. Work to signed dimensions only. Do not scale drawing.
 3. The contractor is responsible for checking all levels and dimensions on site and shall refer all discrepancies to the Architect.
 4. Where appropriate, for details of c.c. structure, or mechanical and electrical details, see Engineers drawings.
 5. Proprietary items shall be fixed in strict accordance with manufacturers instructions.
 6. Sizes of proprietary items shall be checked with manufacturers.
 7. The contractor shall be responsible for the coordination of structure, finishes and services.

| Issue Status | Progress |
|----------------------|----------|
| Planning Application | ■ |
| Fire Cert | |
| Disability Cert | |
| Tender | |
| Construction | |
| As Built | |
| Information Only | |

| No. | Date | Revision | Initials |
|-----|------------|---------------------|----------|
| 01 | 20.05.2021 | ISSUED FOR PLANNING | EKD |

| | |
|---------------|--|
| Project | Aderrig Phase 2, Adamstown SDZ Residential Development |
| Drawing Title | Block Plans - Sheet 1 of 2 |
| Drawing No | 6250-P-301 |
| Scale | 1:200@A1 |
| Rev | 01 |
| Drawn | EKD |
| Date | 05.2021 |

6-7 HANCOURT TERRACE, DUBLIN 2, IRELAND
 T +353-1-618 2400 F +353-1-676 7356
 e encl@bkdarchitects.com
 www.bkd.ie

bkd architects
 BURKE-KENNEDY-DOYLE