



1 Bicycle Store Type 1 Roof Plan  
Scale 1:50




2 Bicycle Store Type 1 Plan  
Scale 1:50

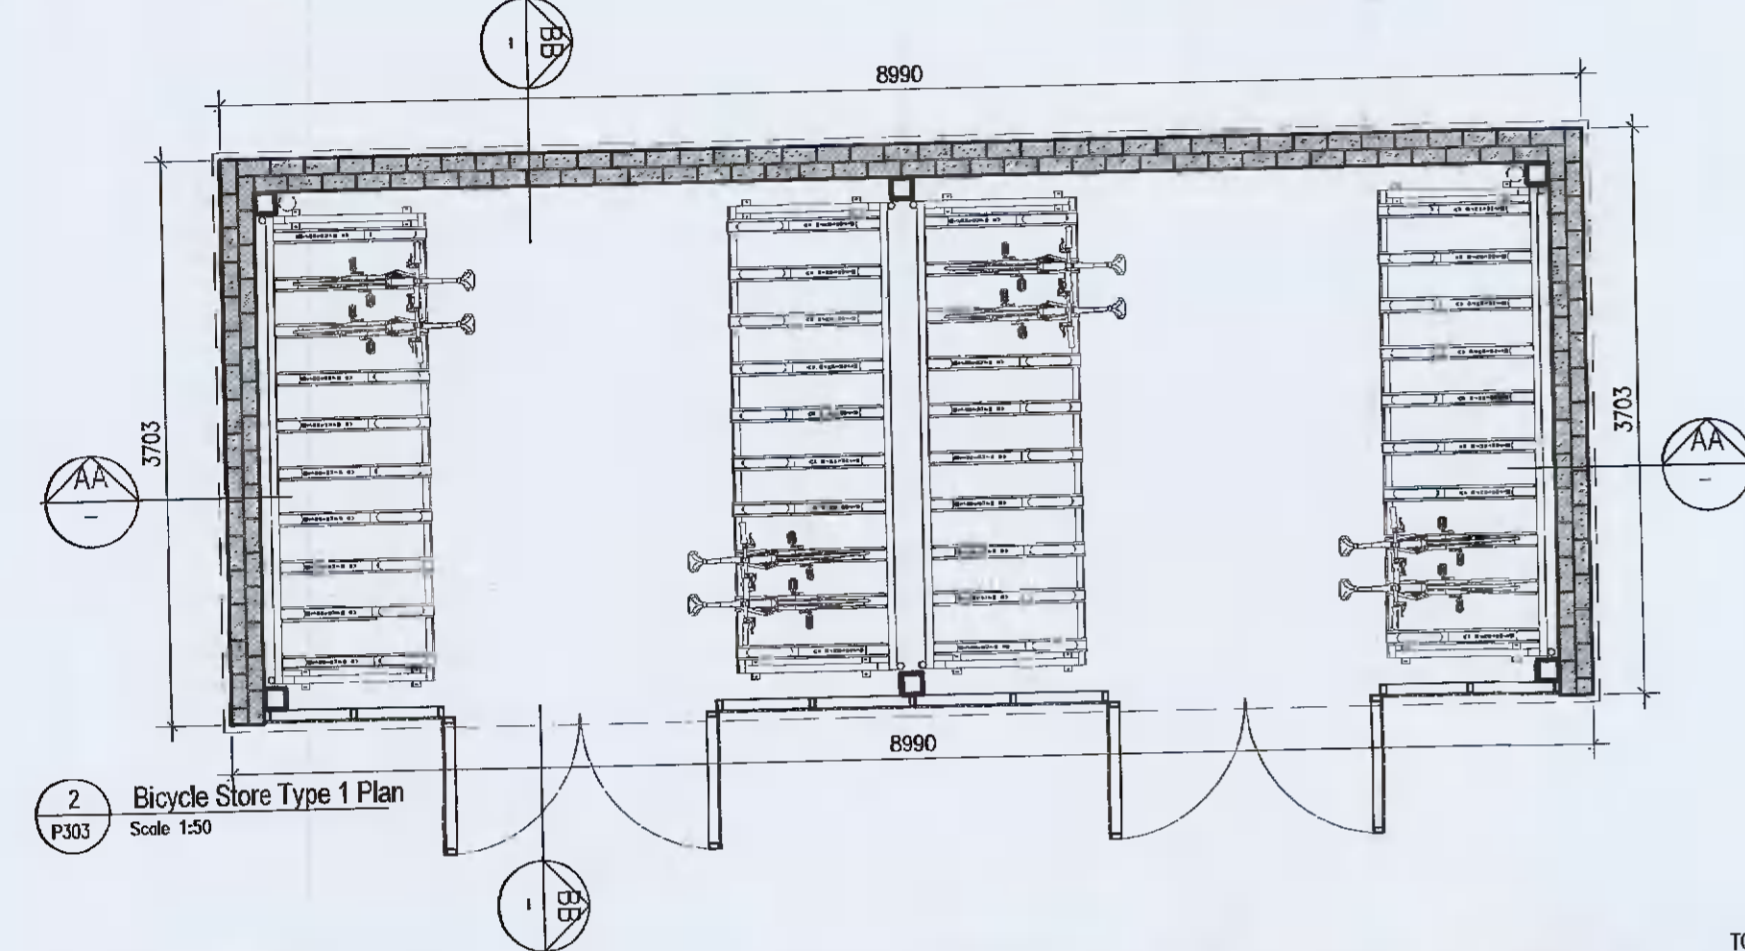


3 Bicycle Store Type 1 Front Elevation  
Scale 1:50

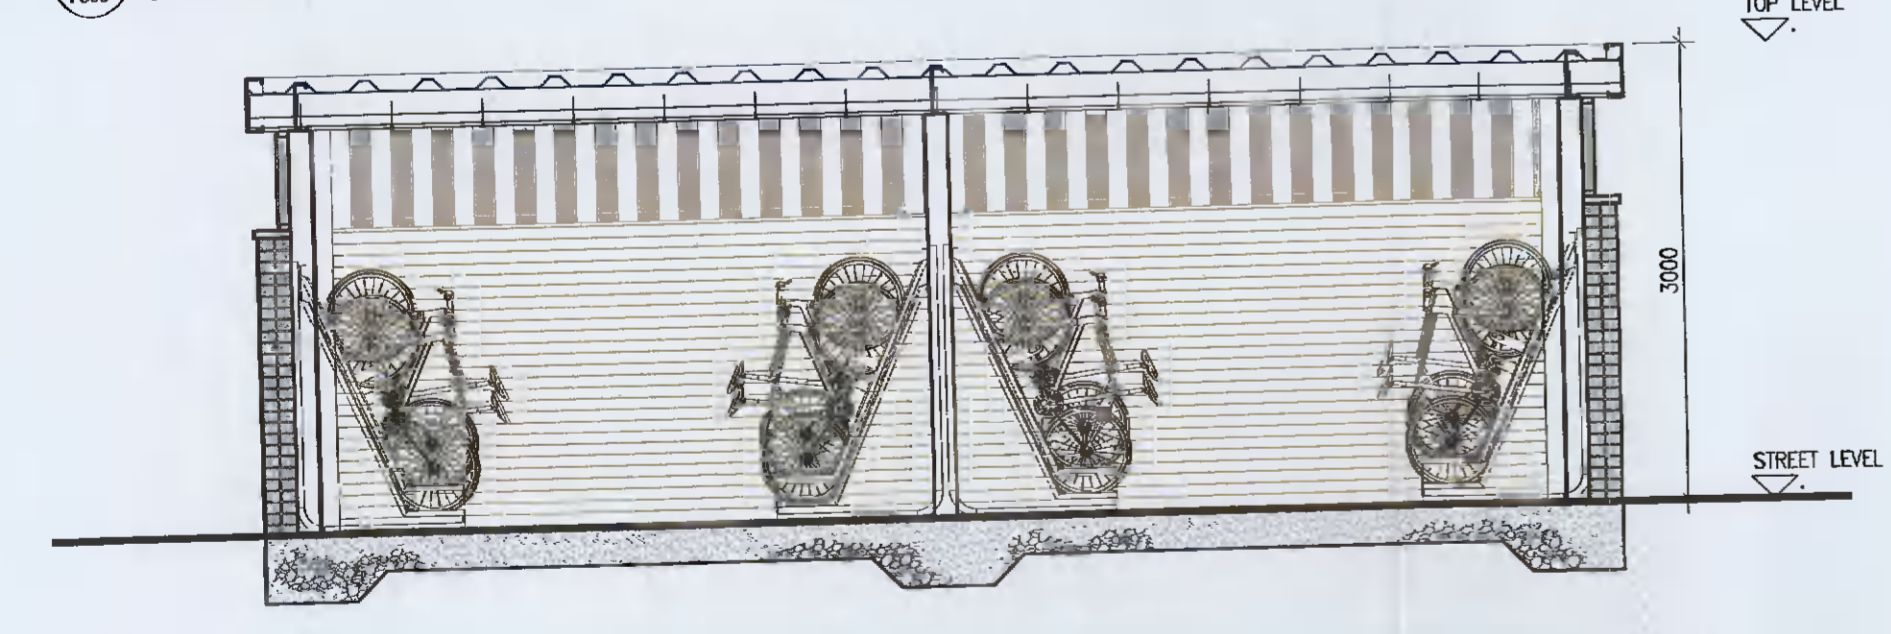

4 Bicycle Store Type 1 Section A  
Scale 1:50


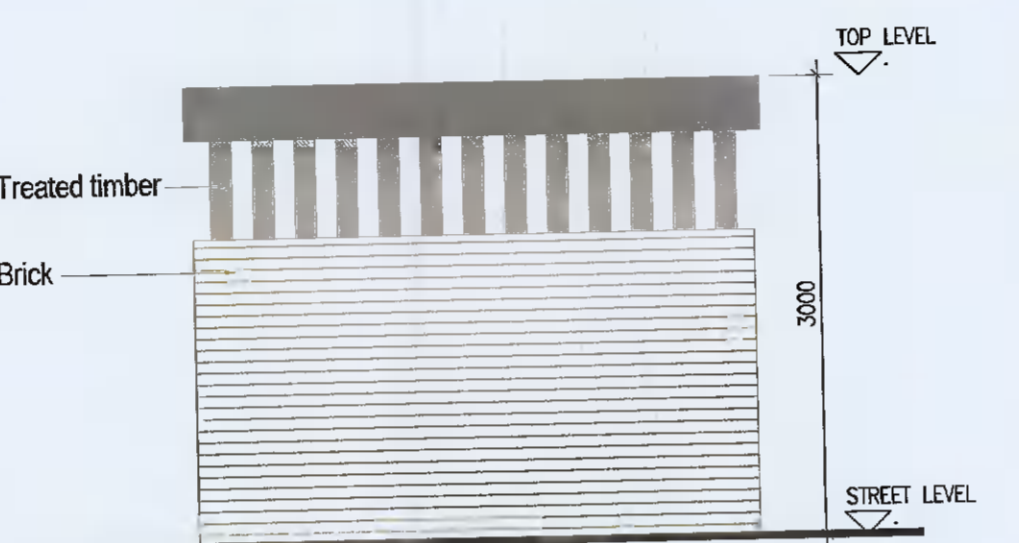


5 Bicycle Store Type 1 Front Elevation  
Scale 1:50

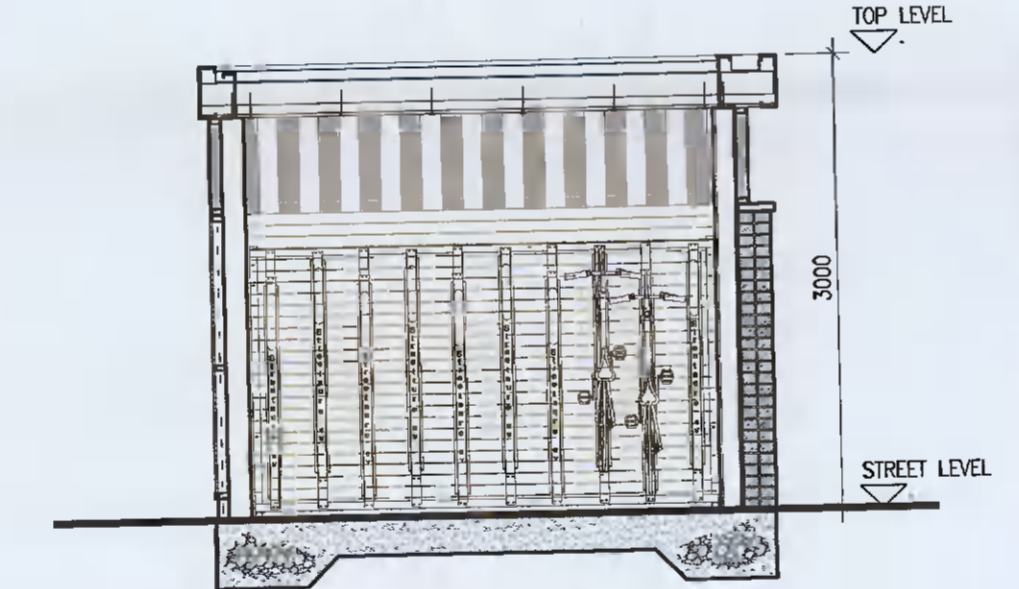


6 Bicycle Store Type 1 Front Elevation  
Scale 1:50


**TYPE 1 - Bicycle Store**

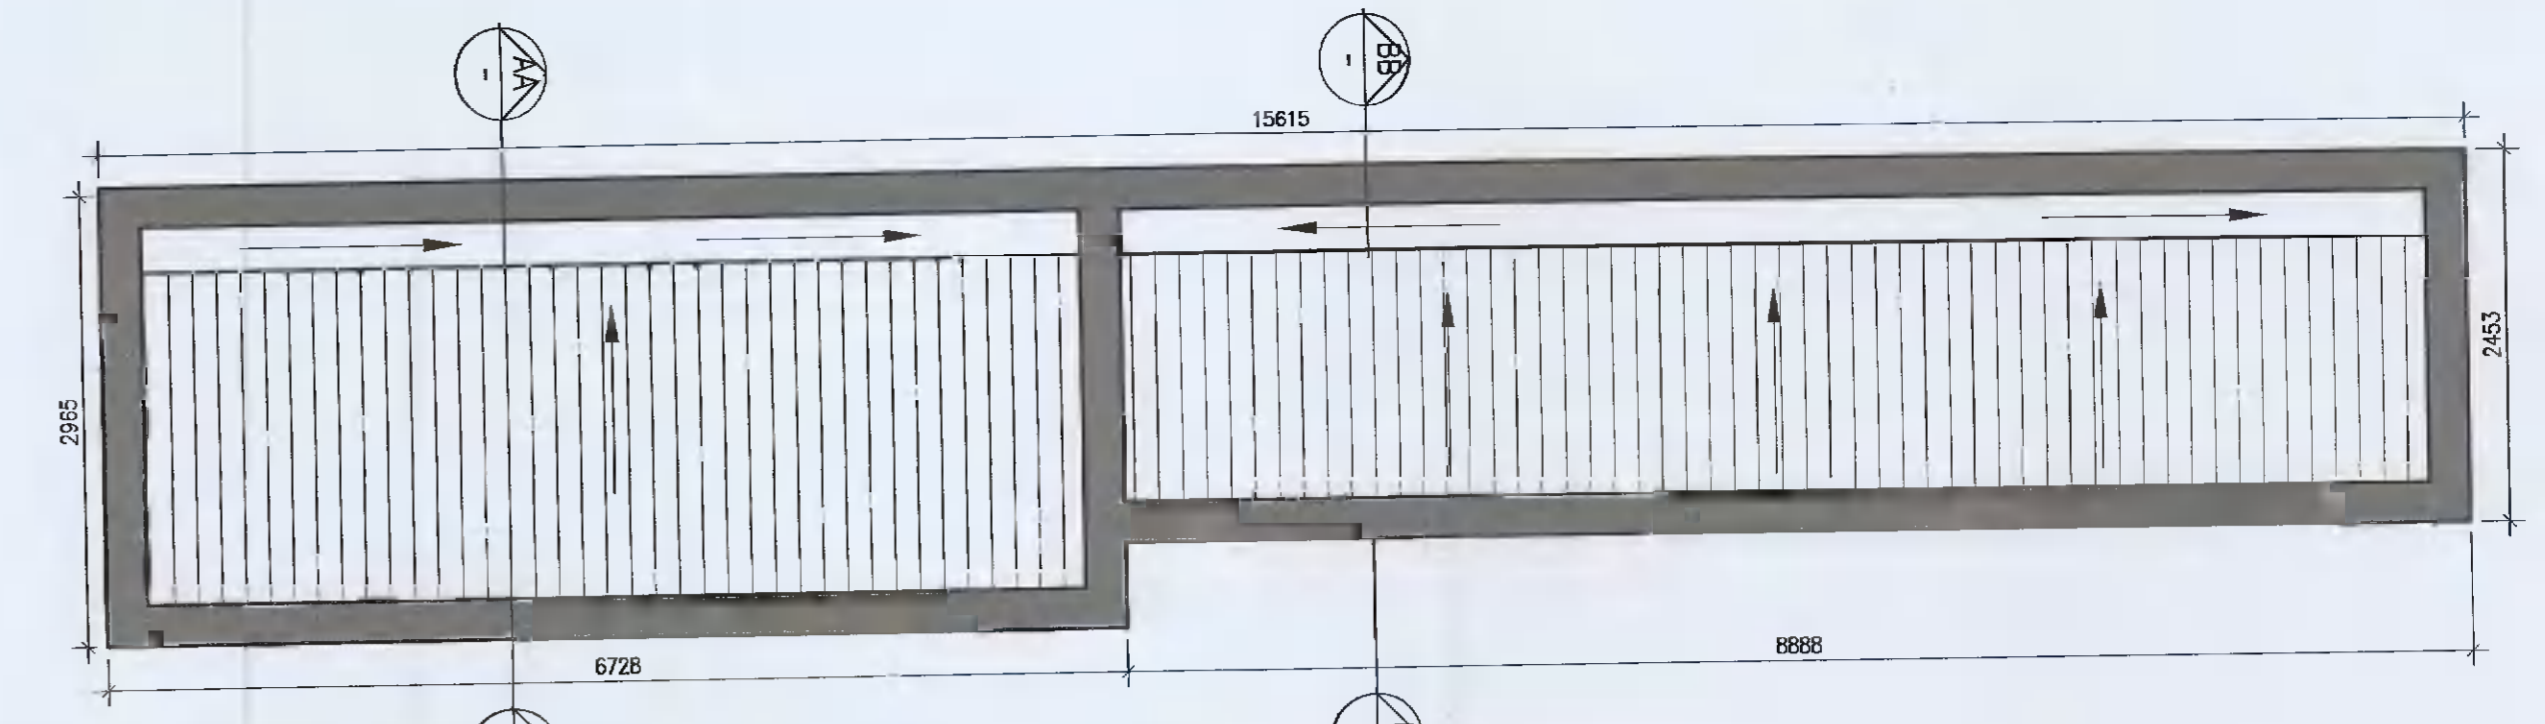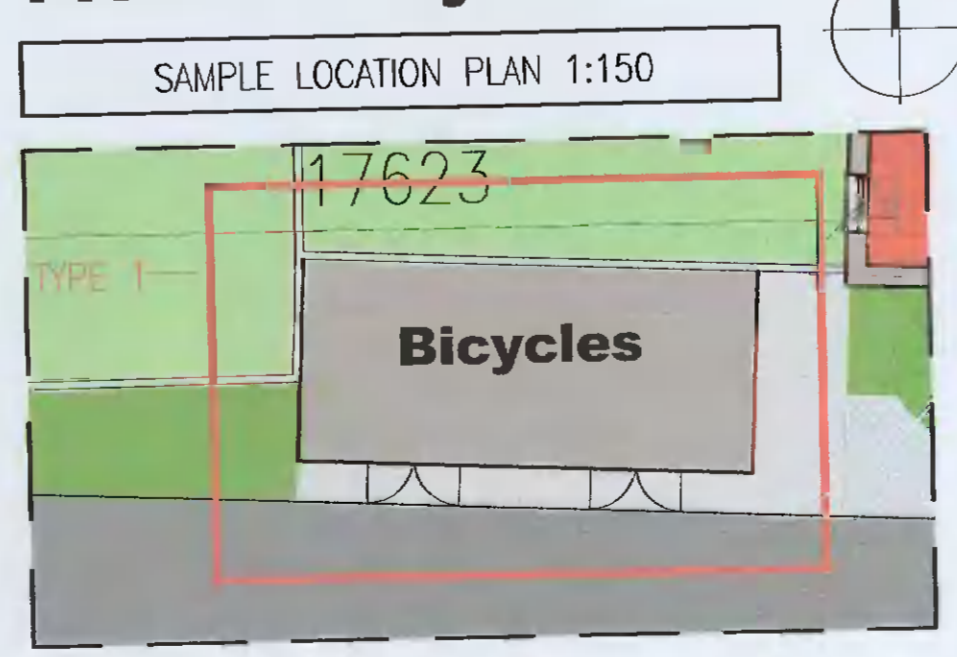


7 Bicycle Store Type 2 Roof Plan  
Scale 1:50

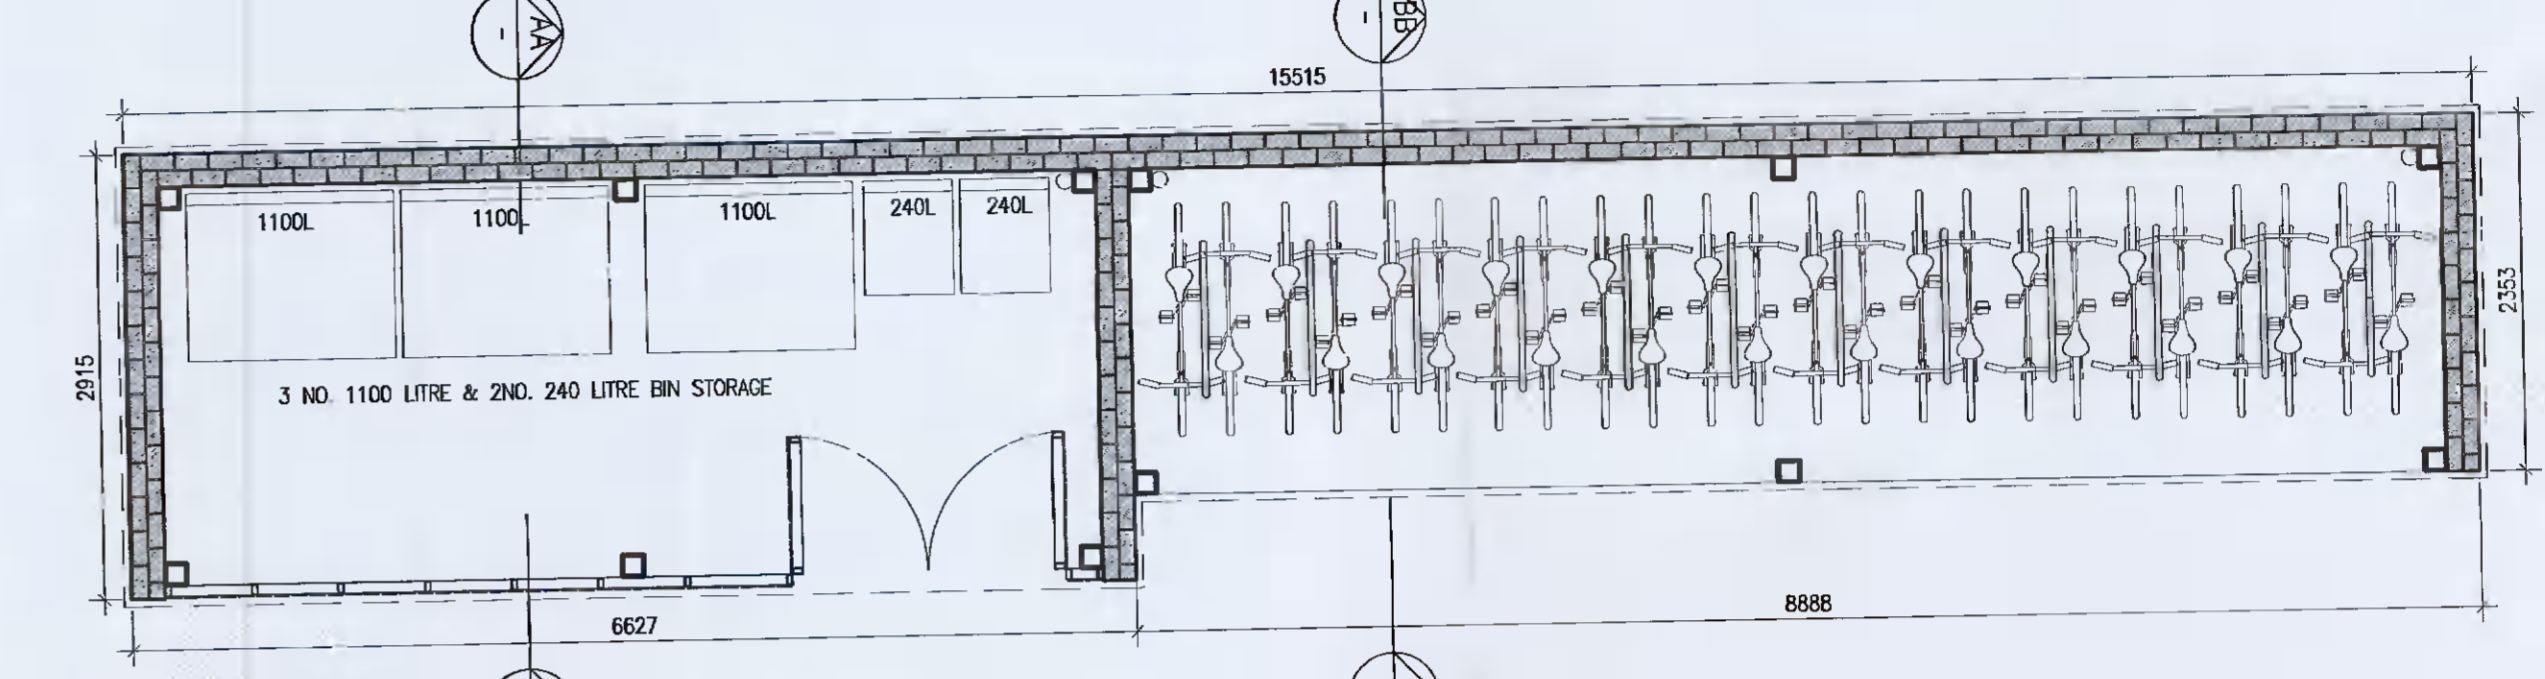

8 Bicycle Store Type 2 Plan  
Scale 1:50

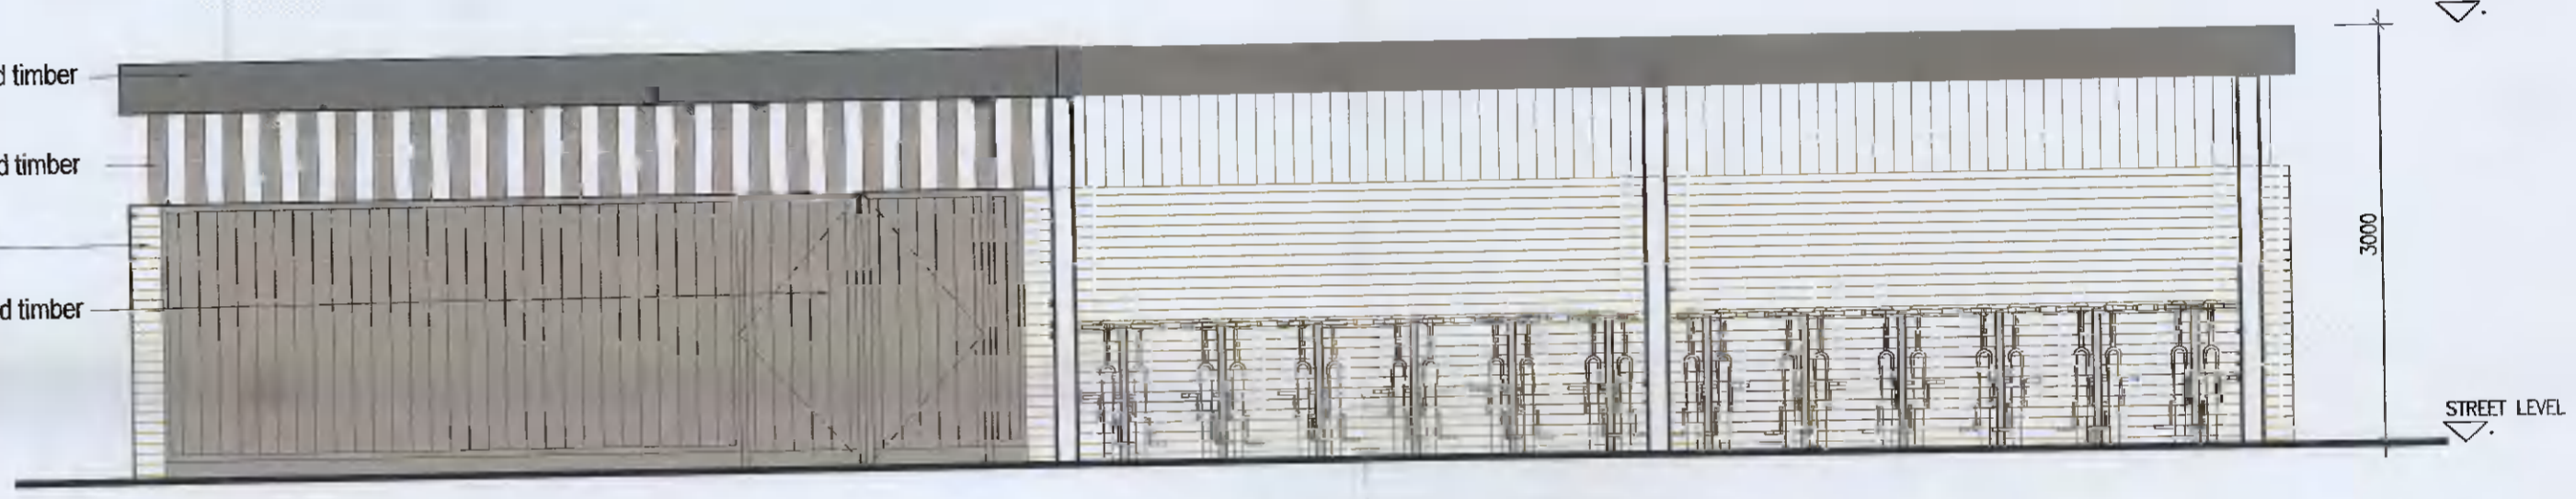


9 Bicycle Store Type 2 Front Elevation  
Scale 1:50

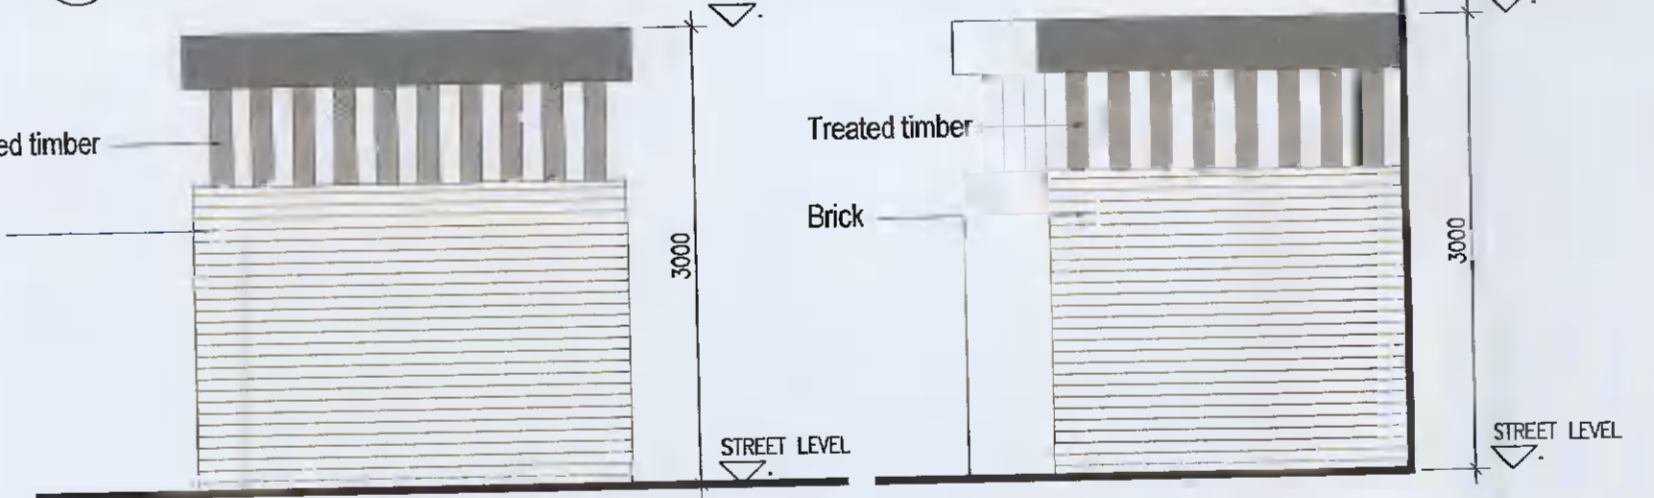


10 Bicycle Store Type 2 Side Elevation 1  
Scale 1:50



11 Bicycle Store Type 2 Side Elevation 2  
Scale 1:50

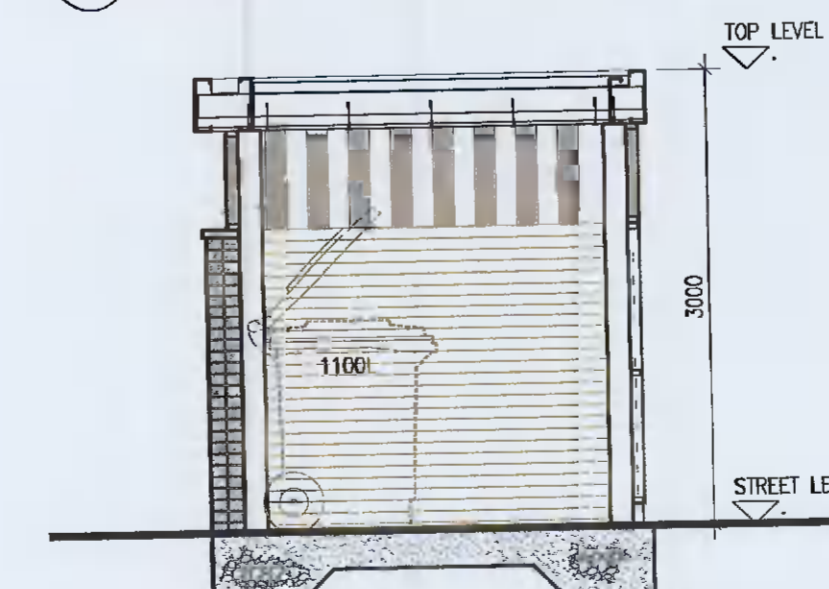


12 Bicycle Store Type 2 Section A  
Scale 1:50

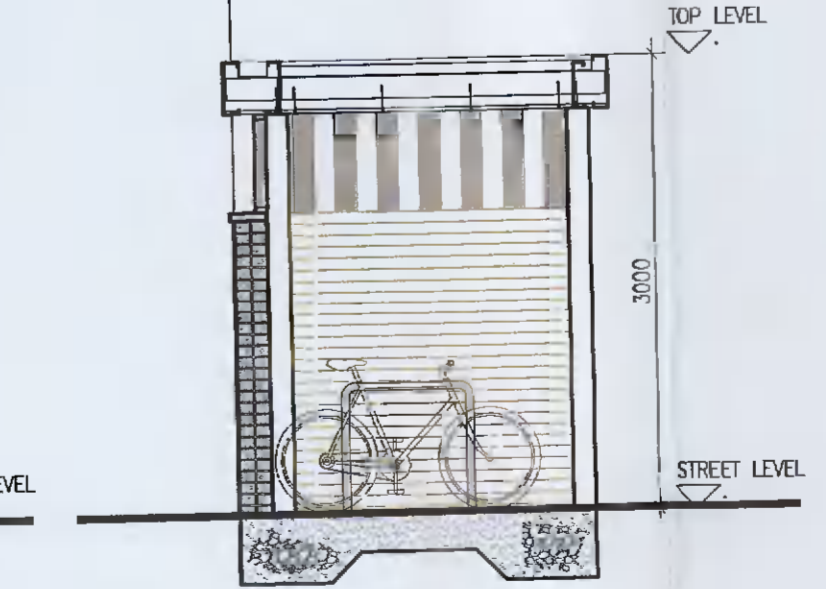

13 Bicycle Store Type 2 Section B  
Scale 1:50

**TYPE 2 - Bicycle & Bin Store**

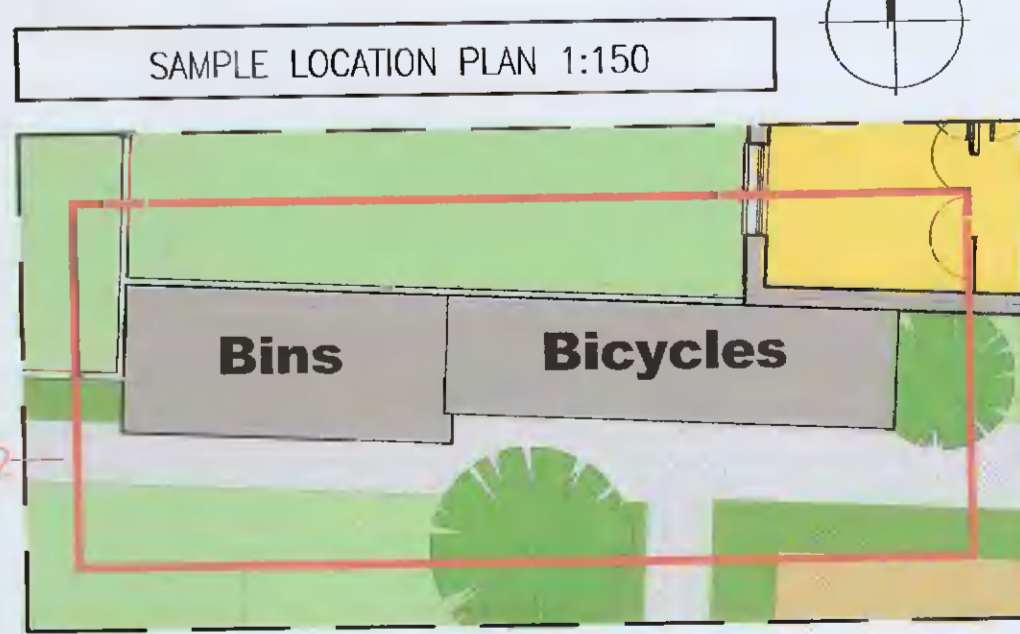

Notes  
1. Copyright Reserved  
2. Work to figured dimensions only. Do not scale drawings.  
3. The contractor is responsible for checking all levels and dimensions on site and shall refer all discrepancies to the Architect.  
4. Where appropriate, for details of e.c. structure, or mechanical and electrical details, see Engineers drawings.  
5. Proprietary items shall be fixed in strict accordance with manufacturers instructions.  
6. Sizes of proprietary items shall be checked with manufacturers.  
7. The contractor shall be responsible for the coordination of structure, finishes and services.  
8. All work shall be done in accordance with the relevant standards and specifications.  
9. The contractor shall be responsible for the coordination of structure, finishes and services.  
10. The contractor shall be responsible for the coordination of structure, finishes and services.  
11. The contractor shall be responsible for the coordination of structure, finishes and services.  
12. The contractor shall be responsible for the coordination of structure, finishes and services.  
13. The contractor shall be responsible for the coordination of structure, finishes and services.  
14. The contractor shall be responsible for the coordination of structure, finishes and services.  
15. The contractor shall be responsible for the coordination of structure, finishes and services.  
16. The contractor shall be responsible for the coordination of structure, finishes and services.  
17. The contractor shall be responsible for the coordination of structure, finishes and services.  
18. The contractor shall be responsible for the coordination of structure, finishes and services.  
19. The contractor shall be responsible for the coordination of structure, finishes and services.  
20. The contractor shall be responsible for the coordination of structure, finishes and services.

Issue Status	Progress	Planning Application	Fire Cert	Disability Cert	Tender	Construction	As Built

No.	Date	Revision	Initials
01	12.04.2021	Preliminary issue for comment	BKD
02	20.05.2021	ISSUED FOR PLANNING	BKD

Project	Aderrig Phase 2, Adamstown SDZ Residential Development
Drawing Title	Bicycle Store Type 1 & Bicycle and Bin Store Type 2
Drawing No	6259-P-303
Scale	1:50@A1
Rev	02
Drawn	BKD
Date	12.04.2021

6-7 HARICOURT TERRACE, DUBLIN 2, IRELAND  
1+353-1-616 2400 | 4-353-1-670 7886  
#architects@bkd.ie  
www.bkd.ie

**bkd architects**  
BURKE-KENNEDY DOYLE