


REFERENCE NOTE

REFER TO DWG. NO. H657-OCSC-XX-XX-DR-C-0500 FOR PROPOSED DRAINAGE LAYOUT

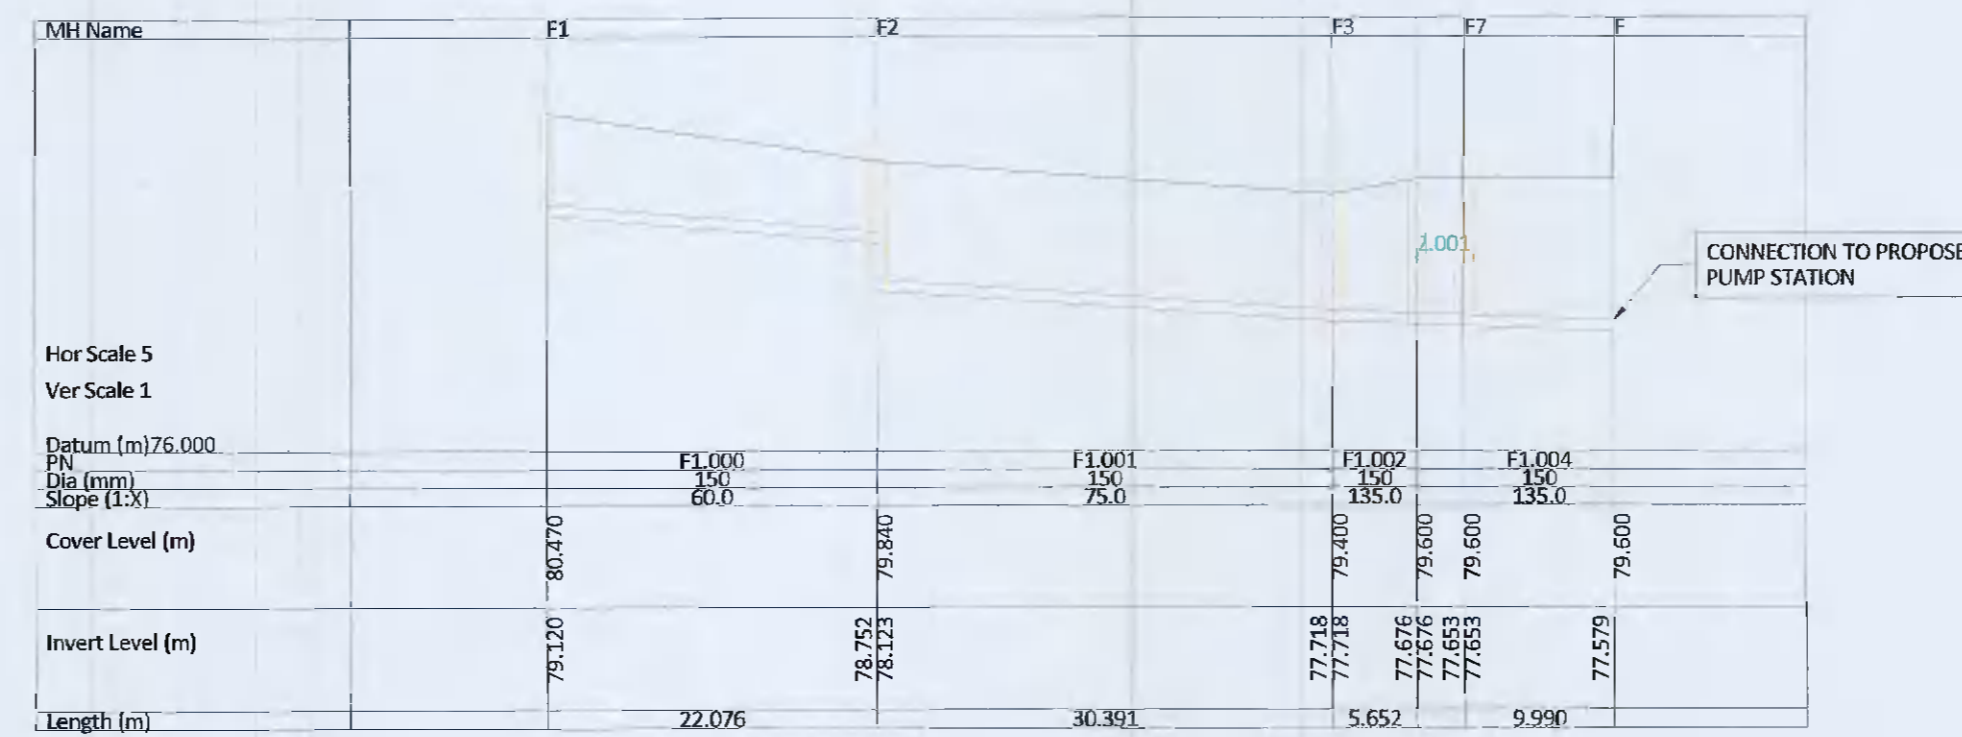

WASTEWATER NETWORK F1.000 - F1.004



WASTEWATER NETWORK F2.000 - F2.001


PLANNING DRAWING.

NOT FOR CONSTRUCTION.
ALL LEVELS GIVEN ARE
RELATIVE TO ORDNANCE DATUM.
THIS DRAWING HAS BEEN ISSUED FOR INFORMATION
PURPOSES ONLY AND MUST NOT BE USED
FOR CONSTRUCTION UNDER ANY CIRCUMSTANCES

ORDNANCE SURVEY OF IRELAND LICENCE NO. EN0000821 © GOVERNMENT OF IRELAND

- FOR SETTING OUT REFER TO ARCHITECT'S DRAWINGS.
- THIS DRAWING TO BE READ IN CONJUNCTION WITH ALL OTHER ARCHITECTURAL AND ENGINEERING DRAWINGS AND ALL OTHER RELEVANT DRAWINGS AND SPECIFICATIONS.
- DO NOT SCALE THIS DRAWING. USE FIGURED DIMENSIONS ONLY.
- NO PART OF THIS DOCUMENT MAY BE REPRODUCED OR TRANSMITTED IN ANY FORM OR STORED IN ANY RETRIEVAL SYSTEM OF ANY NATURE WITHOUT THE WRITTEN PERMISSION OF O'CONNOR SUTTON CRONIN AS COPYRIGHT HOLDER EXCEPT AS AGREED FOR USE ON THE PROJECT FOR WHICH THE DOCUMENT WAS ORIGINALLY ISSUED.

Rev No.	Date	Revision Note	Drm by	Chkd by	Rev No.	Date	Revision Note	Drm by	Chkd by
P01	01.06.21	STAGE COMPLETE - SUITABLE FOR PLANNING	DOM	MK					

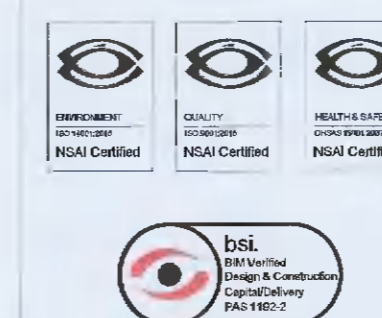

Head Office,
9 Prussia Street,
Dublin 7,
D07 KT57

TEL +353 (0)1 8682000
e: contactus@ocsc.ie
w: www.ocsc.ie



Dublin London Belfast Galway Cork

Client:	HIBERNIA REIC LTD							
Project:	KATHARINE TYNAN HOUSE							
Title:	PROPOSED DRAINAGE WASTEWATER LONGSECTION							
Code	Originator	Zone	Level	Type	Role	Number	Status	Revision
H657	OCSC	XX	XX	DR	C	0511	S8	P01
Date: JUNE '21 Scale: 1:100 @ A1 Drm by: DOM Chkd by: MK Aprvd by: PH								