



Existing Connection to Existing Spakaway
8602

 
Existing Connection to Existing Public Drain
8602

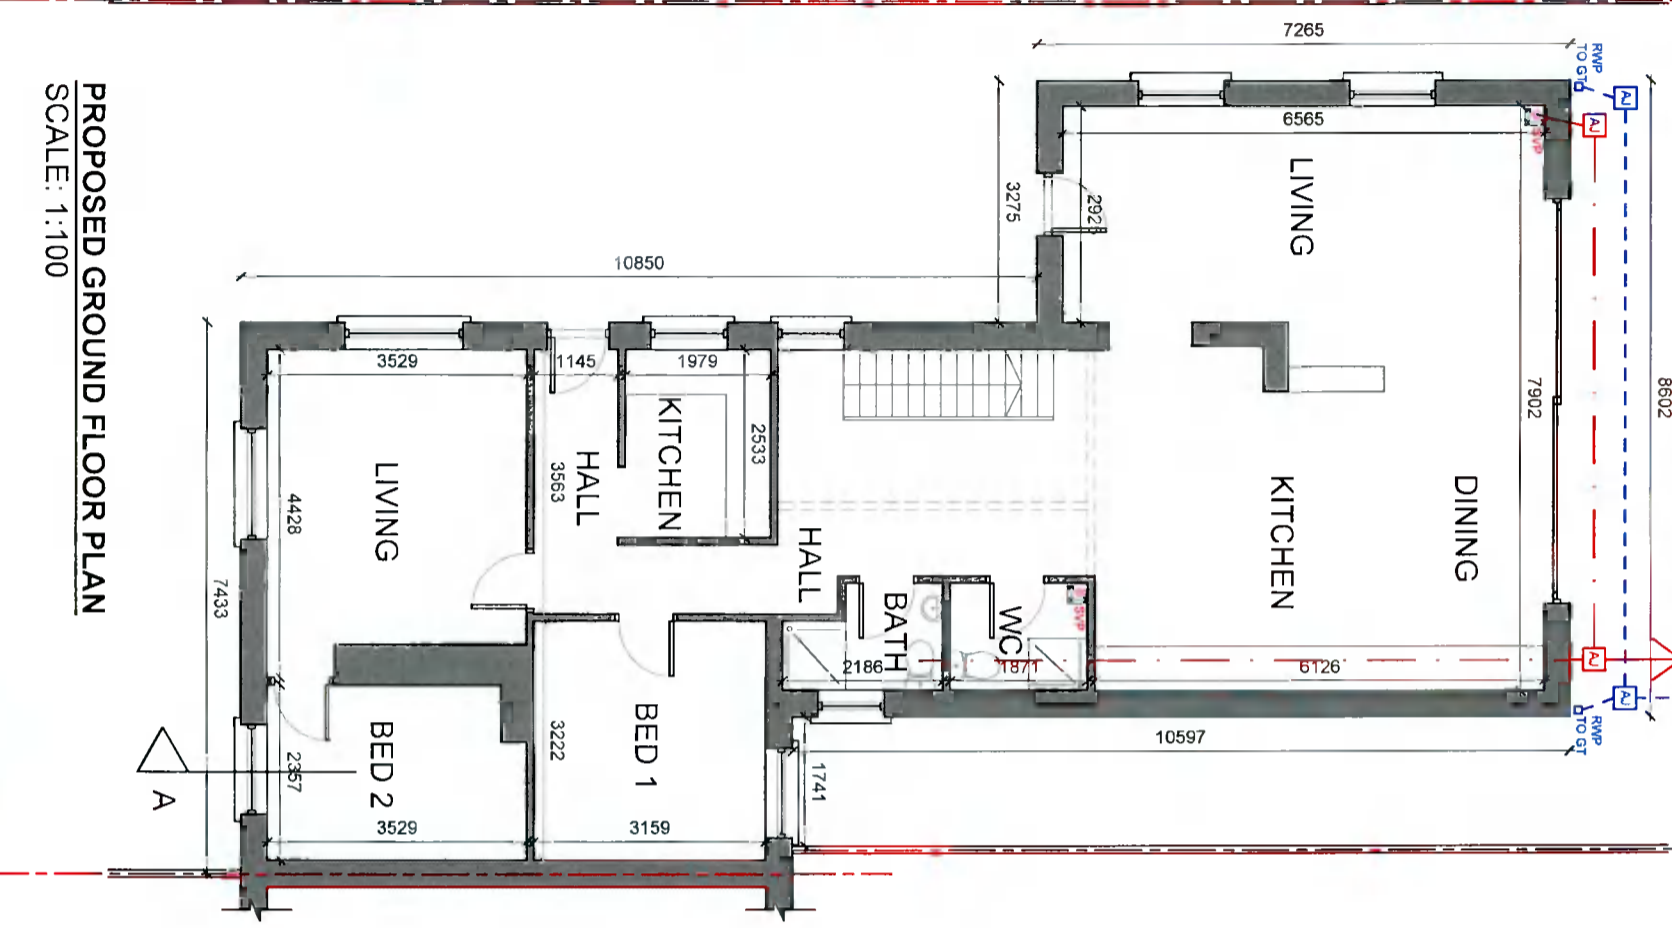

PROPOSED GROUND FLOOR PLAN
SCALE: 1:100

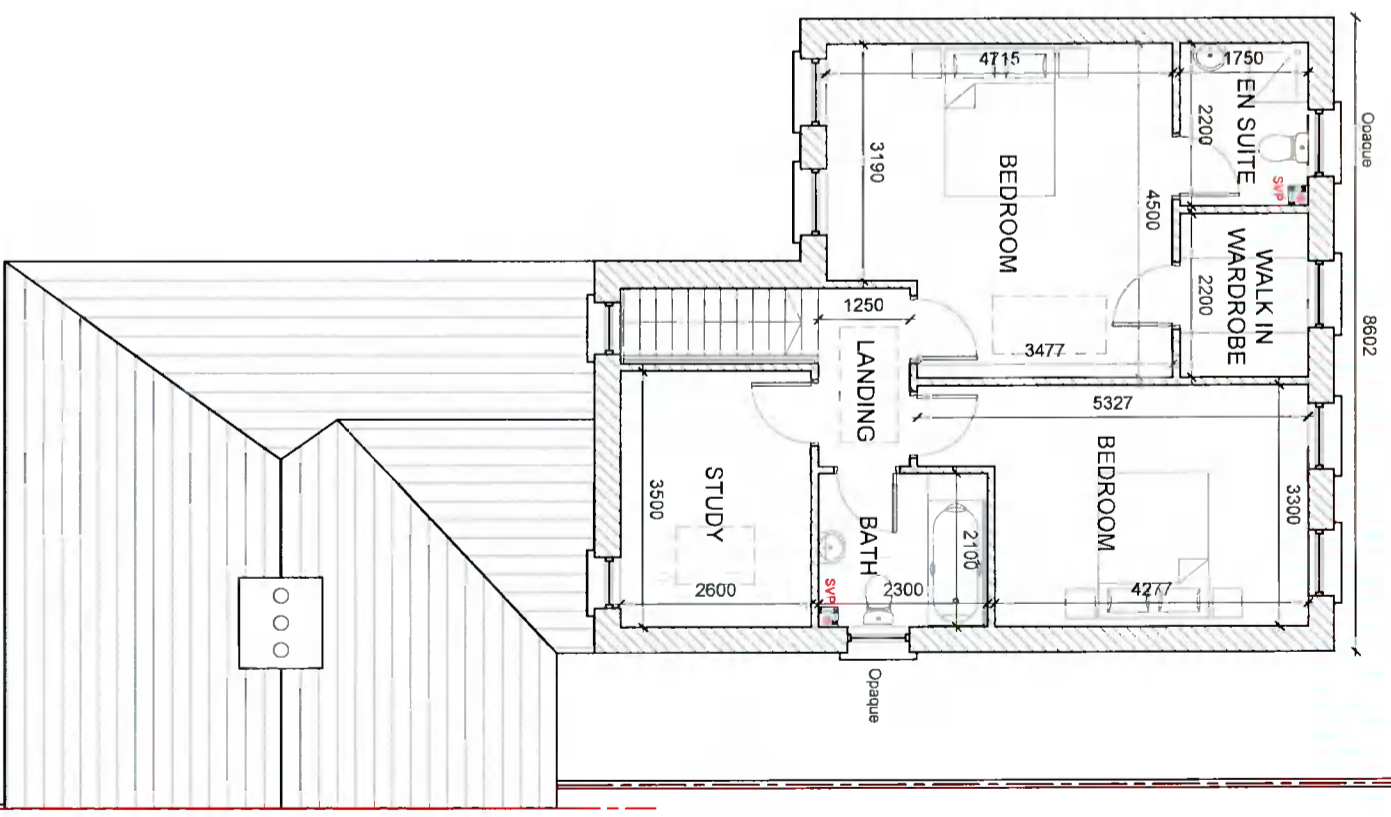

PROPOSED FIRST FLOOR PLAN
SCALE: 1:100



NOTES:
COPYRIGHT RESERVED. DO NOT SCALE DRAWING.
USE FIGURED DIMENSIONS ONLY.
ALL DISCREPANCIES TO BE REPORTED TO AKM CONSULTANTS LTD IMMEDIATELY.
ALL DRAWINGS TO BE READ IN CONJUNCTION WITH STRUCTURAL, ENGINEERS & MECHANICAL ENGINEERS DETAILS. ALL DIMENSIONS TO BE CHECKED ON SITE BY MAIN CONTRACTOR PRIOR TO CONSTRUCTION. MAIN CONTRACTOR RESPONSIBLE FOR SET-OUT

REVISIONS:	DATE	DESCRIPTION	NO

AKM Design
Architecture - Planning - Engineering
Unit 4 Orchard Business Centre 2009 Orchard Avenue Citywest D24
T 353 1 4796234 E info@akmdesign.ie
Architecture | Planning | Engineering | Building Surveying | Development Consultants

PROJECT TITLE:	NO.26 KNOCKMEENAGH RD.
DRAWING TITLE:	PROPOSED GROUND & FIRST FLOOR PLAN
CLIENT:	GRAHAM BROWN
DATE:	JUNE '21

DOCUMENT NO:	20164-AKM-XX-ZZ-DR-A-1001	STAGE:	S4 PLANNING
DRAWN BY:	JK	LEVELS & LOCATION CODE:	XX
PROJECT CODE:	20164	SEQUENCE NUMBER:	1001
ORGANISATION CODE:	AKM	DOCUMENT CODE:	DR
DEPARTMENT CODE:	NA	REVISION:	AKM JOB NO.: 20164
ROLES CODE:	A		