



NOTES:


1. THIS DRAWING IS TO BE READ IN CONJUNCTION WITH ALL OTHER RELEVANT DRAWINGS & SPECIFICATIONS.
2. DO NOT SCALE, USE FIGURED DIMENSIONS ONLY.

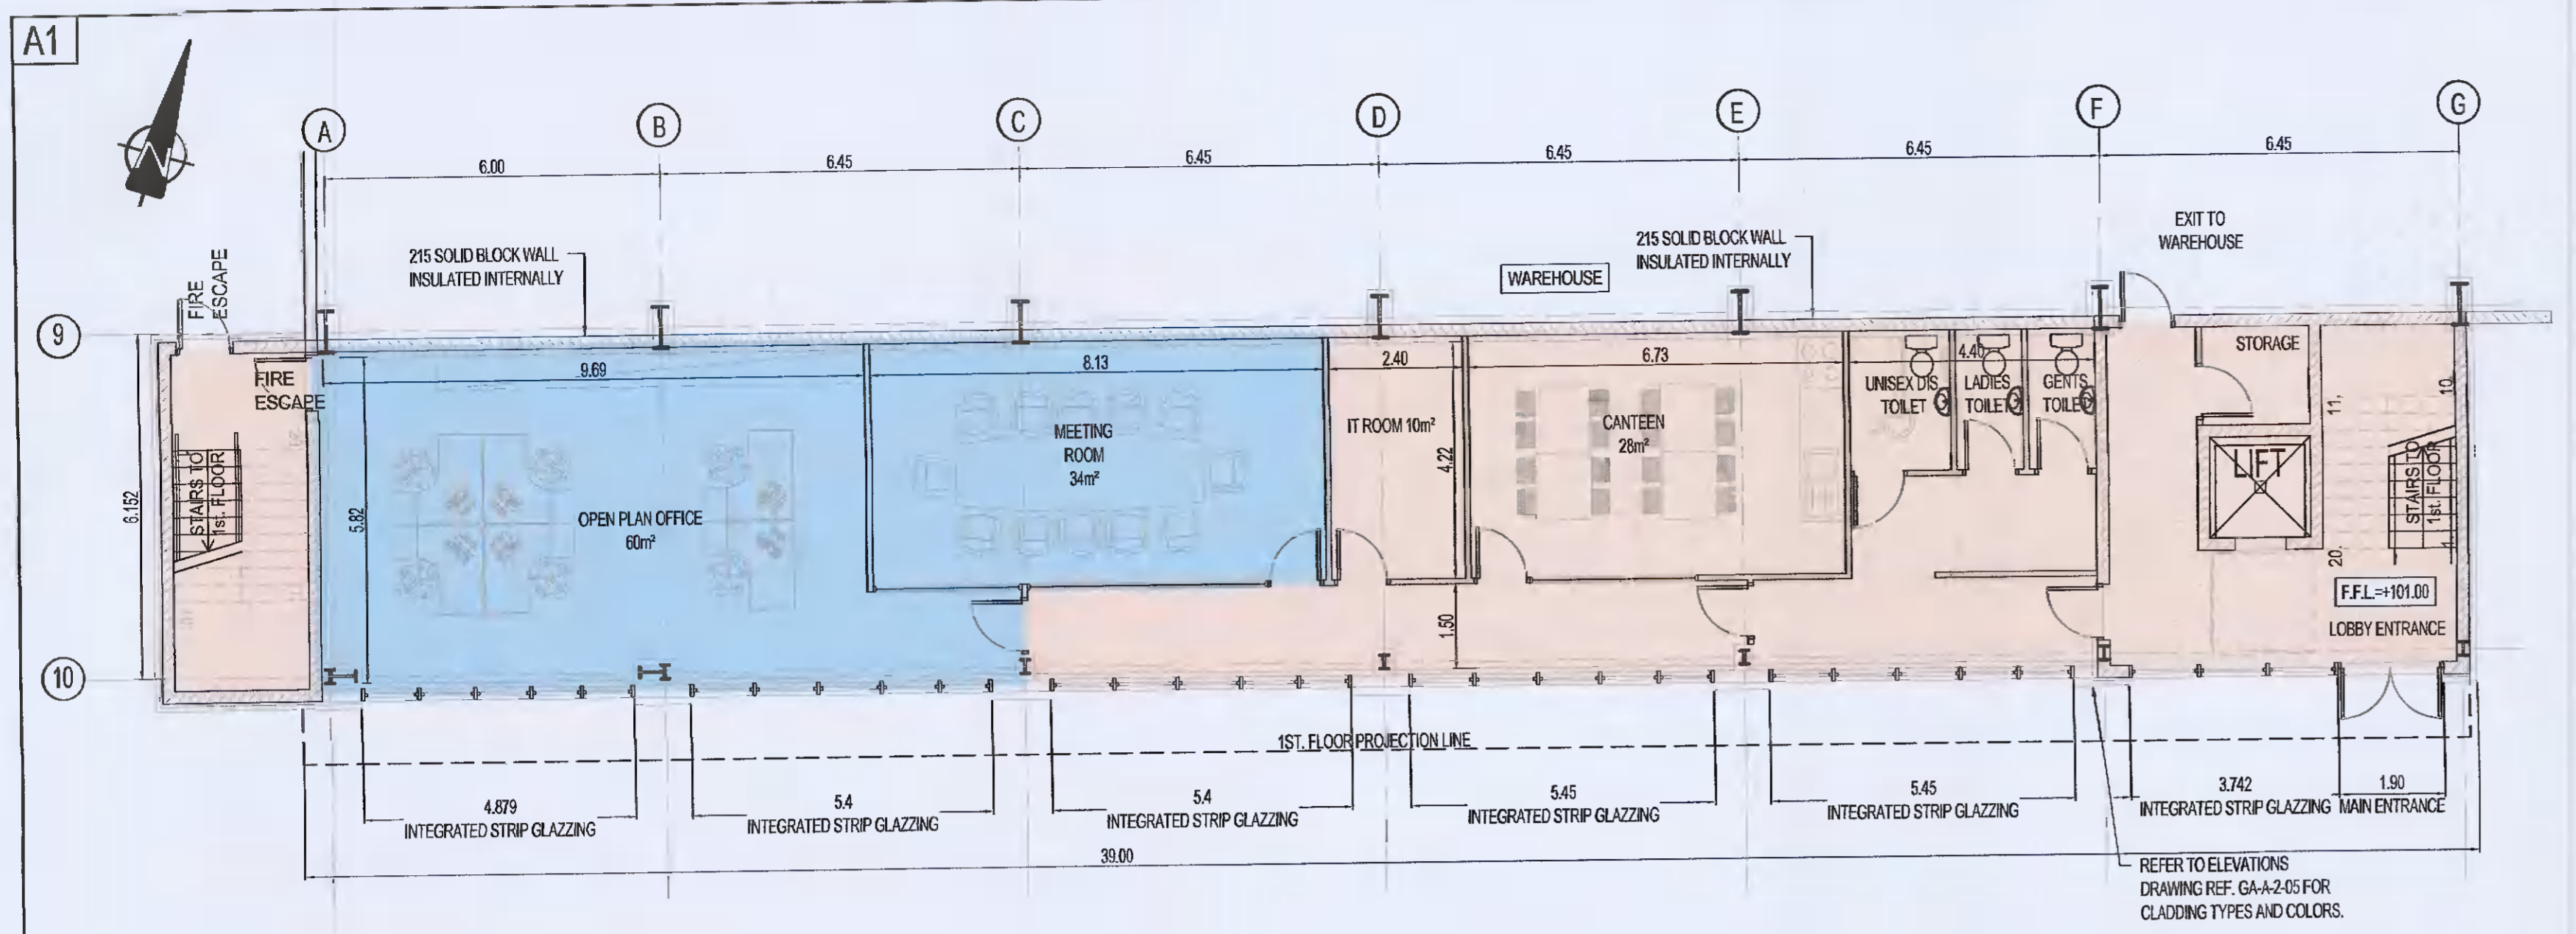


ANCILLARY OFFICES - GROUND FLOOR PLAN
SCALE 1:100

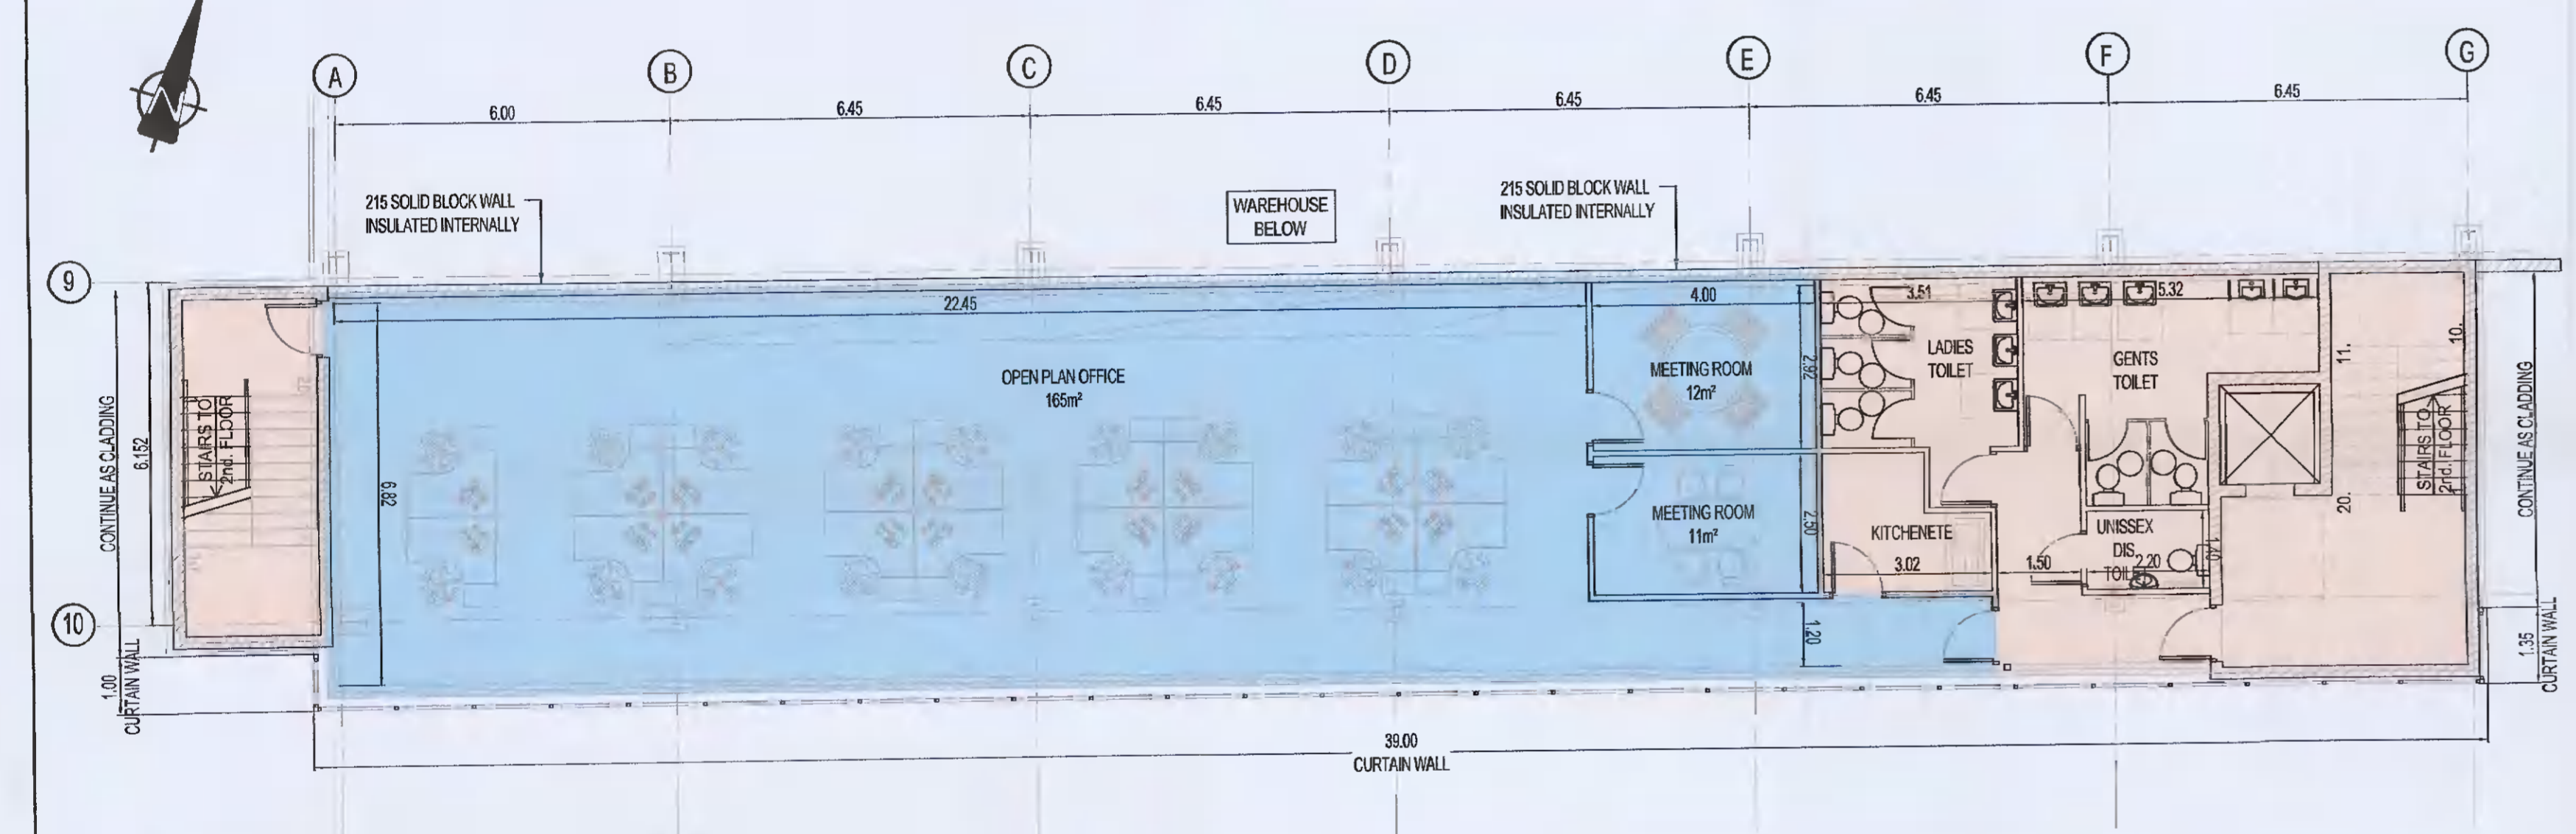


ANCILLARY OFFICES - FIRST FLOOR PLAN
SCALE 1:100

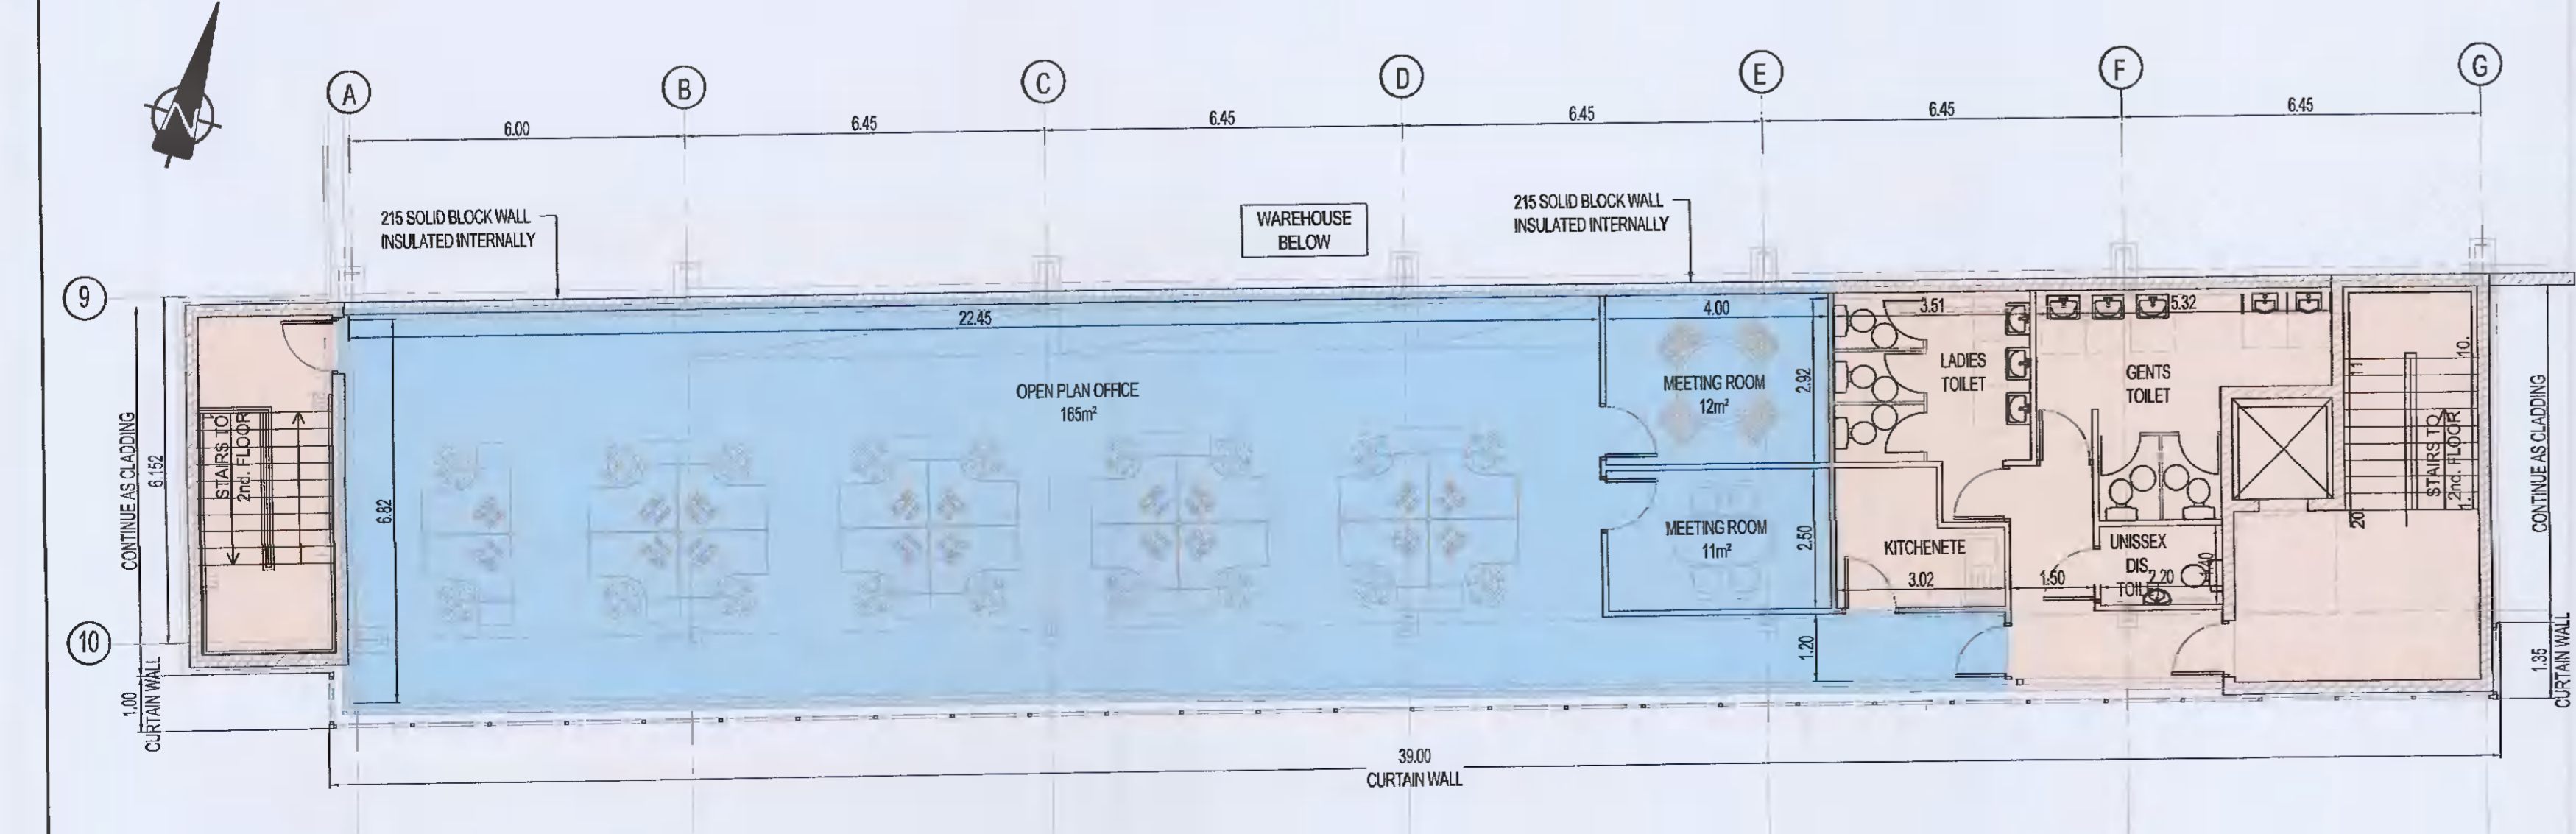


ANCILLARY OFFICES - SECOND FLOOR PLAN
SCALE 1:100

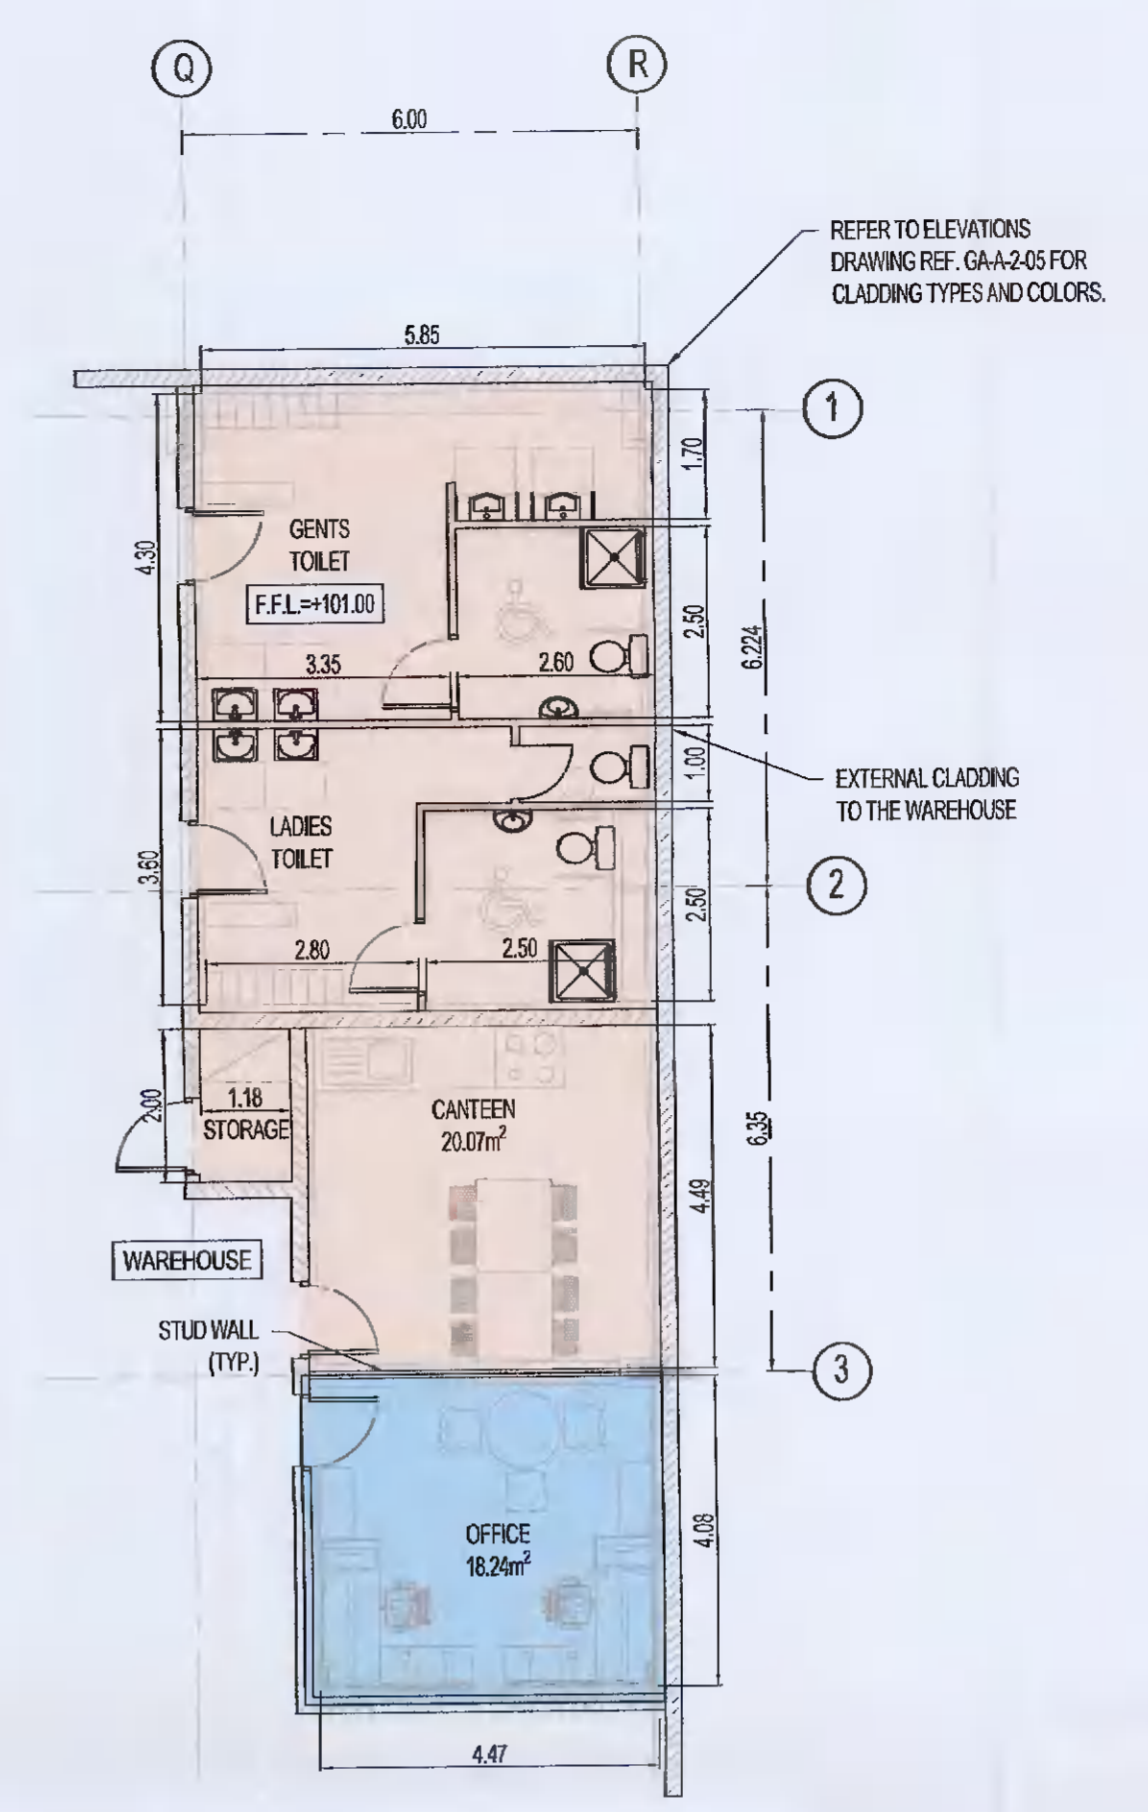

STAFF FACILITIES TOILET BLOCK - GROUND FLOOR PLAN
SCALE 1:100

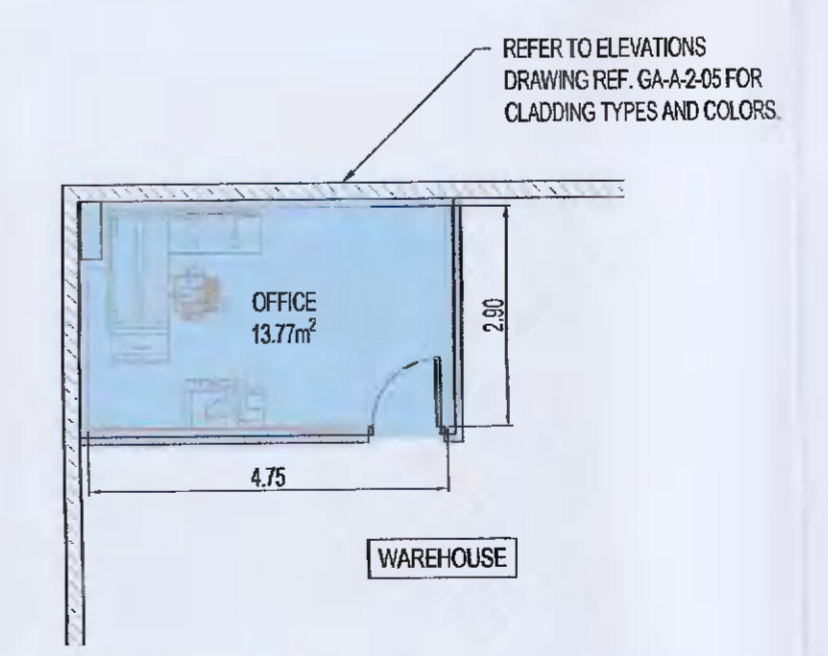

MODULAR OFFICE - GROUND FLOOR PLAN
SCALE 1:100

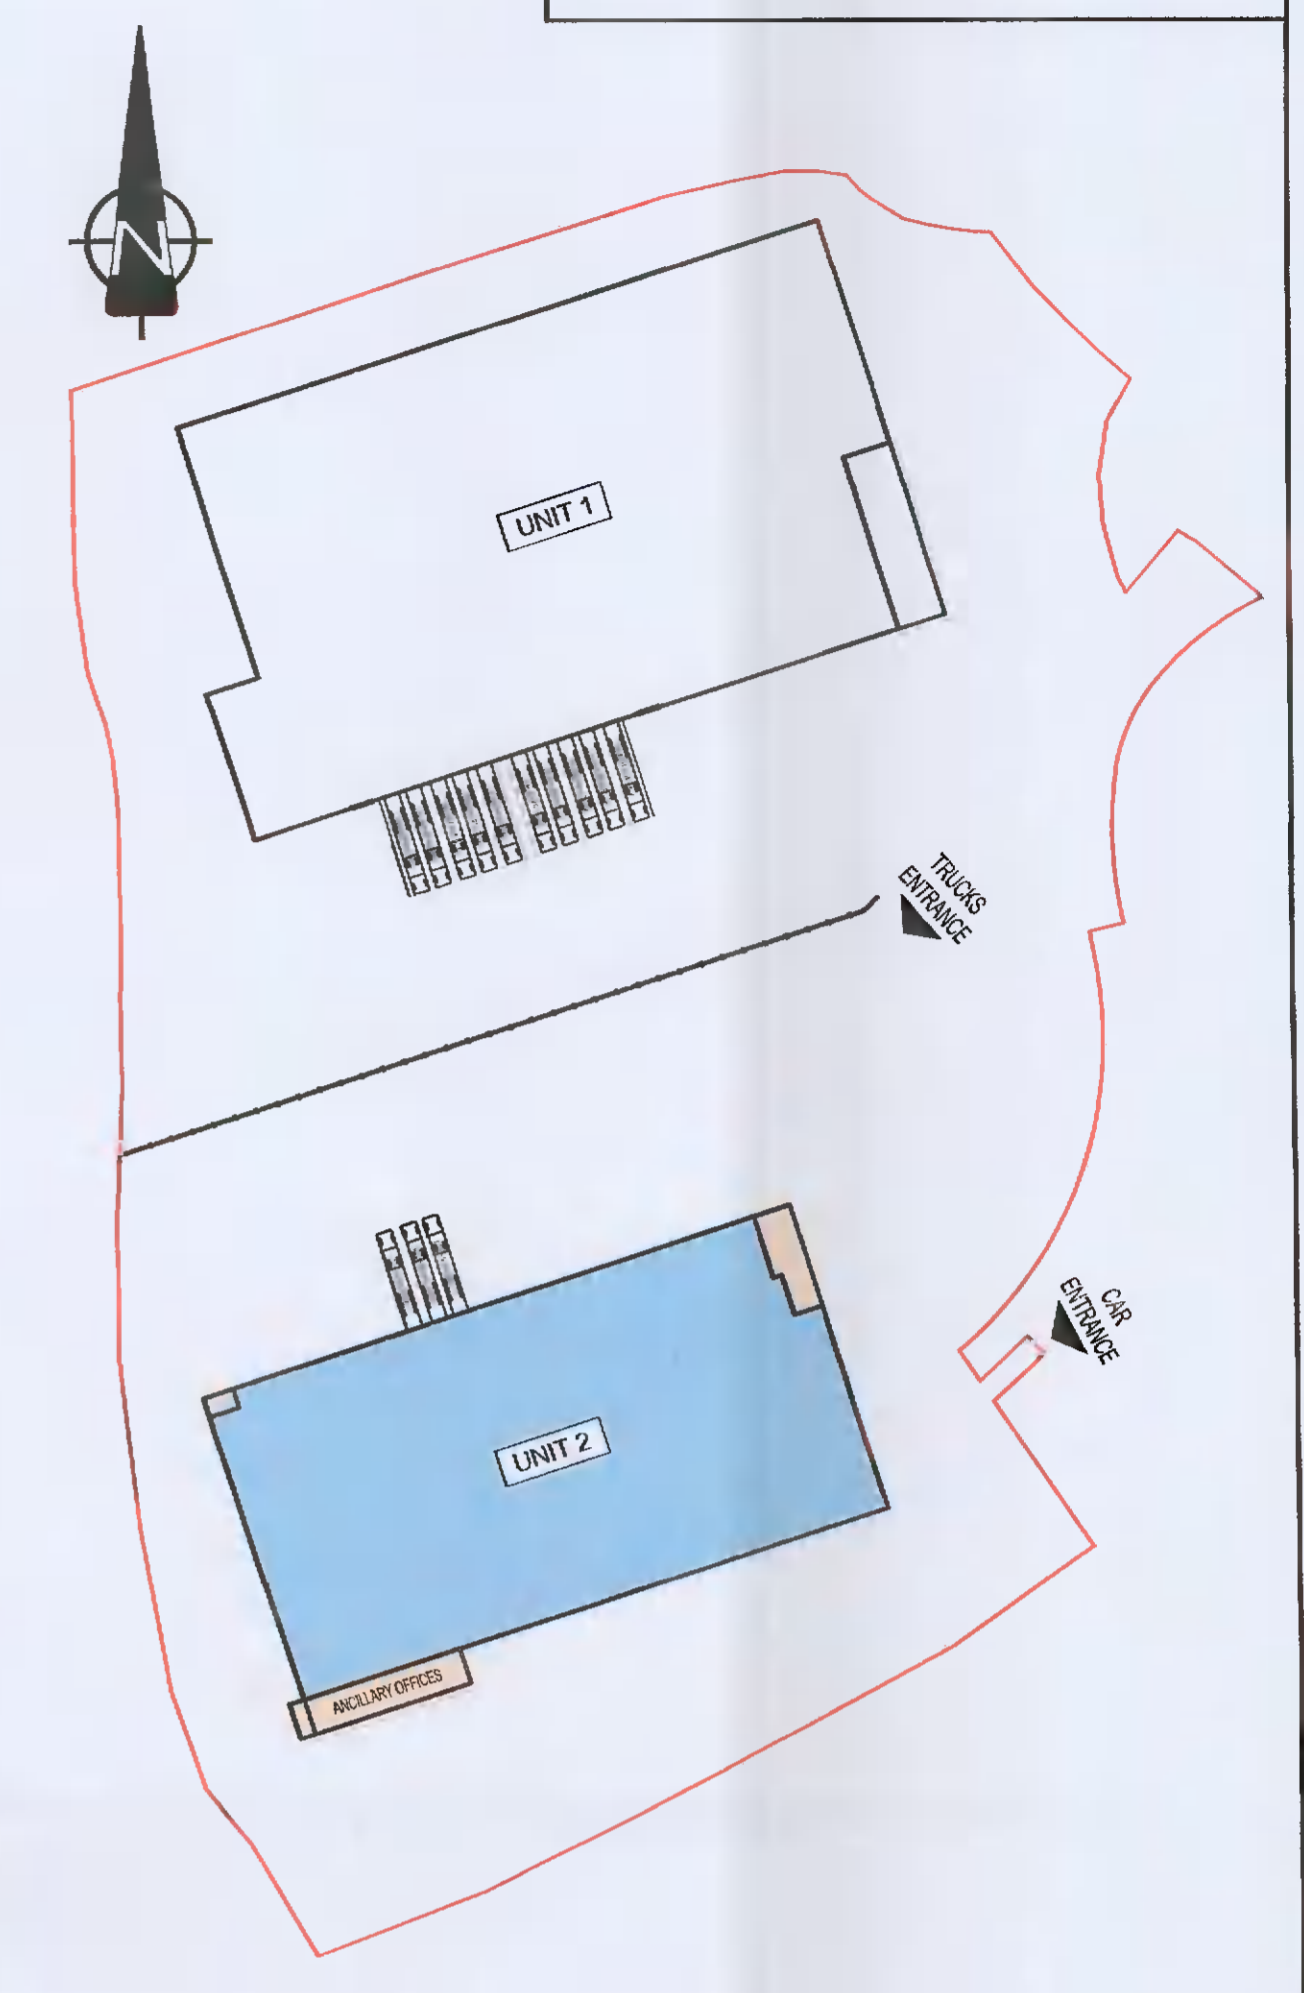

KEY PLAN
SCALE 1:1250

PL7	31-05-2021	TK	PK	PK	ISSUED FOR PLANNING
Rev	Date	By	Chk.	App.	Reason
PLANNING					
Job Title WAREHOUSE DEVELOPMENT AT BROWNSBARN, CITYWEST CAMPUS, DUBLIN 24					
Drawing Title UNIT 2 ANCILLARY OFFICE & WAREHOUSE TOILET BLOCK FLOOR PLANS					
Author/Client Exeter Ireland Property IV B Limited					
KAVANAGH BURKE CONSULTING ENGINEERS					
Tel. 01 - 450 0694		Unit G3, Calmount Pk.		Ballymount, Dublin 12.	
Fax. 01 - 426 4340					
Email: pkavanagh@kavanaghburke.ie					
Dr. SCB	Checked: SB	Approved: PK			
Scale: 1:100	Date: May 2021				
Job No: D1678	Drawing: GA-A-2-04	Rev: PL7			