


UNIT 1 - SPRINKLER TANK & PUMP HOUSE FLOOR PLAN

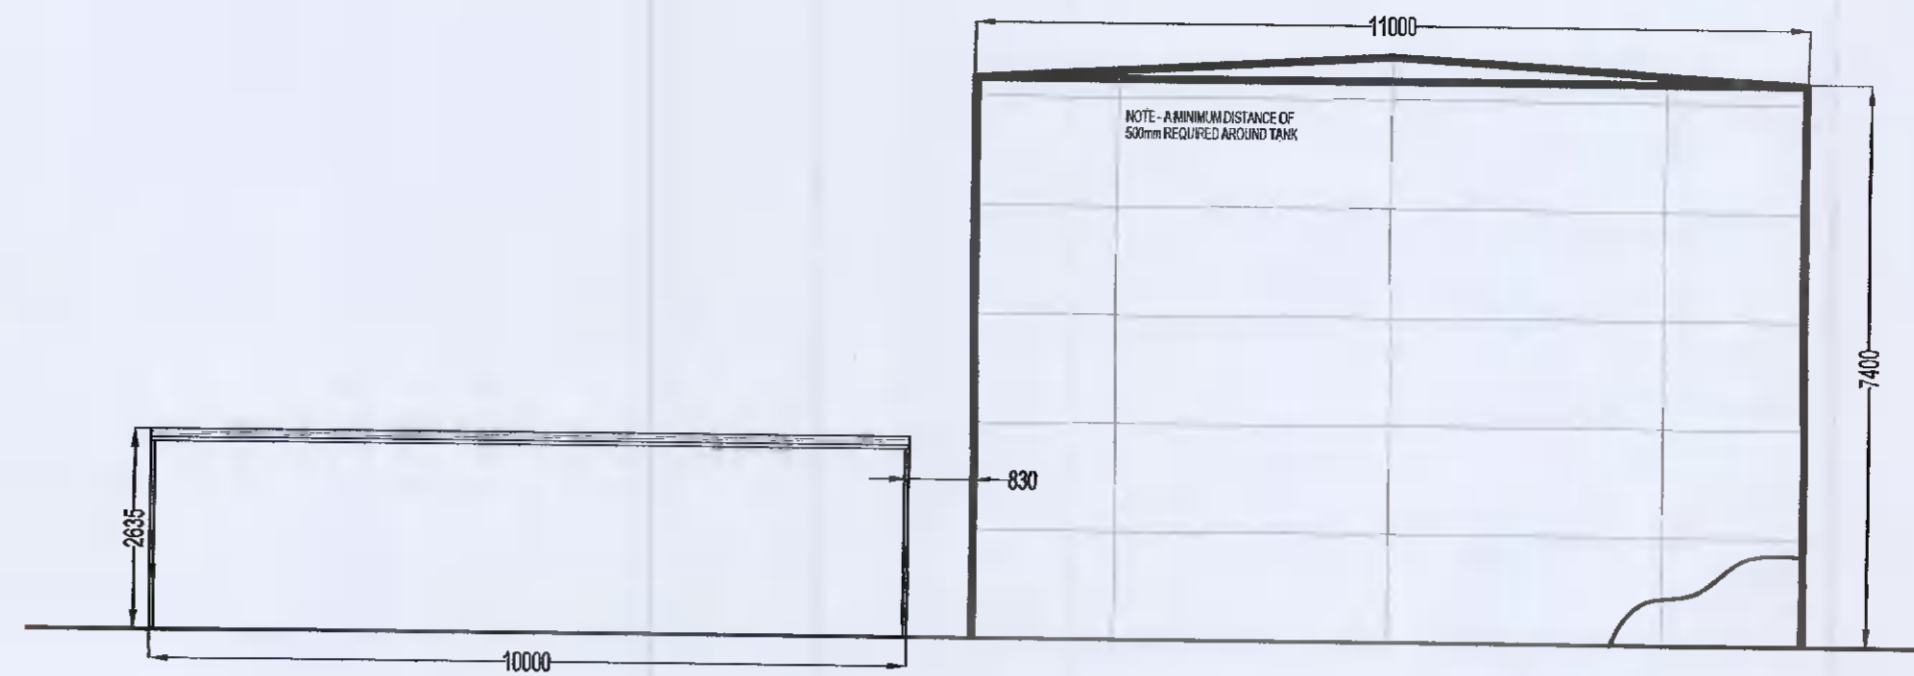

UNIT 1 - SPRINKLER TANK & PUMP HOUSE SECTION A-A
SCALE 1:100



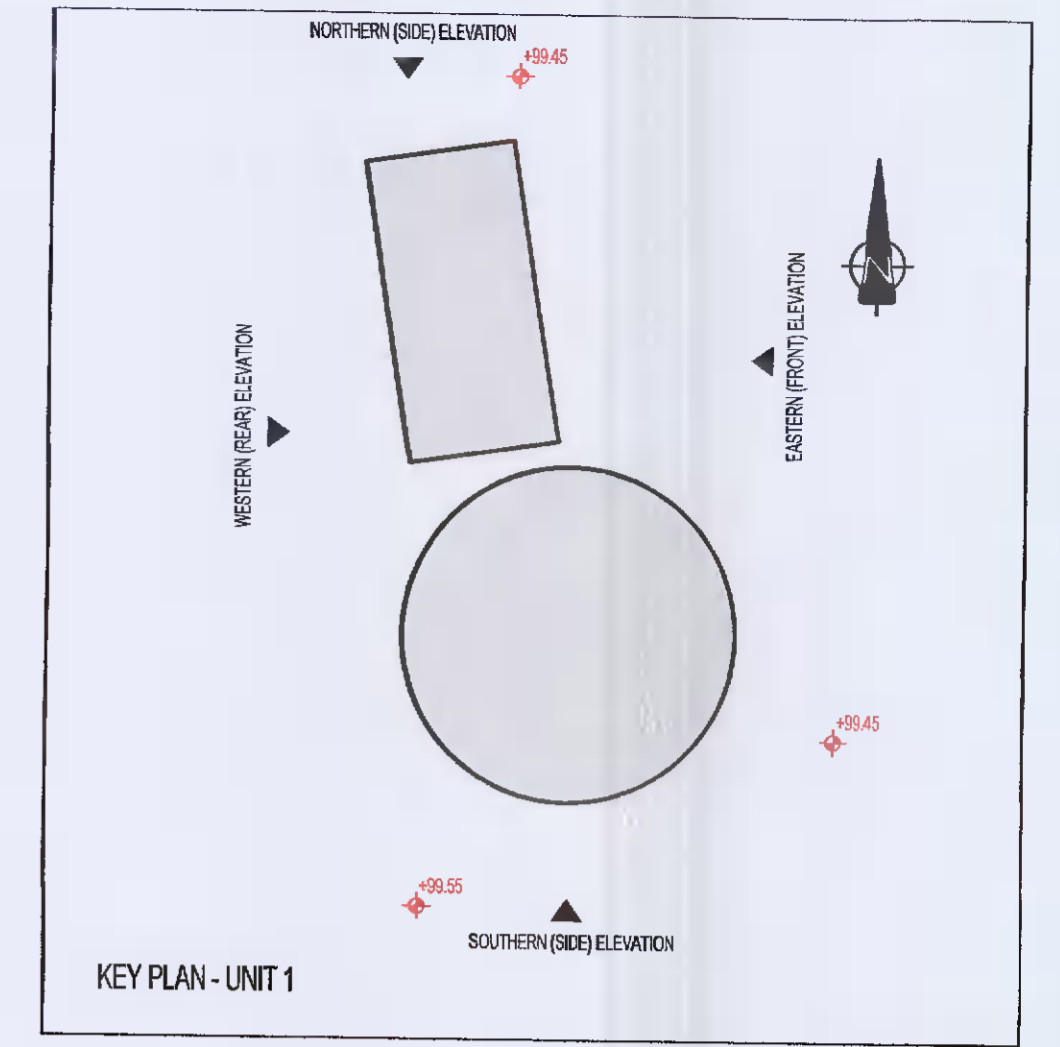


TABLE OF AREA & VOLUME OF SPRINKLER TANK AND PUMPHOUSE


UNIT 1	SPRINKLER TANK AREA	SPRINKLER TANK VOLUME	PUMP HOUSE AREA
GROUND FLOOR	95m ²	703m ³	47m ²

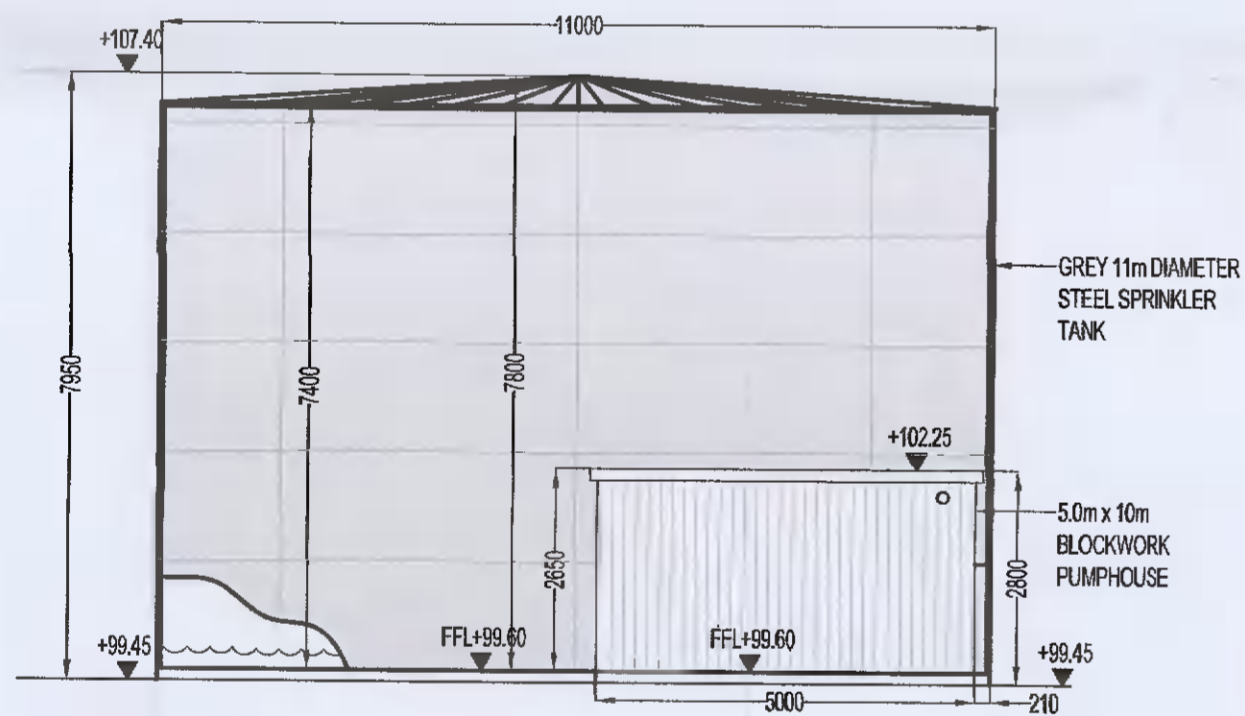


NORTHERN (SIDE) ELEVATION
SCALE 1:100

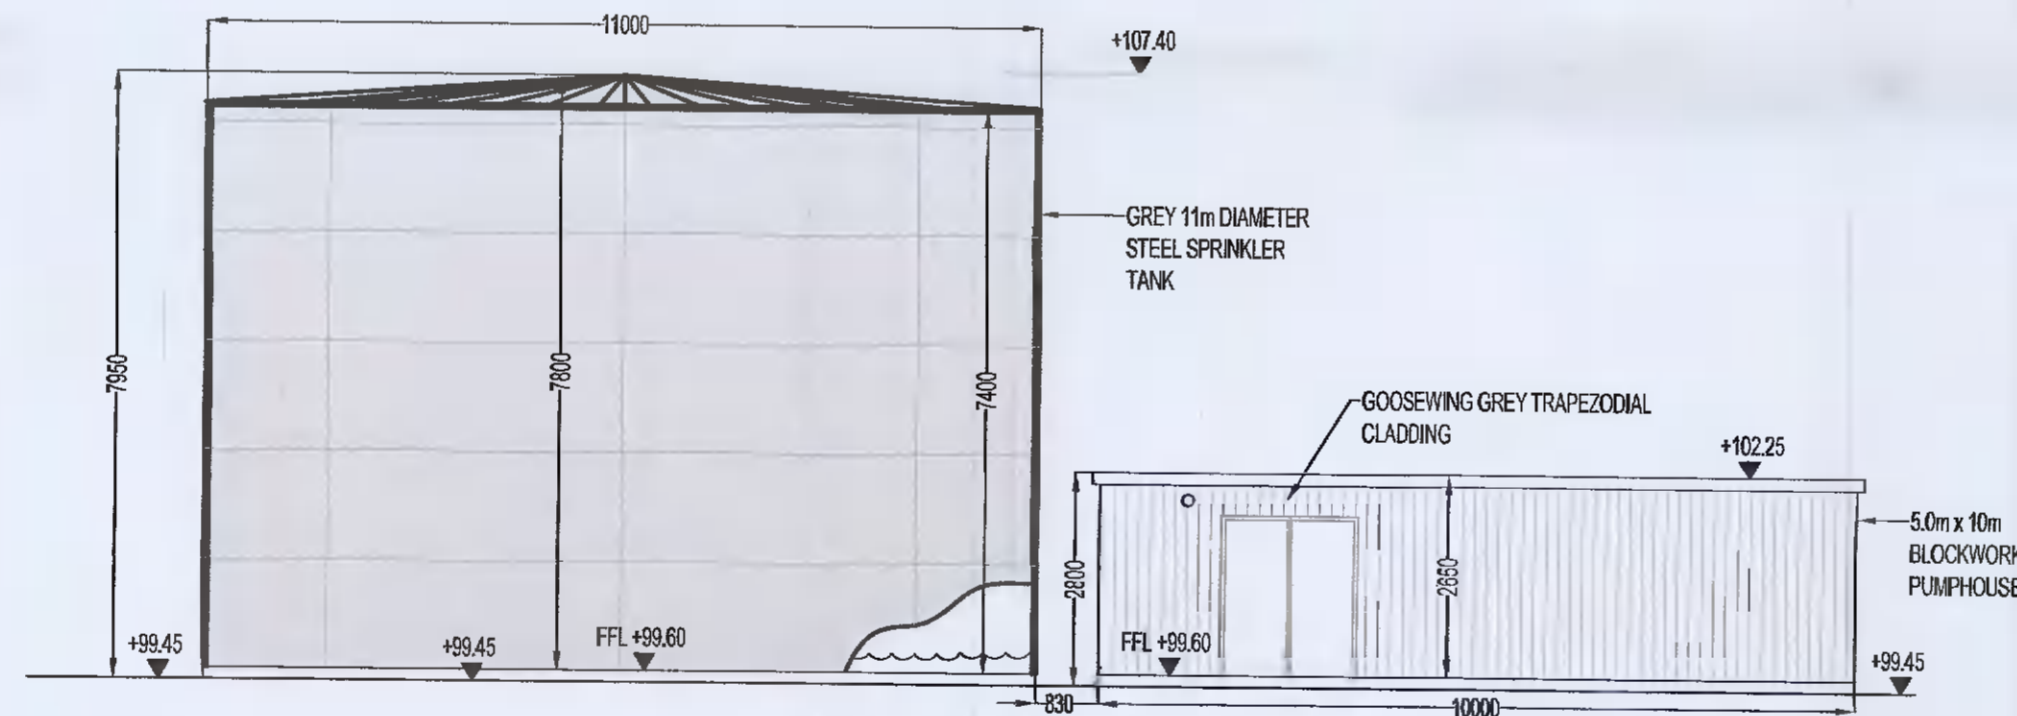

EASTERN (FRONT) ELEVATION
SCALE 1:100

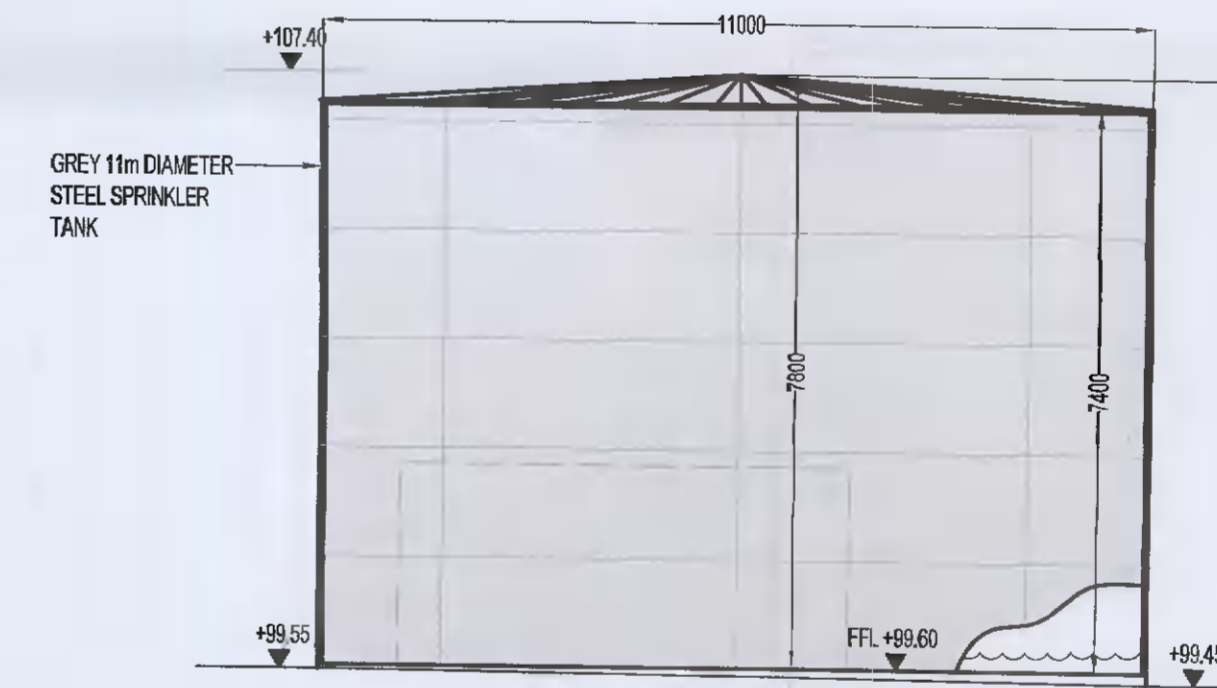

SOUTHERN (SIDE) ELEVATION
SCALE 1:100

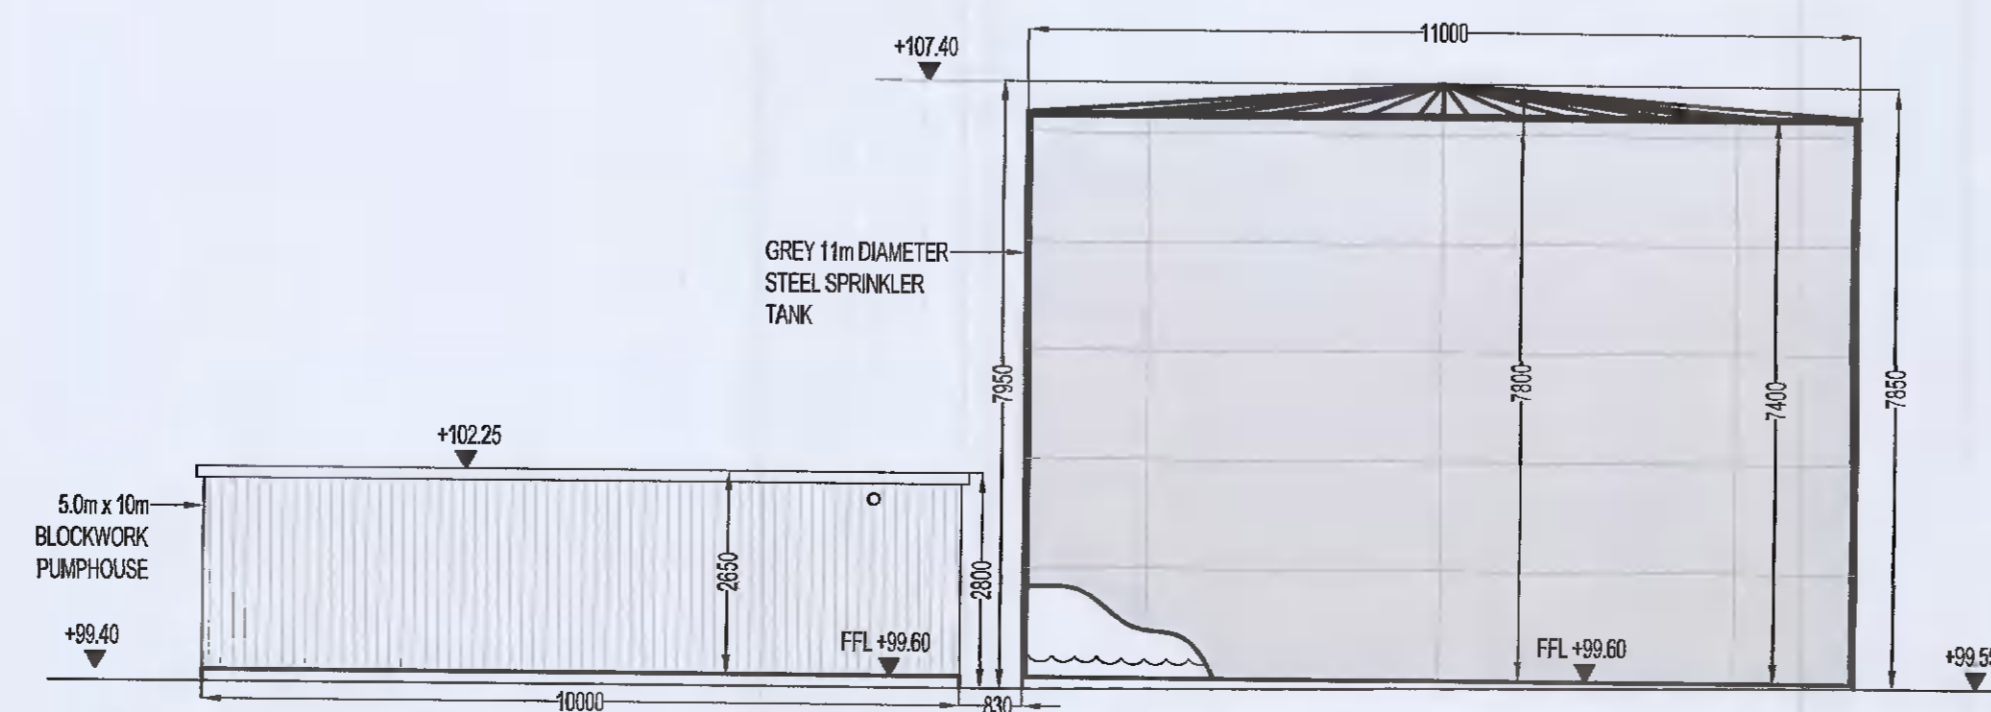

WESTERN (REAR) ELEVATION
SCALE 1:100

PL1	20/03/2021	OB	ED	PK	ISSUED FOR PLANNING
Mark	Date	By	Chk	App	Reason
PLANNING					
WAREHOUSE DEVELOPMENT AT BROWNSBARN, CITYWEST CAMPUS, DUBLIN 24					
UNIT 1 SPRINKLER TANK & PUMP HOUSE PLAN, SECTION AND ELEVATIONS					
Exeter Ireland Property IV B Limited					
KAVANAGH BURKE CONSULTING ENGINEERS					
Tel: 01 - 450 0694		Unit G3, Calmount Pk.		Ballymount, Dublin 12.	
Fax: 01 - 426 4340		Email: pkavanagh@kavanaghburke.ie			
Drn	OB	Checked	ED	Approved	PK
Scale:	1:100	Date:	June 2021		
Job No:	D1678	Drawings:	SP-01	PL1	