



As agreed with South Dublin County Council in the pre-application consultation meeting the final finishes, including cladding materials and colour codes, will be agreed with the Council post planning through planning condition. Greener Ideas Limited will ensure only Council approved finished are applied on site.

 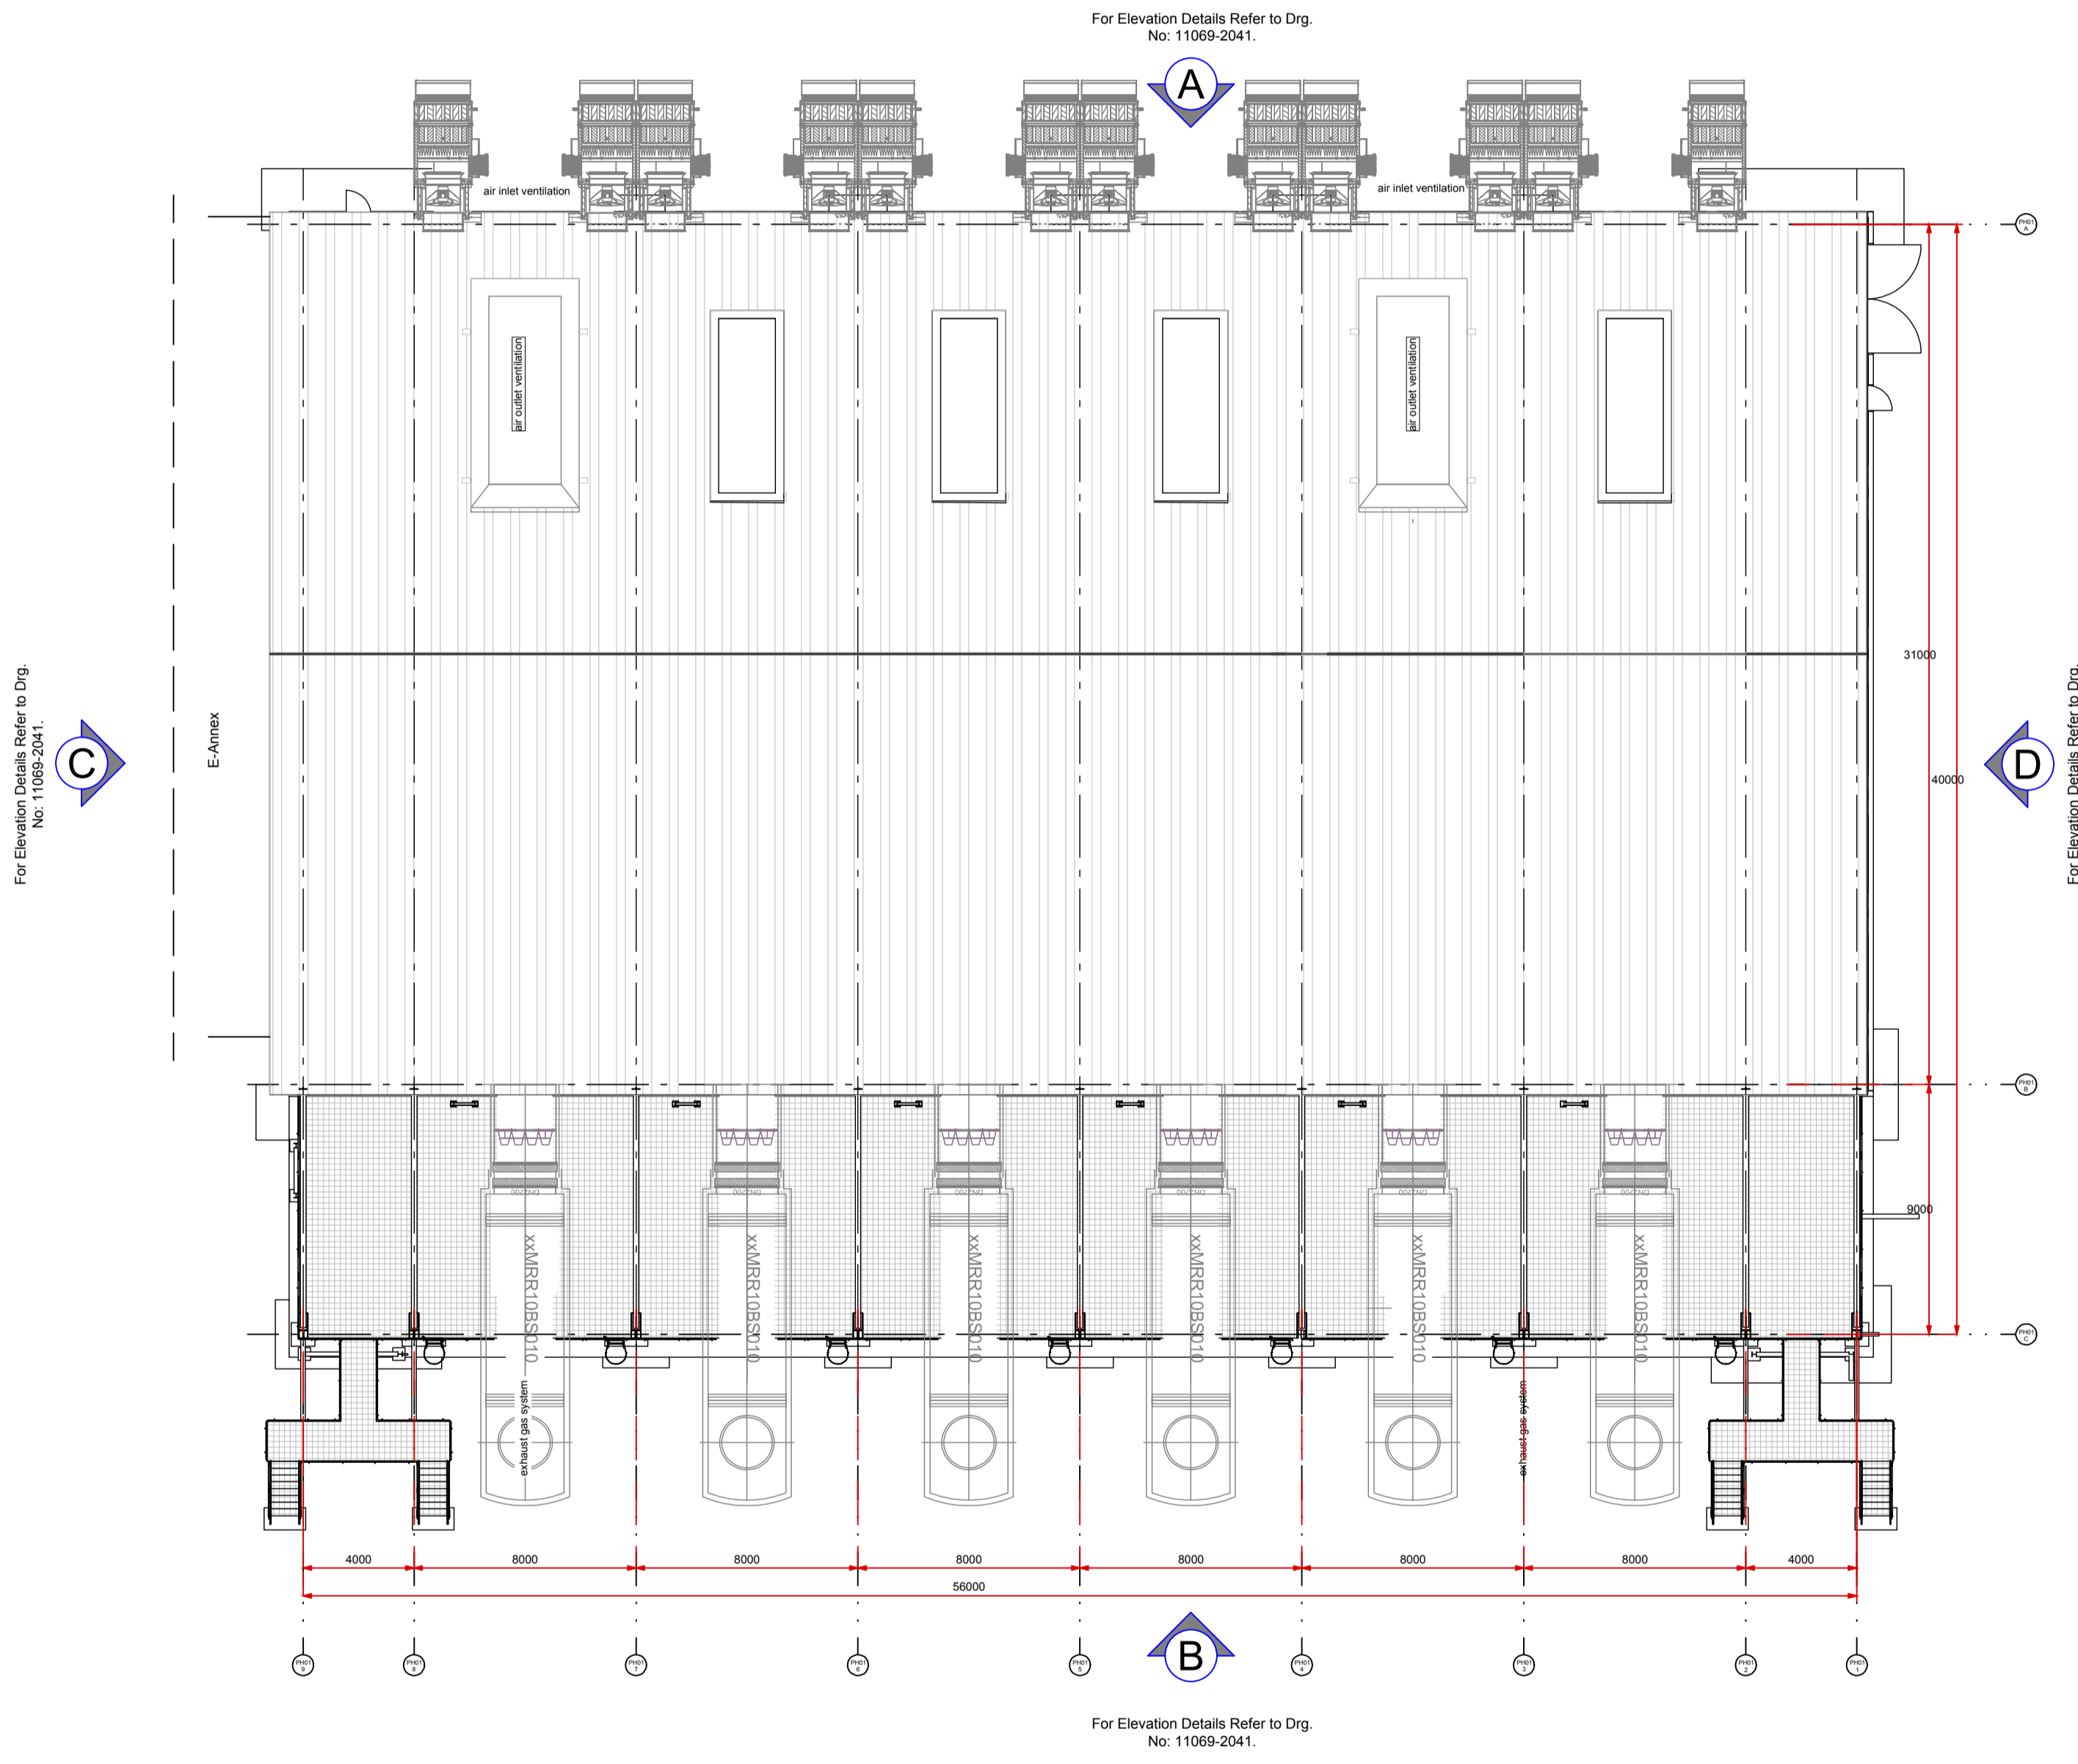


ROOF PLAN

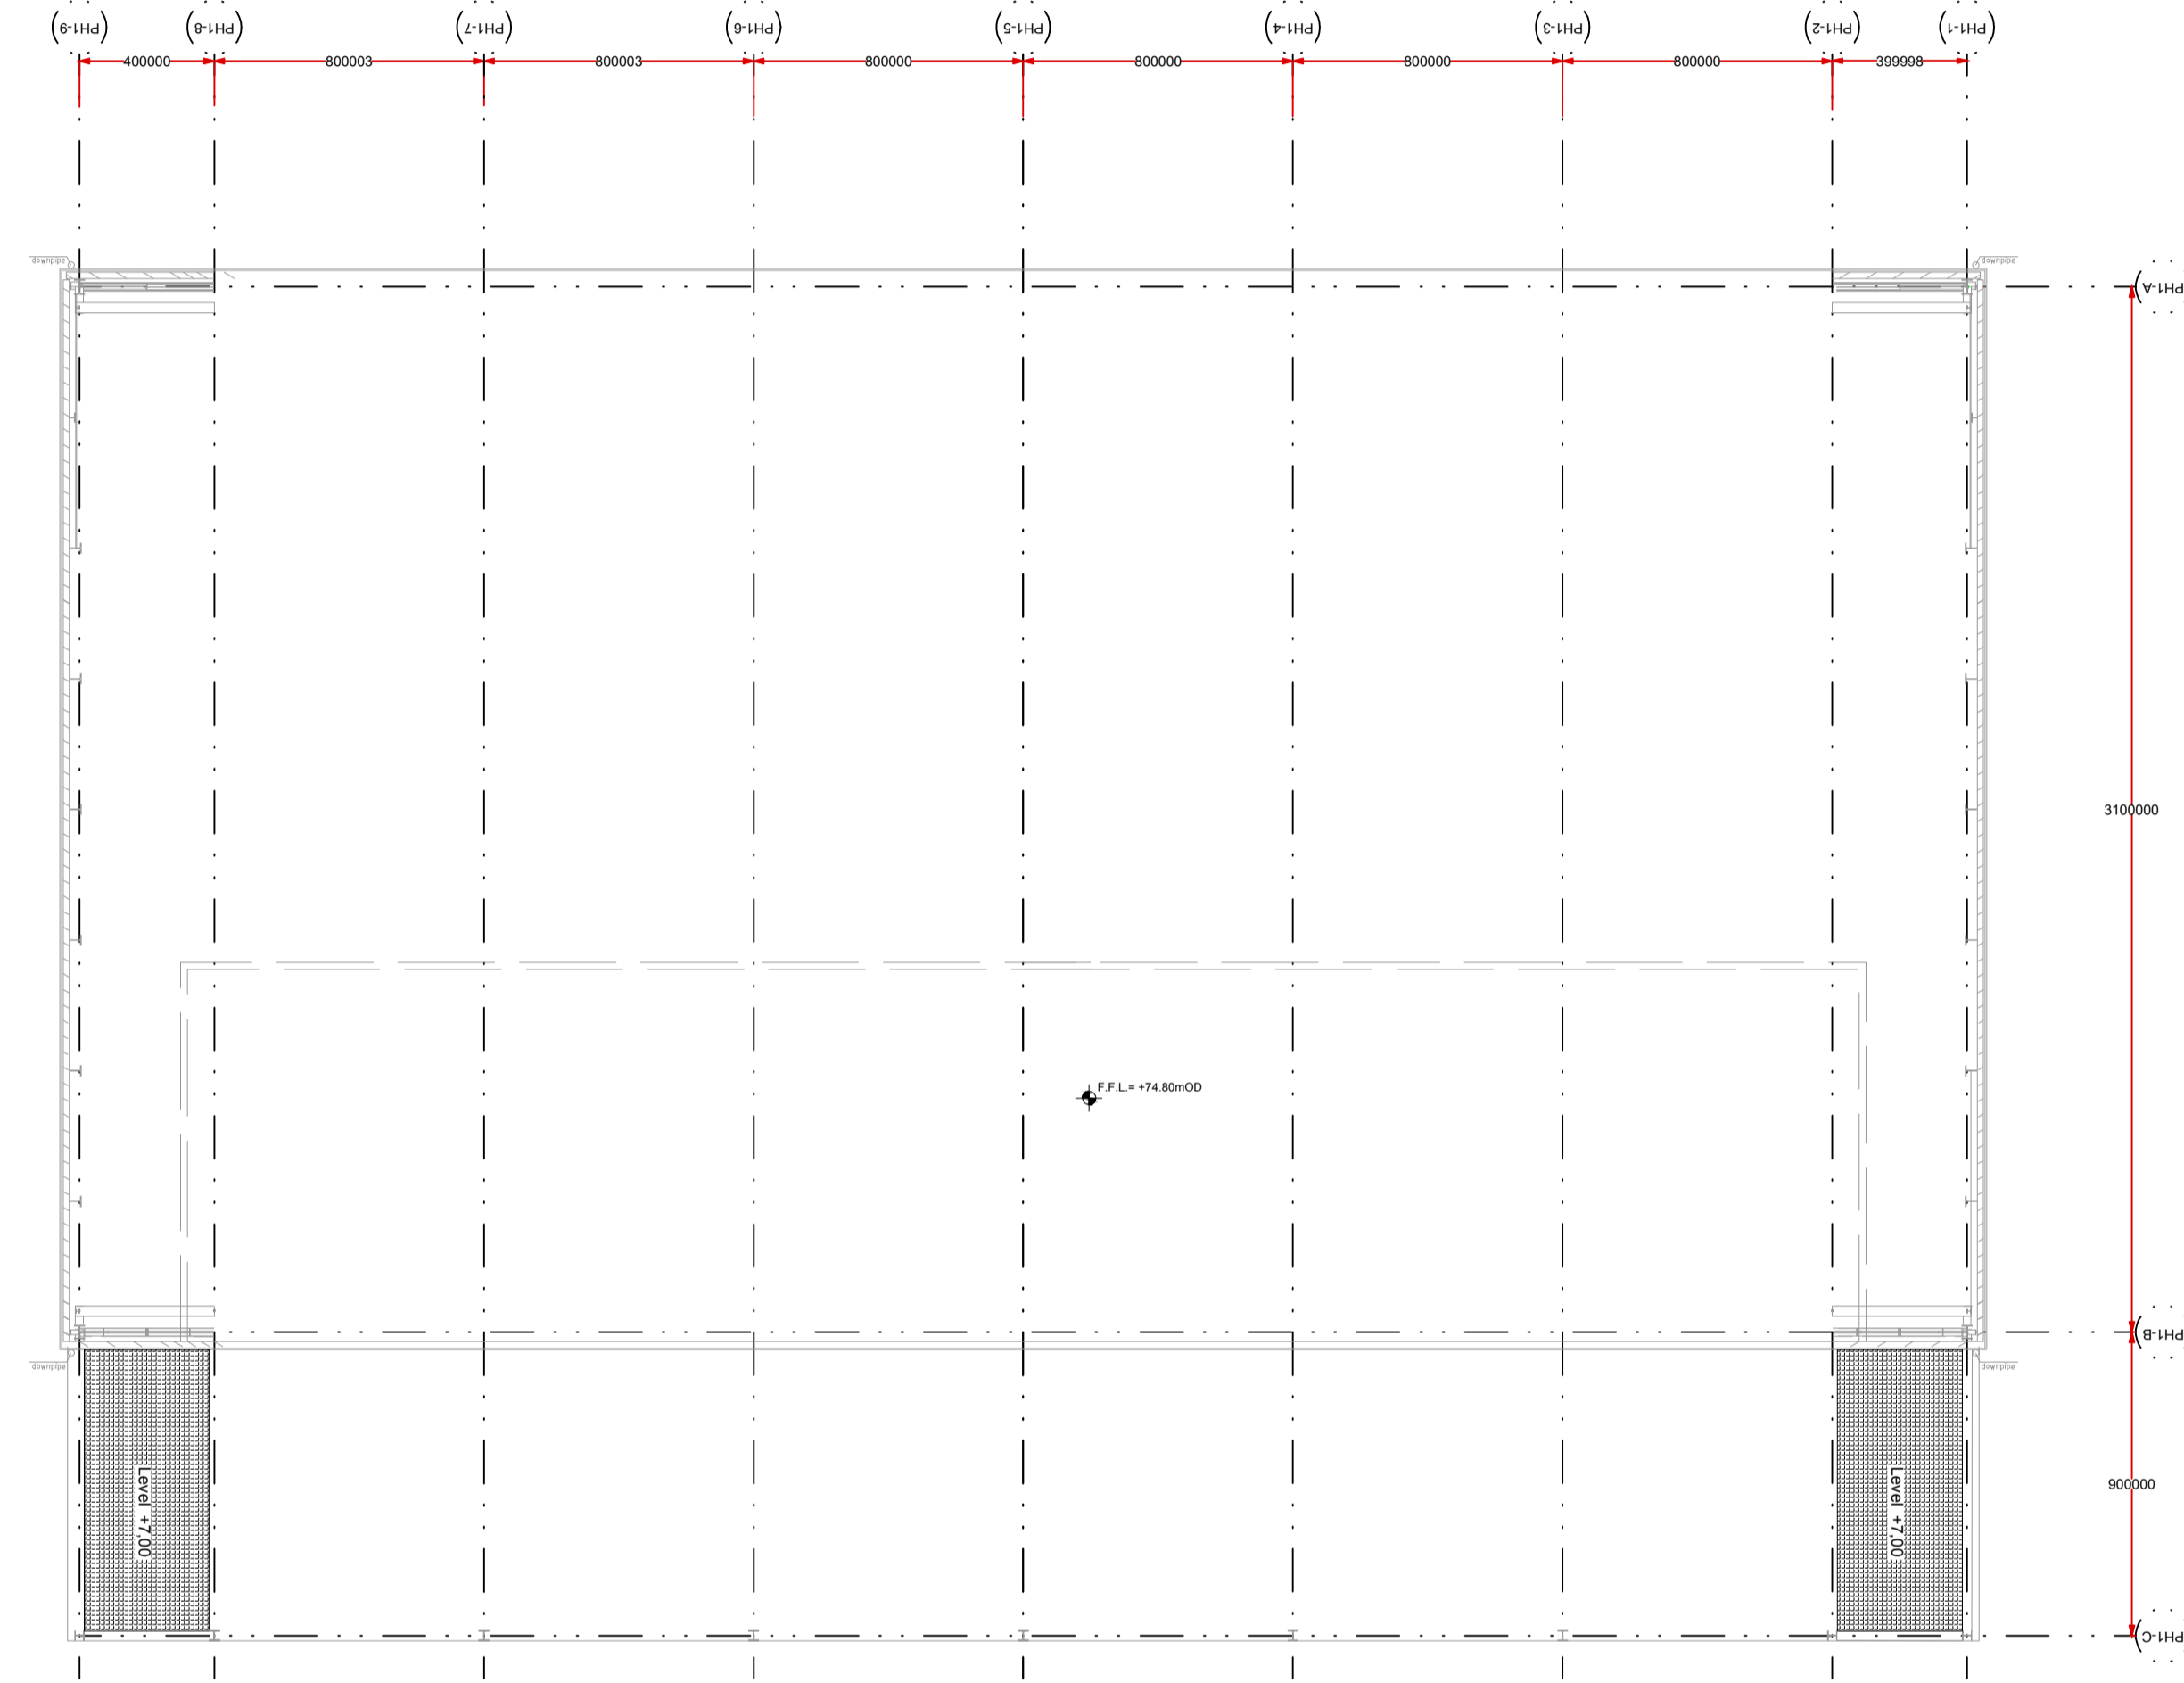

FLOOR PLAN

- NOTES:
- FIGURED DIMENSIONS ONLY TO BE TAKEN FROM THIS DRAWING.
  - ALL DRAWINGS TO BE CHECKED BY THE CONTRACTOR ON SITE.
  - ENGINEER/EMPLOYERS REPRESENTATIVE, AS APPROPRIATE, TO BE INFORMED BY THE CONTRACTOR OF ANY DISCREPANCIES BEFORE ANY WORK COMMENCES.
  - THE CONTRACTOR SHALL UNDERTAKE A THOROUGH CHECK FOR THE ACTUAL LOCATION OF ALL SERVICES/UTILITIES, ABOVE AND BELOW GROUND, BEFORE ANY WORK COMMENCES.
  - ALL LEVELS SHOWN RELATE TO ORDNANCE SURVEY DATUM AT MALIN HEAD.



Rev	Date	Description	By	Chkd.
A	18.06.21	PLANNING ISSUE	MN	MMCC

Client:

Project: **PROFILE PARK POWER PLANT**

Title: **GAS ENGINE HALL FLOOR & ROOF PLANS**

Scale @ A1: 1:200

Prepared by: M. Nolan    Checked: M. McCarthy    Date: June 2021

Project Director: S. Tinnelly

Drawing Status: Planning

**TOBIN**  
CONSULTING ENGINEERS

Block 10-4, Blanchardstown Corporate Park,  
Dublin 15, Ireland.  
tel: +353-(0)1-8030406  
fax: +353-(0)1-8030409  
e-mail: dublin@tobin.ie  
www.tobin.ie

TOBIN Consulting Engineers will not be liable for any use of this document for any purpose other than that for which it was originally prepared and approved. Except where specifically and explicitly agreed in writing by TOBIN Consulting Engineers, copyright in this document and any information contained therein shall remain the property of TOBIN Consulting Engineers and shall not be reproduced or transmitted in any form and this document shall not be relied upon by any third party for any purpose.

Drawing No.: 11069-2040    Revision: **A**