




SIDE ELEVATION
Scale 1:125

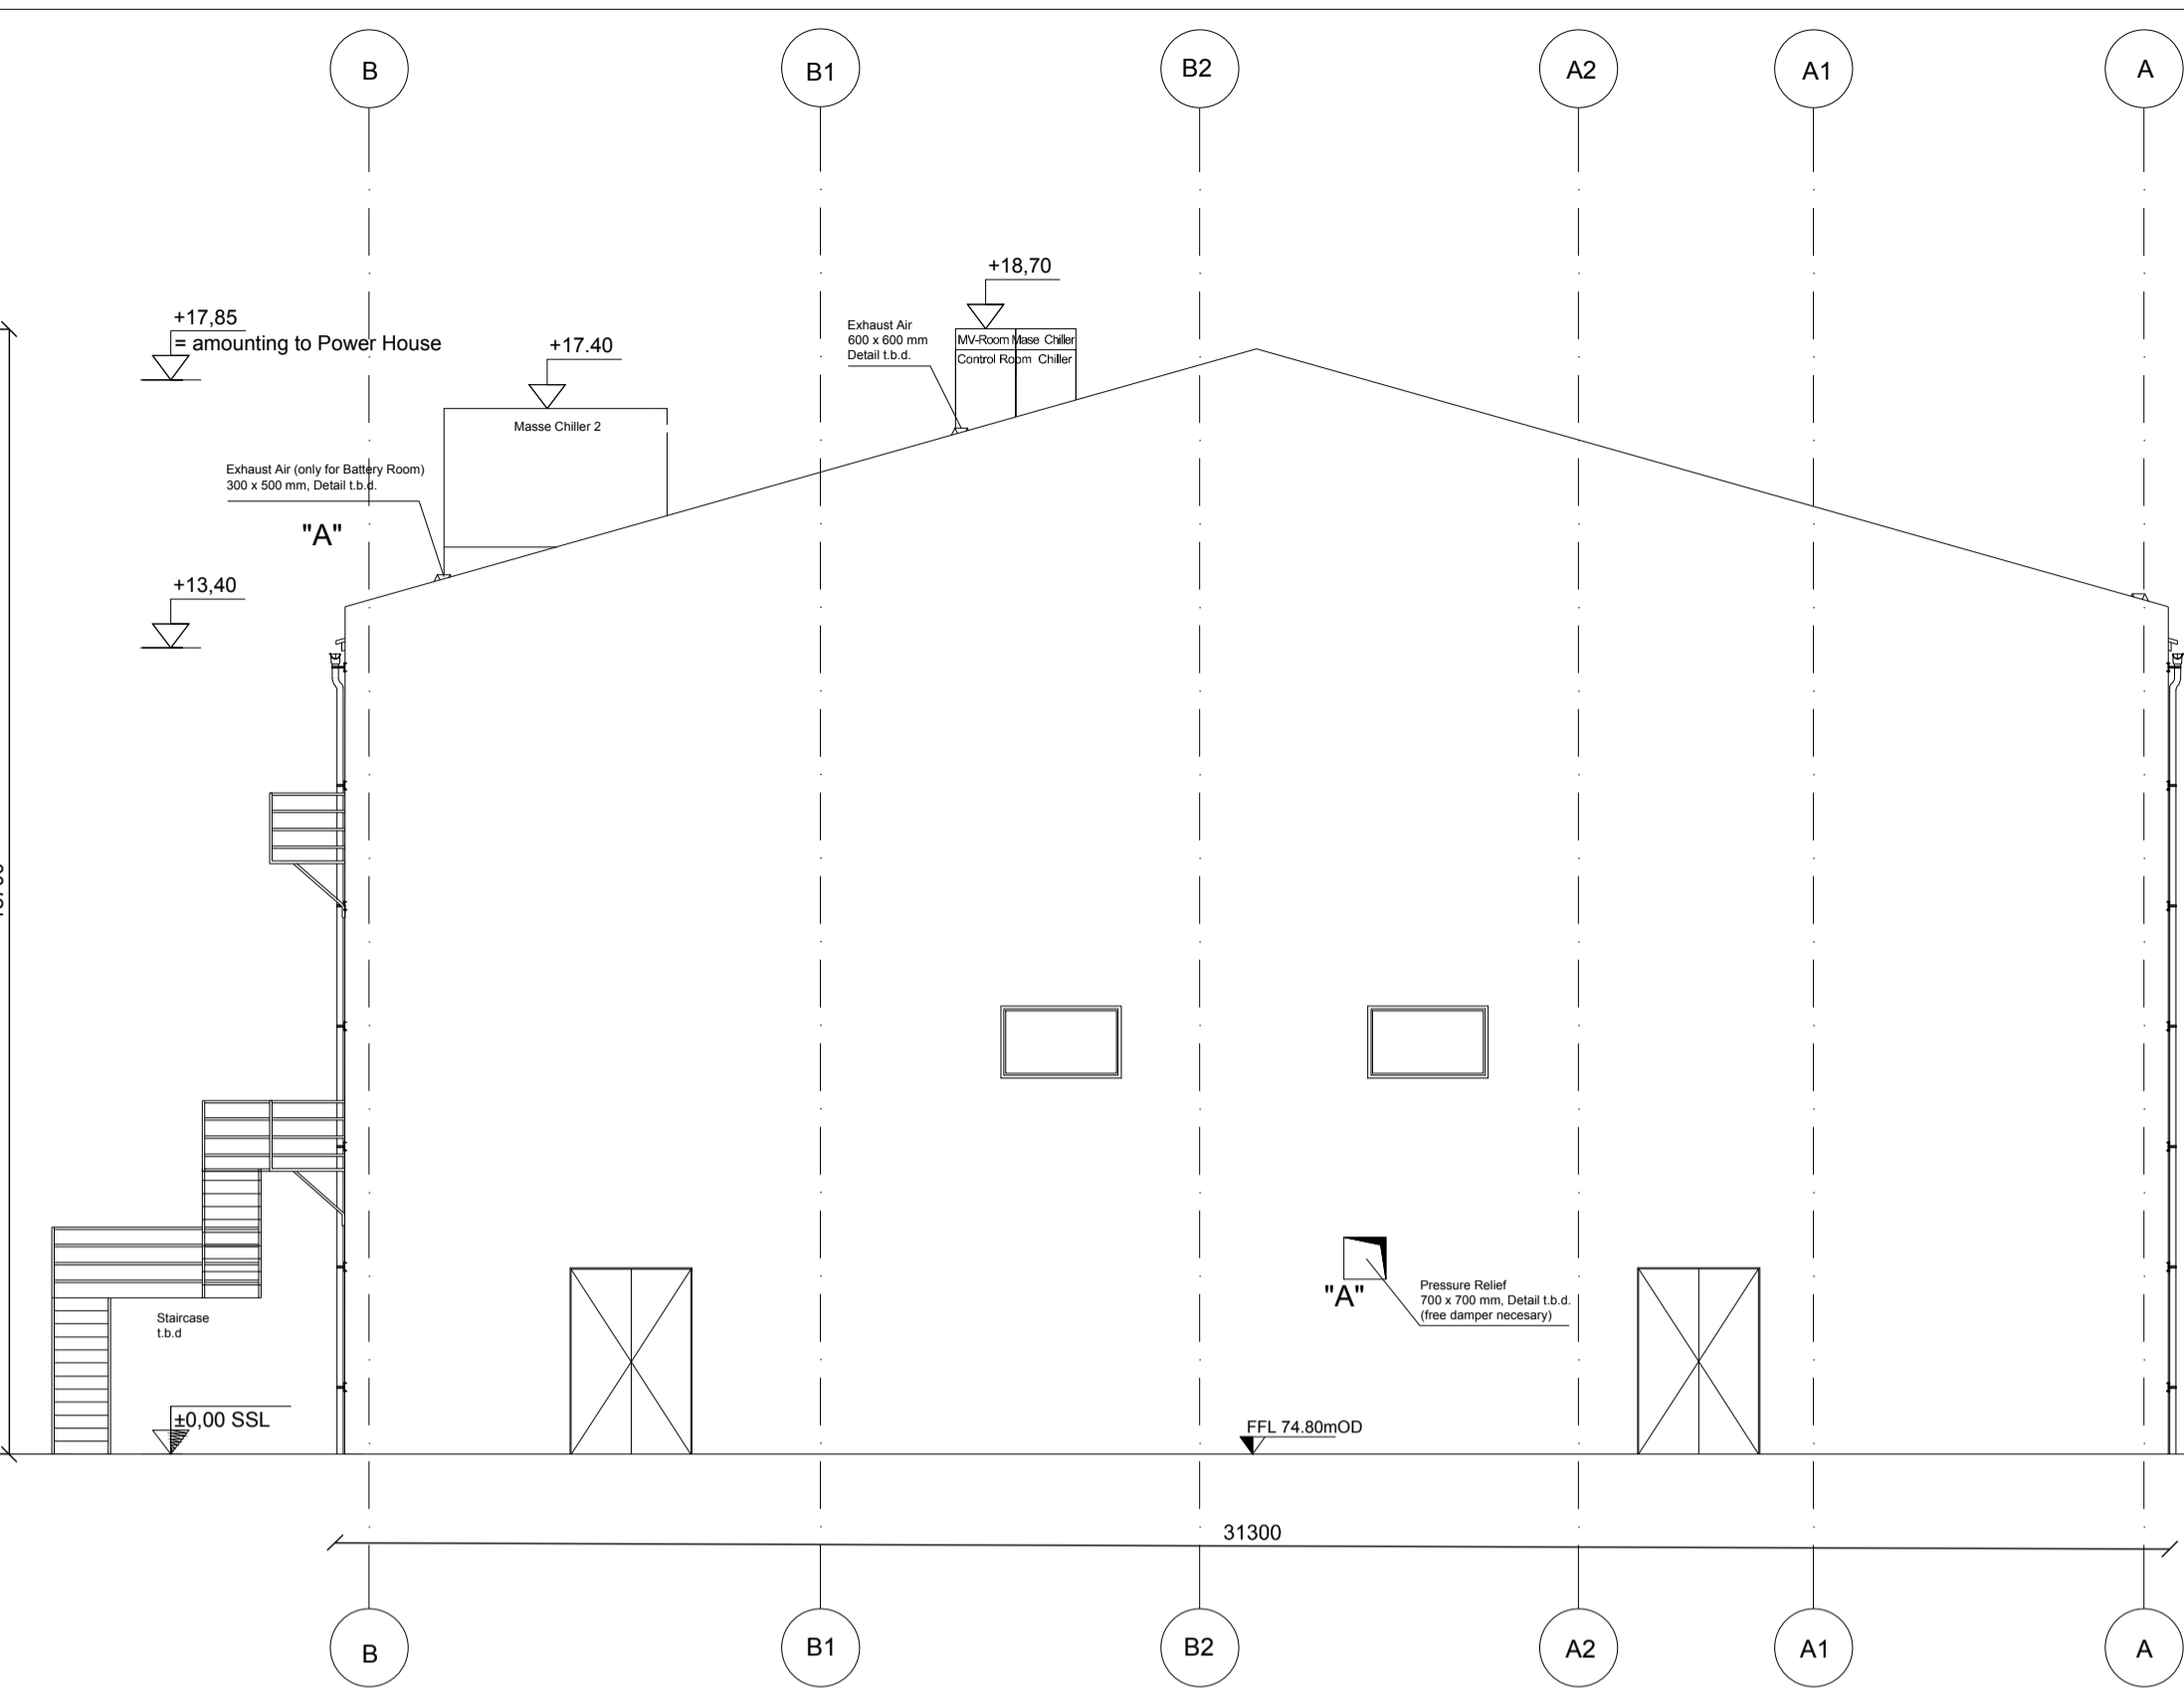


SIDE ELEVATION (Powerhouse Side)
Scale 1:125

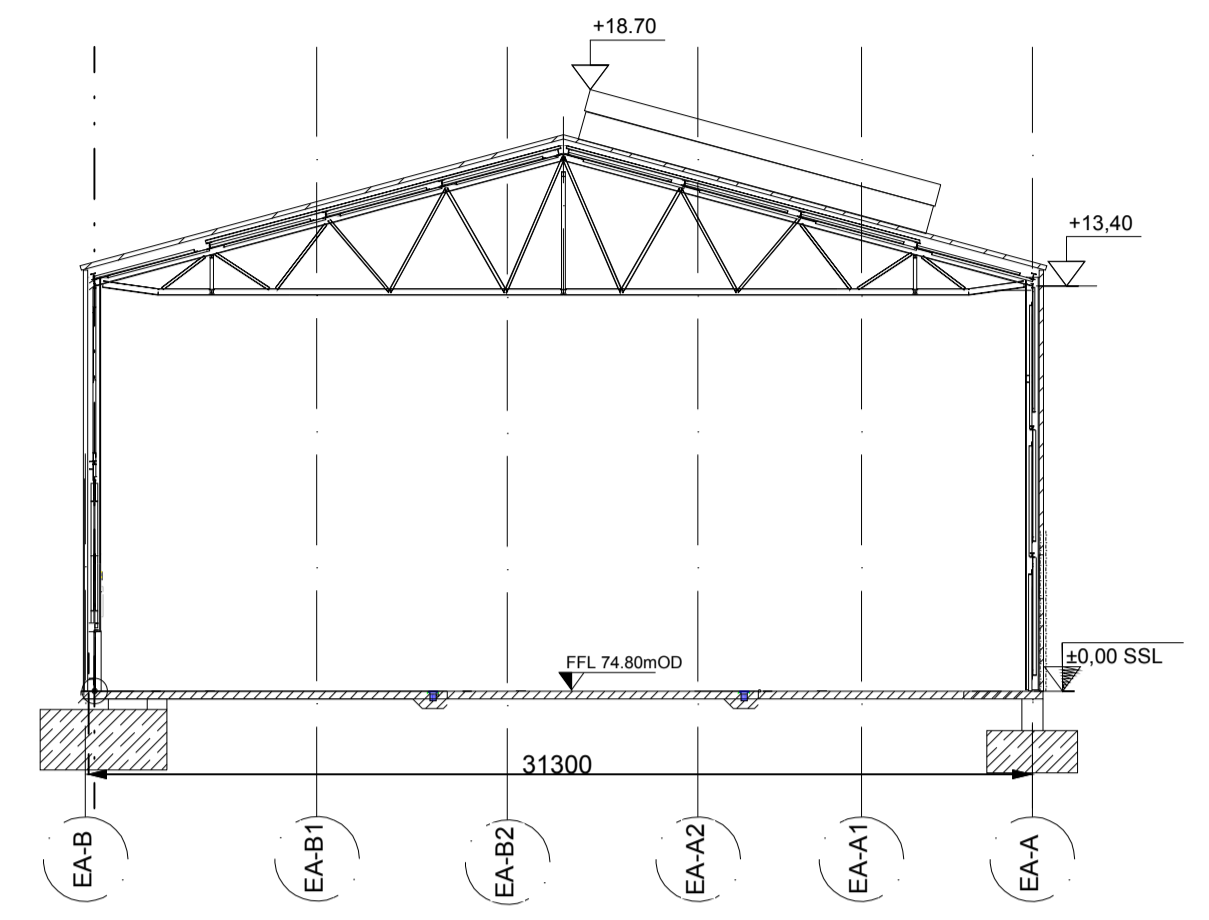


SECTION 1-1
Scale 1:250

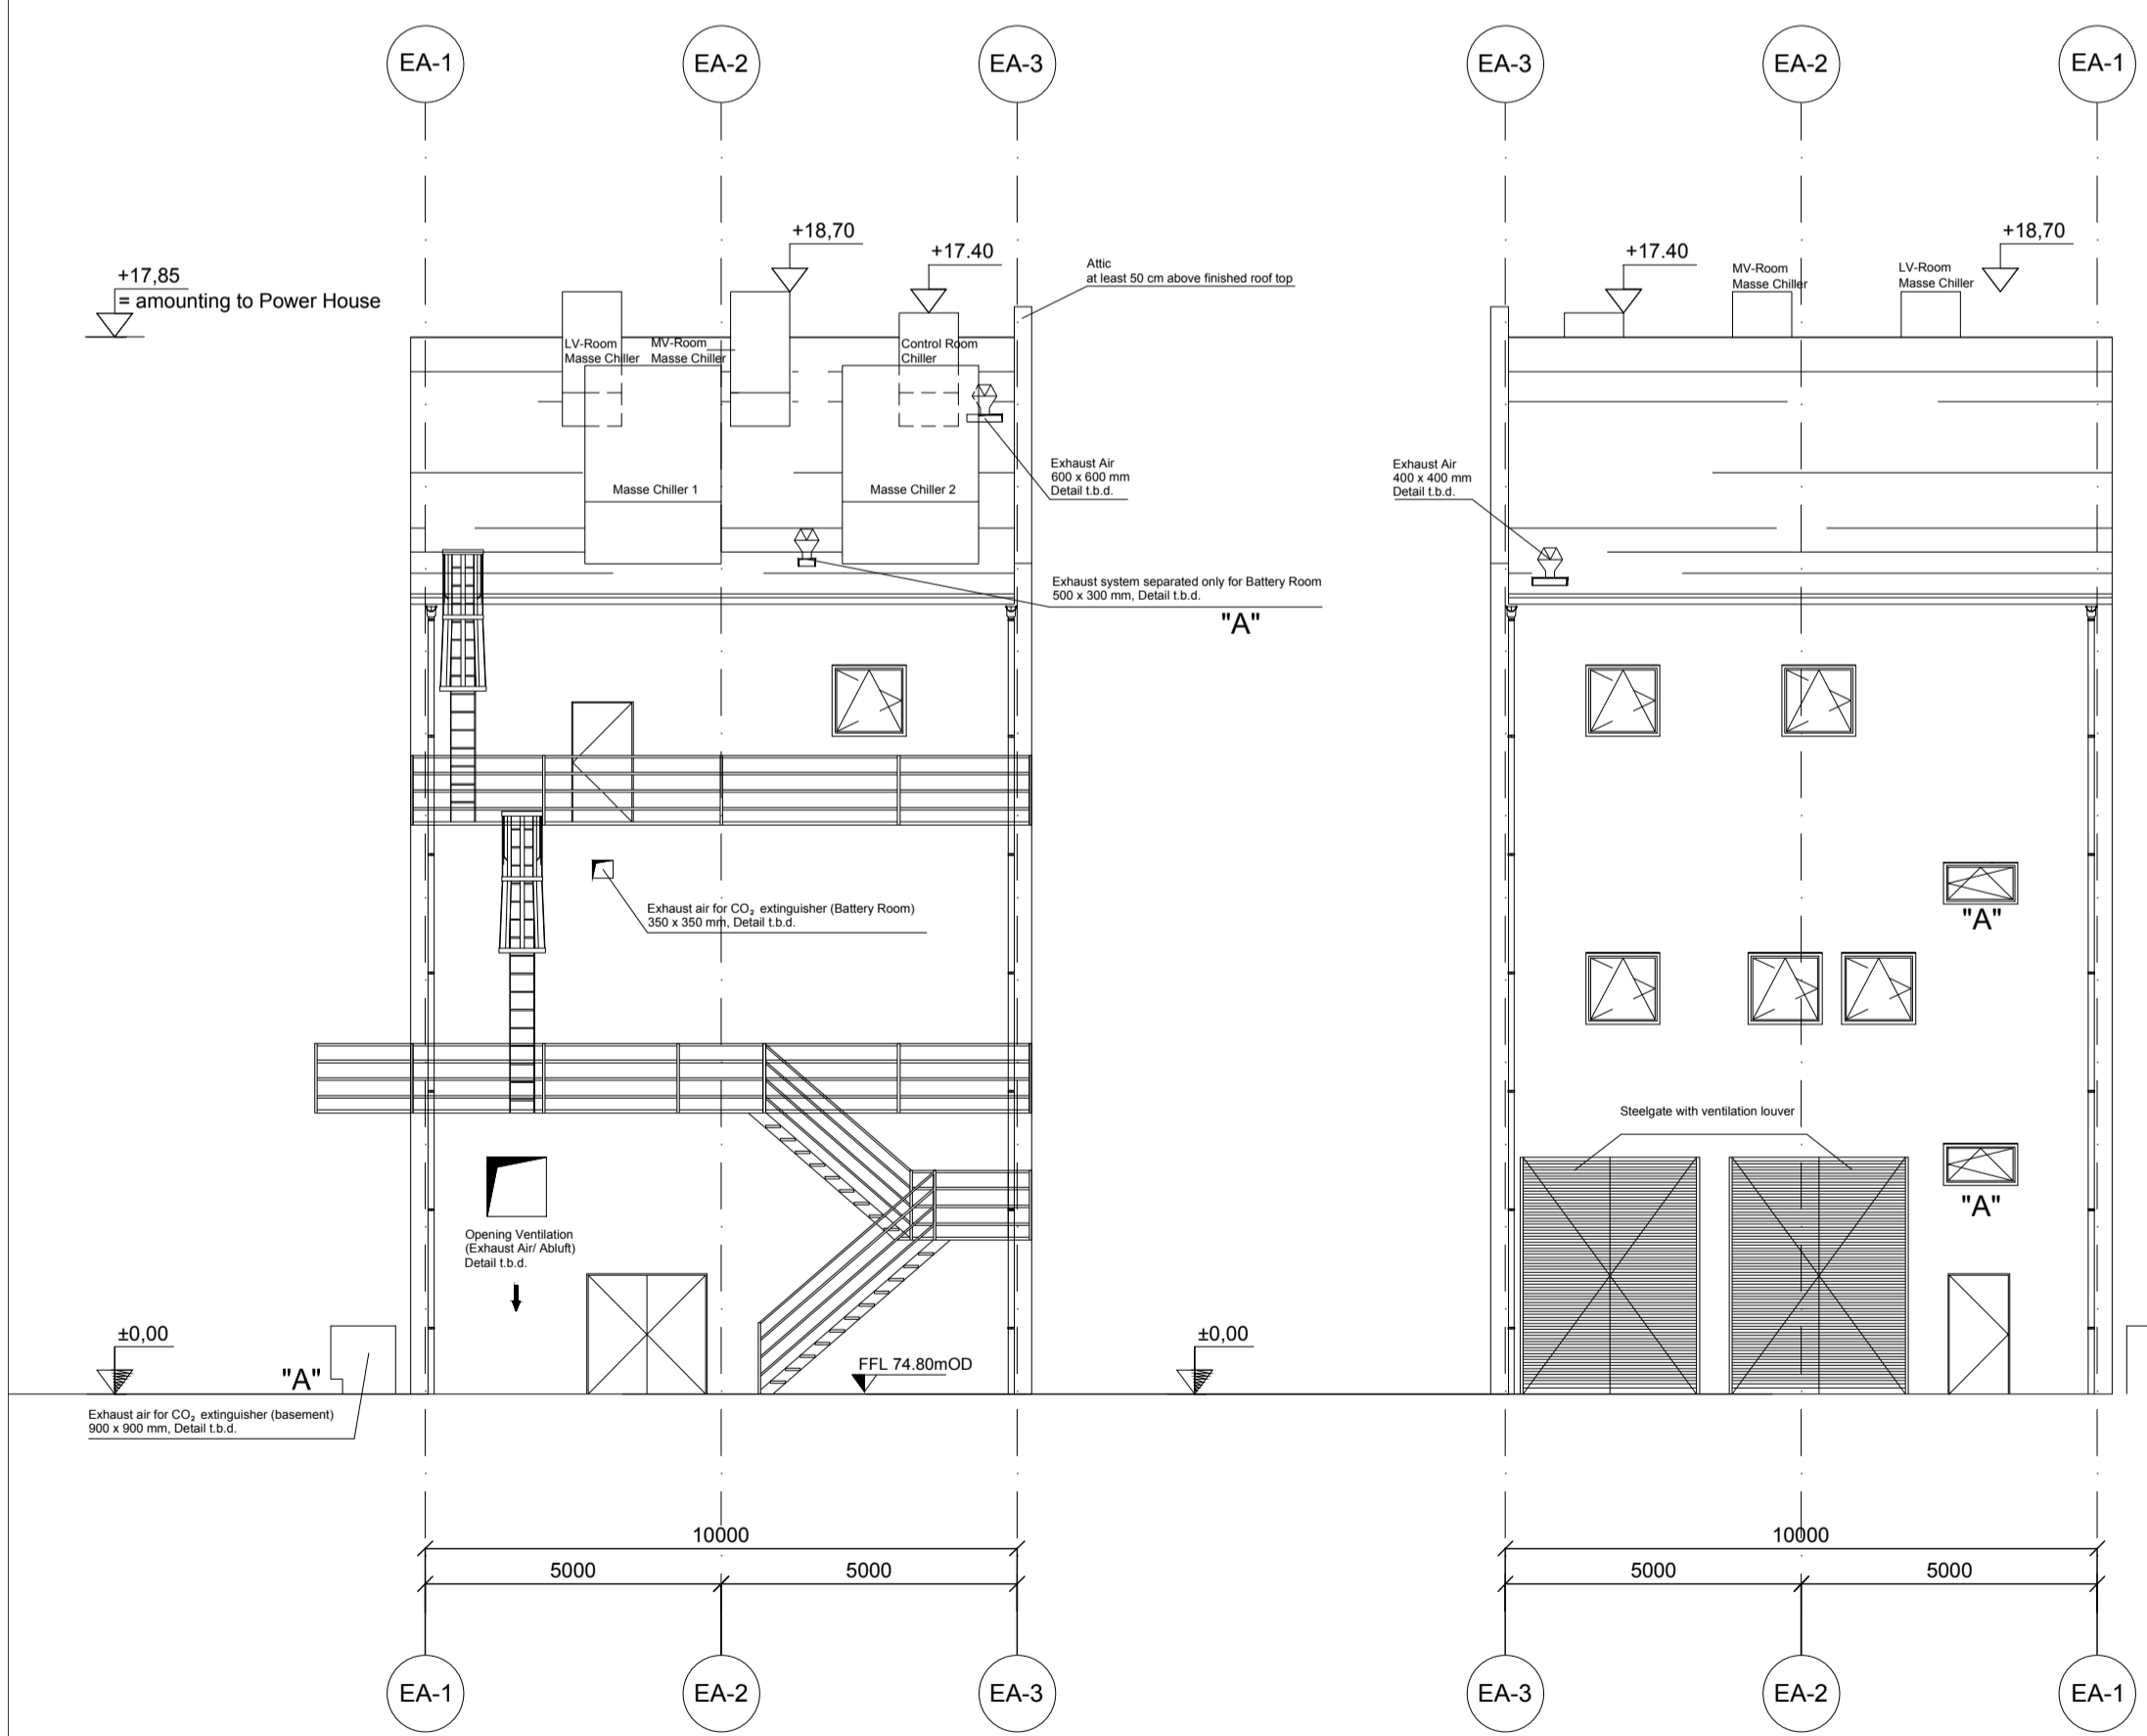


REAR ELEVATION
Scale 1:125

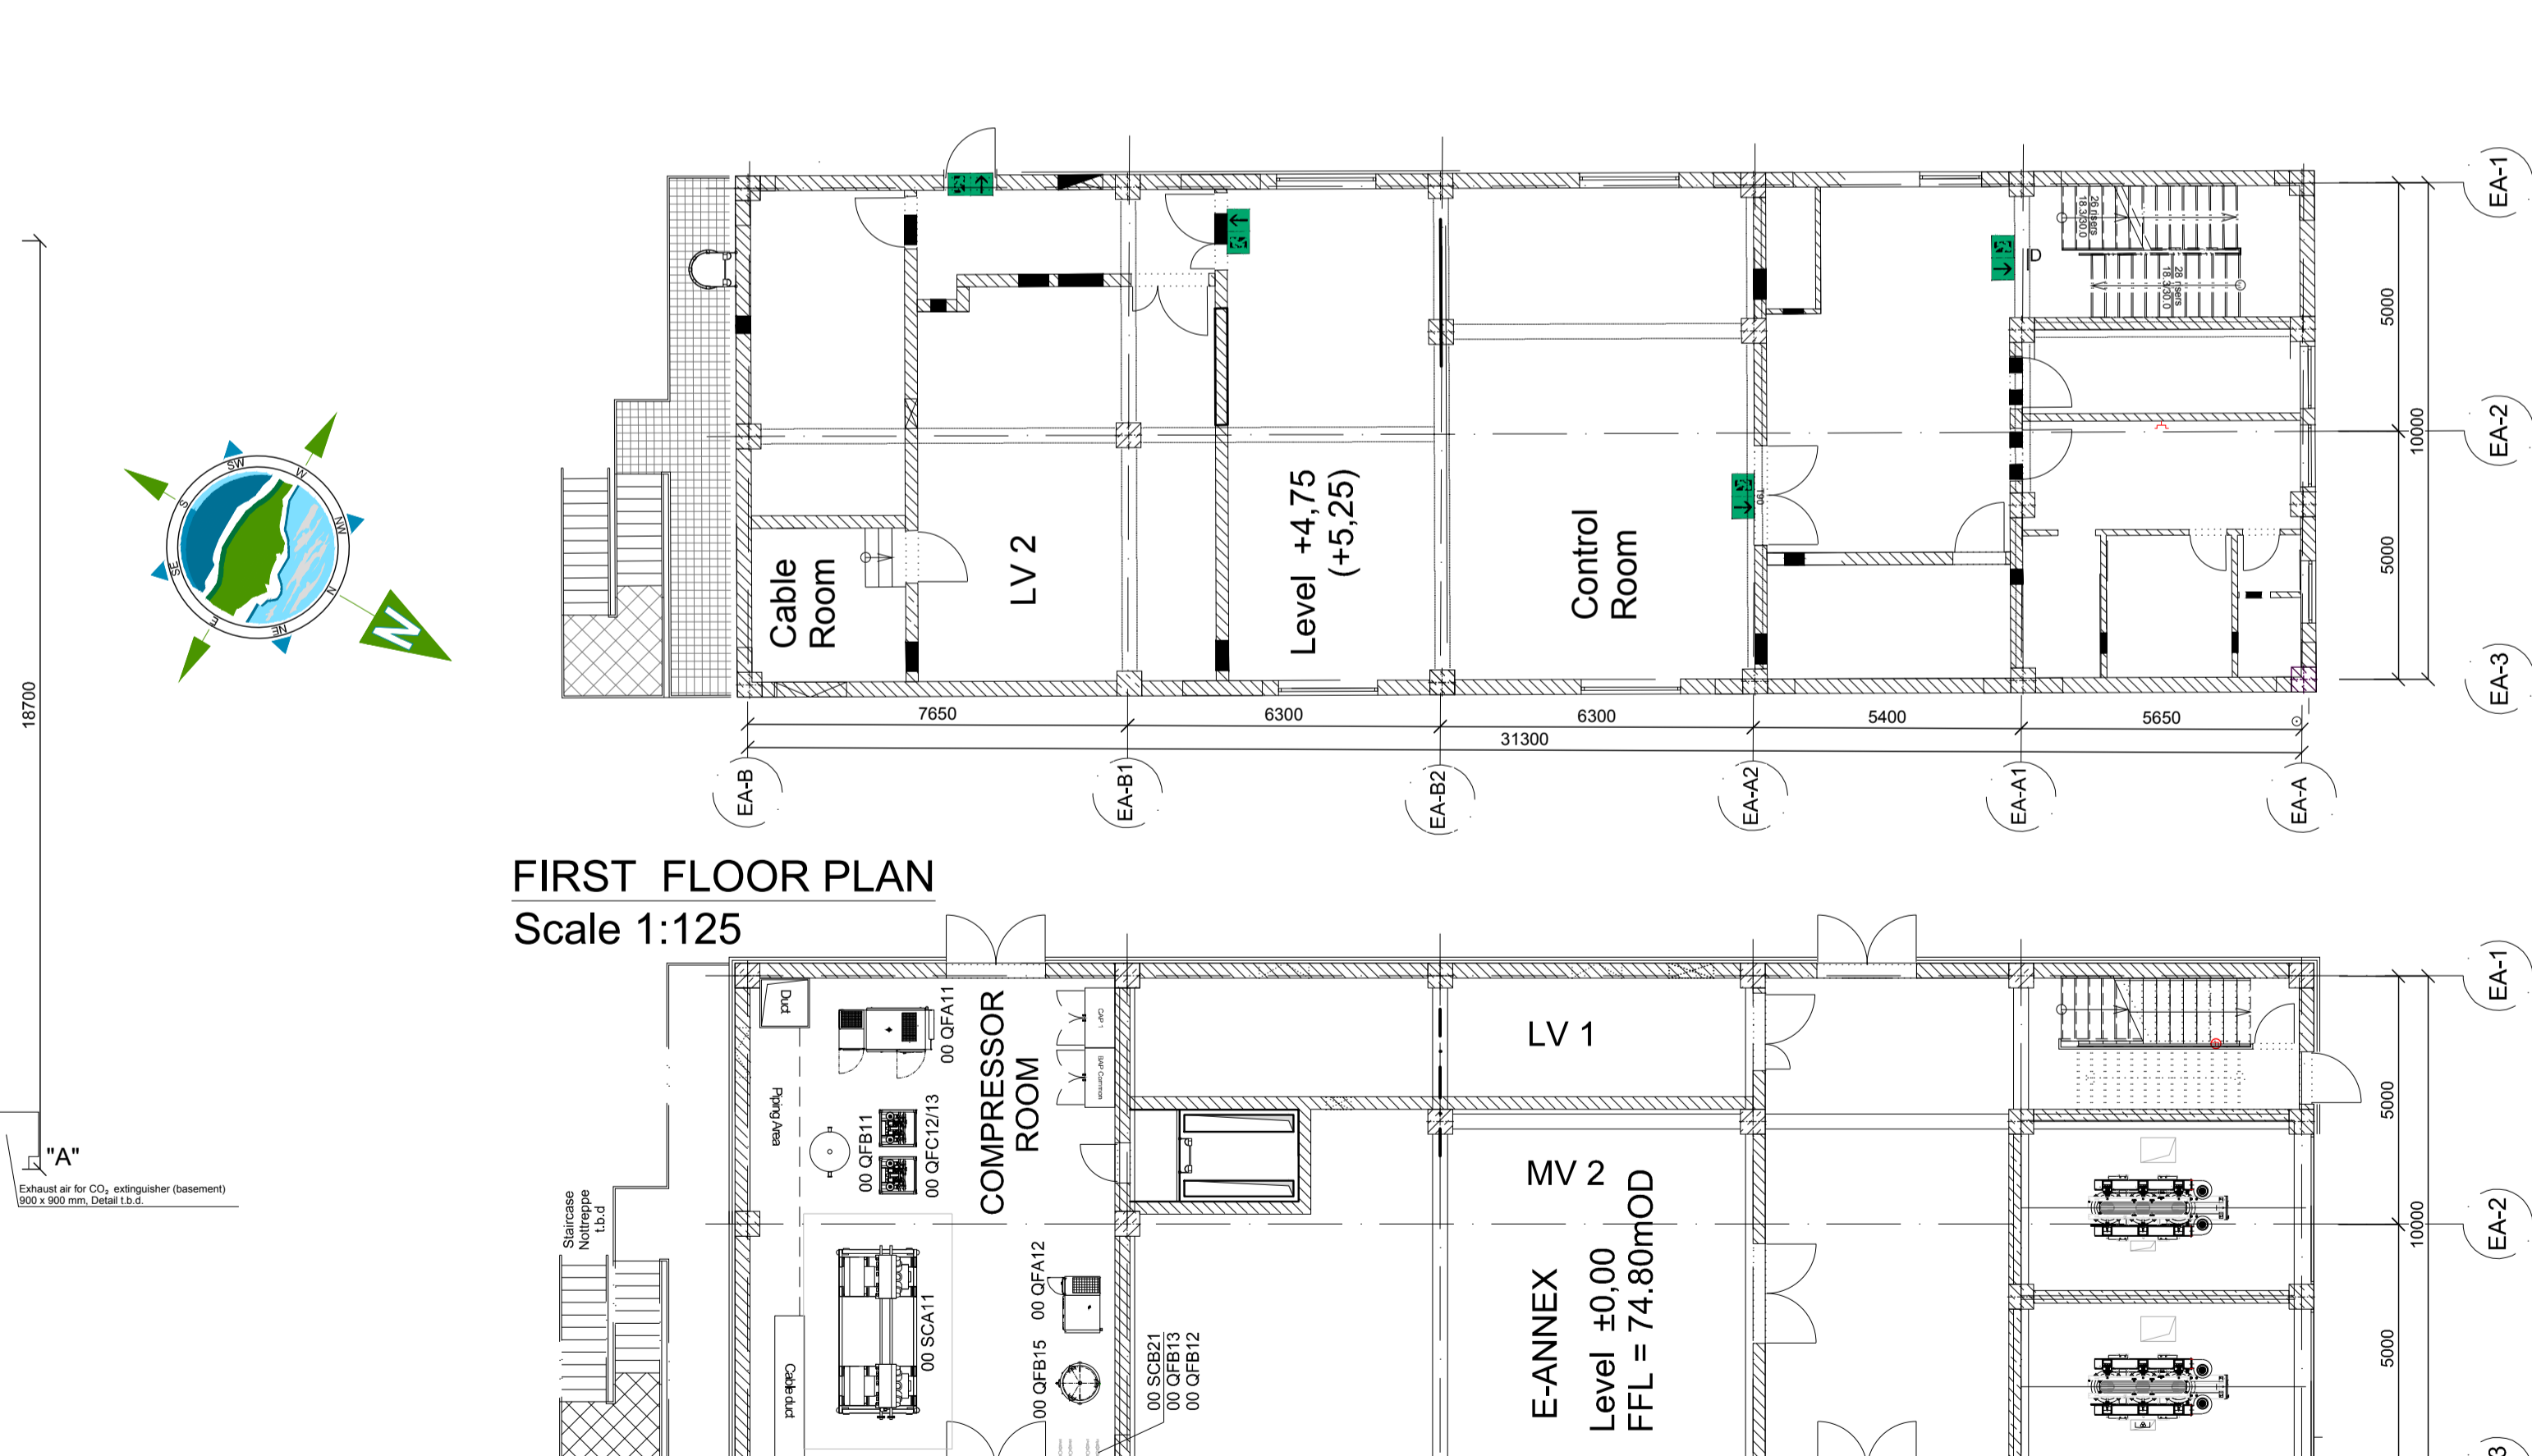


FRONT ELEVATION
Scale 1:125

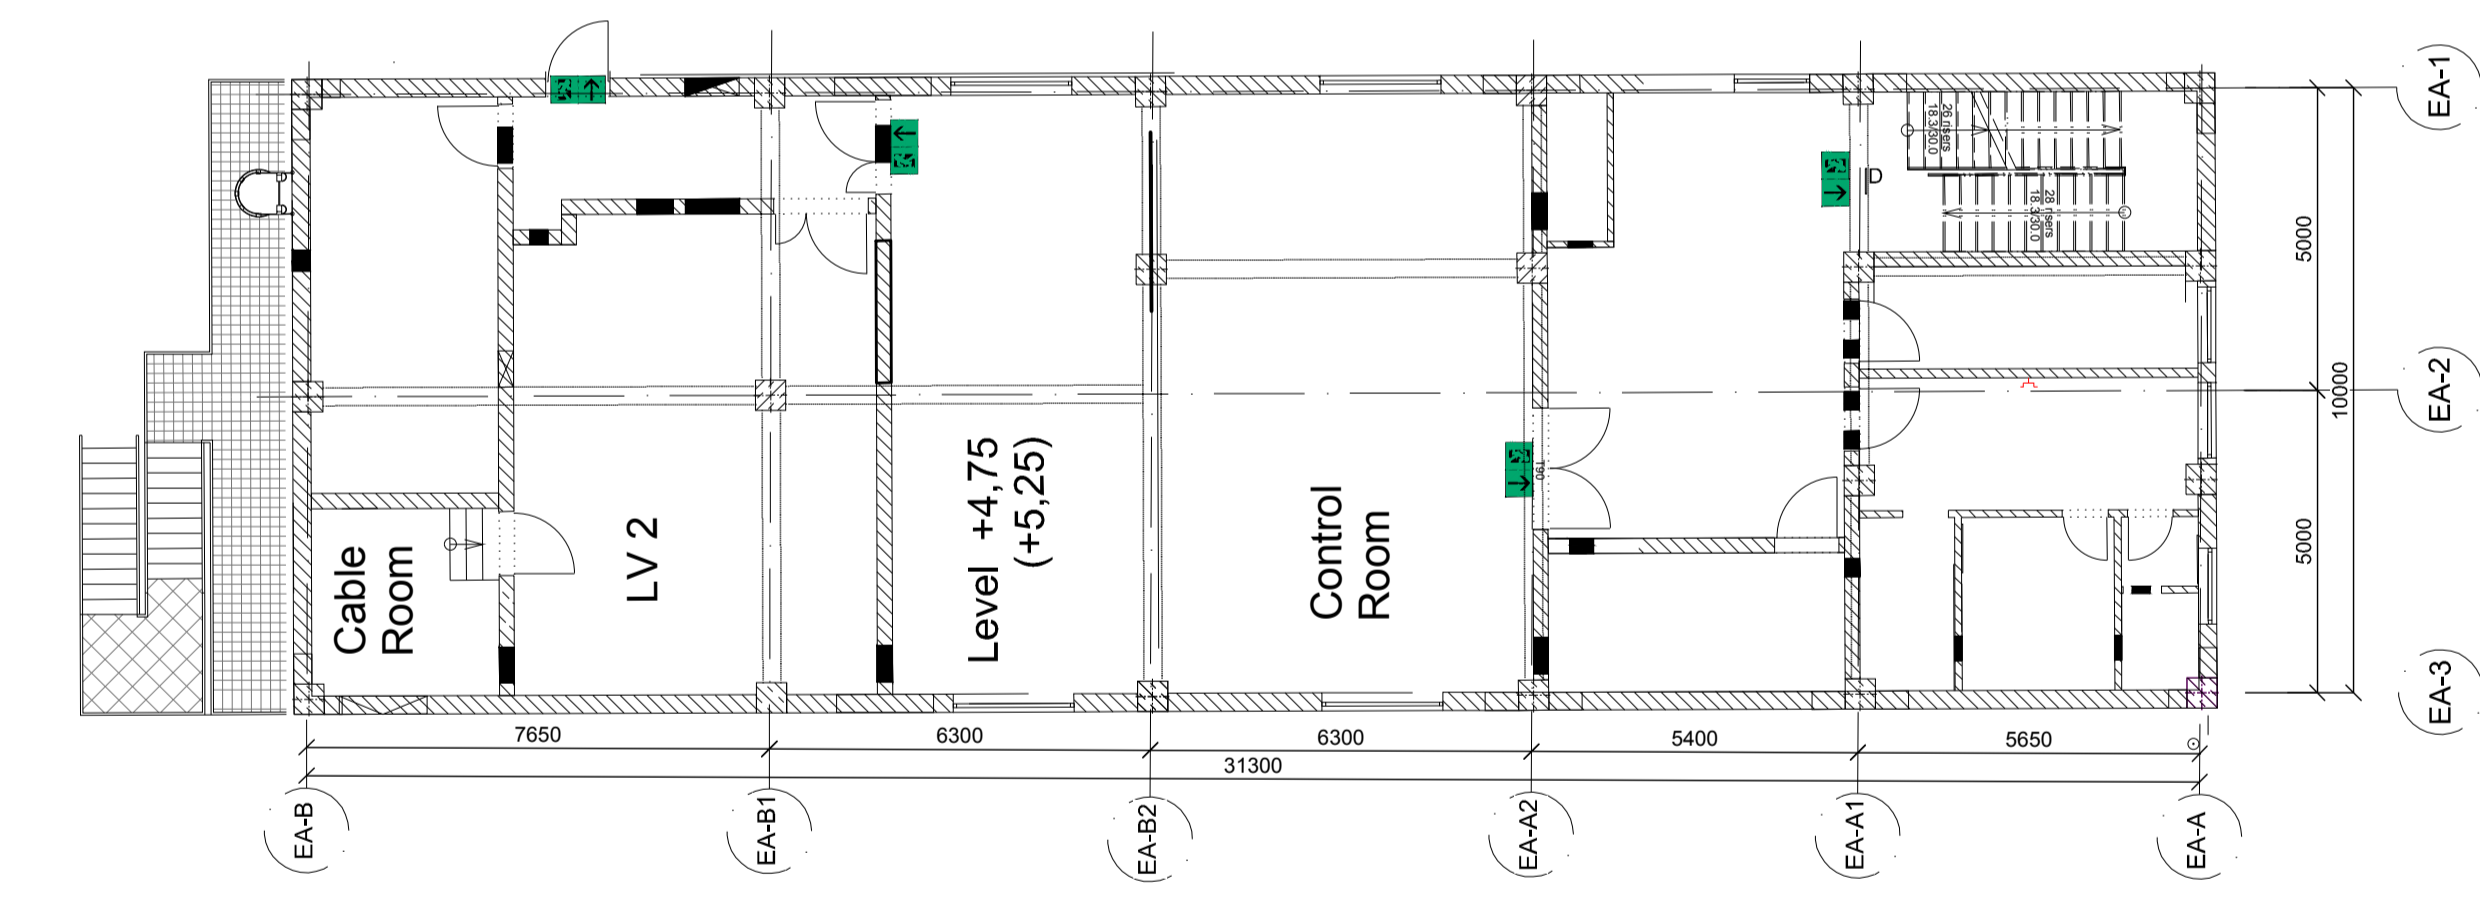

FIRST FLOOR PLAN
Scale 1:125

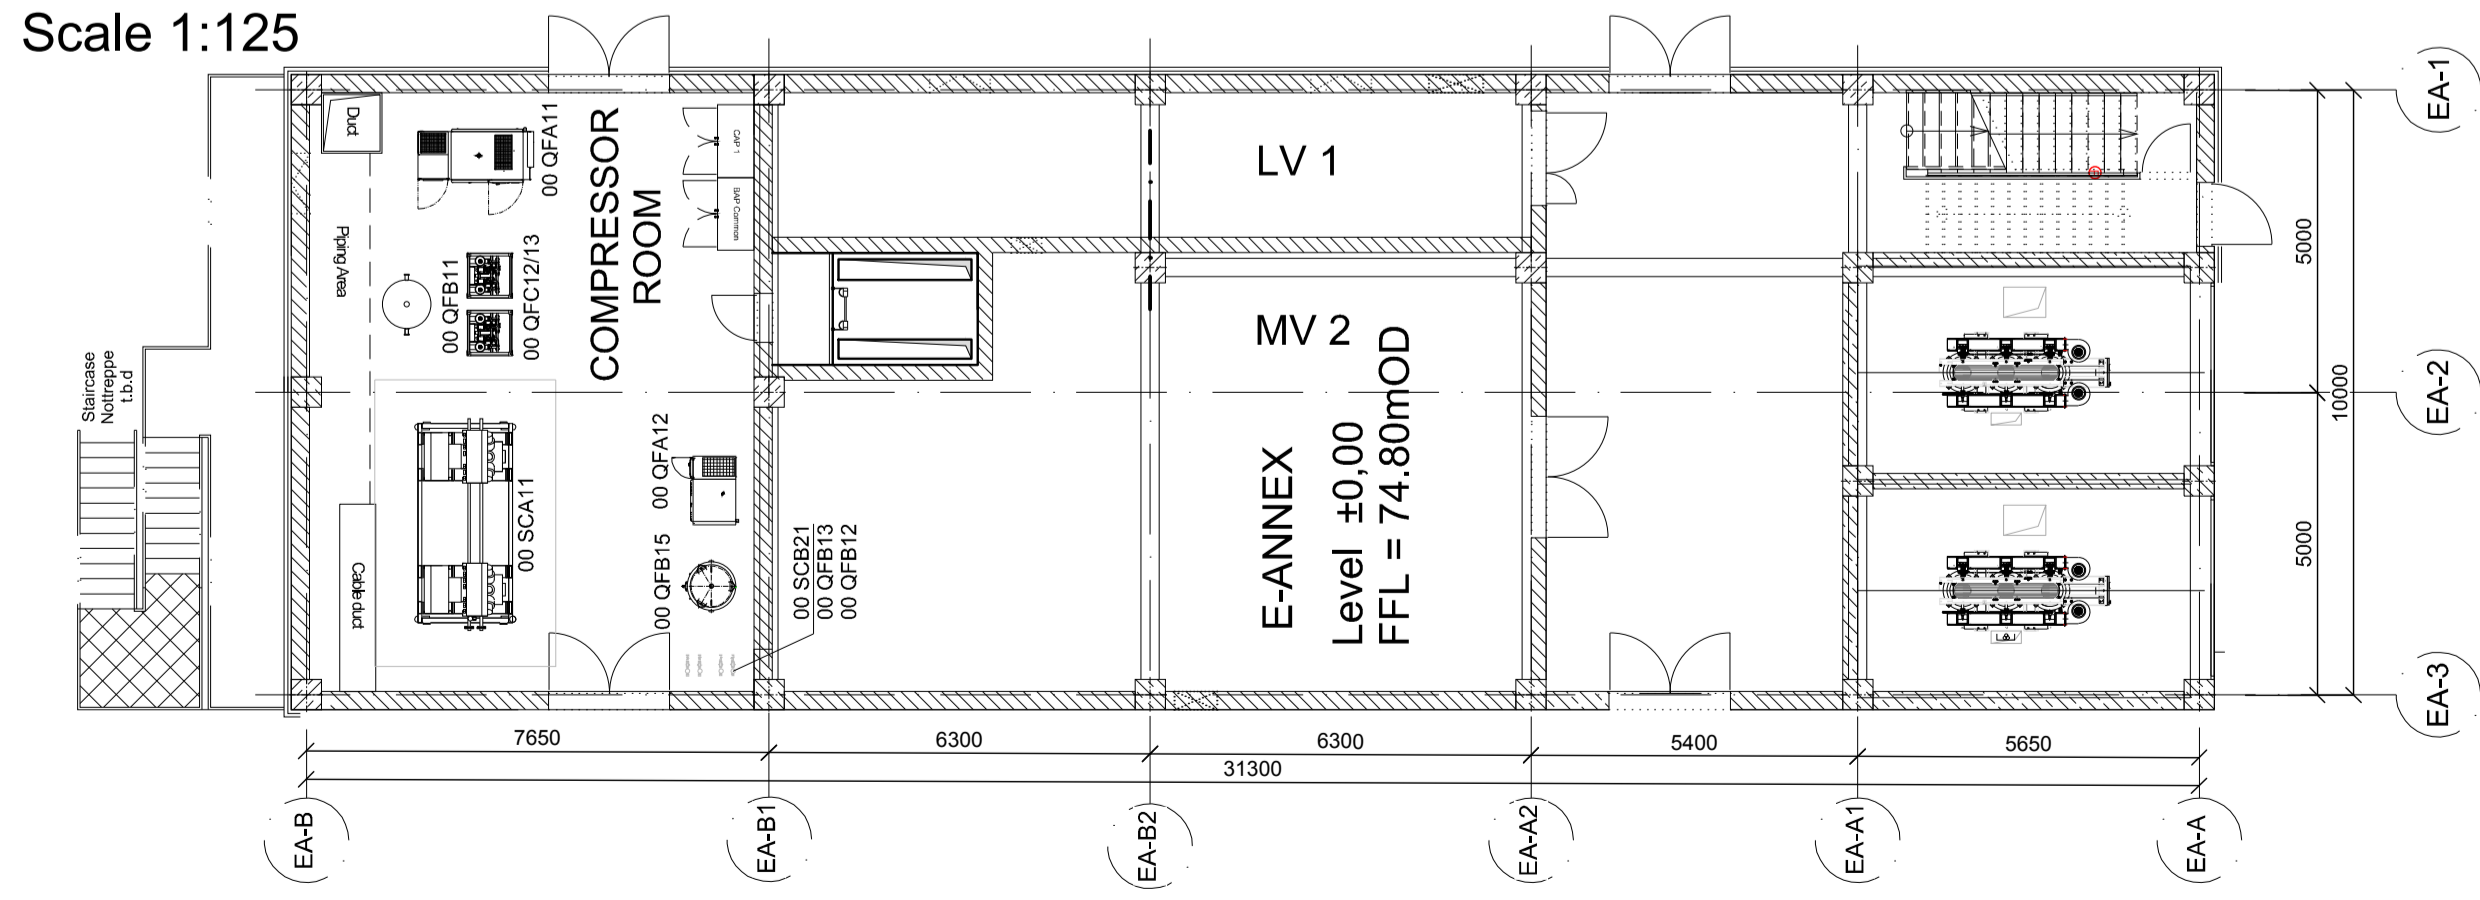

GROUND FLOOR PLAN
Scale 1:125

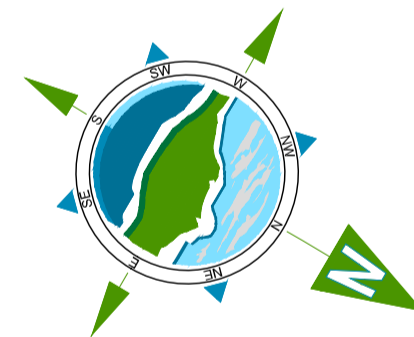

As agreed with South Dublin County Council in the pre-application consultation meeting the final finishes, including cladding materials and colour codes, will be agreed with the Council post planning through planning condition. Greener Ideas Limited will ensure only Council approved finishes are applied on site.



Rev	Date	Description	By	Chkd.
A	18.06.21	PLANNING ISSUE	MN	MMcC



Client: **Greener Ideas**
Project: **PROFILE PARK POWER PLANT**

Title: **ELECTRICAL ANNEX PLAN, ELEVATIONS & SECTION**

Scale @ A1: **As Shown**
Prepared by: **M. Nolan** Checked: **M. McCarthy** Date: **June 2021**
Project Director: **S. Tinnelly**
Drawing Status: **Planning**

TOBIN
CONSULTING ENGINEERS
Block 10-4, Blanchardstown Corporate Park,
Dublin 15, Ireland.
tel: +353-(0)1-8030406
fax: +353-(0)1-8030409
e-mail: dublin@tobin.ie
www.tobin.ie

TOBIN Consulting Engineers will not be liable for any use of this document for any purpose other than that for which it was originally prepared and issued. Except where specifically noted and explicitly agreed in writing by TOBIN Consulting Engineers, no responsibility shall be accepted or assumed by TOBIN Consulting Engineers for any use of this document for any purpose other than that for which it was originally prepared and issued. Drawing No.: **11069-2042** Revision: **A**