




**ELEVATION A**  
Scale 1:200

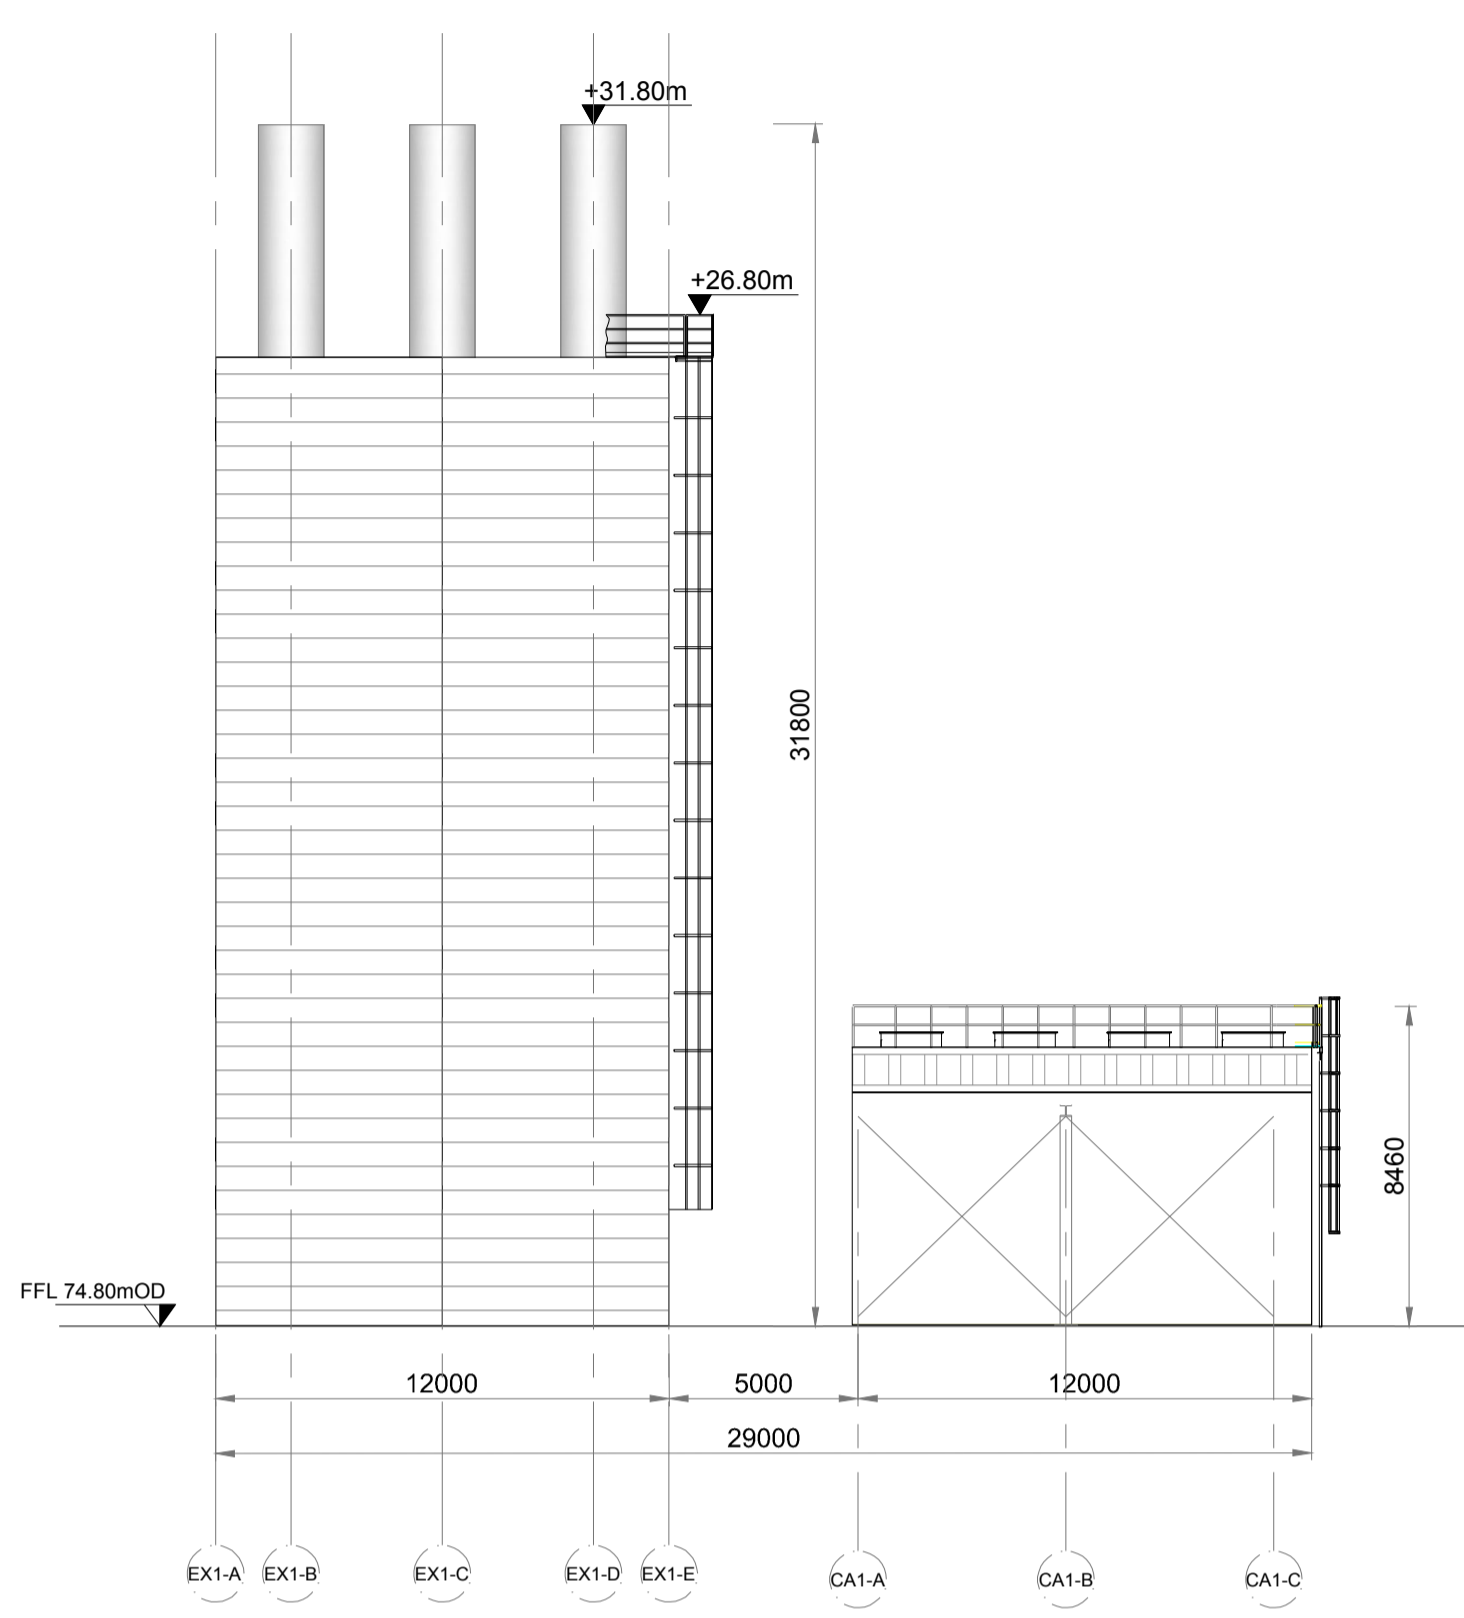


**ELEVATION B**  
Scale 1:200

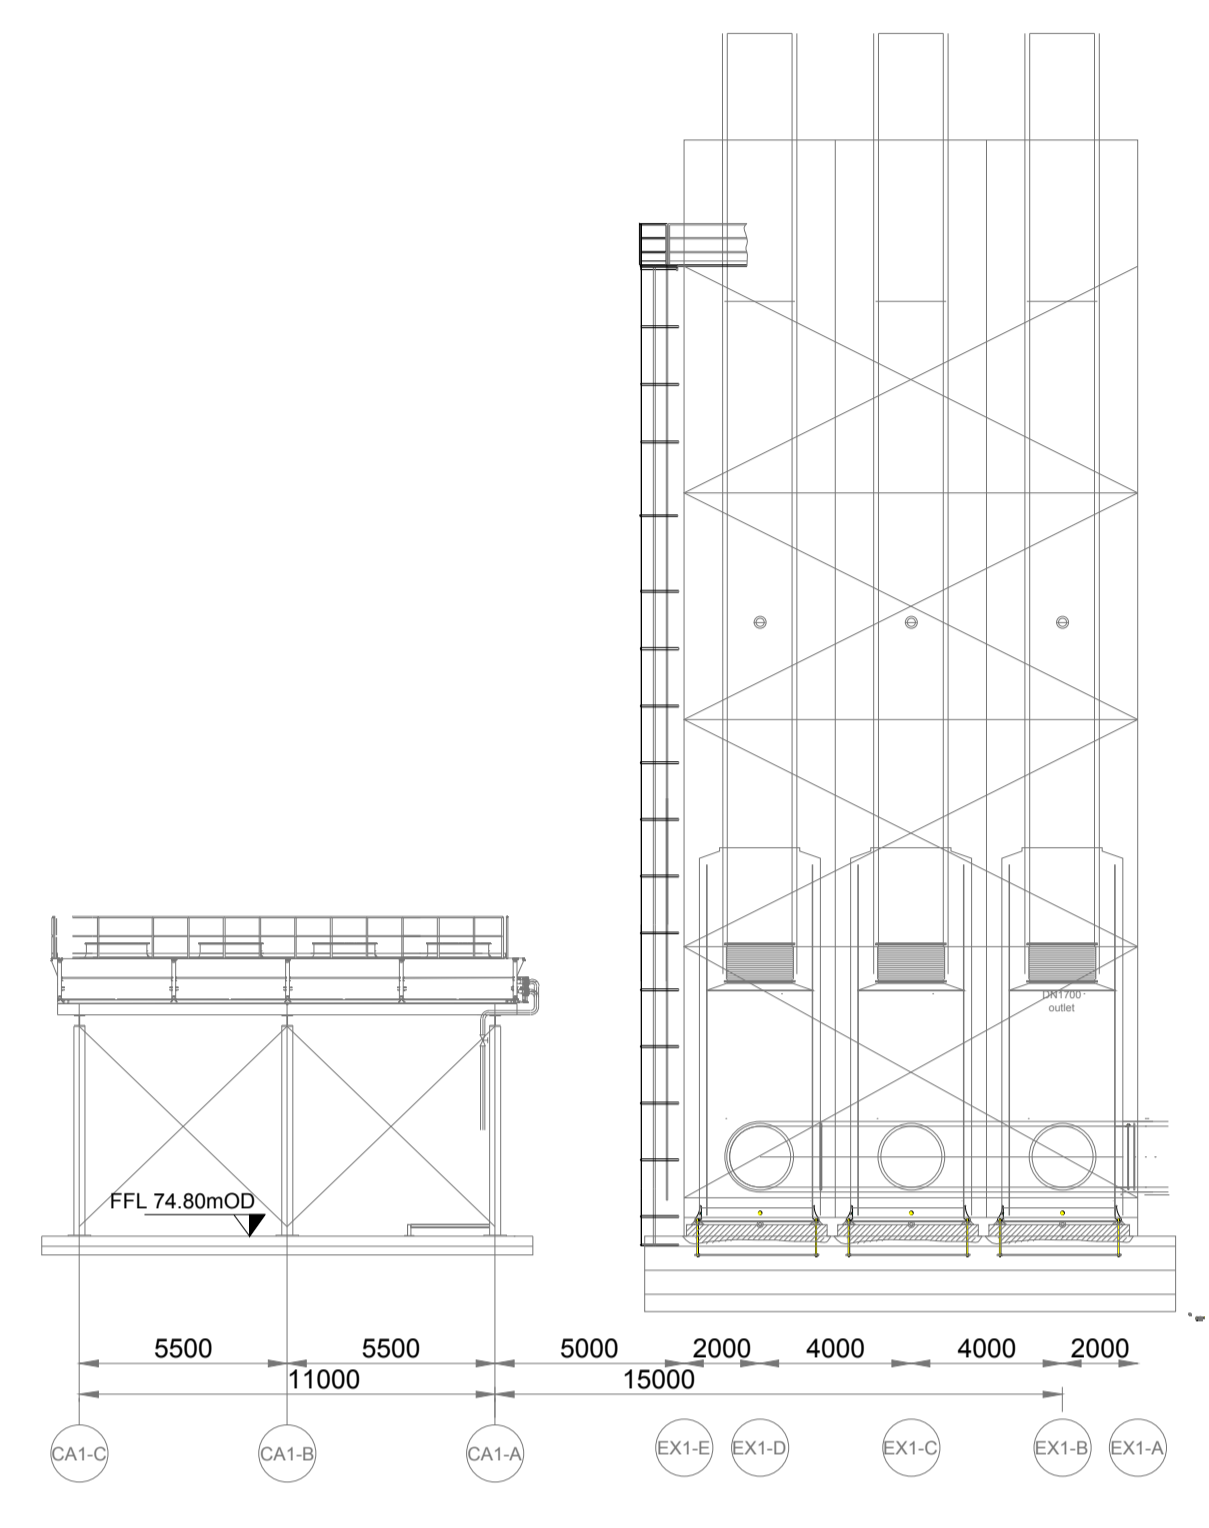


**SECTION 1-1**  
Scale 1:200

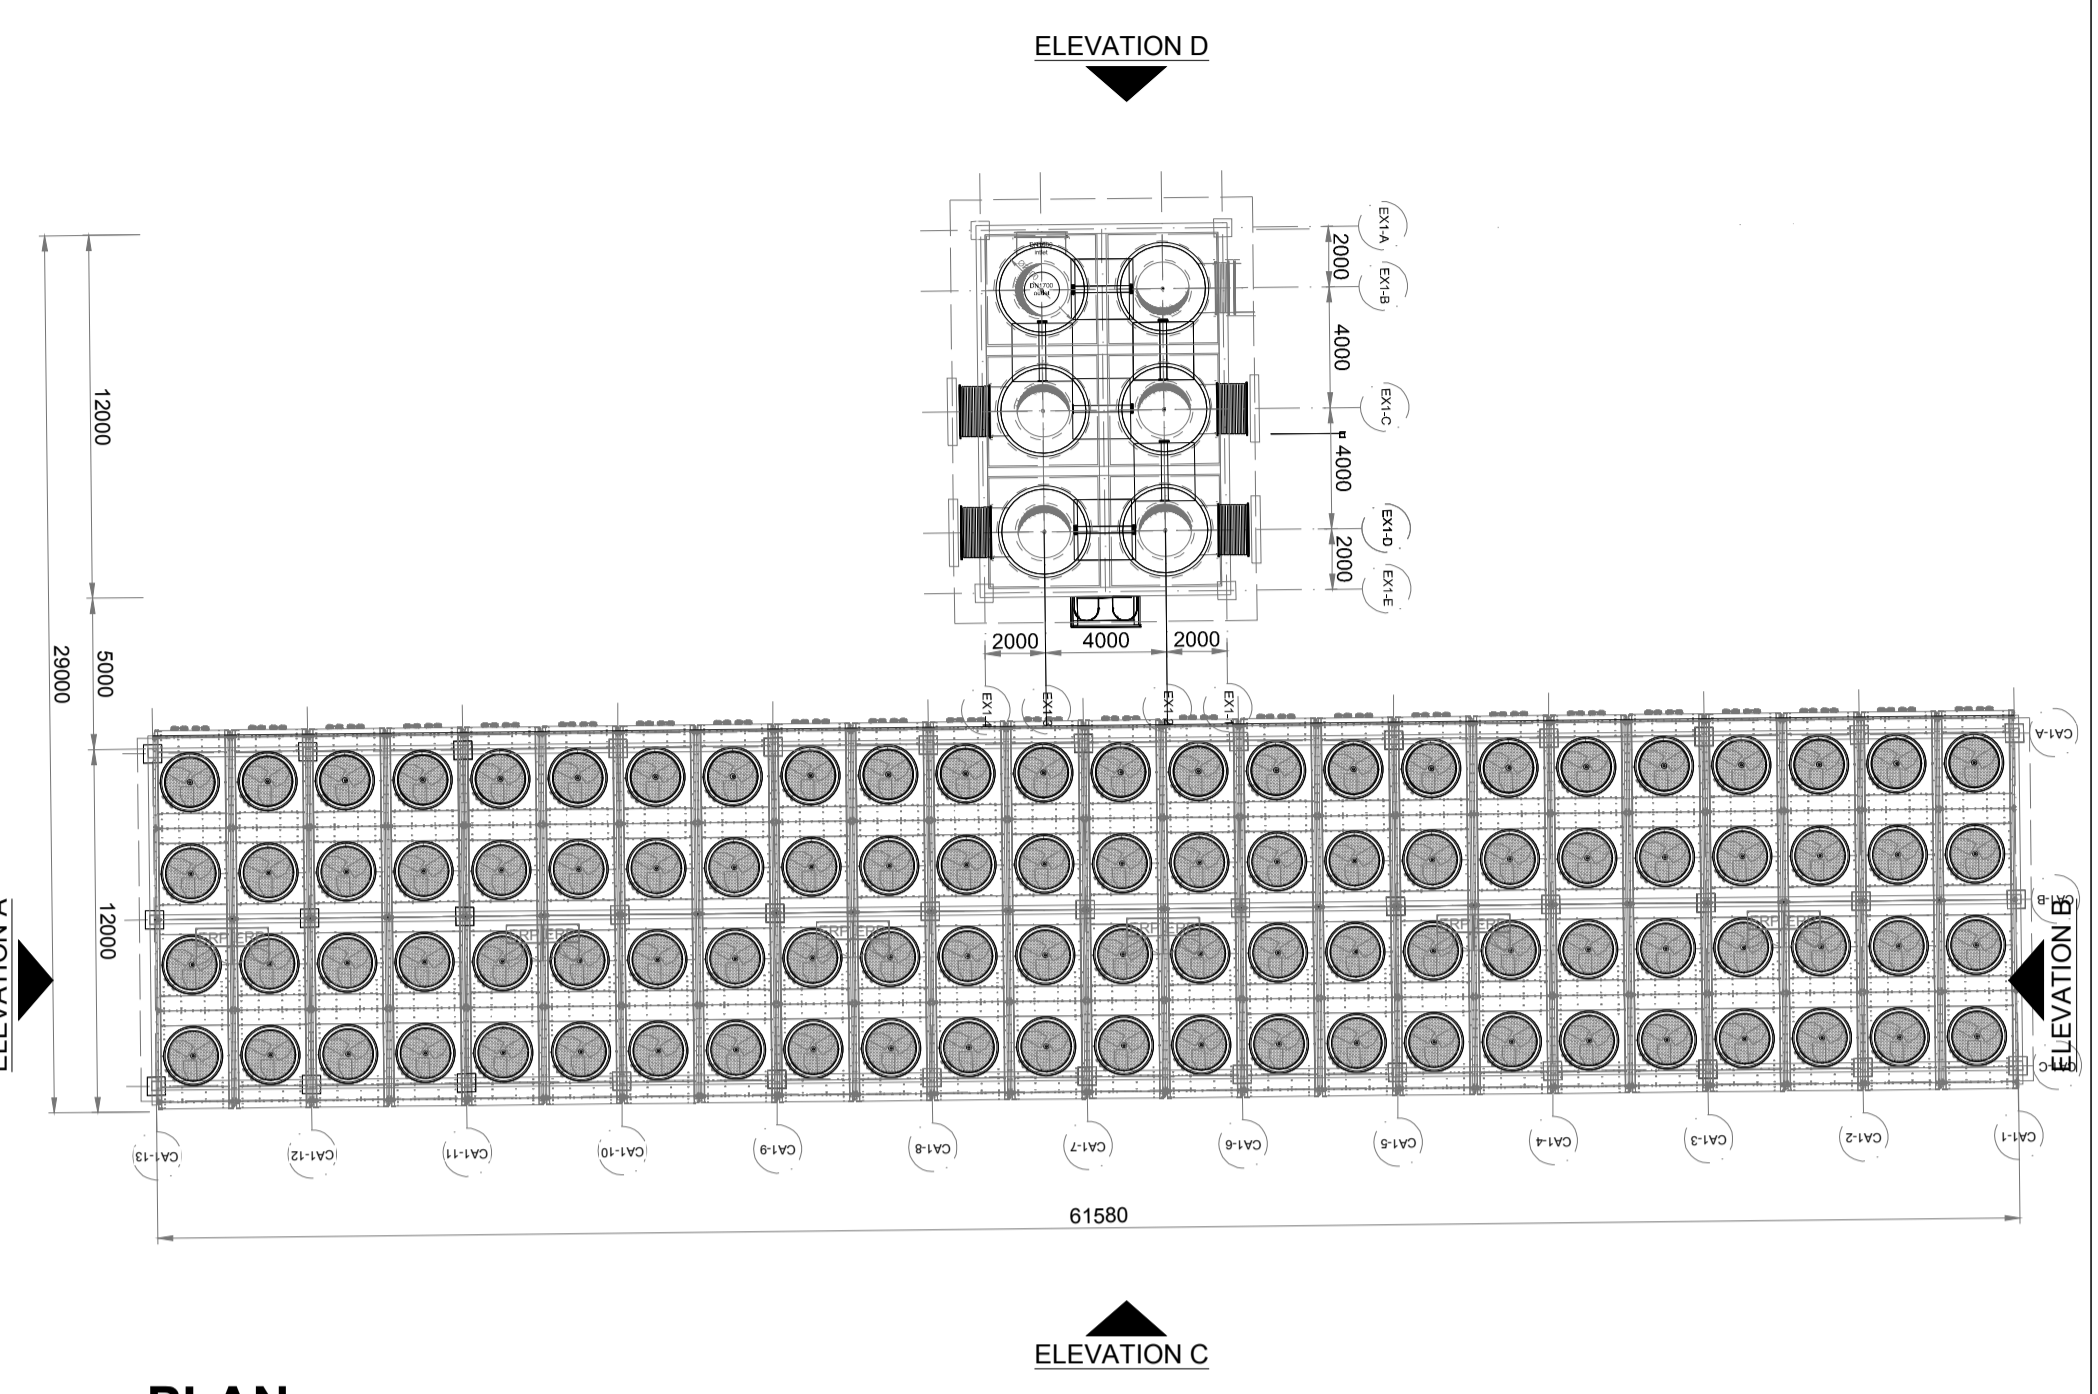

**PLAN**  
Scale 1:250

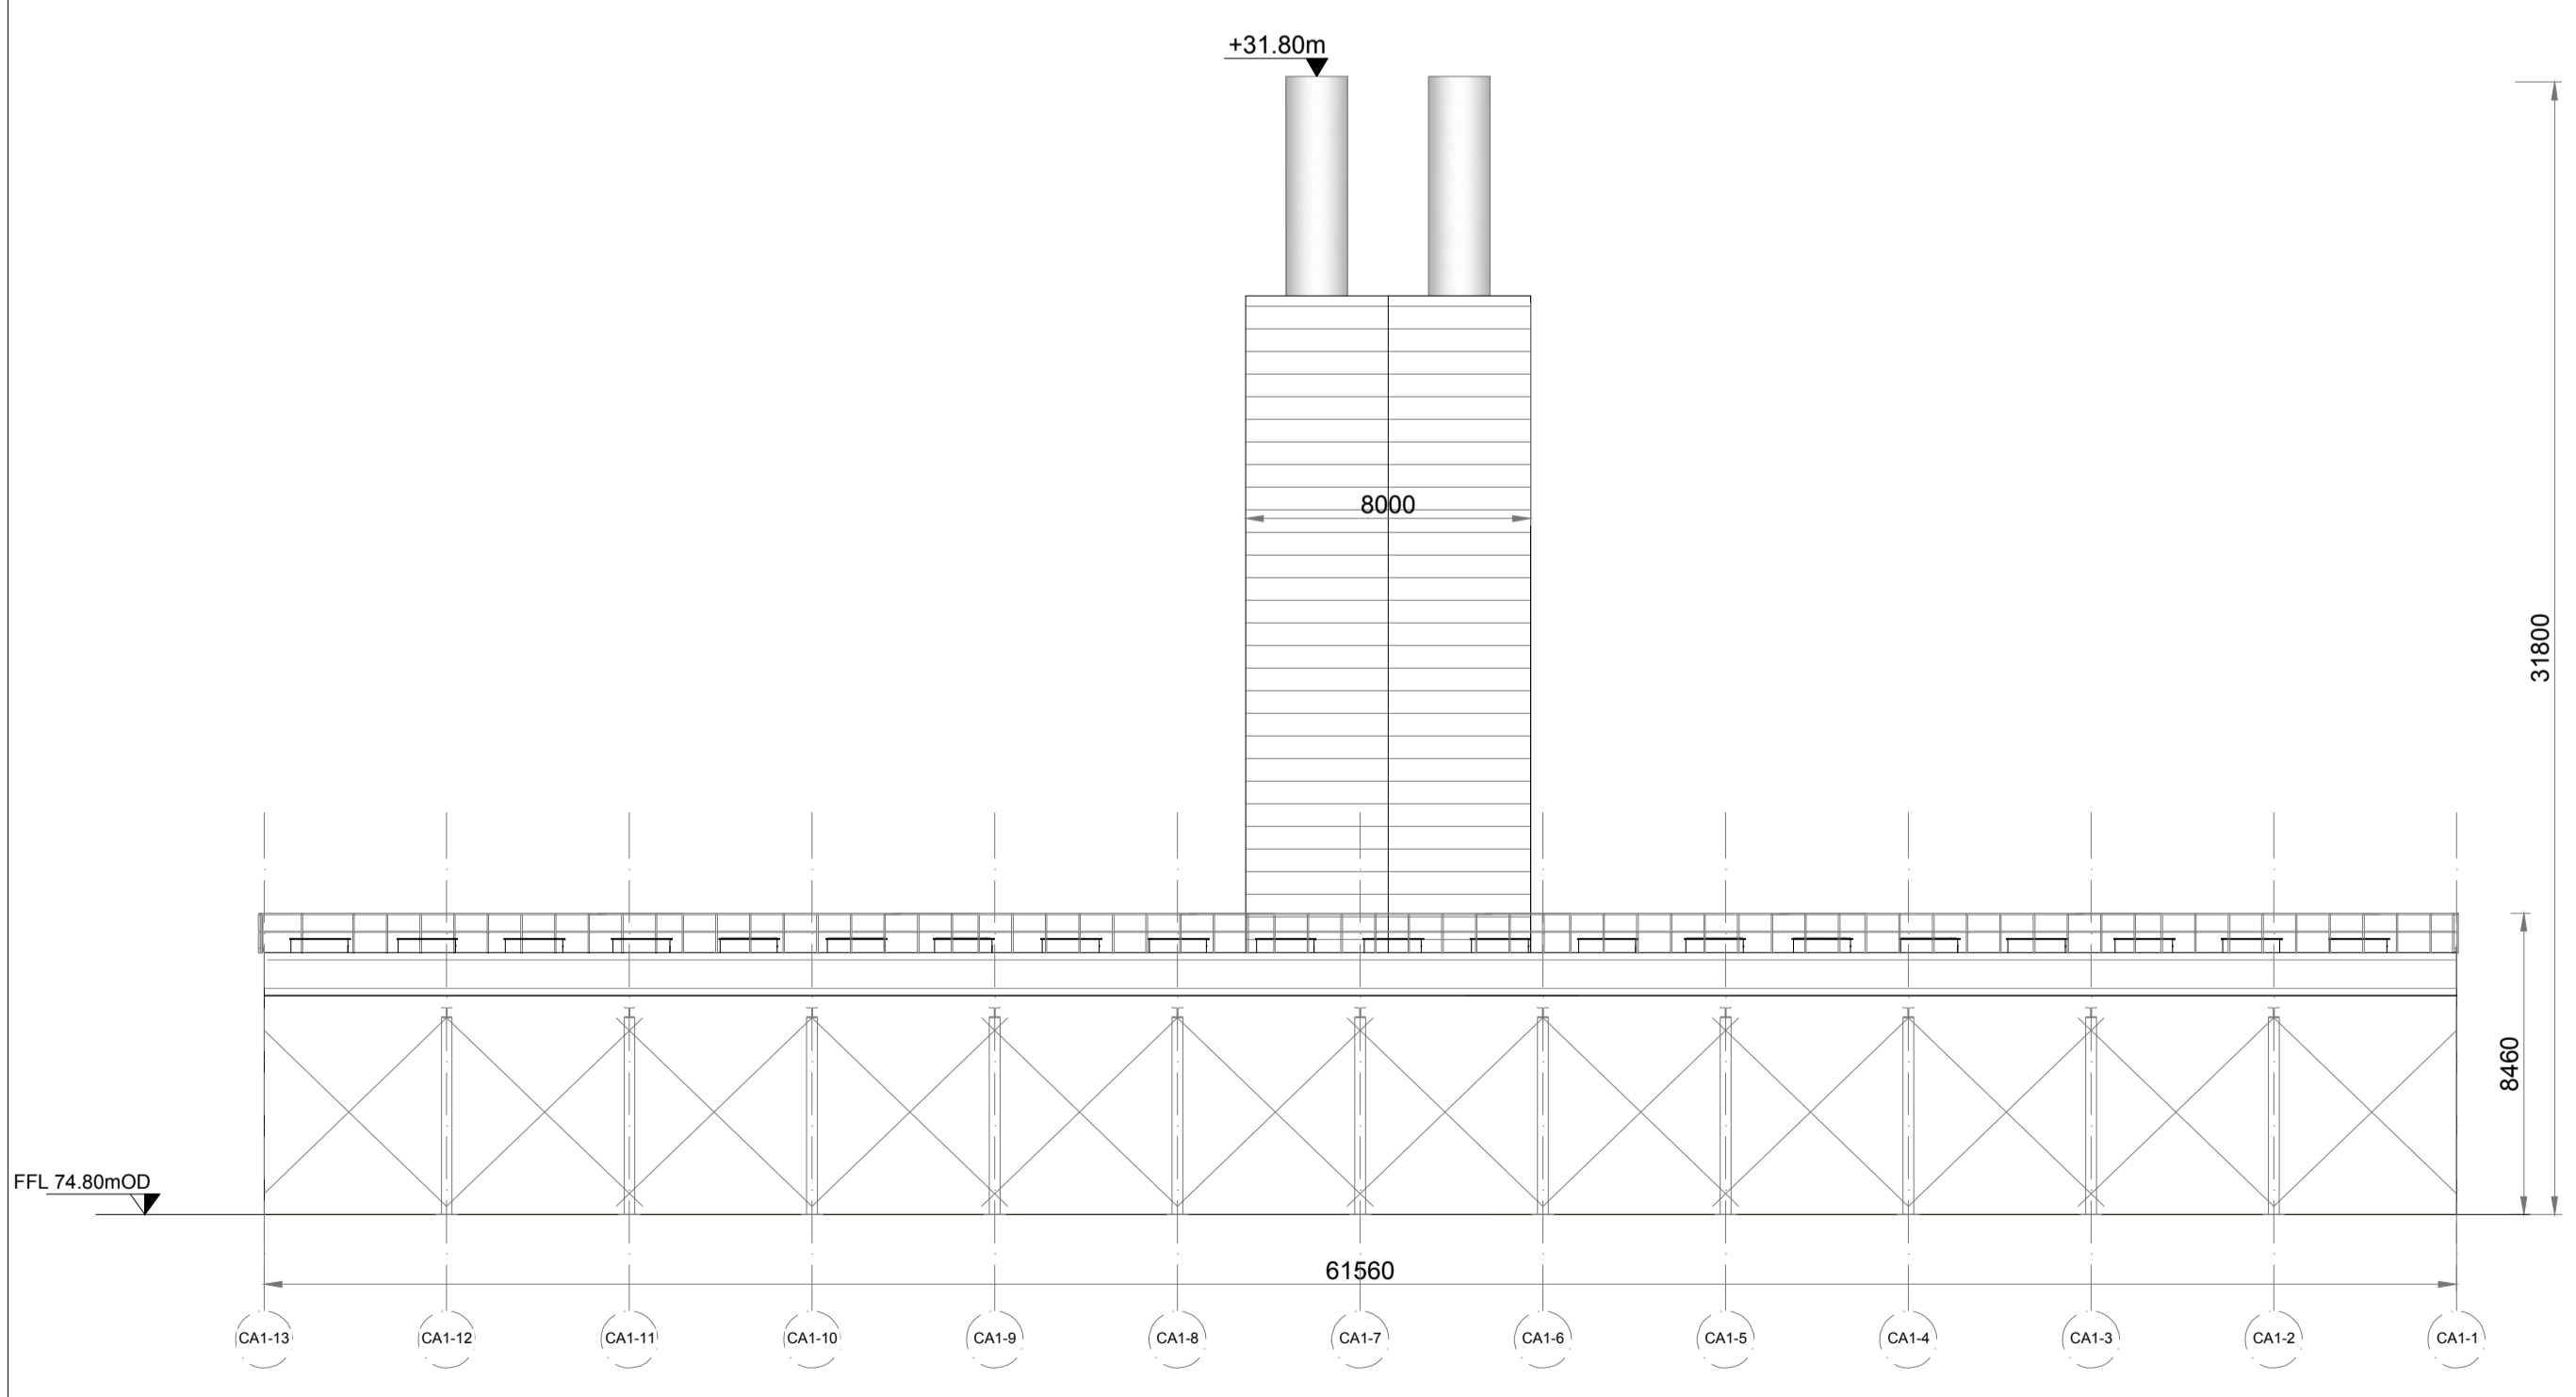


**ELEVATION C**  
Scale 1:200

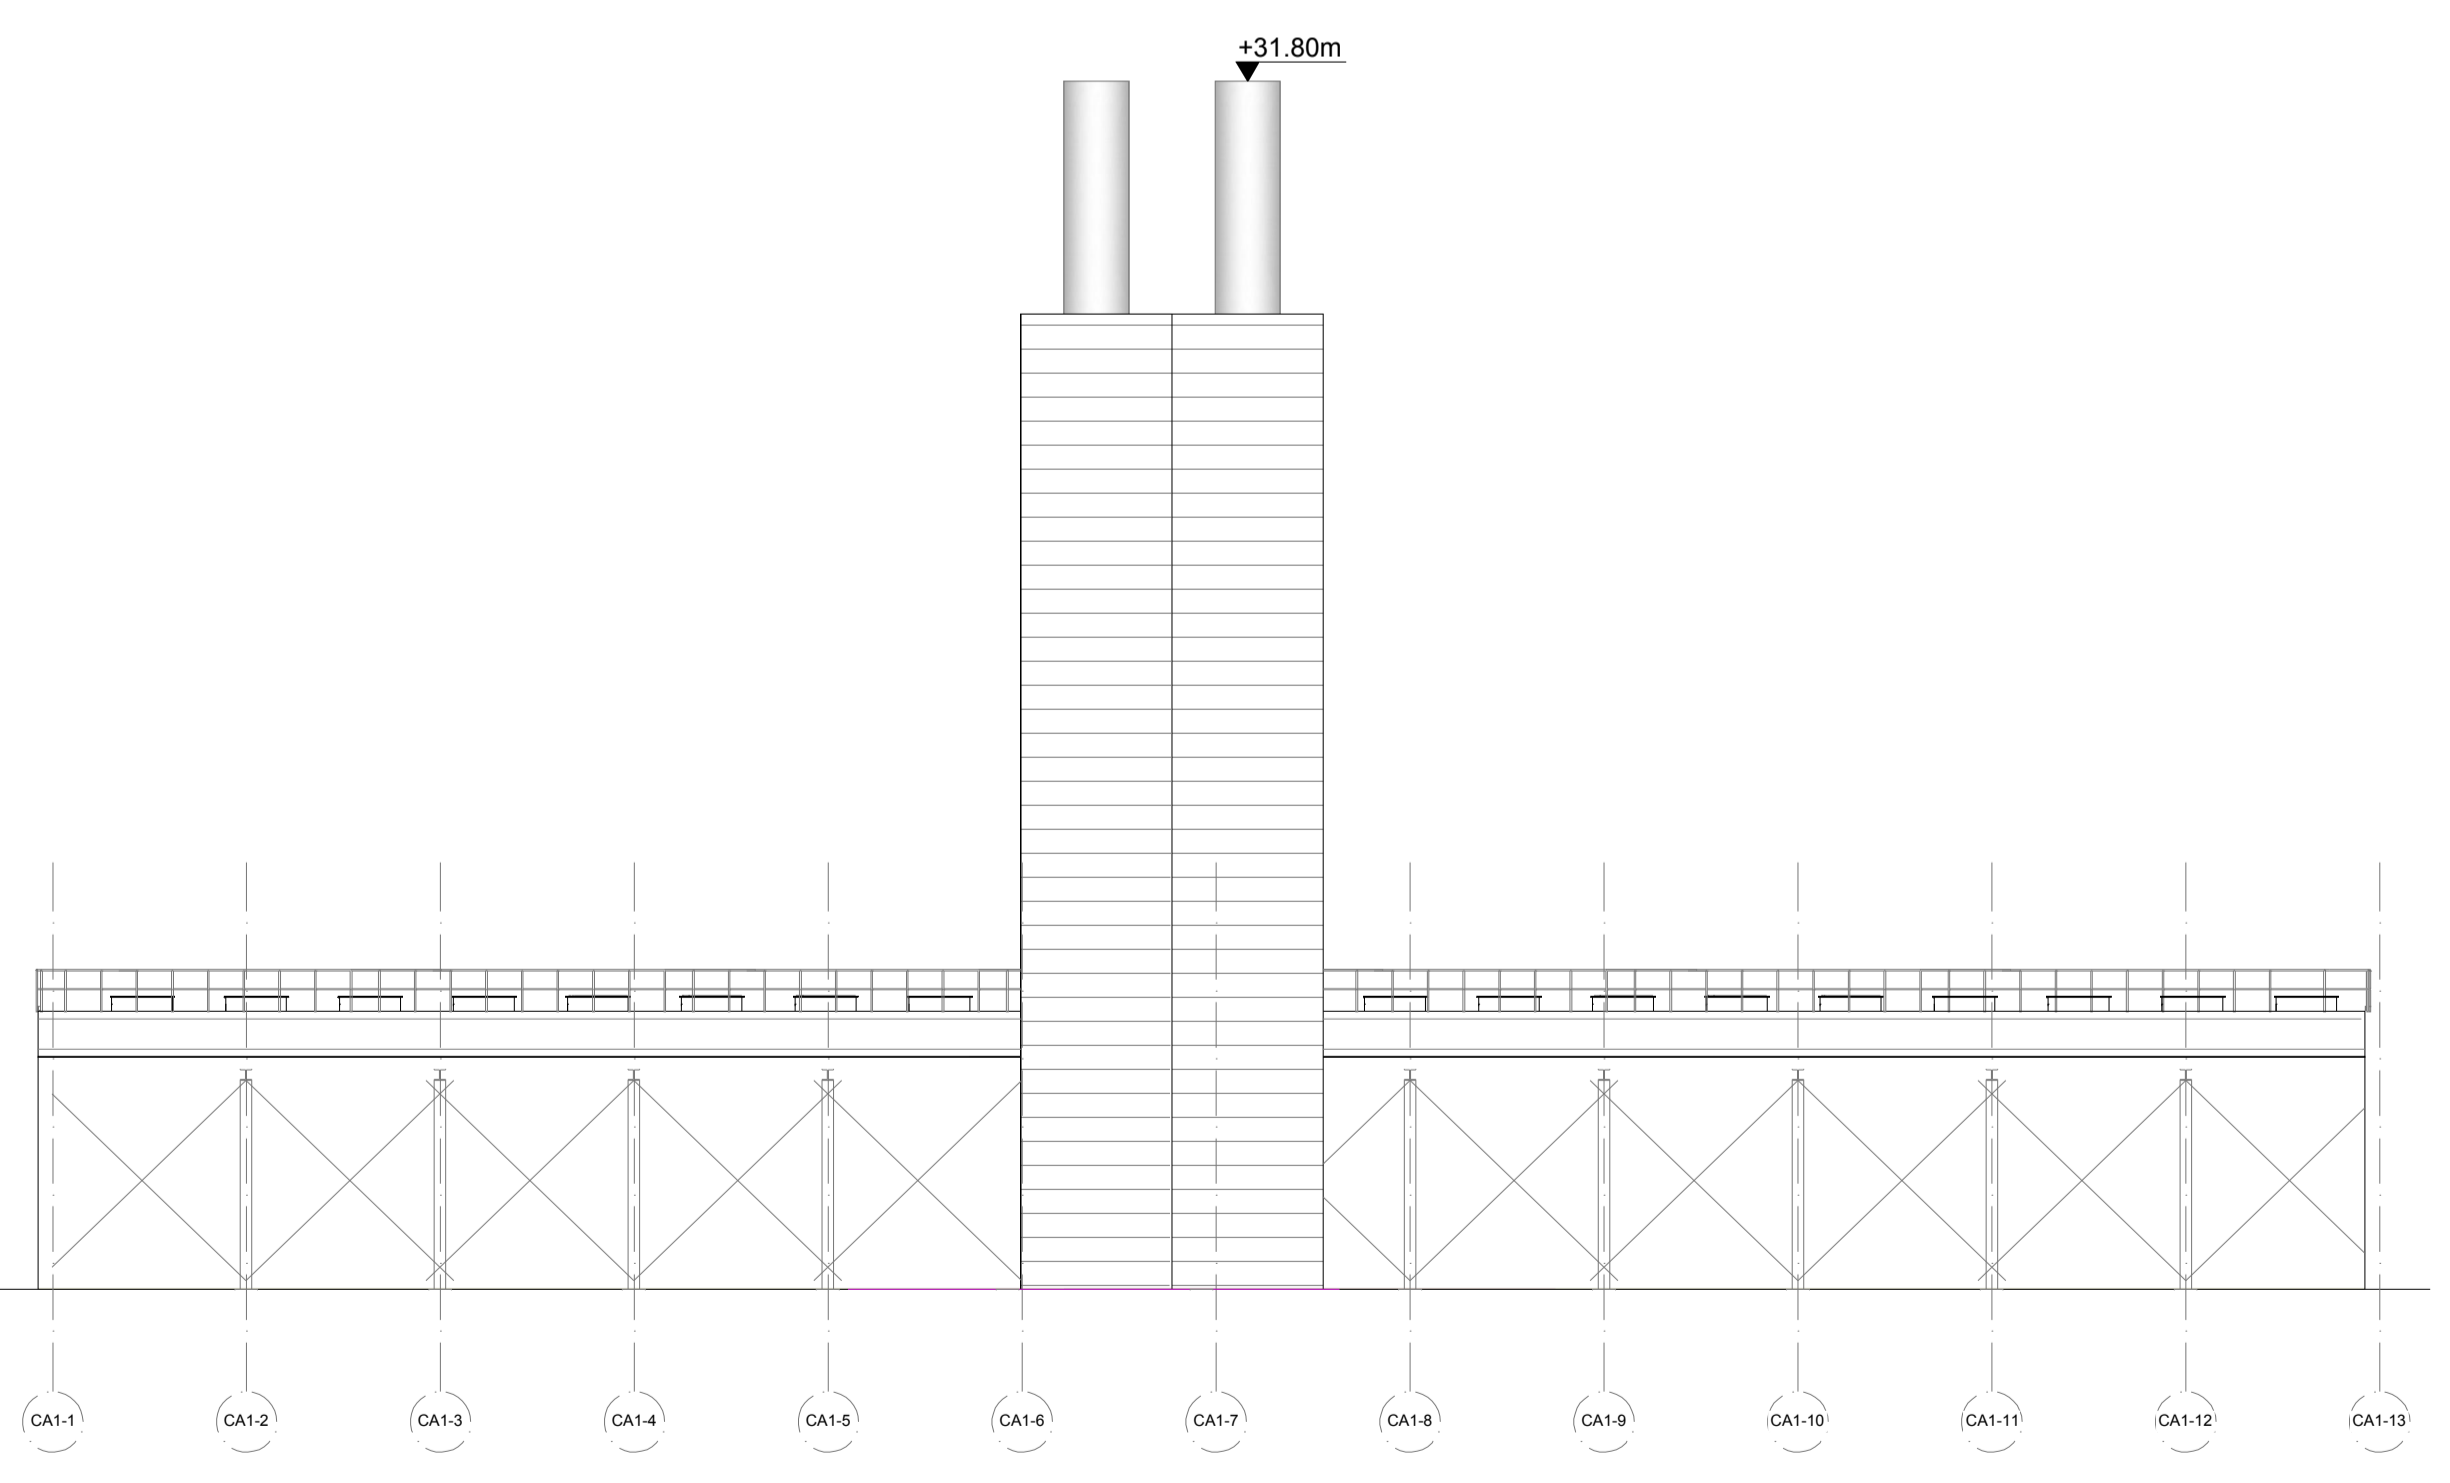

**ELEVATION D**  
Scale 1:200

As agreed with South Dublin County Council in the pre-application consultation meeting the final finishes, including cladding materials and colour codes, will be agreed with the Council post planning through planning condition. Greener Ideas Limited will ensure only Council approved finished are applied on site.

Rev	Date	Description	By	Chkd.
A	18.06.21	PLANNING ISSUE	MN	MMcC

Client: 

Project: **PROFILE PARK POWER PLANT**

Title: **RADIATOR COOLERS & EXHAUST STACK PLAN, ELEVATIONS & SECTION**

Scale @ A1: **As Shown**

Prepared by:	Checked:	Date:
M. Nolan	M. McCarthy	June 2021
Project Director:	S. Tinnelly	
Drawing Status:	Planning	

**TOBIN**  
CONSULTING ENGINEERS

Block 10-4, Blanchardstown Corporate Park,  
Dublin 15, Ireland.  
tel: +353-(0)1-8030406  
fax: +353-(0)1-8030409  
e-mail: dublin@tobin.ie  
www.tobin.ie

TOBIN Consulting Engineers will not be liable for any use of this document for any purpose other than that for which it was originally prepared and approved. Except where specifically and explicitly agreed in writing by TOBIN Consulting Engineers, copyright in this document and any drawings or other information contained therein shall not be transferred to any third party for any purpose.

Drawing No.: **11069-2043** Revision: **A**