




Elevation S2

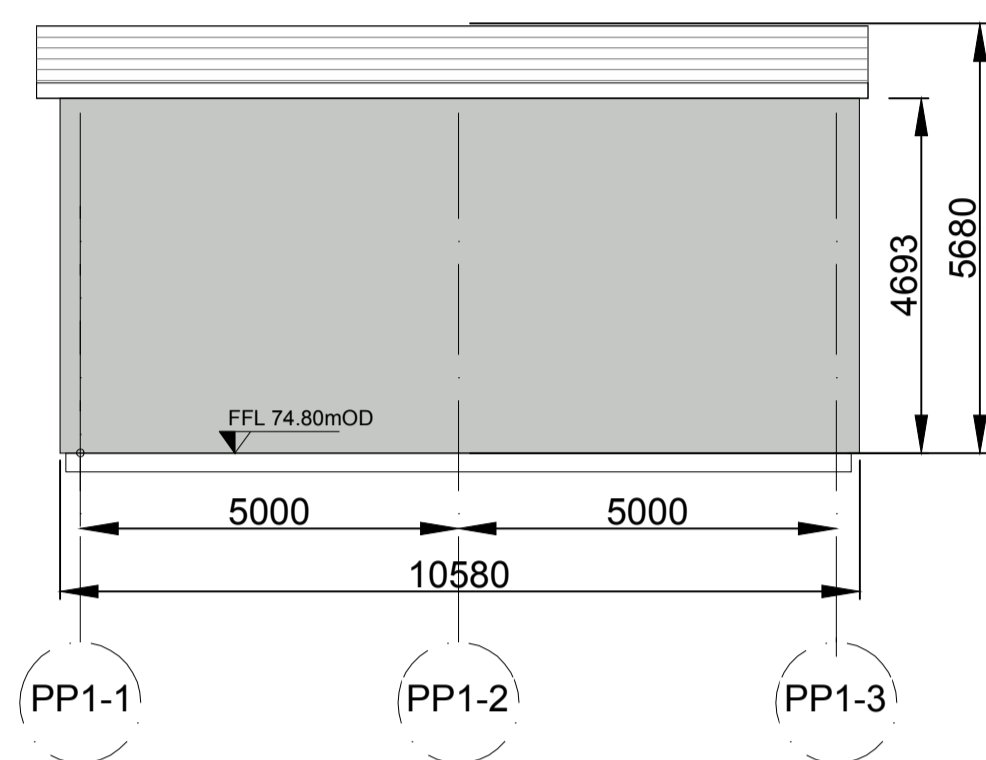


Elevation S1

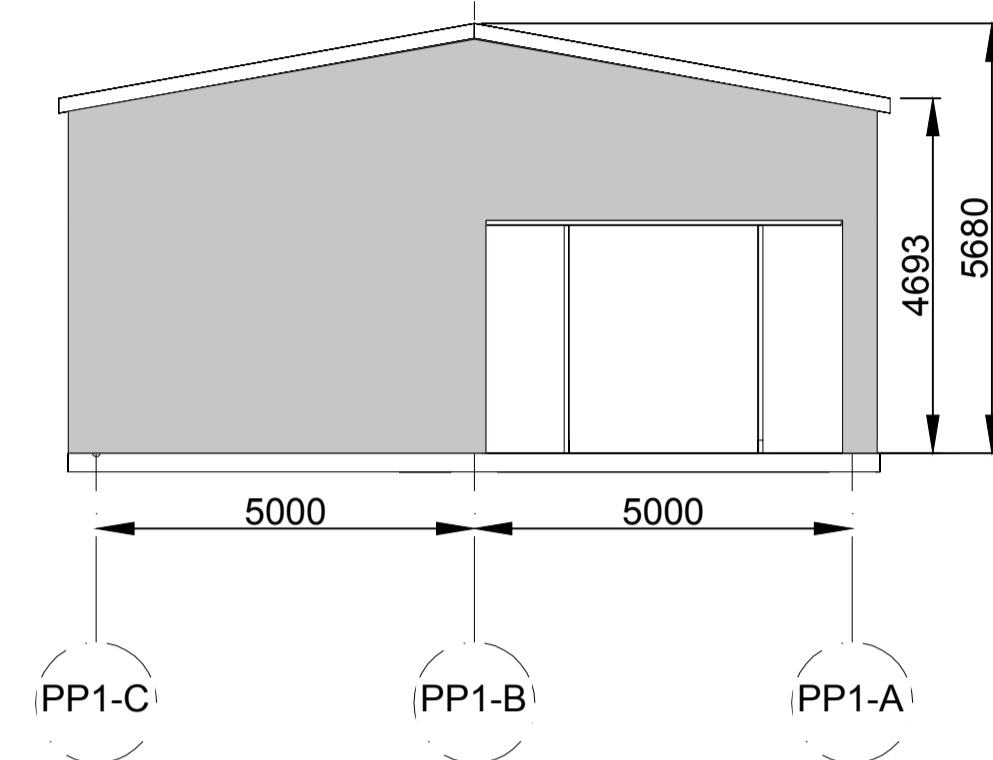


Section S2

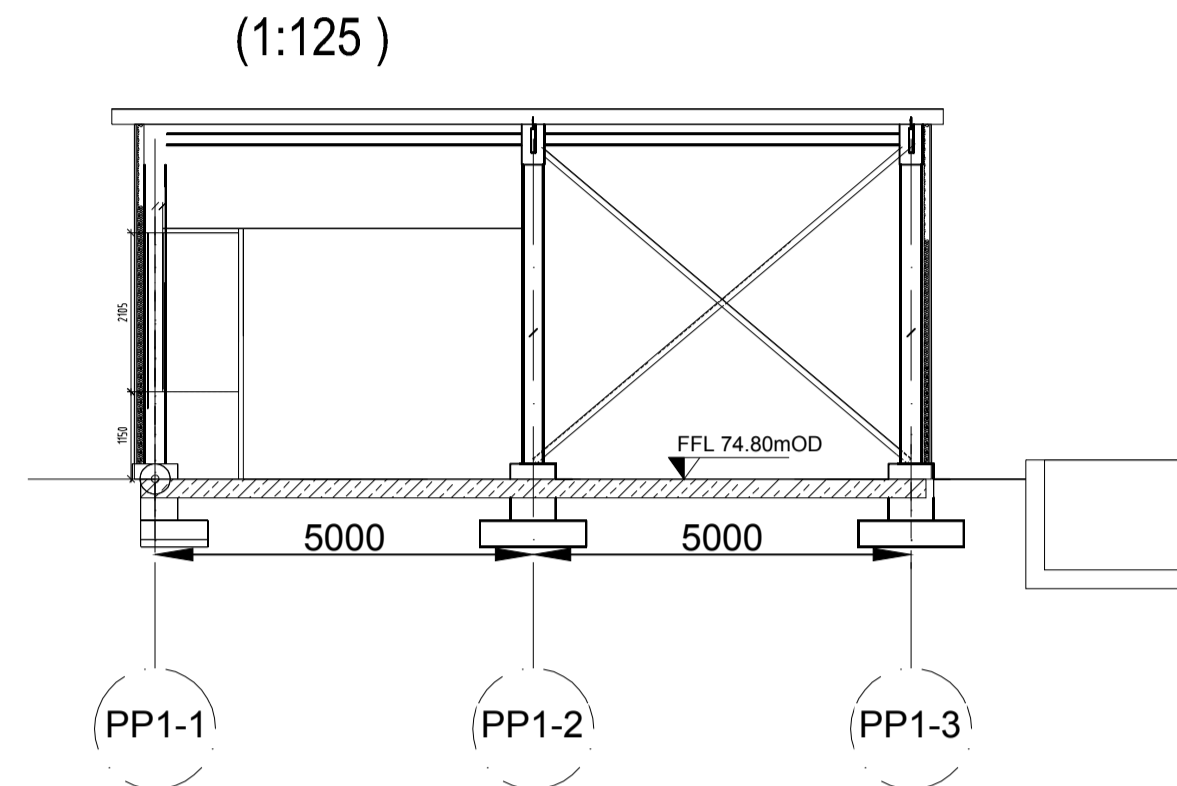



Elevation S4

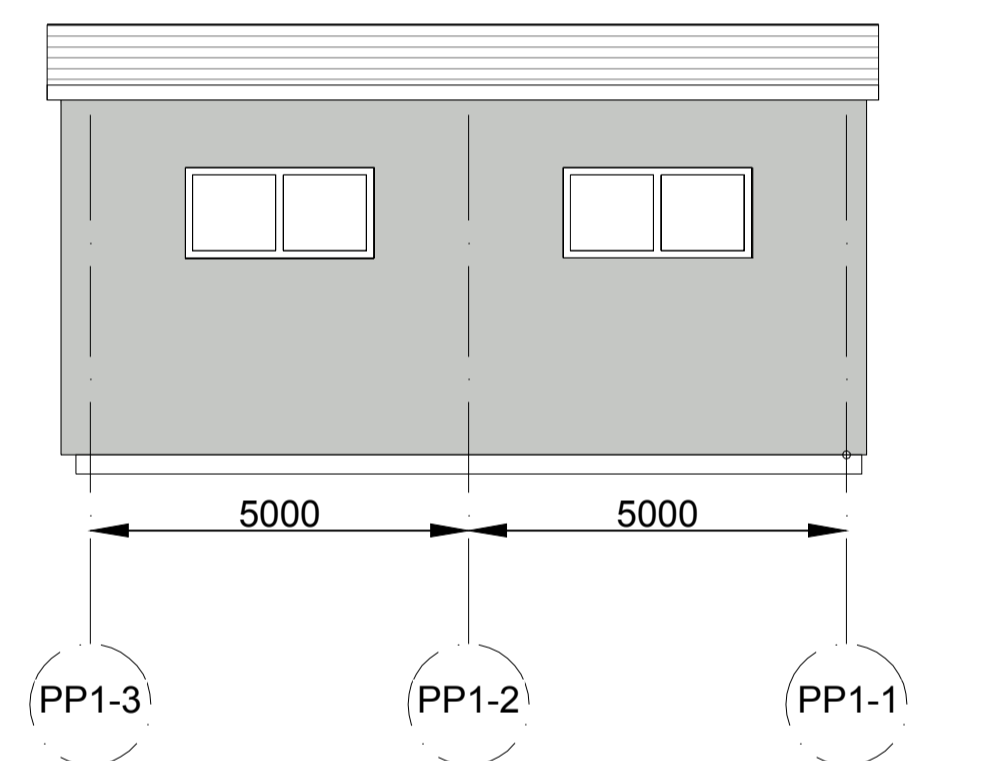

Elevation S3

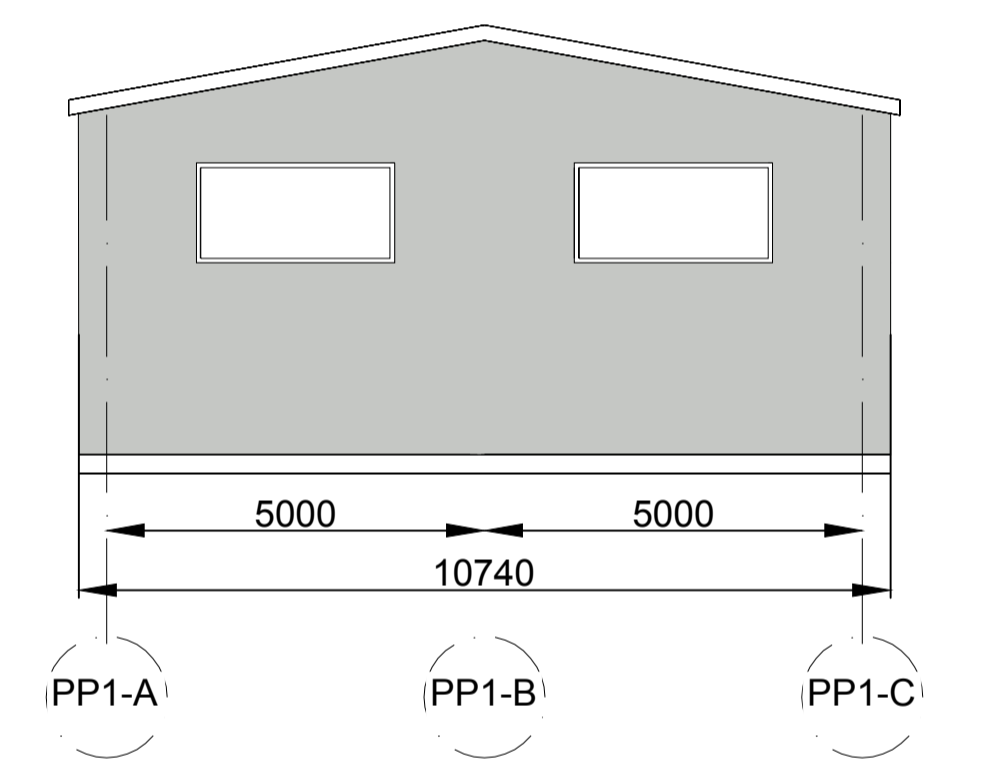

Plan

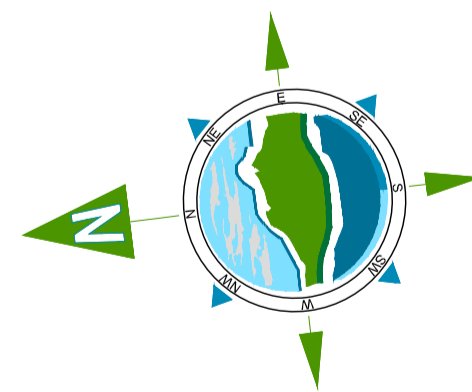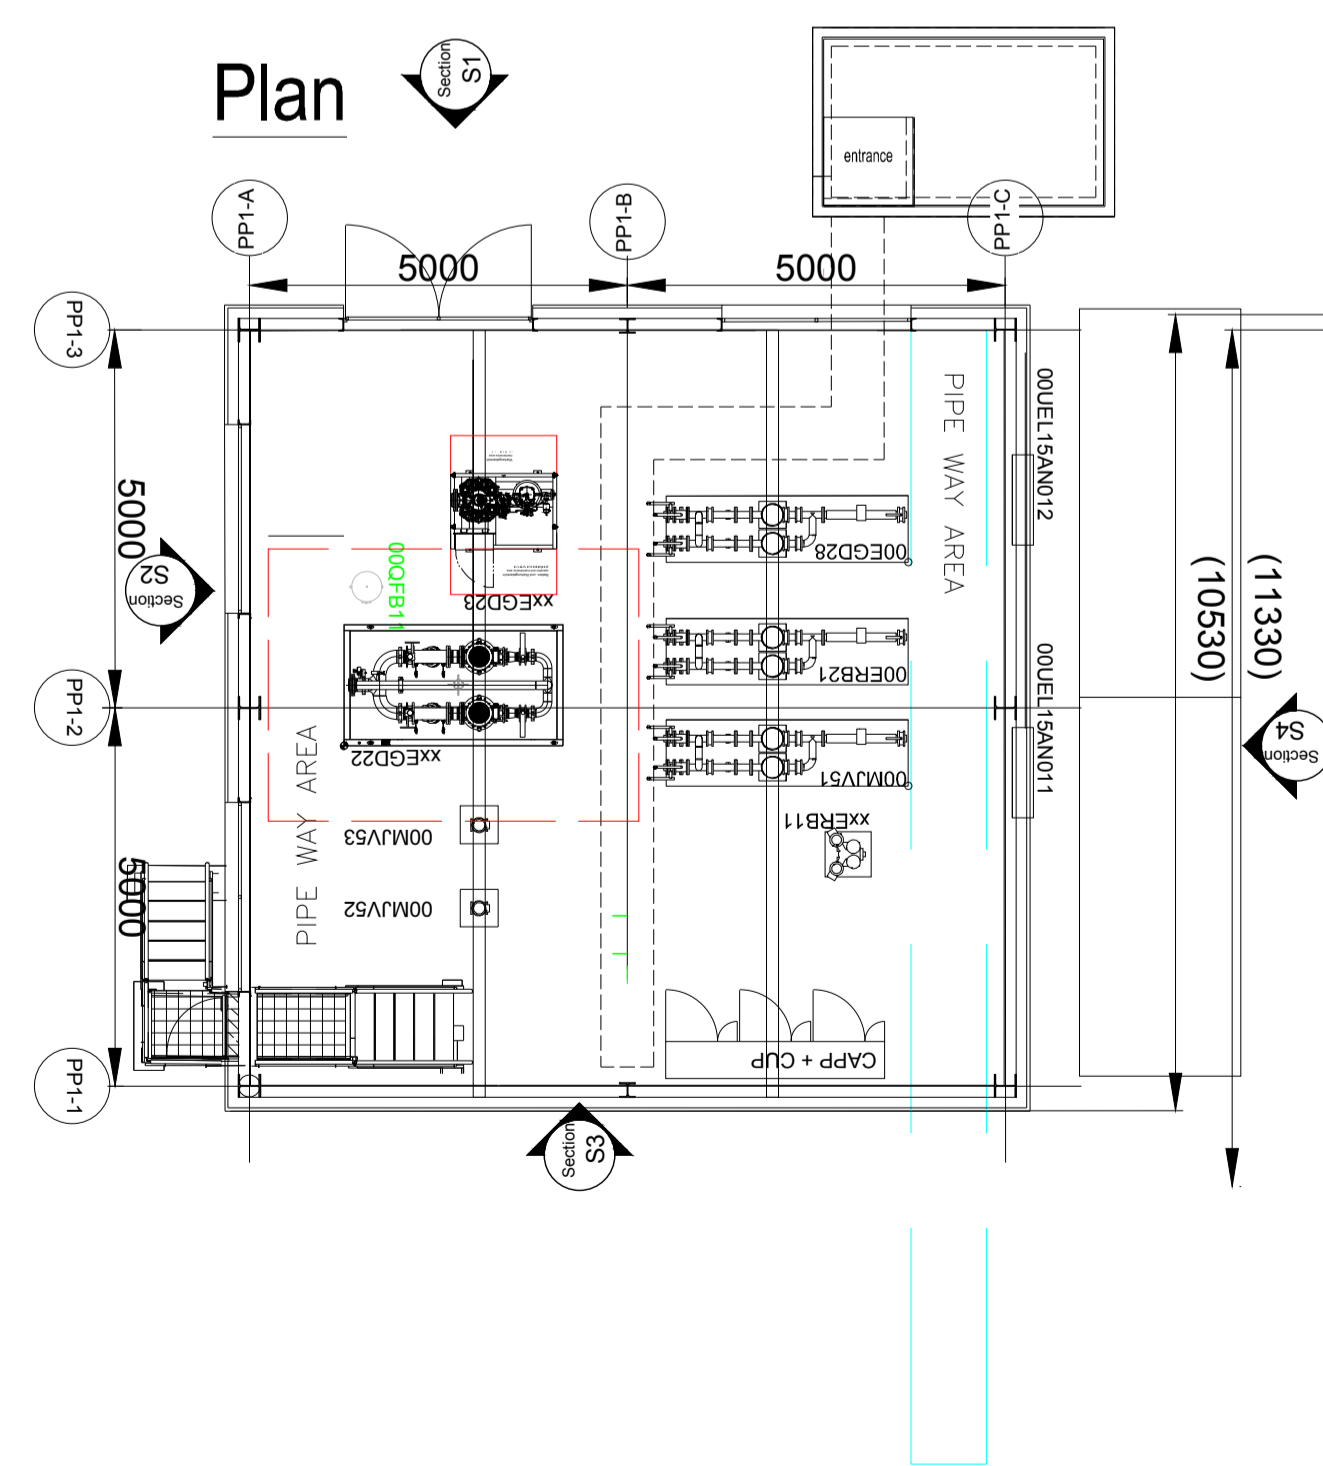

As agreed with South Dublin County Council in the pre-application consultation meeting the final finishes, including cladding materials and colour codes, will be agreed with the Council post planning through planning condition. Greener Ideas Limited will ensure only Council approved finishes are applied on site.

Rev	Date	Description	By	Chkd.
A	18.06.21	PLANNING ISSUE	MN	MMcC



Project:
**PROFILE PARK
POWER PLANT**

Title:
**TANK FARM BUILDING
PLAN, ELEVATIONS & SECTION**

Scale @ A1: 1:100
Prepared by: M. Nolan
Checked: M. McCarthy
Date: June 2021
Project Director: S. Tinnelly
Drawing Status: Planning

TOBIN
CONSULTING ENGINEERS
Block 10-4, Blanchardstown Corporate Park,
Dublin 15, Ireland.
tel: +353-(0)1-8030406
fax: +353-(0)1-8030409
e-mail: dublin@tobin.ie
www.tobin.ie

Tobin Consulting Engineers will not be liable for any use of this document for any purpose other than that for which it was originally prepared and issued. Except where specifically and explicitly agreed in writing by TOBIN Consulting Engineers, its copyright holder, no part of this document may be reproduced or transmitted in any form and this document shall not be relied upon by any third party for any purpose.
Drawing No.: 11069-2047
Revision: A