



**ELEVATION**

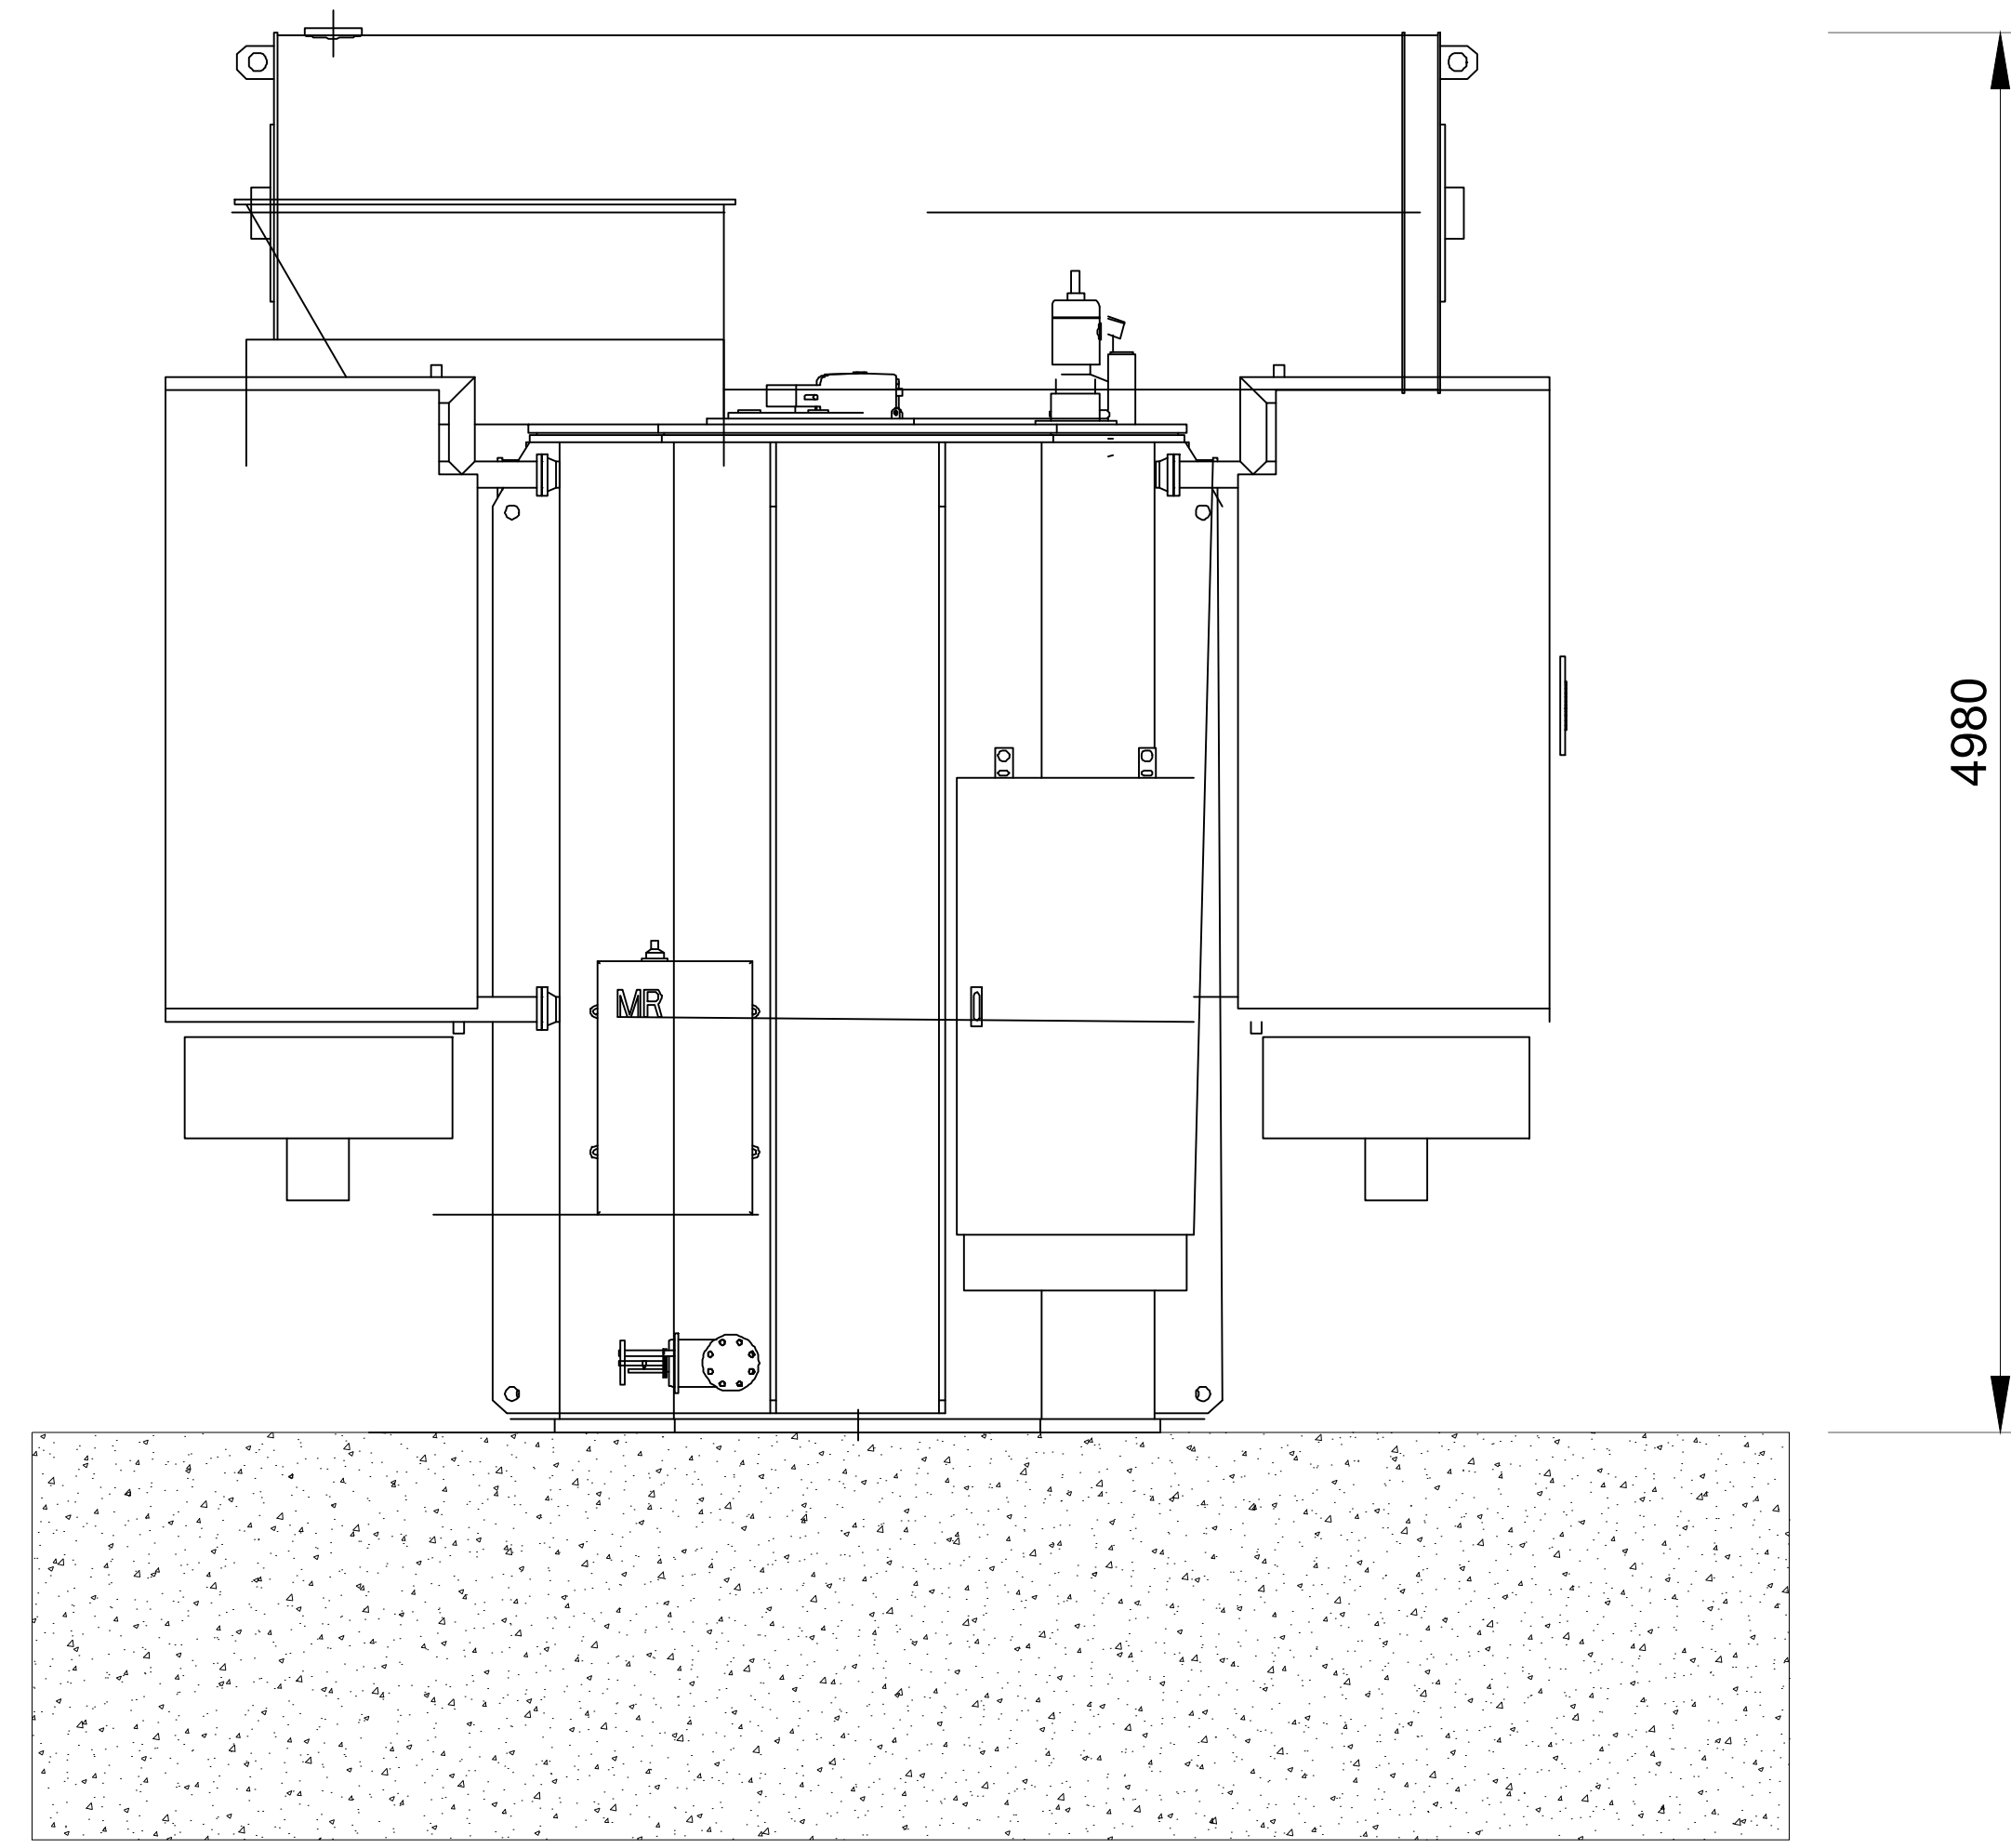


**ELEVATION**

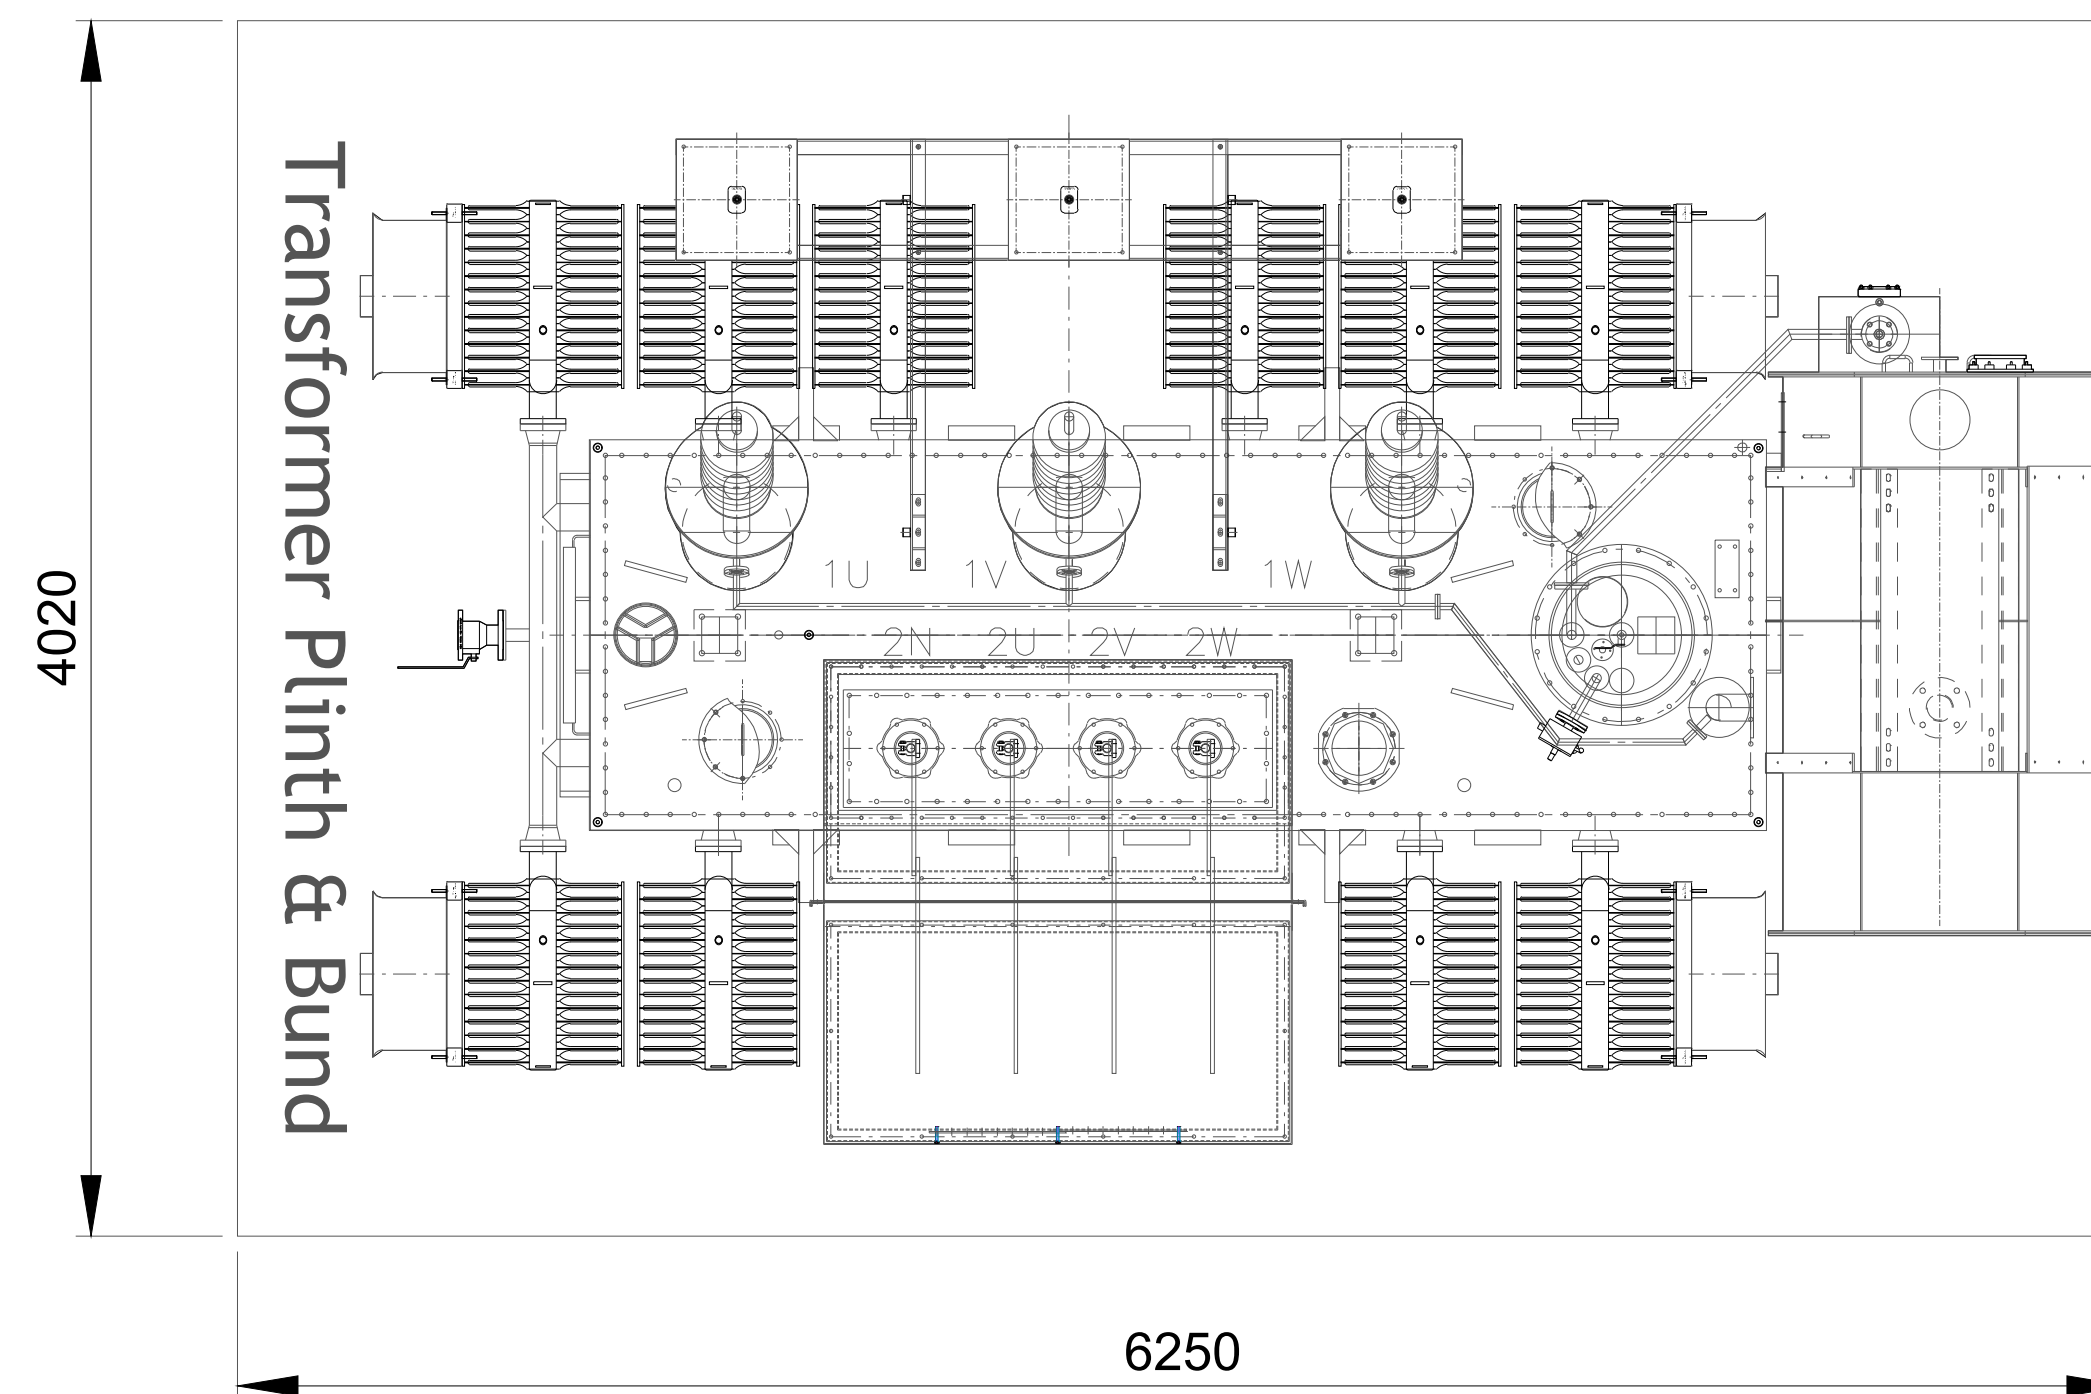

**PLAN**

Rev	Date	Description	By	Chkd.
A	18.06.21	PLANNING ISSUE	MN	MMcC

Client: 

Project: **PROFILE PARK POWER PLANT**

Title: **TRANSFORMER TYPICAL DETAILS**

Scale @ A1:	1:50	
Prepared by:	Checked:	Date:
M. Nolan	M. McCarthy	June 2021
Project Director:	S. Tinnelly	
Drawing Status:	Planning	

**TOBIN**  
CONSULTING ENGINEERS

Block 10-4, Blanchardstown Corporate Park,  
Dublin 15, Ireland.  
tel: +353-(0)1-8030406  
fax: +353-(0)1-8030409  
e-mail: dublin@tobin.ie  
www.tobin.ie

TOBIN Consulting Engineers will not be liable for any use of this document for any purpose other than that for which it was originally prepared and approved. Except where specifically and explicitly agreed in writing by TOBIN Consulting Engineers, the copyright holder, no part of this document may be reproduced or transmitted in any form and this document shall not be relied upon by any third party for any purpose.

Drawing No.: **11069-2051** Revision: **A**