



CONTIGUOUS ELEVATION A
- Scale 1:250

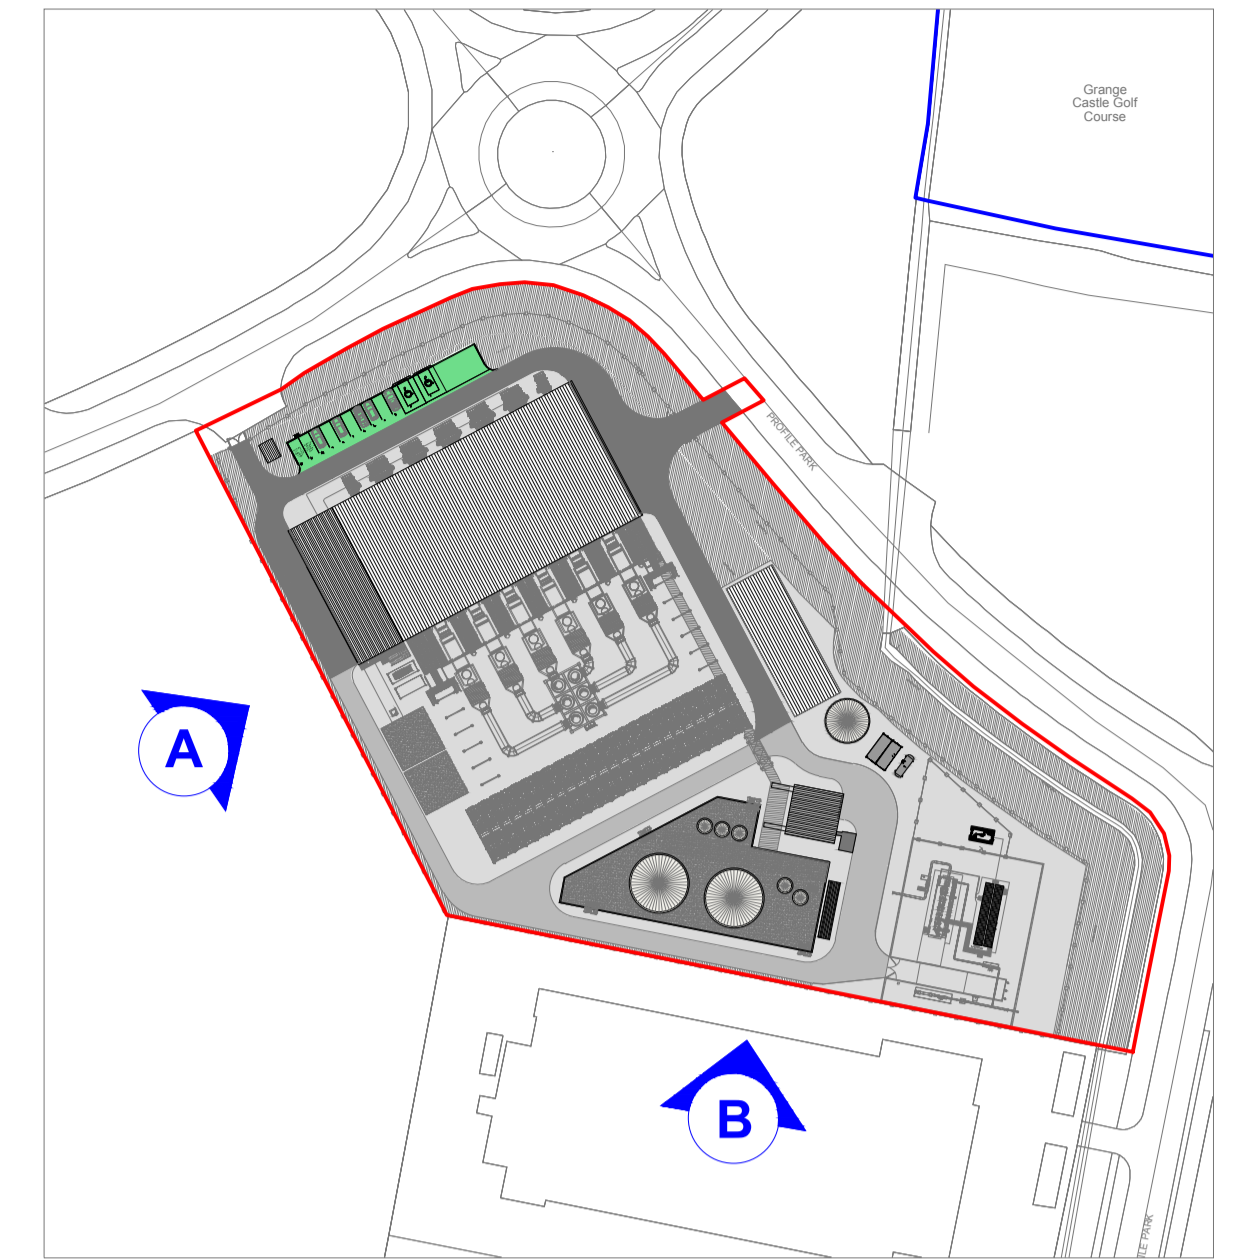

As agreed with South Dublin County Council in the pre-application consultation meeting the final finishes, including cladding materials and colour codes, will be agreed with the Council post planning through planning condition. Greener Ideas Limited will ensure only Council approved finishes are applied on site.

Rev	Date	Description	By	Chkd.
A	18.06.21	PLANNING ISSUE	MN	MMCC

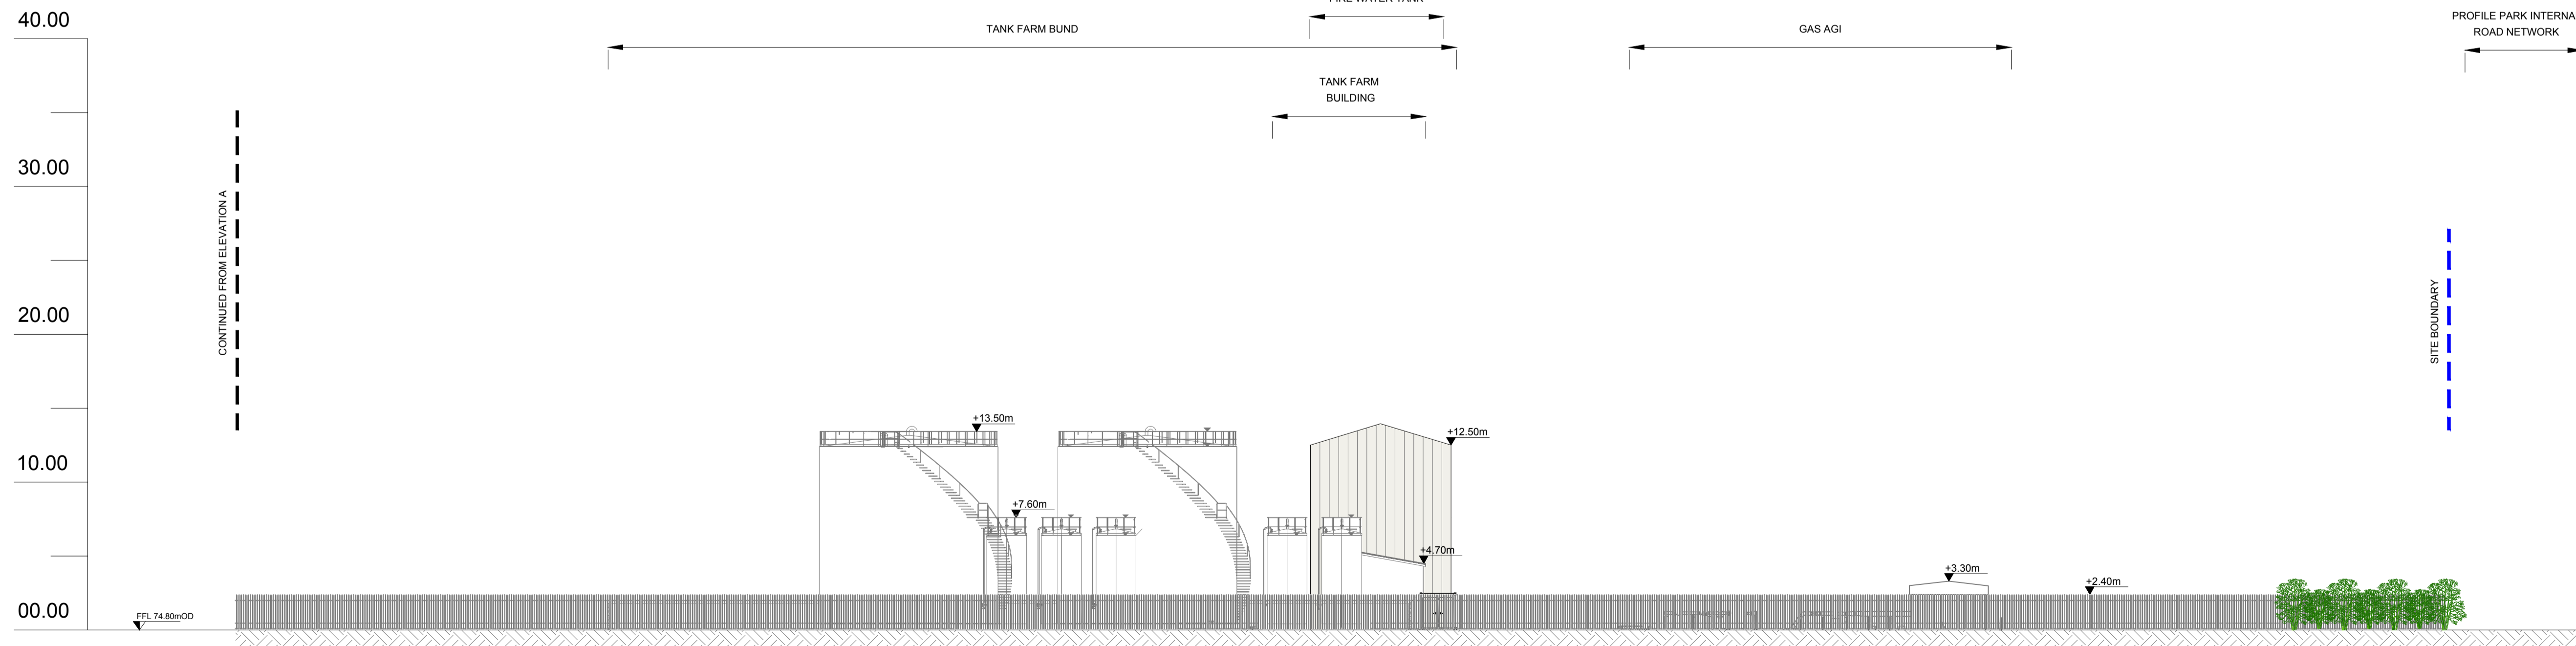

CONTIGUOUS ELEVATION B
- Scale 1:250

Client: 

Project: **PROFILE PARK POWER PLANT**

Title: **CONTIGUOUS ELEVATION Sheet 1 of 3**

Scale @ A1: 1:250

Prepared by:	Checked:	Date:
M. Nolan	M. McCarthy	June 2021
Project Director:	S. Tinnelly	
Drawing Status:	Planning	

TOBIN
CONSULTING ENGINEERS

Block 10-4, Blanchardstown Corporate Park,
Dublin 15, Ireland.
tel: +353-(0)1-8030406
fax: +353-(0)1-8030409
e-mail: dublin@tobin.ie
www.tobin.ie

Tobin Consulting Engineers will not be liable for any use of this document for any purpose other than that for which it was originally prepared and approved. Except where specifically and explicitly agreed in writing by TOBIN Consulting Engineers, its copyright, title and other intellectual property rights in this document shall not be retained upon by any third party for any purpose.

Drawing No.: **11069-2059** Revision: **A**