


CONTIGUOUS ELEVATION C
- Scale 1:300



As agreed with South Dublin County Council in the pre-application consultation meeting the final finishes, including cladding materials and colour codes, will be agreed with the Council post planning through planning condition. Greener Ideas Limited will ensure only Council approved finished are applied on site.

Rev	Date	Description	By	Chkd.
A	18.06.21	PLANNING ISSUE	MN	MMcC

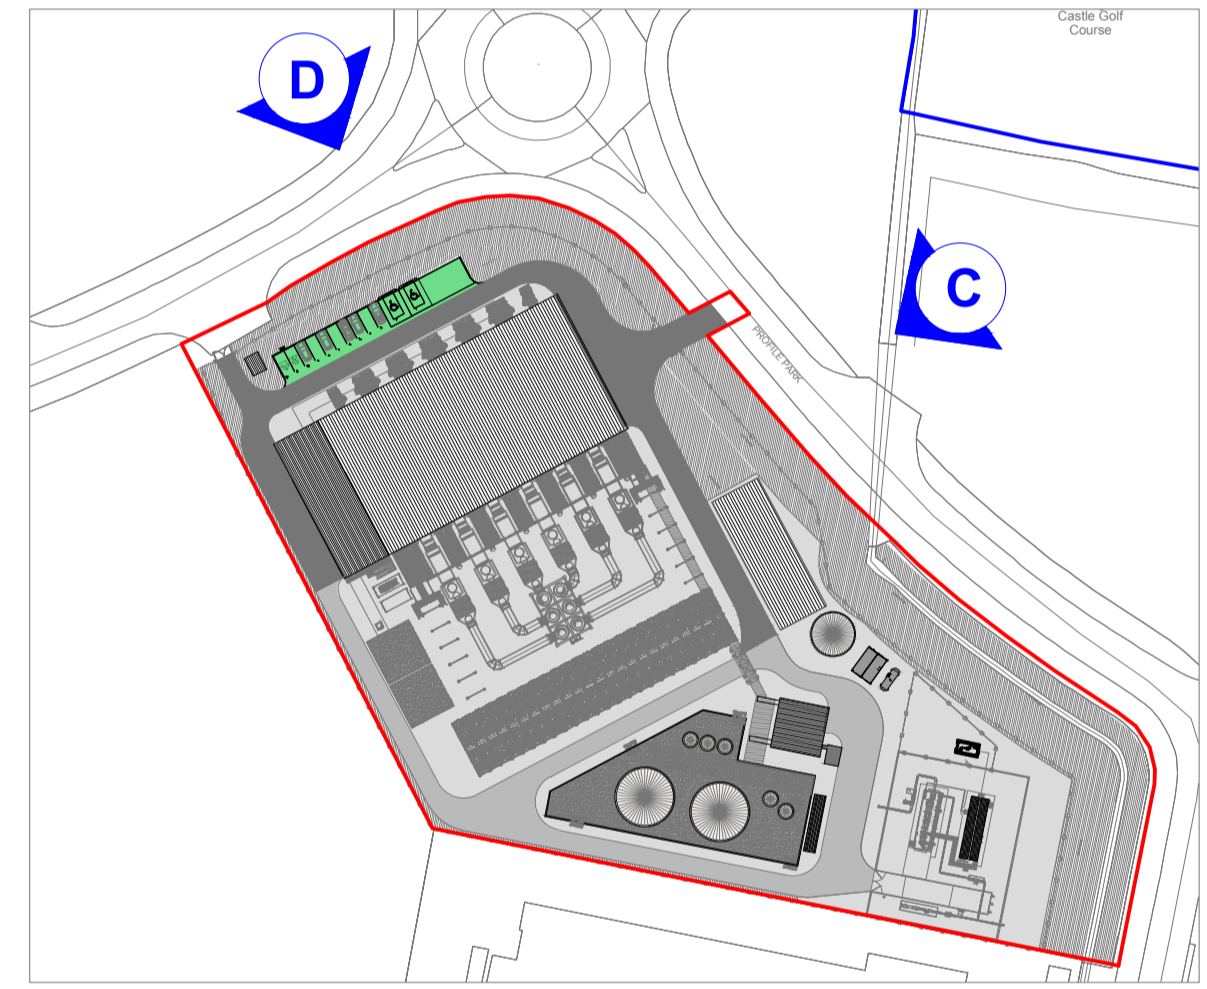


Project:
PROFILE PARK POWER PLANT

Title:
CONTIGUOUS ELEVATION Sheet 2 of 3

Scale @ A1: **1:300**
 Prepared by: M. Nolan Checked: M. McCarthy Date: June 2021
 Project Director: S. Tinnelly
 Drawing Status: **Planning**

TOBIN
CONSULTING ENGINEERS
 Block 10-4, Blanchardstown Corporate Park,
 Dublin 15, Ireland.
 tel: +353-(0)1-8030406
 fax: +353-(0)1-8030409
 e-mail: dublin@tobin.ie
 www.tobin.ie

Drawing No.: **11069-2060** Revision: **A**

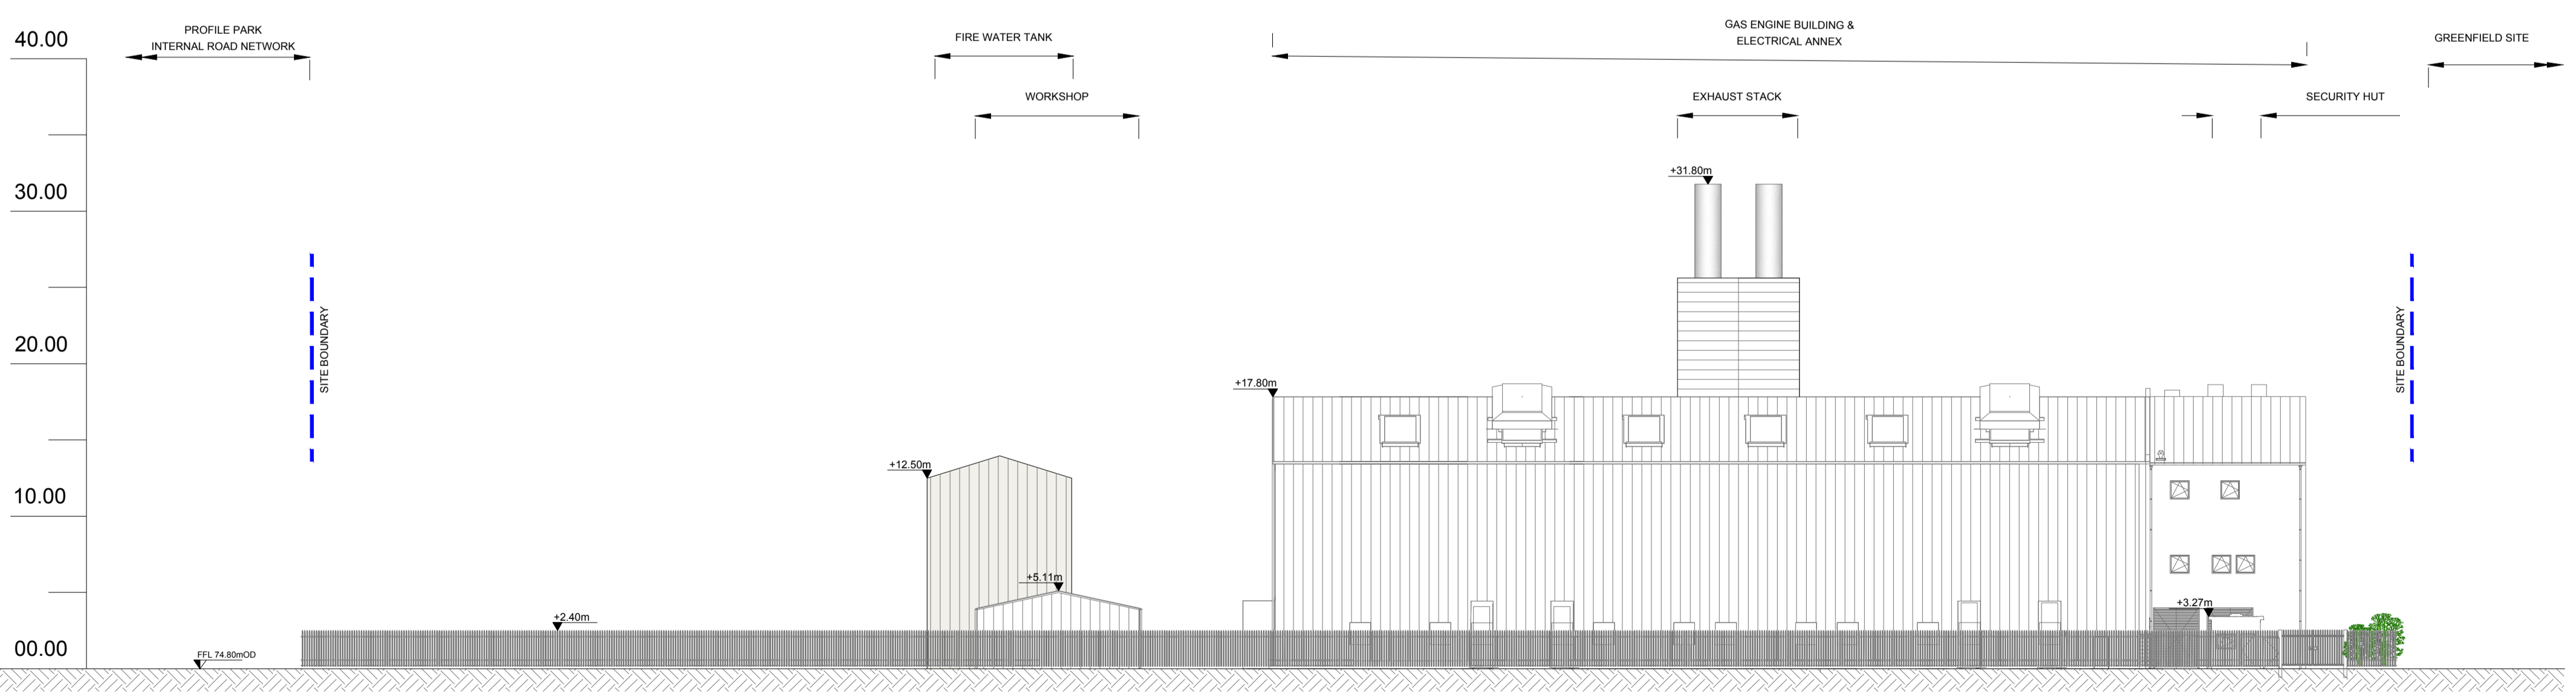

CONTIGUOUS ELEVATION D
- Scale 1:300