


CONTIGUOUS ELEVATION E
- Scale 1:250

As agreed with South Dublin County Council in the pre-application consultation meeting the final finishes, including cladding materials and colour codes, will be agreed with the Council post planning through planning condition. Greener Ideas Limited will ensure only Council approved finishes are applied on site.

Rev	Date	Description	By	Chkd.
A	18.06.21	PLANNING ISSUE	MN	MMcC

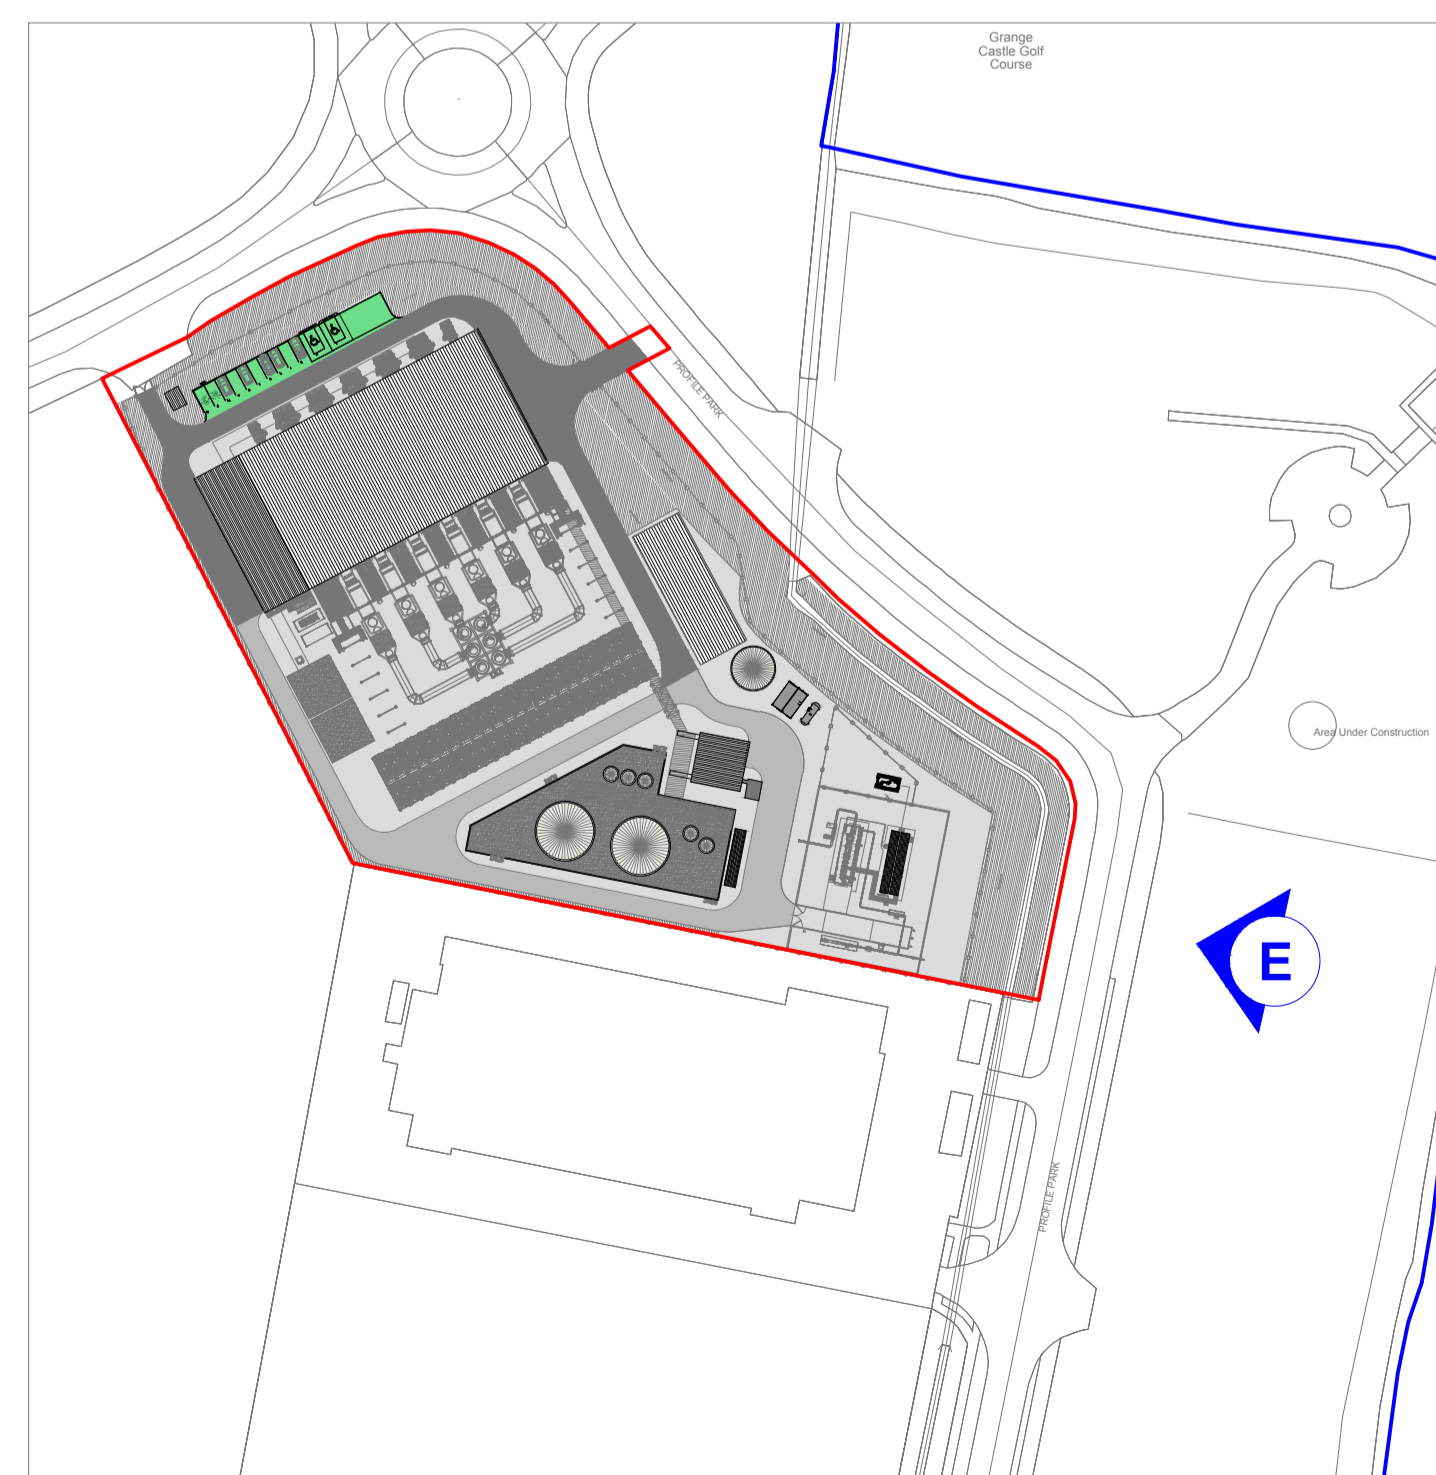

Client: 

Project: **PROFILE PARK POWER PLANT**

Title: **CONTIGUOUS ELEVATION Sheet 3 of 3**

Scale @ A1: 1:250
 Prepared by: M. Nolan Checked: M. McCarthy Date: June 2021
 Project Director: S. Tinnelly
 Drawing Status: Planning

TOBIN
CONSULTING ENGINEERS
 Block 10-4, Blanchardstown Corporate Park,
 Dublin 15, Ireland.
 tel: +353-(0)1-8030406
 fax: +353-(0)1-8030409
 e-mail: dublin@tobin.ie
 www.tobin.ie

Tobin Consulting Engineers will not be liable for any use of this document for any purpose other than that for which it was originally prepared and approved. Except where specifically and explicitly agreed in writing by TOBIN Consulting Engineers, its copyright holder, no part of this document may be reproduced or transmitted in any form and this document shall not be relied upon by any third party for any purpose.

Drawing No.: 11069-2061 Revision: **A**