


READ IN CONJUNCTION WITH PROPOSED GROUND FLOOR PLAN, ENVIRONMENTAL ENGINEERS DRAINAGE DESIGN, REPORTS & LANDSCAPE ARCHITECTS DRAWING

**DRAINAGE LEGEND**

- PROPOSED 150Ø UPVC SURFACE WATER PIPE
- PROPOSED 150Ø UPVC FOUL SEWER PIPE
- - - WATER MAIN (from Well)

Proposed Block Plan & Drainage Layout  
SCALE 1:200

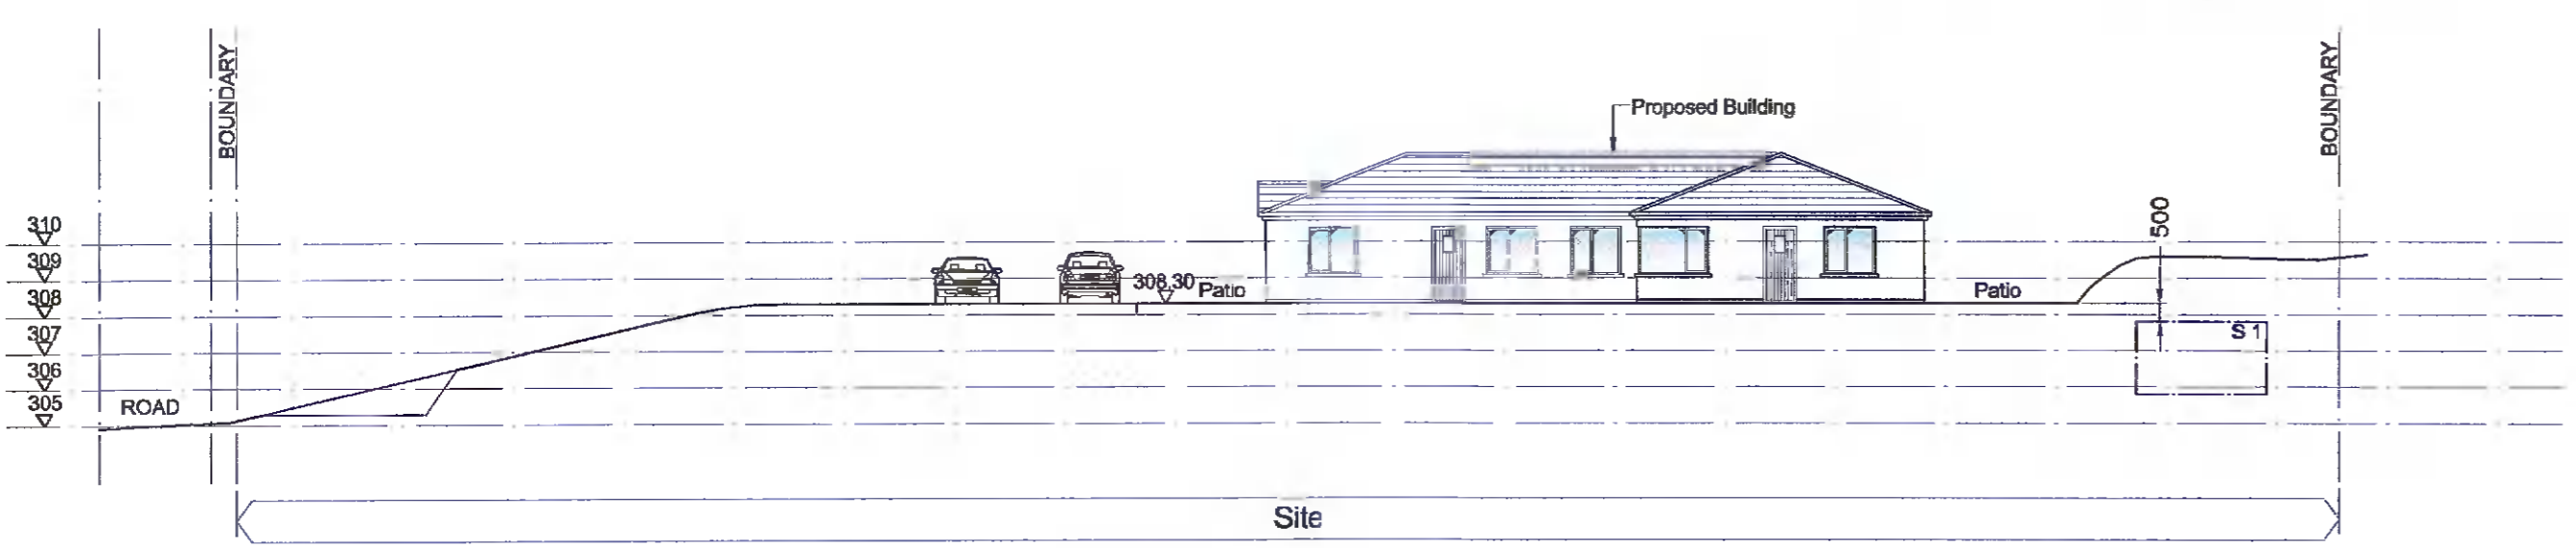

Section B-B  
SCALE 1:200

**Architectural Planning**  
4 CARRIGMORE CLOSE, AYLESBURY,  
Dublin 24 - Ph: 01 4148358

CLIENT: DERMOT McDONNELL  
JOB TITLE: Proposed works at Site at Slievethou, Brittas, Co. Dublin

TITLE: PROPOSED BLOCK PLAN, DRAINAGE LAYOUT & SECTION  
SCALE: AS SHOWN  
JOB No: S273

NOTES:  
This drawing is to be read in conjunction with all relevant Engineers drawings.  
Do not scale use figured dimensions ONLY.  
All dimensions in millimeters unless otherwise stated.  
All dimensions to be checked on site.  
All building works to comply with current building regulations & in accordance with Homebond Standards.

Drawing to be read in conjunction with all Drainage drawings, Landscape drawings & reports.

THIS DRAWING IS ISSUED FOR PLANNING ONLY, AND IS NOT A CONSTRUCTION DRAWING