



1 Waste Compound Plan
1 : 100

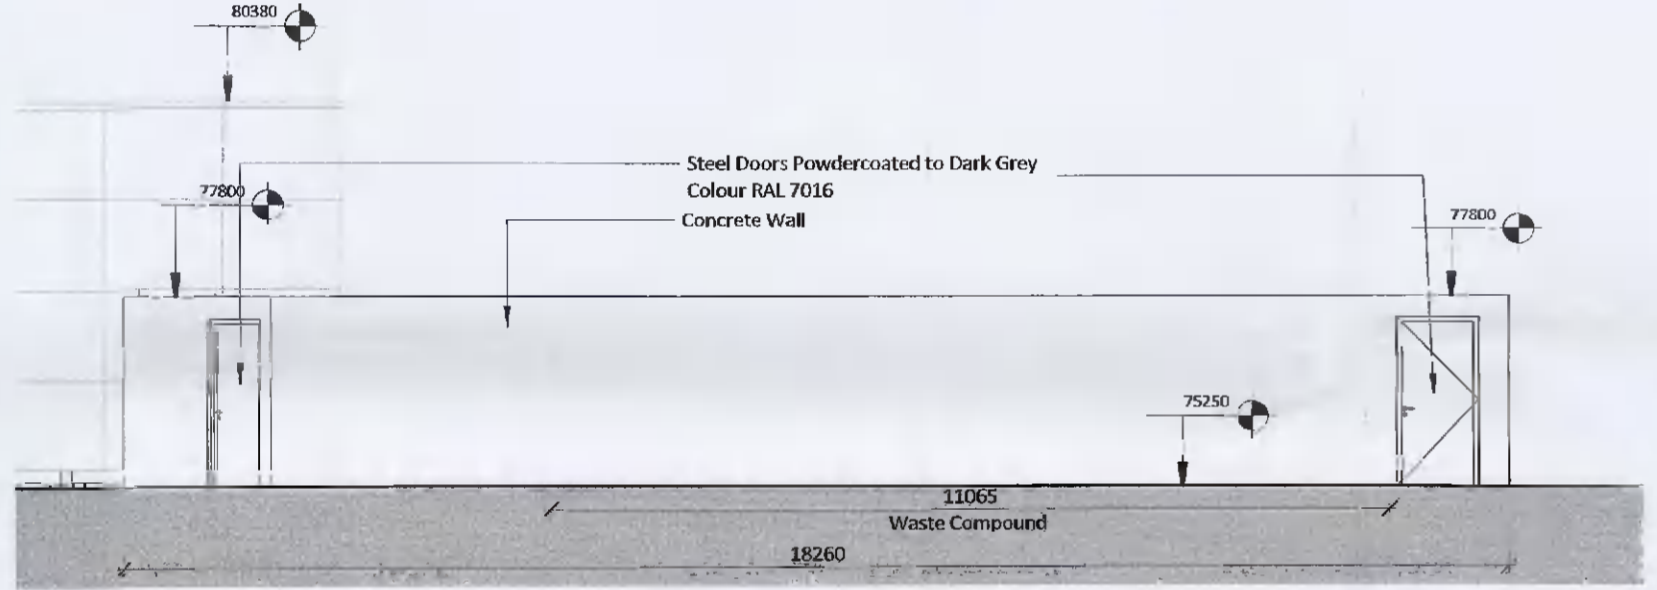


2 Waste Compound - North Elevation
1 : 100

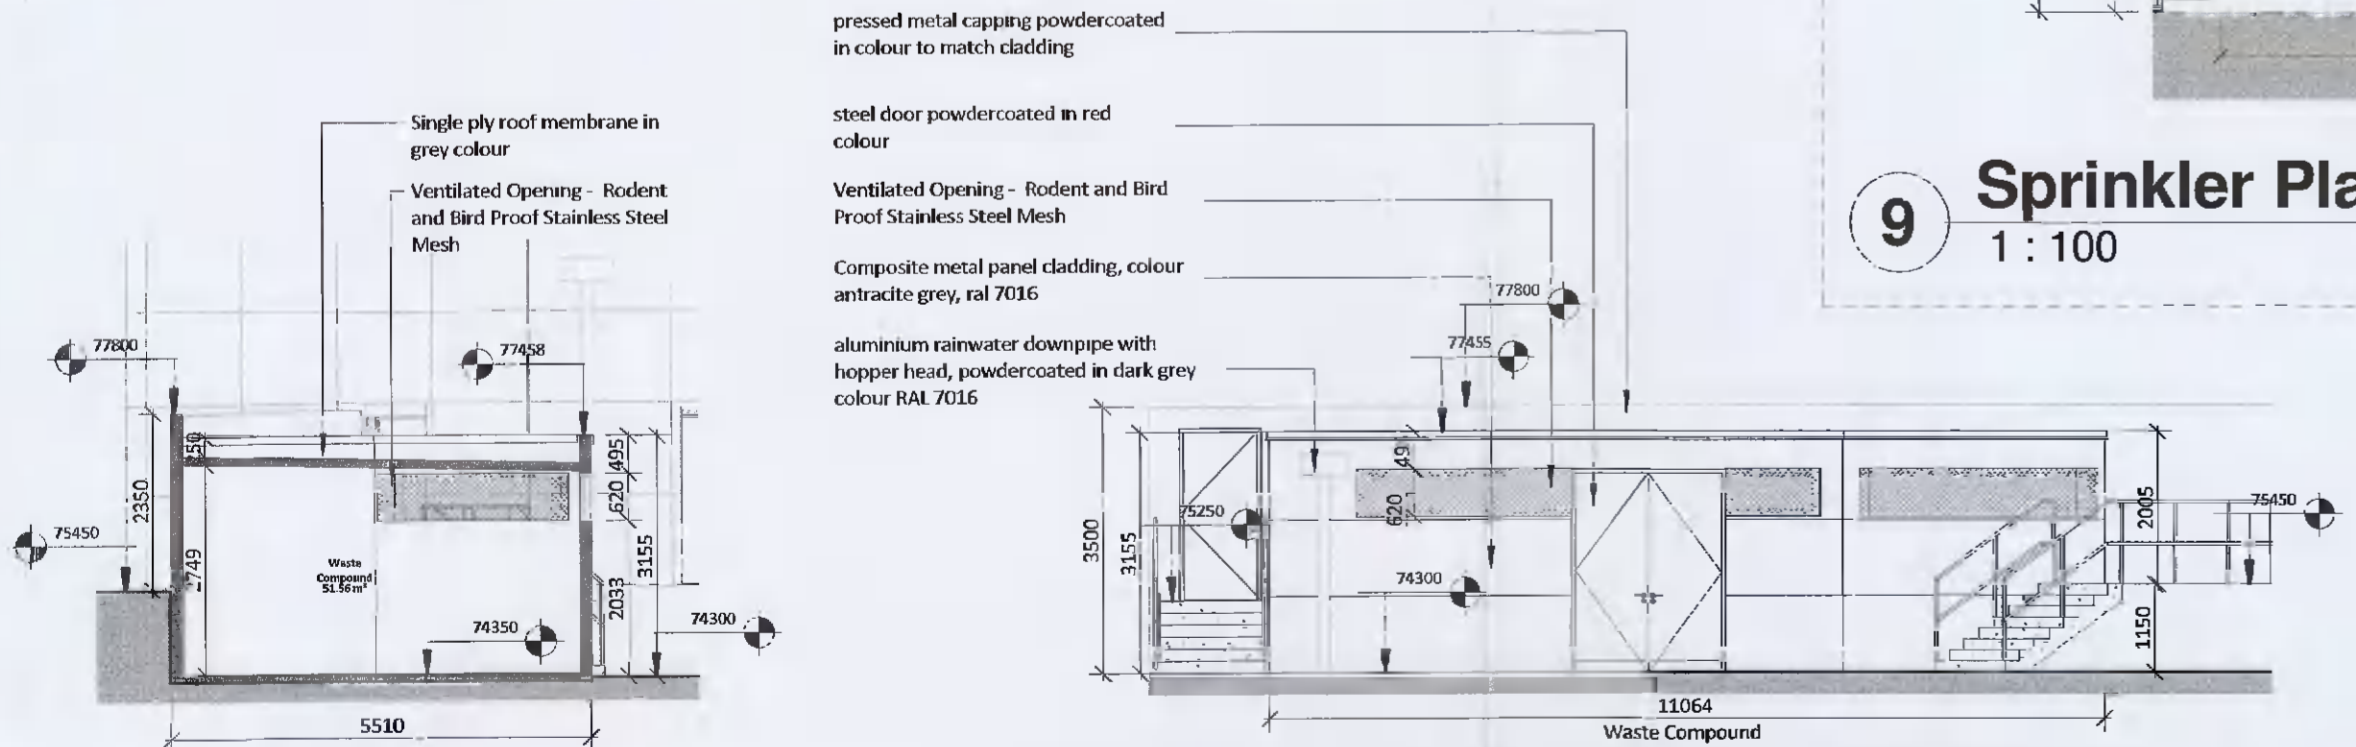


3 Waste Compound Section
1 : 100


4 Waste Compound - South Elevation
1 : 100

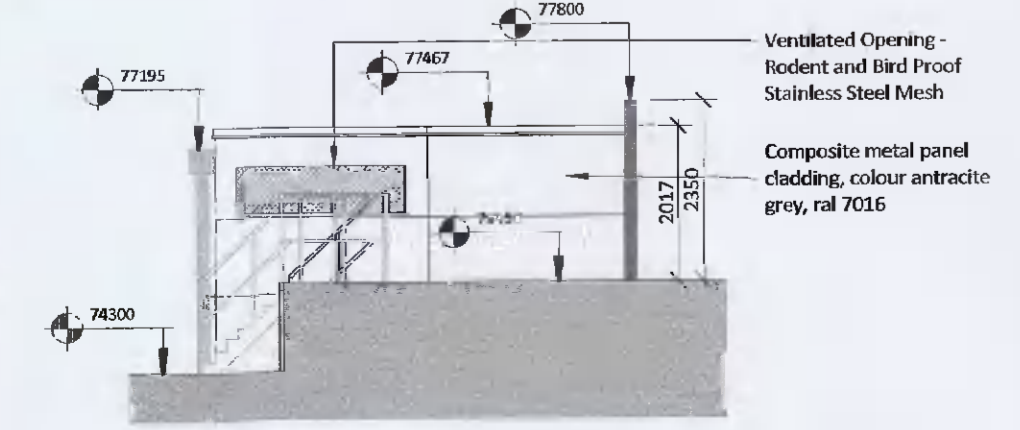


5 Waste Compound - East Elevation
1 : 100

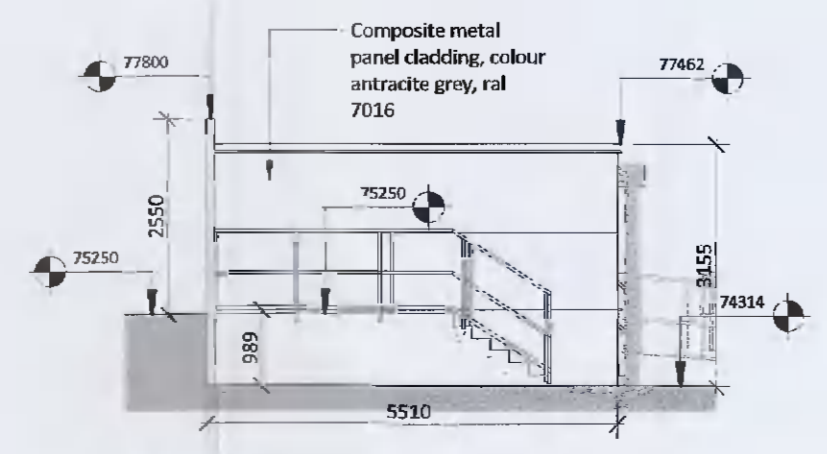


6 Waste Compound - West Elevation
1 : 100

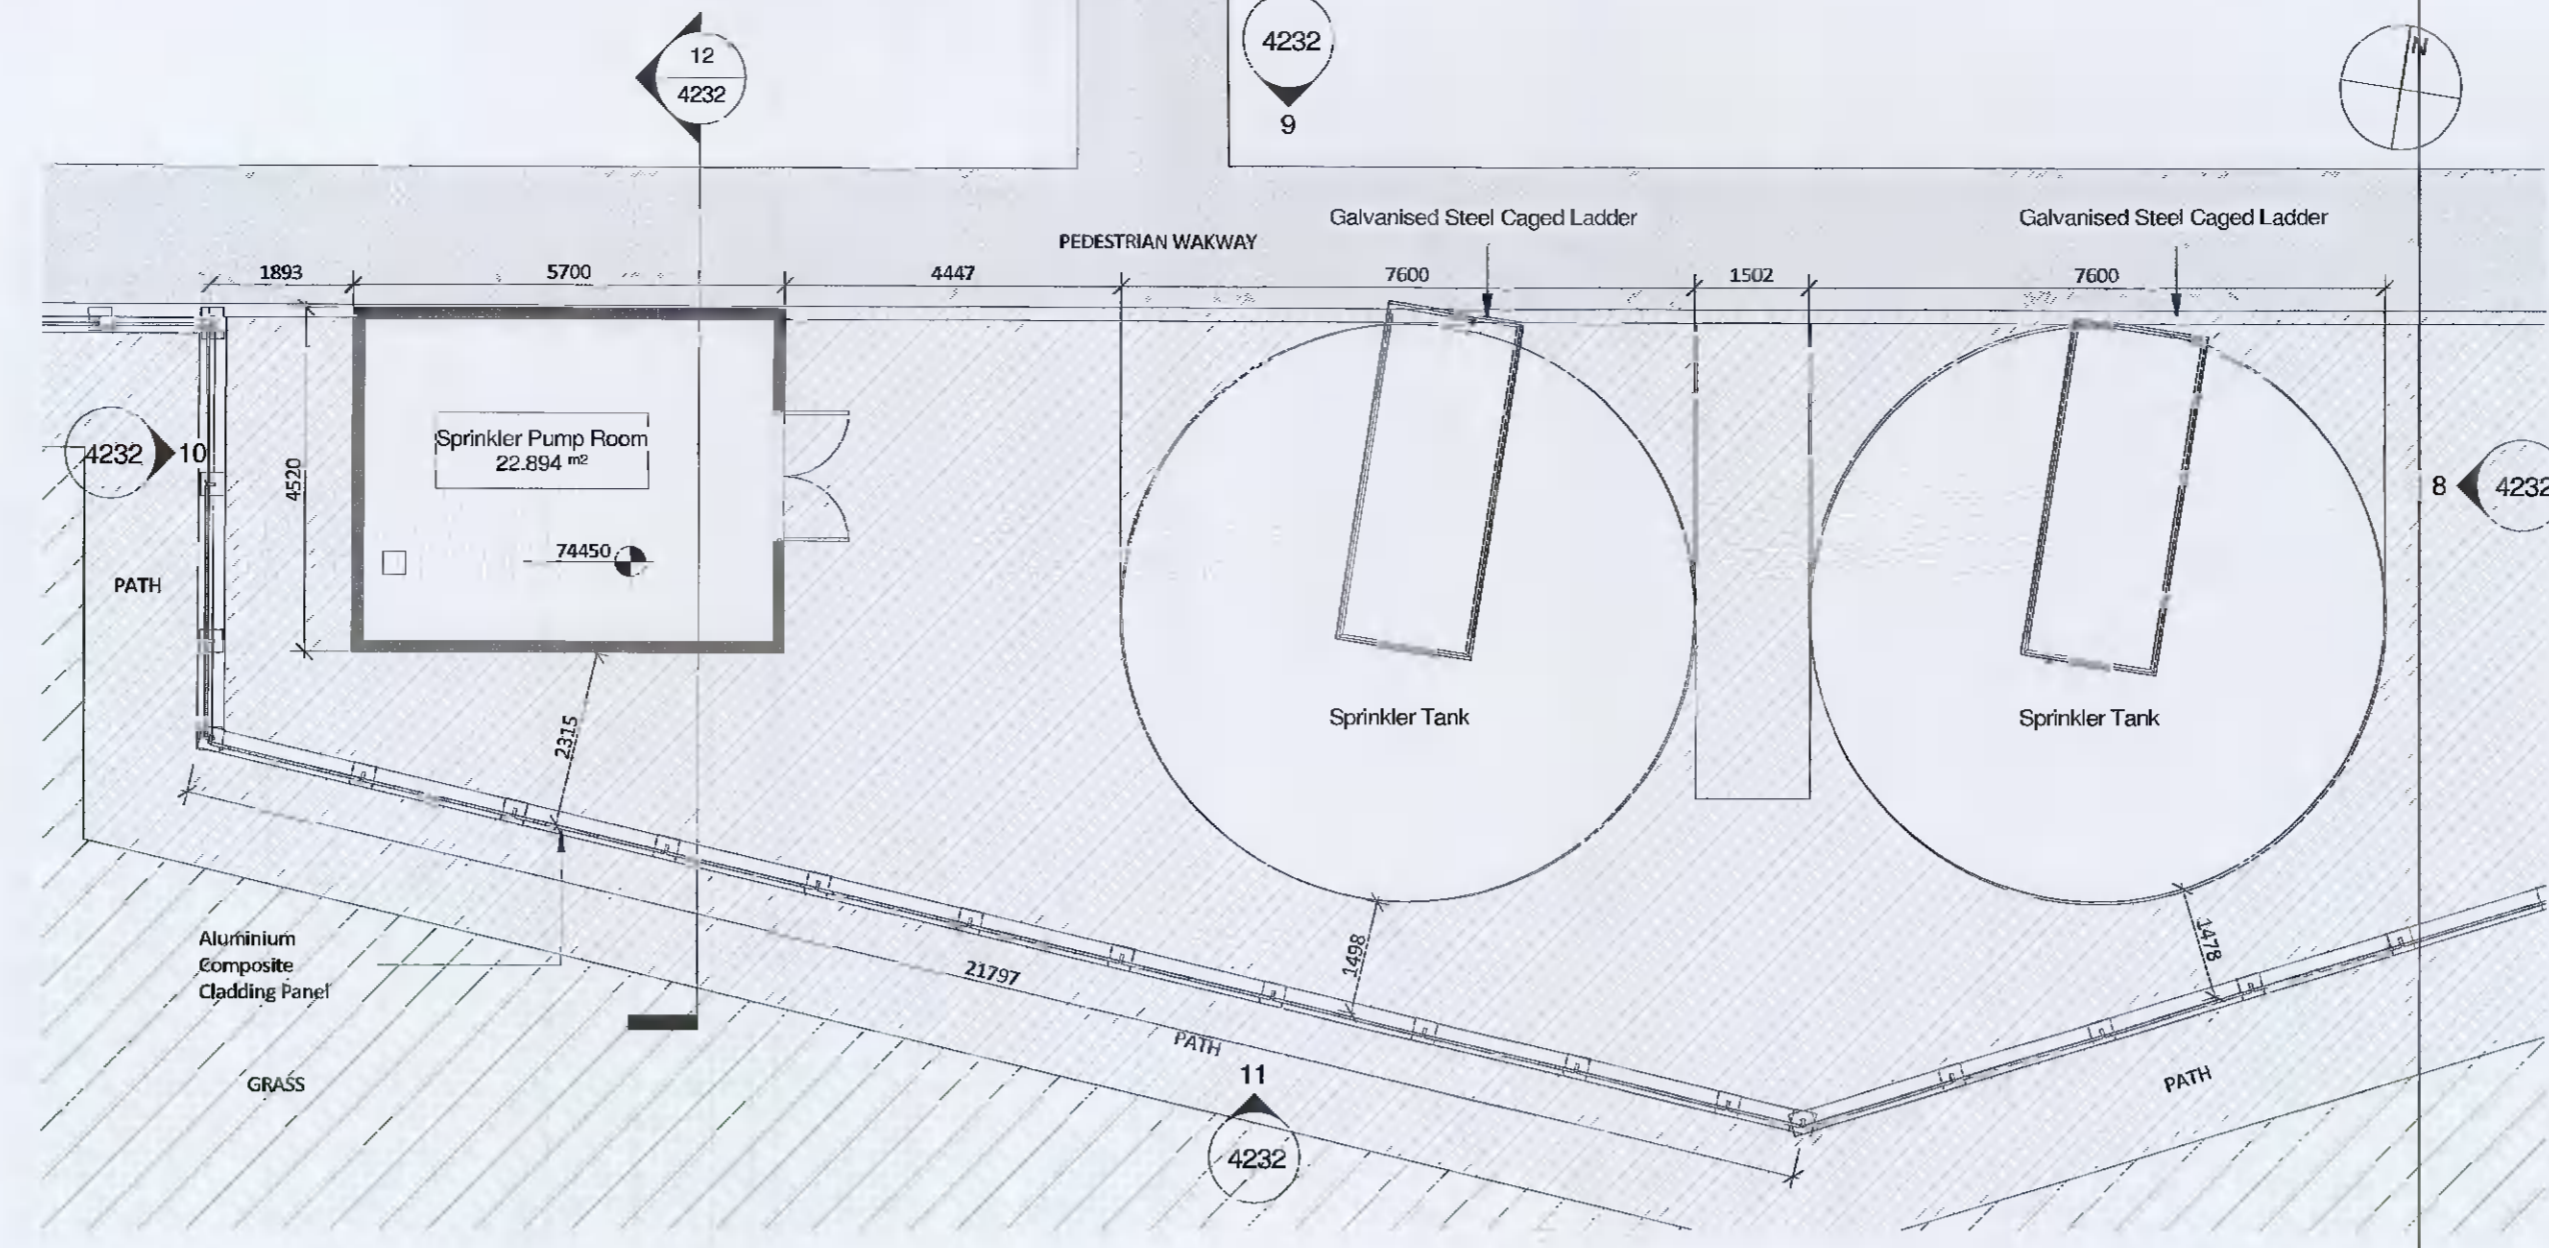


7 Sprinkler Pump Room Plan
1 : 100

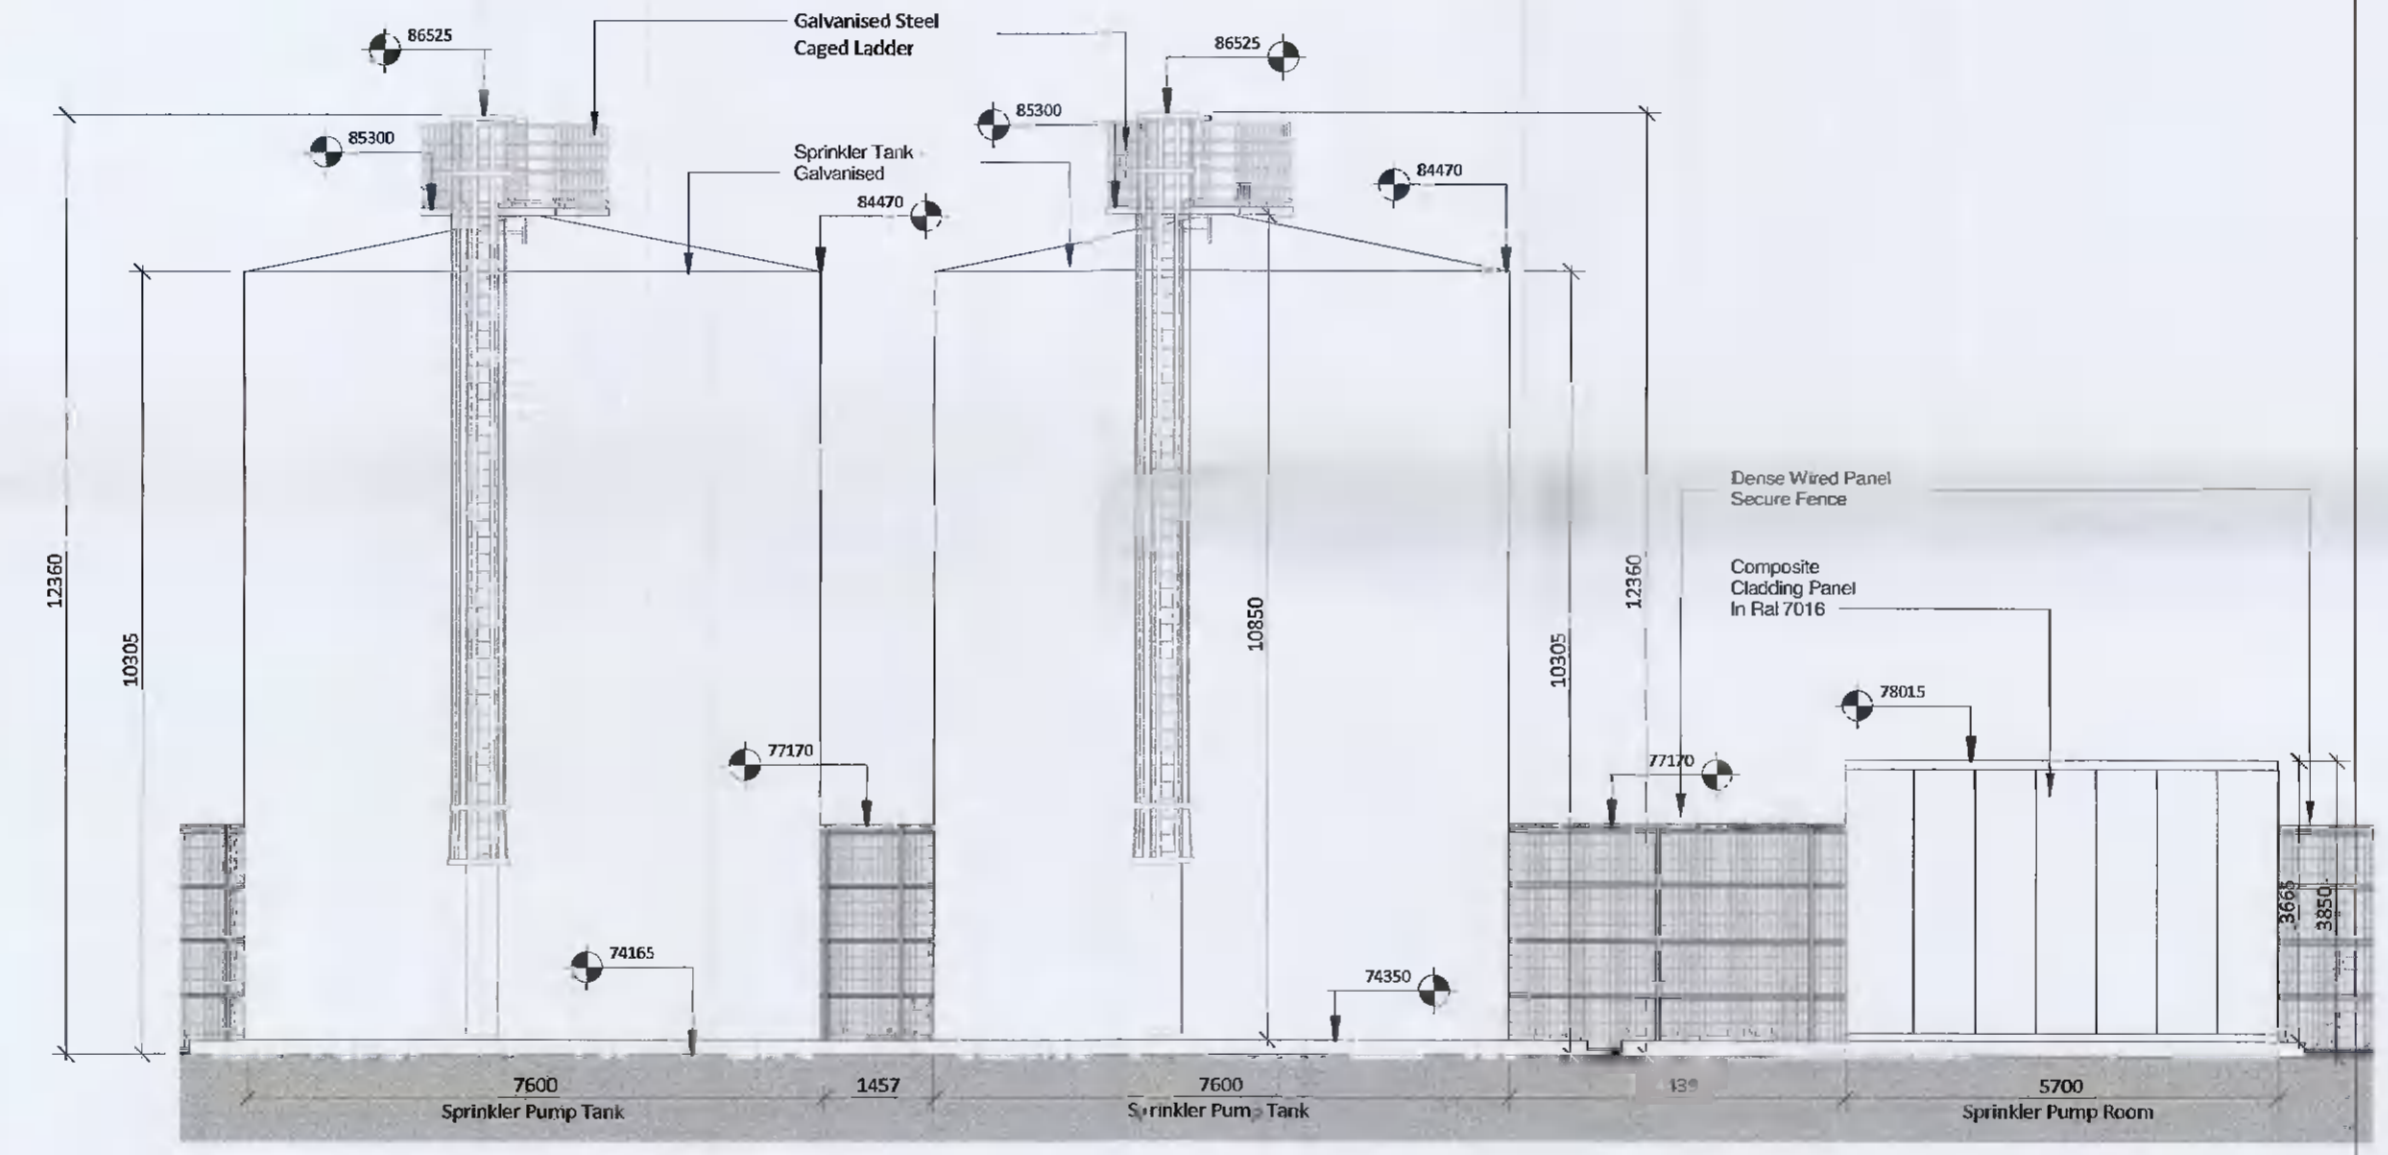


9 Sprinkler Plant - North Elevation
1 : 100

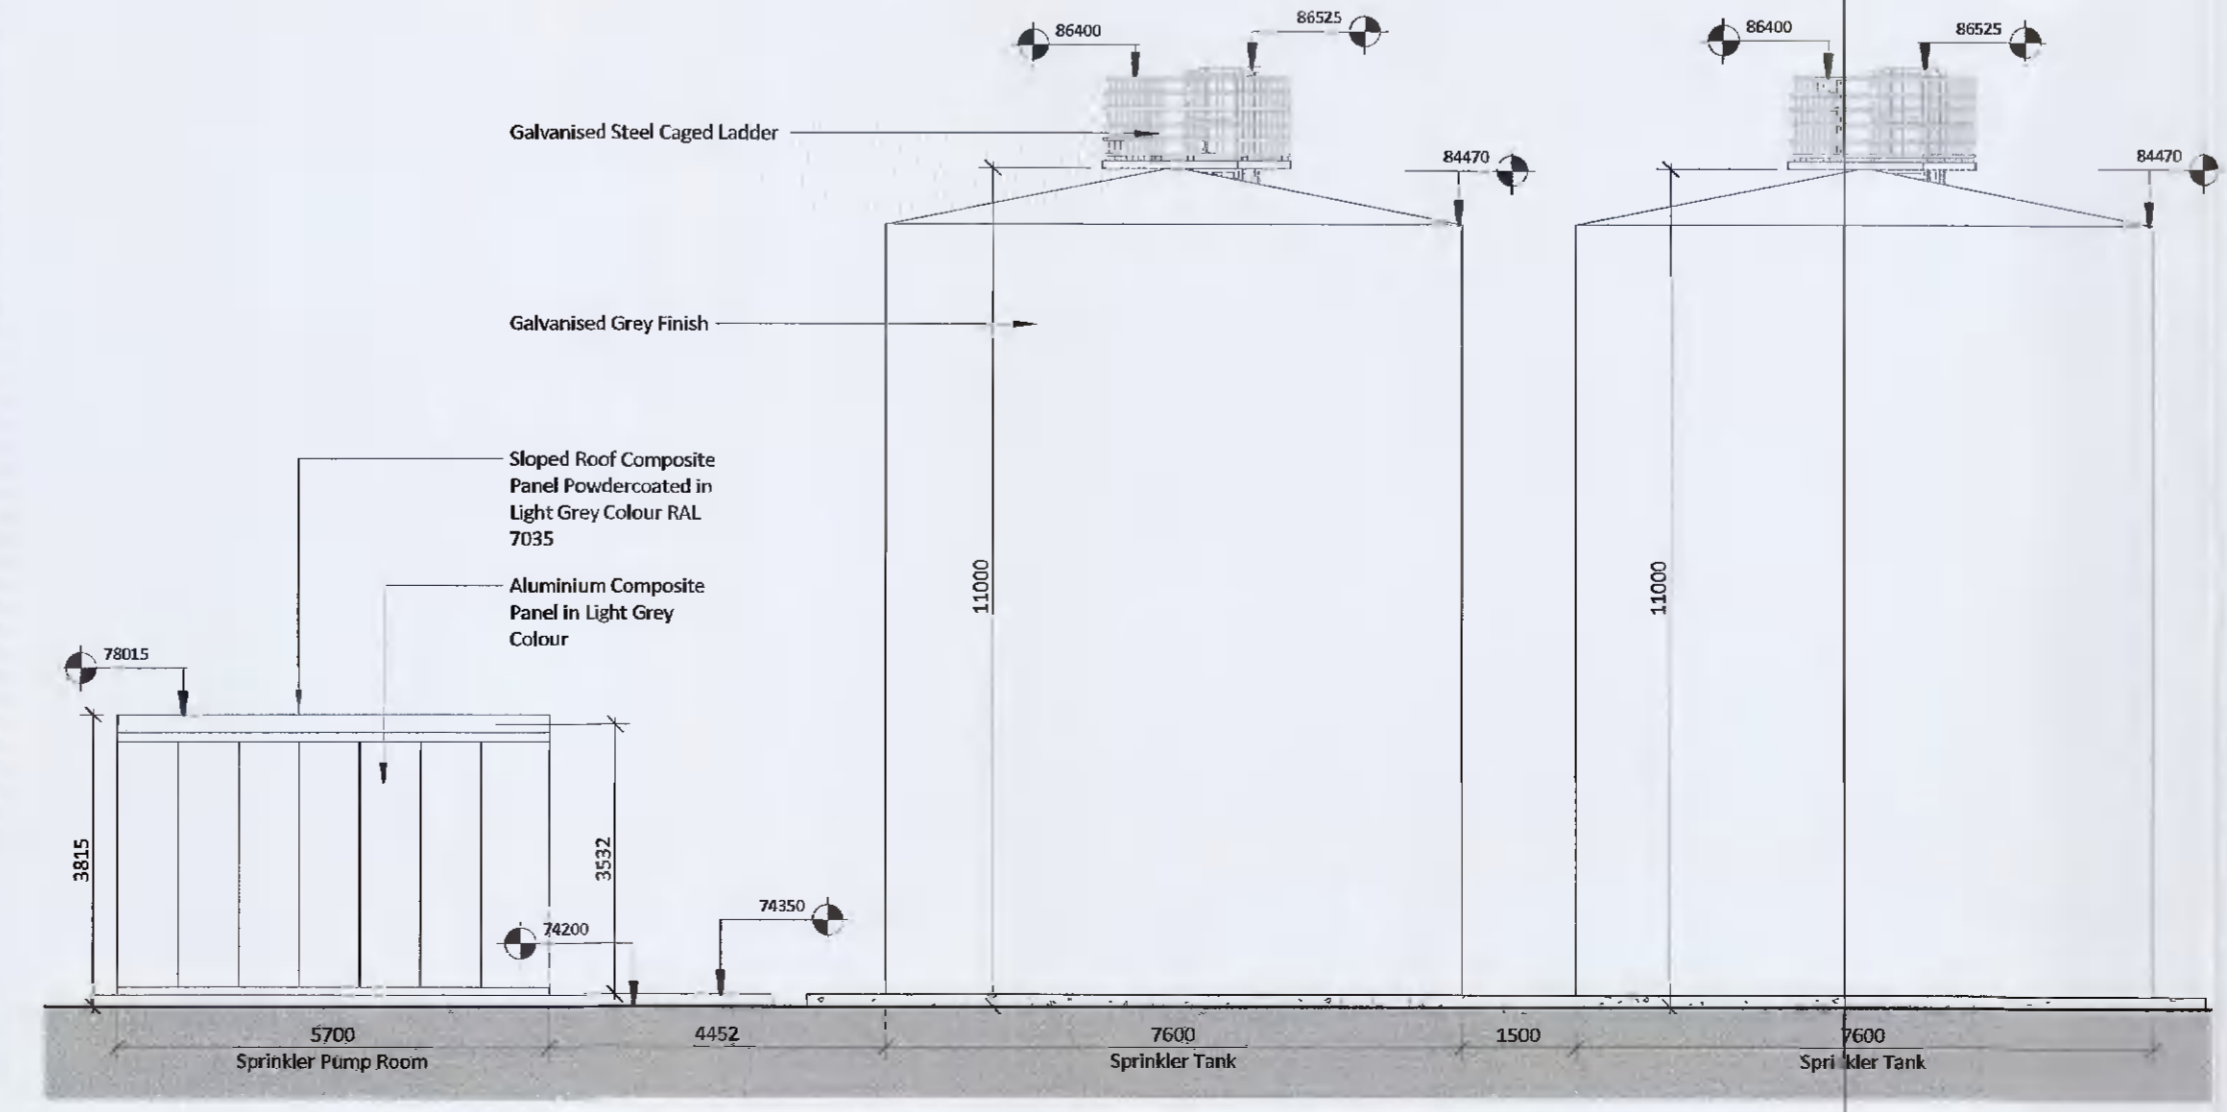


11 Sprinkler Plant - South Elevation
1 : 100

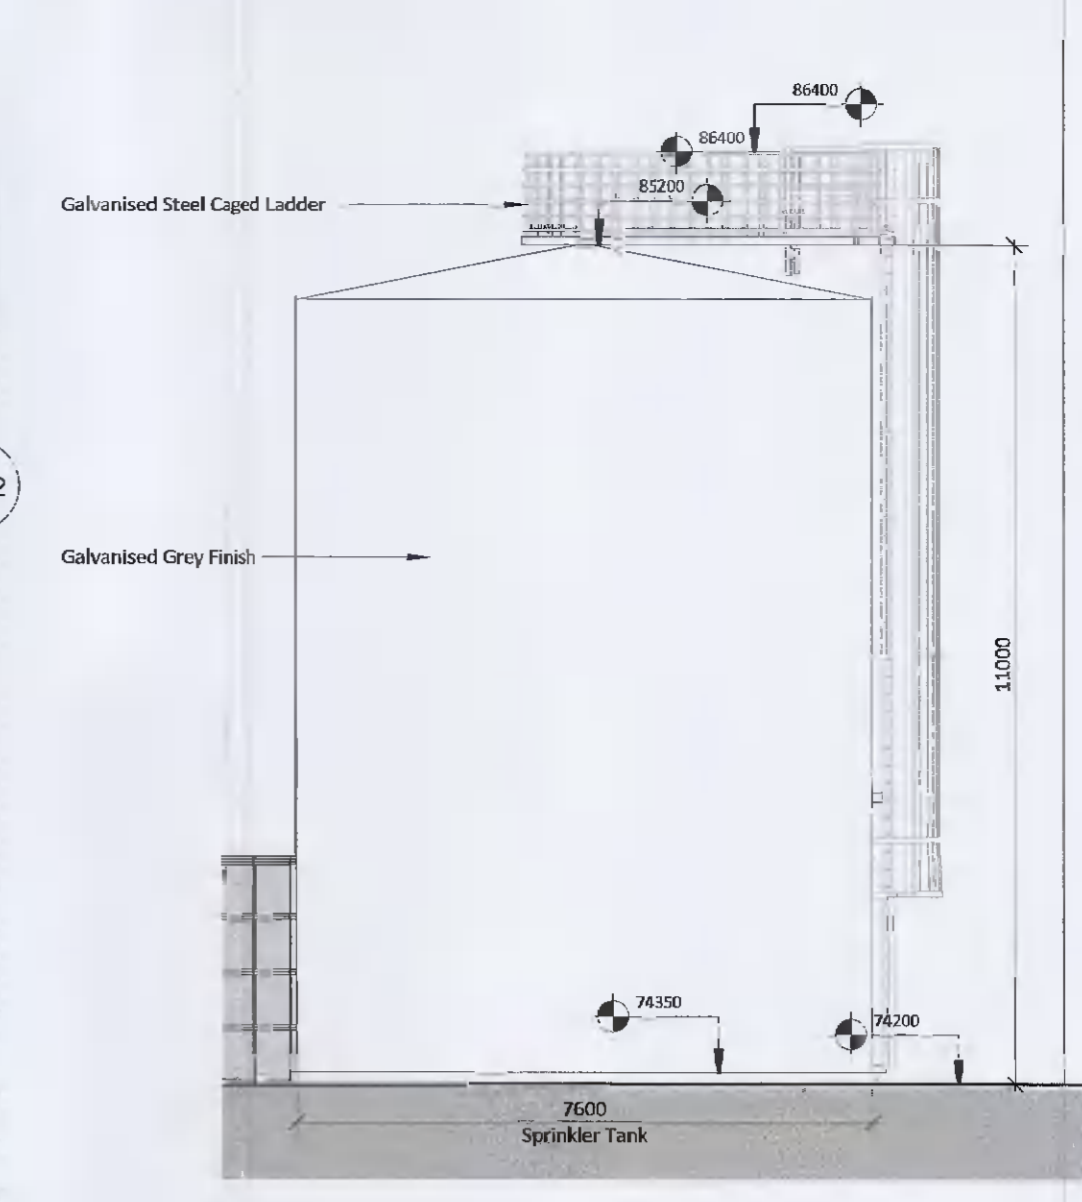

8 Sprinkler Plant - East Elevation
1 : 100

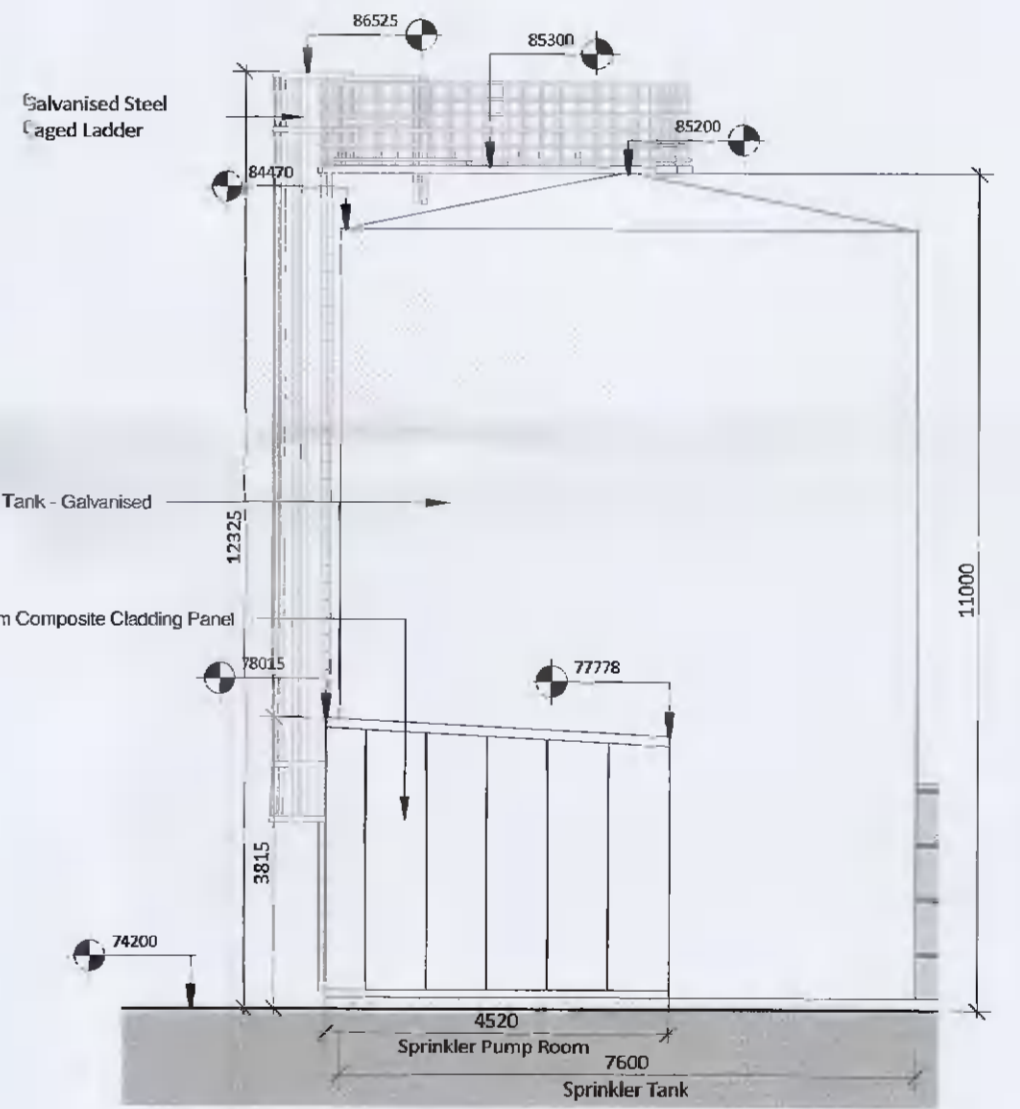

10 Sprinkler Plant - West Elevation
1 : 100

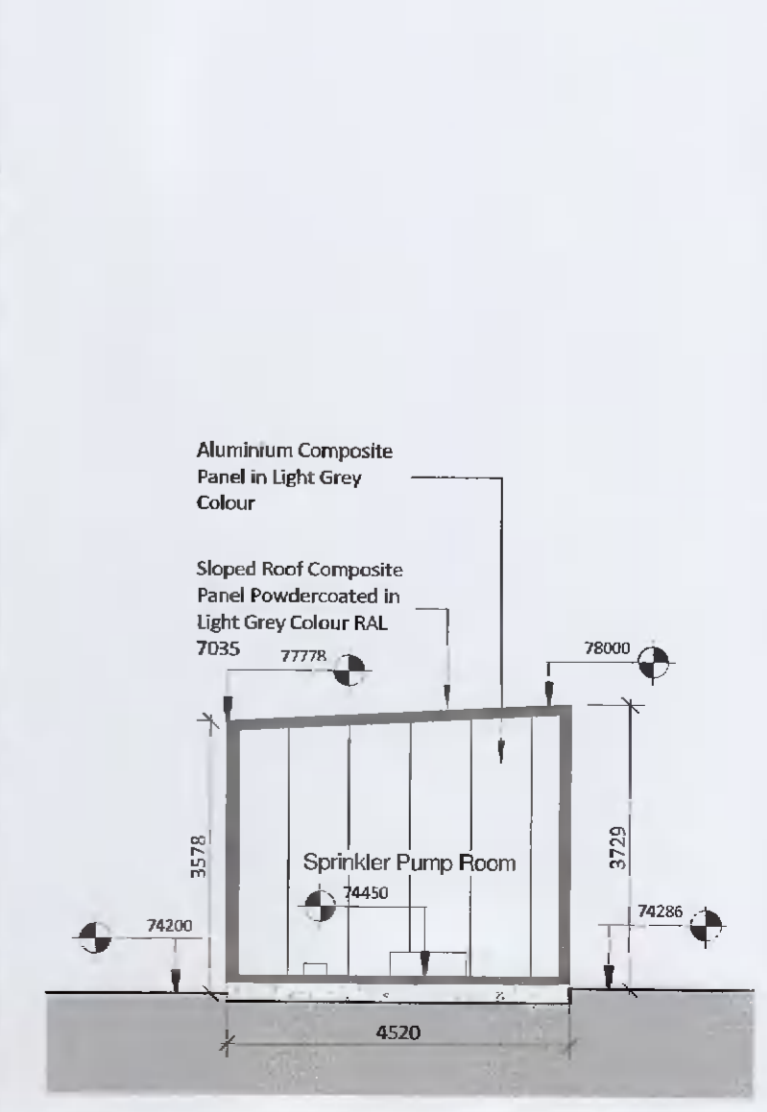

12 Sprinkler Plant - Section
1 : 100

Client: **EQUINIX**

HAZARD IDENTIFICATION LEGEND:

| HAZARD IDENTIFICATION (if none state 'none relevant') | CONTROL AND MITIGATION MEASURES |
|---|---------------------------------|
| | |

NOTE:
Hazards listed above are only those considered significant risks and:
a) not likely to be obvious to a competent contractor or other designers;
b) unusual; or
c) likely to be difficult to manage effectively

| REV | DATE | DESCRIPTION | DWN | CHK | APP |
|-----|------------|---------------------|-----|-----|-----|
| P01 | 2021-06-16 | Issued for Planning | NC | MB | JS |

Key:

Project: DB8 - Equinix

Drawing Title: Proposed Ancillary Buildings - Waste Compound, Sprinkler Water Compound - Pump Room

Drawing Number: DB080-RKD-ZZ-XX-DR-A-ZZZZ-4232

Scale: 1:100 Paper Size: A1 Purpose: S4 Revision: P01