

Client:



# EQUINIX

## HAZARD IDENTIFICATION LEGEND:

HAZARD IDENTIFICATION	CONTROL AND MITIGATION MEASURES
(if there is a note relevant)	





**NOTE:**  
 Hazards listed above are only those considered significant risks and:

- not likely to be obvious to a competent contractor or other person;
- unlikely to be avoided, or
- likely to be difficult to manage effectively.

Fixed dimensions only are to be taken from this drawing. All dimensions are to be checked on site before any work is put in hand.

### NOTES

- The installation and design shall comply with all Regulations.
- The drawing shall be read in conjunction with all associated equipment schedules and mechanical, electrical, structural and architectural drawings.

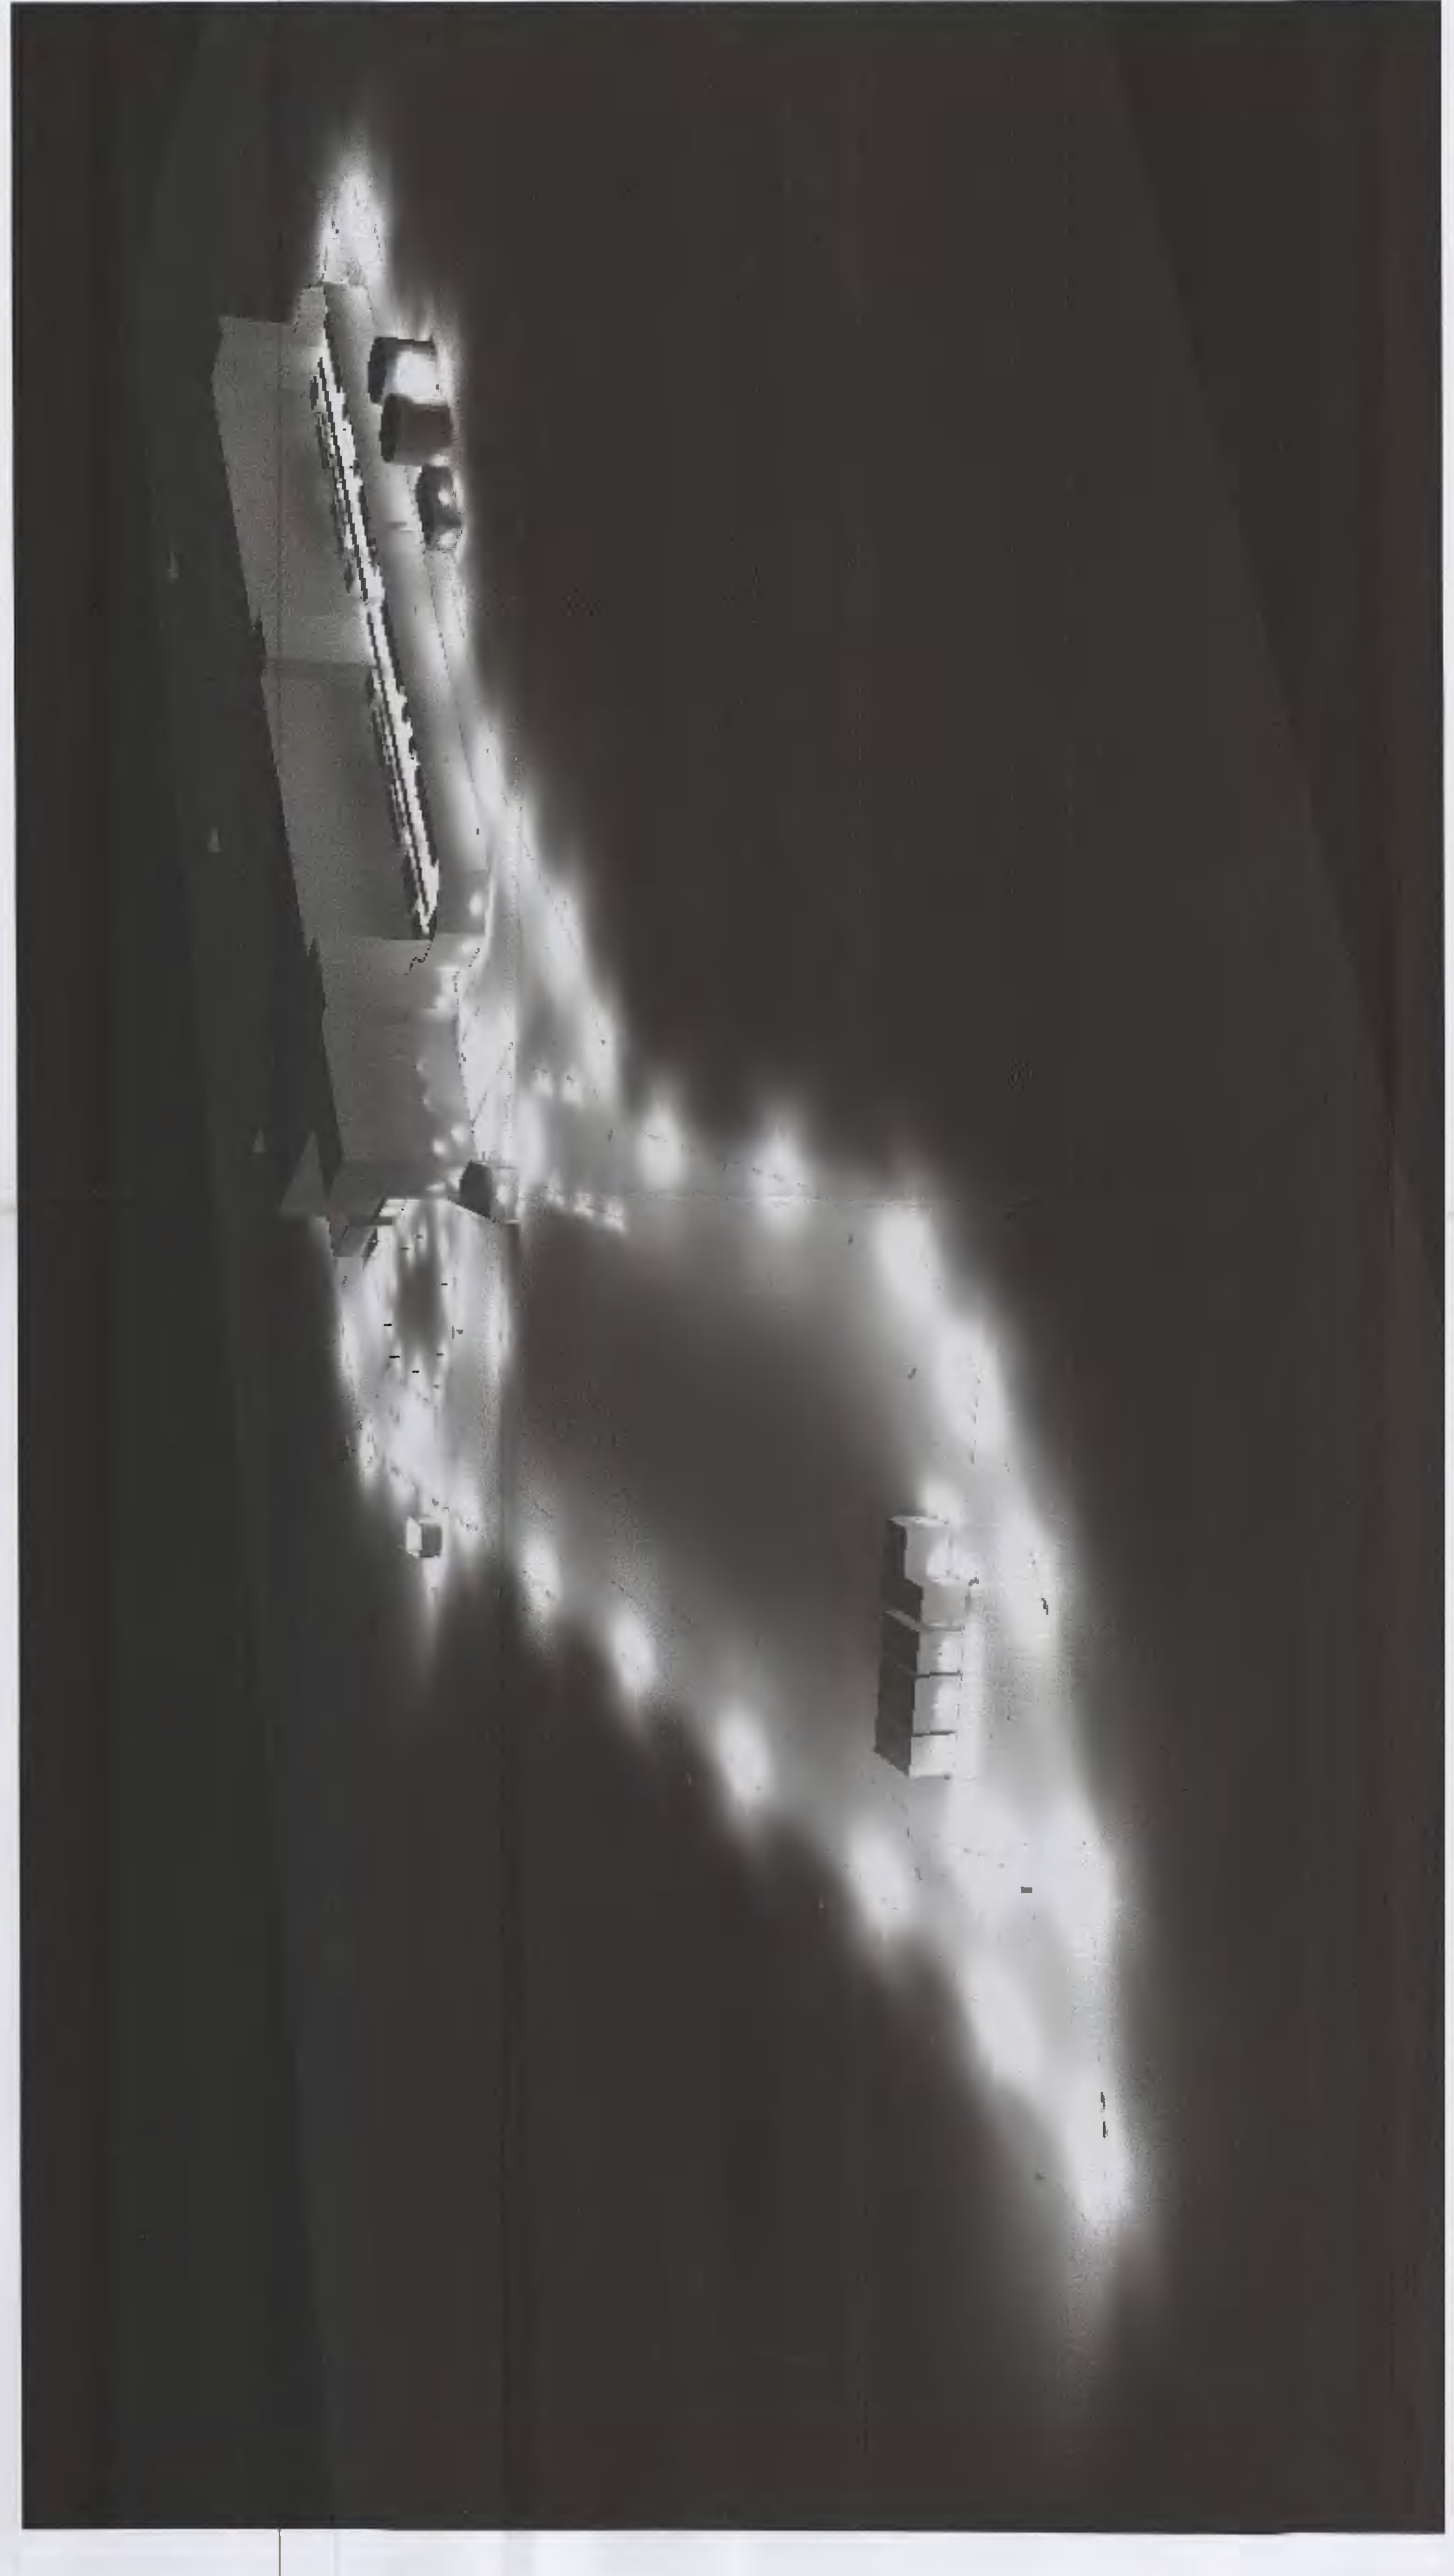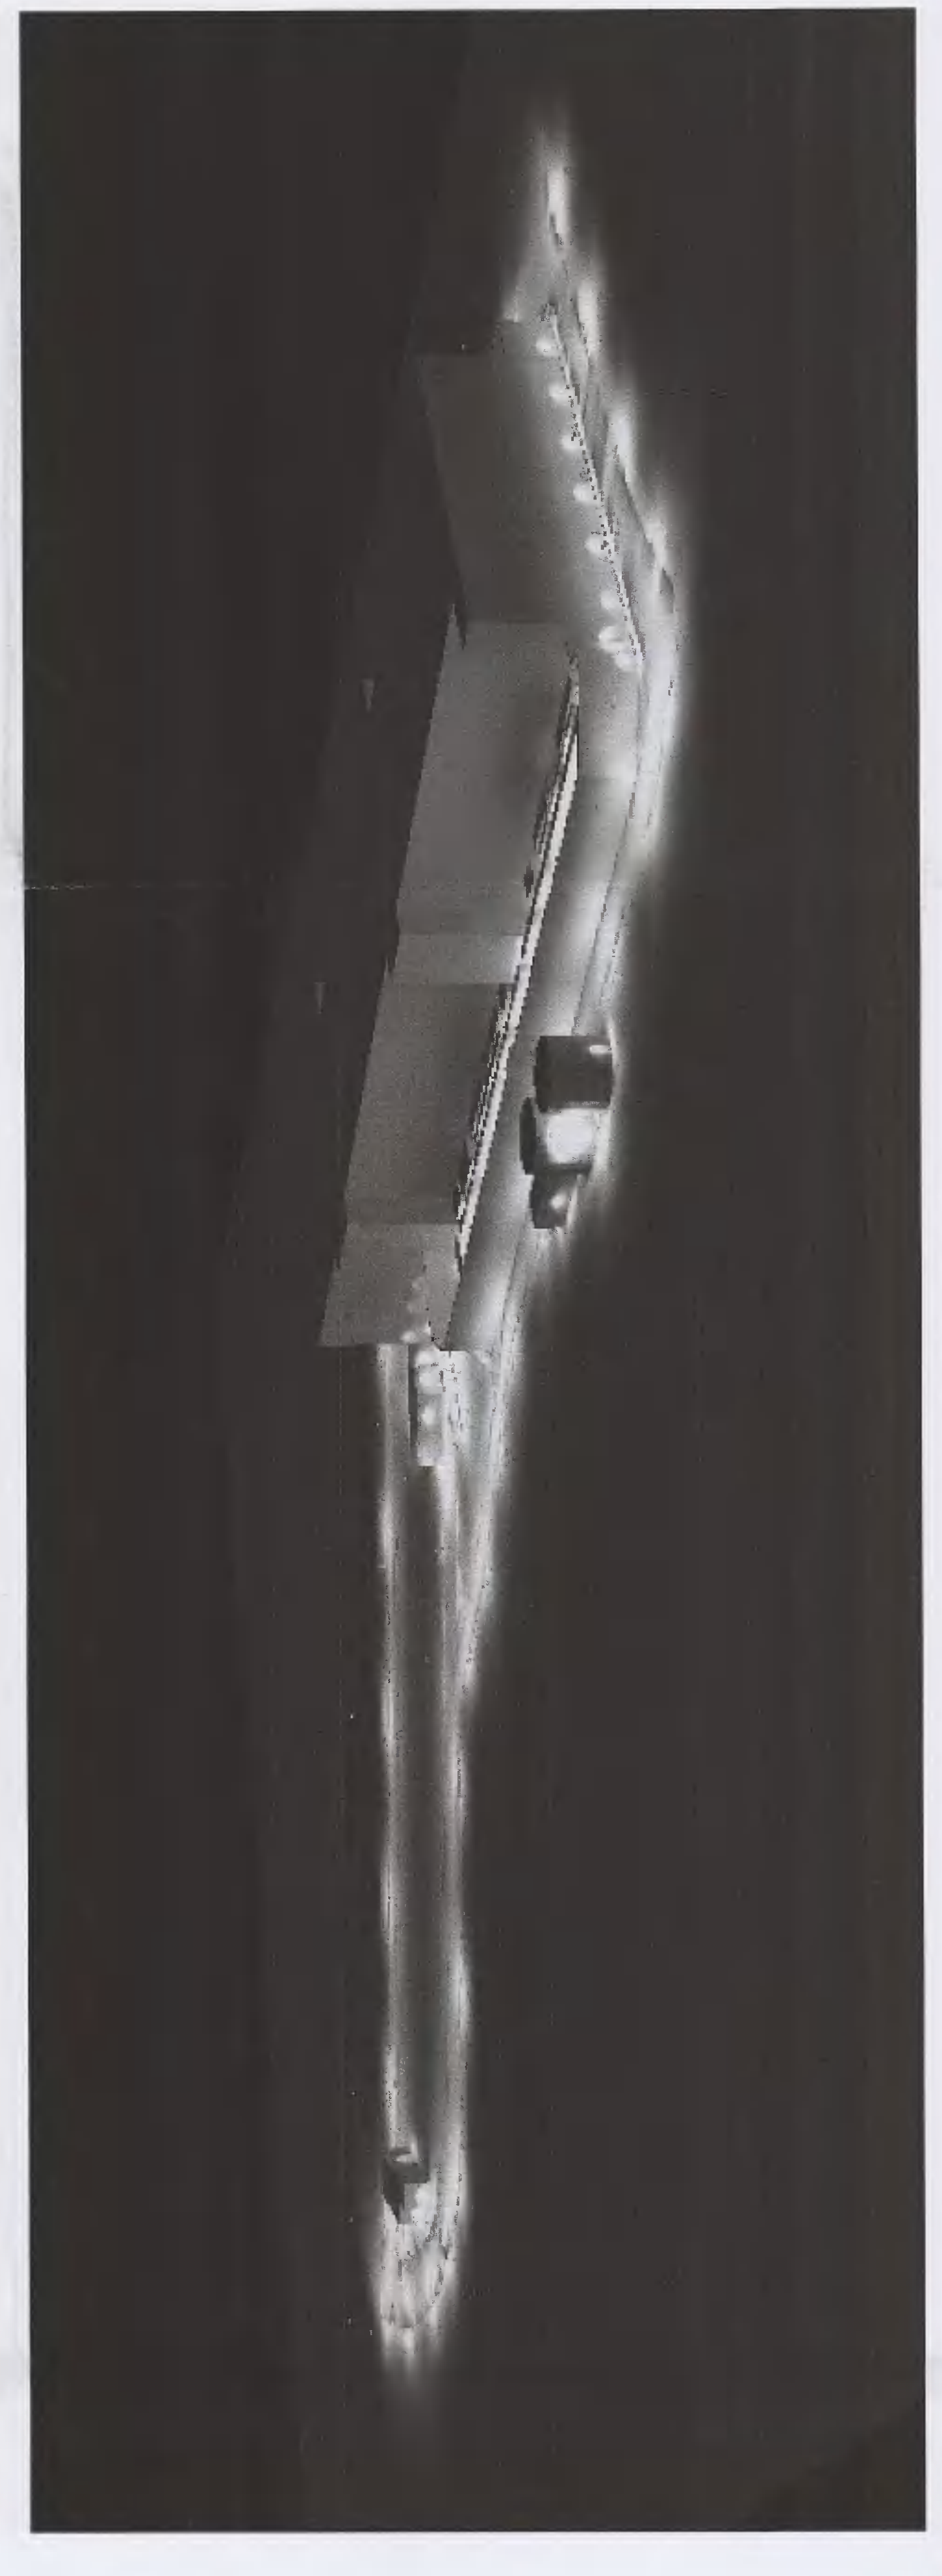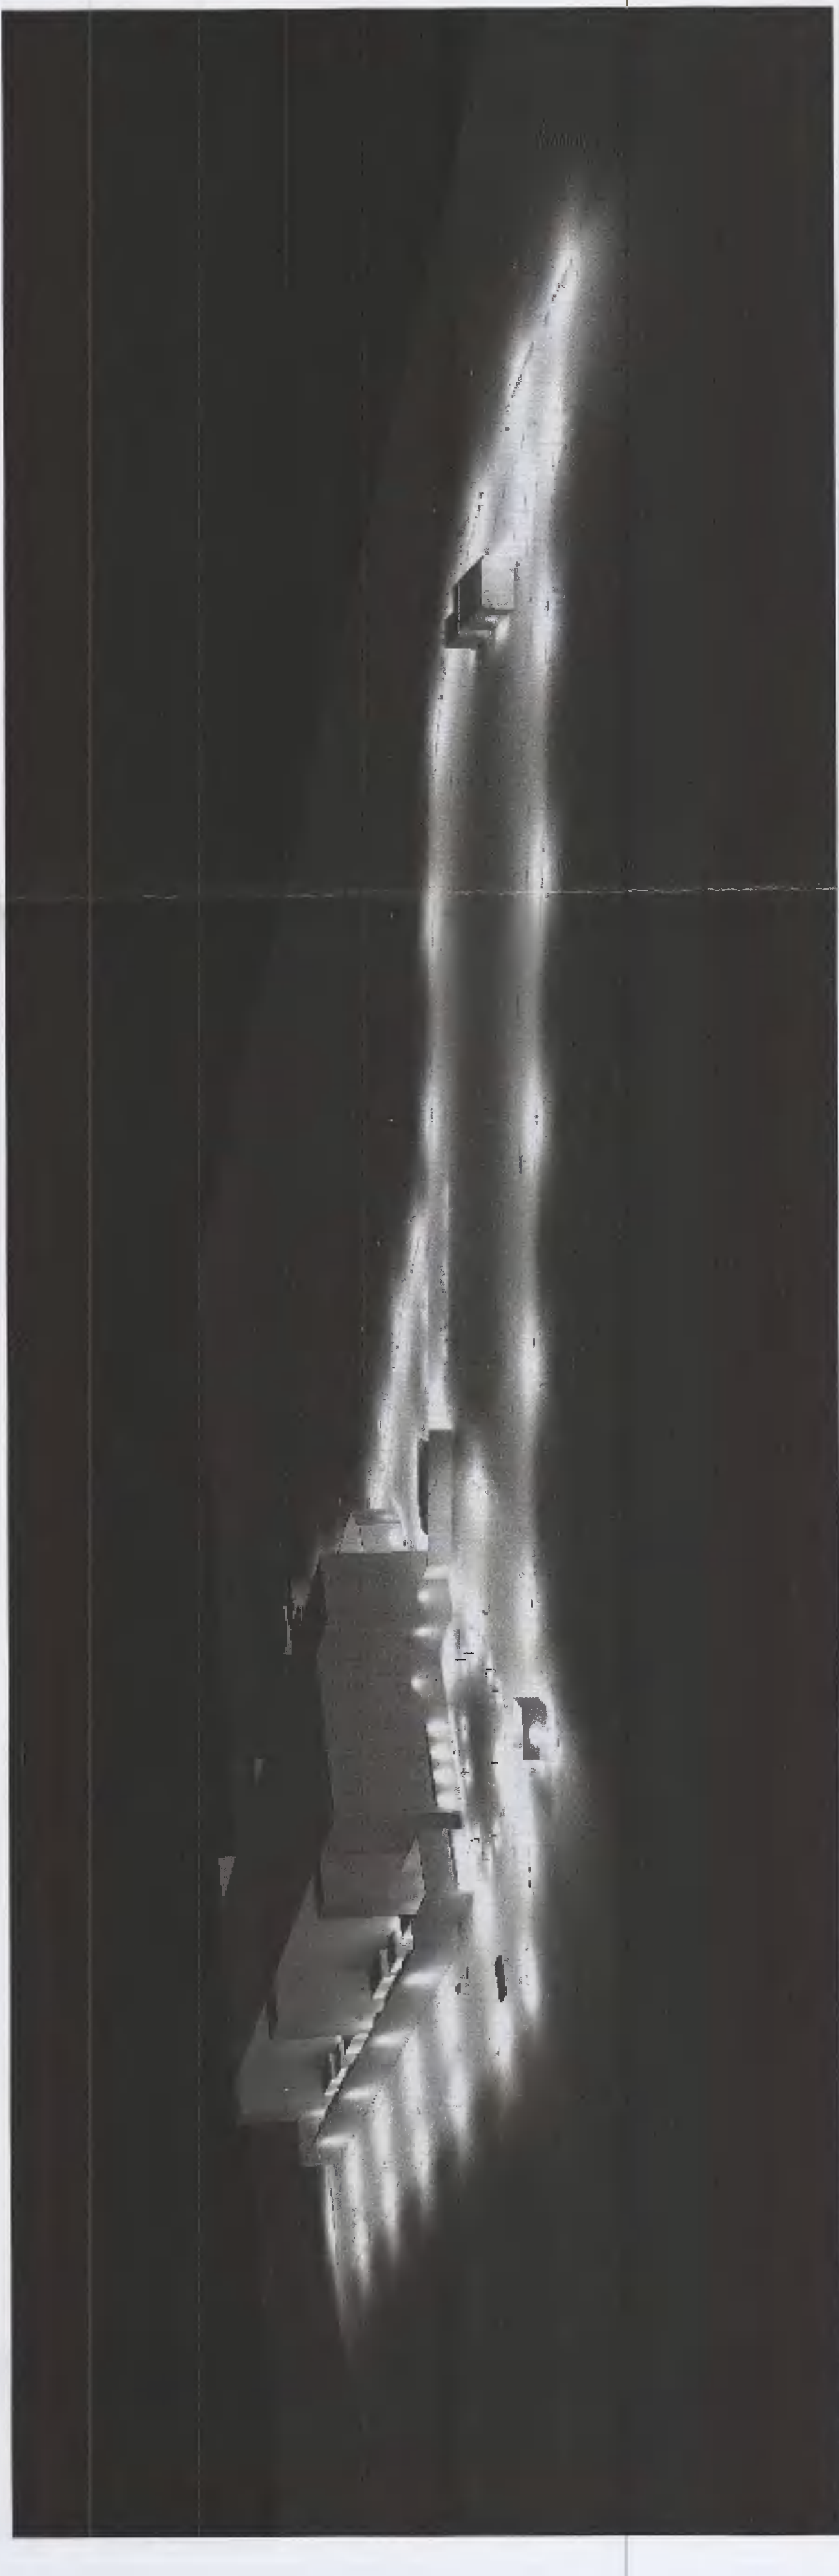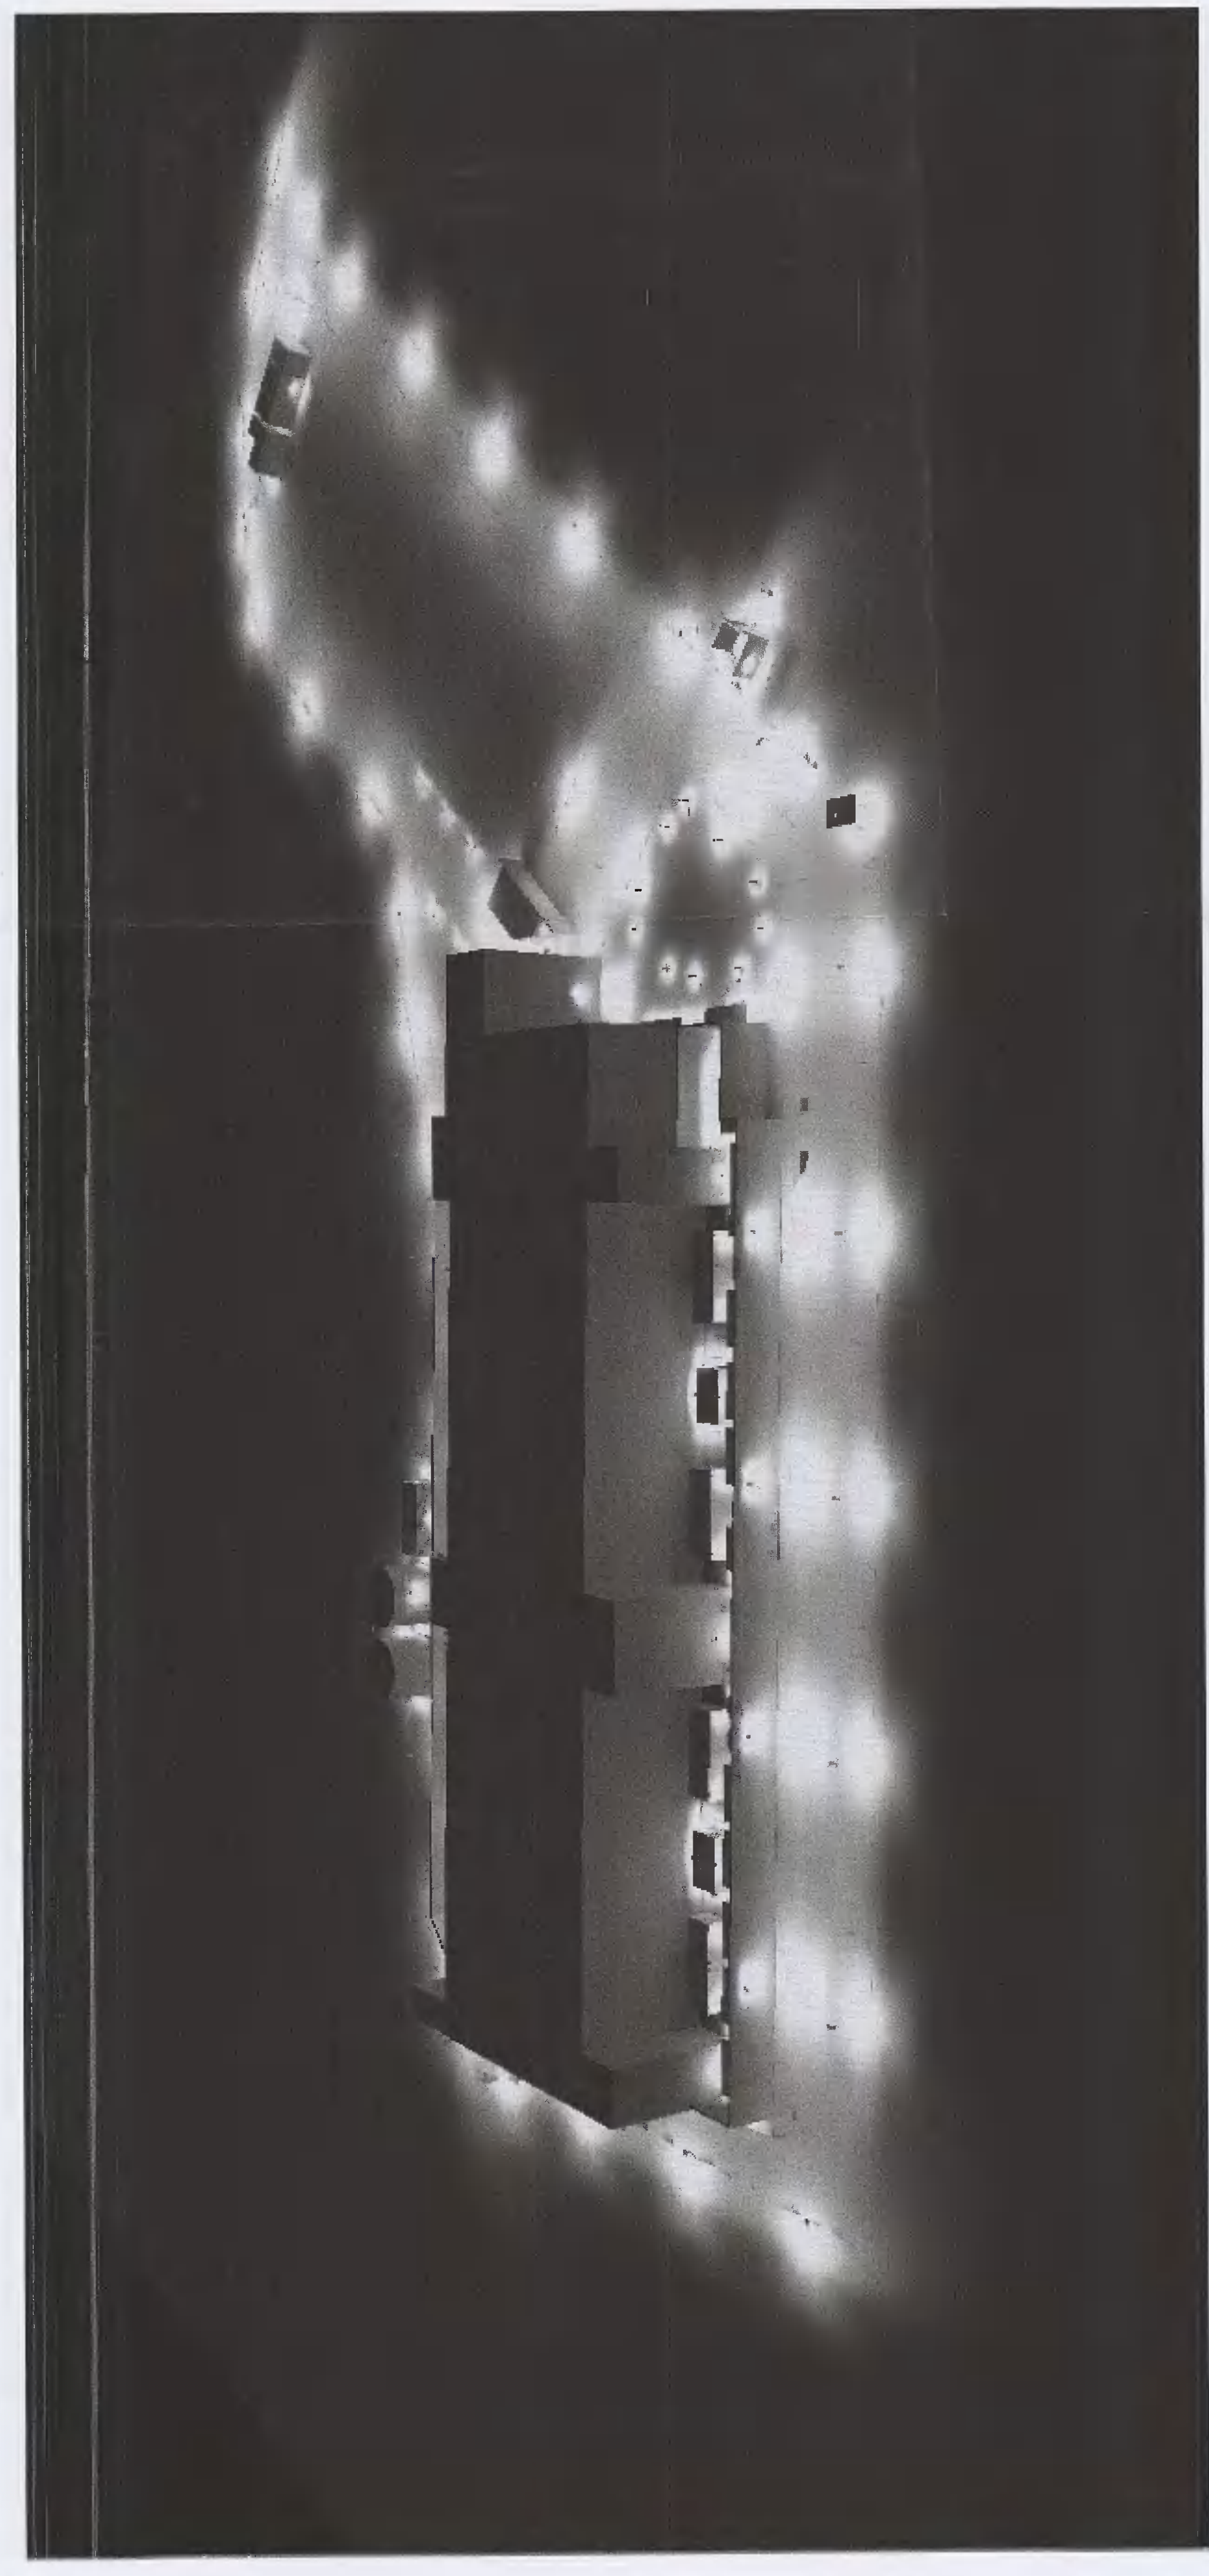

REV	DATE	DESCRIPTION	ISSUED BY	CHKD BY

Key:

Project: EQUINIX DB080  
 Drawing Title: EXTERNAL LIGHTING LAYOUT - PHASE 1 VISUAL PRESENTATION OF PROPOSED MODEL  
 Drawing Number: DB080-RED-ZZ-06-DR-LITE-1026  
 Scale: NTS Paper Size: A0 Purpose: Revision: S3 P01

