



1. Figured Dimensions Only to be Taken from this Drawing. All Dimensions to be Checked on Site.
2. This drawing to be read in conjunction with all other Architectural & Engineering drawings & all other relevant drawings & Specification.

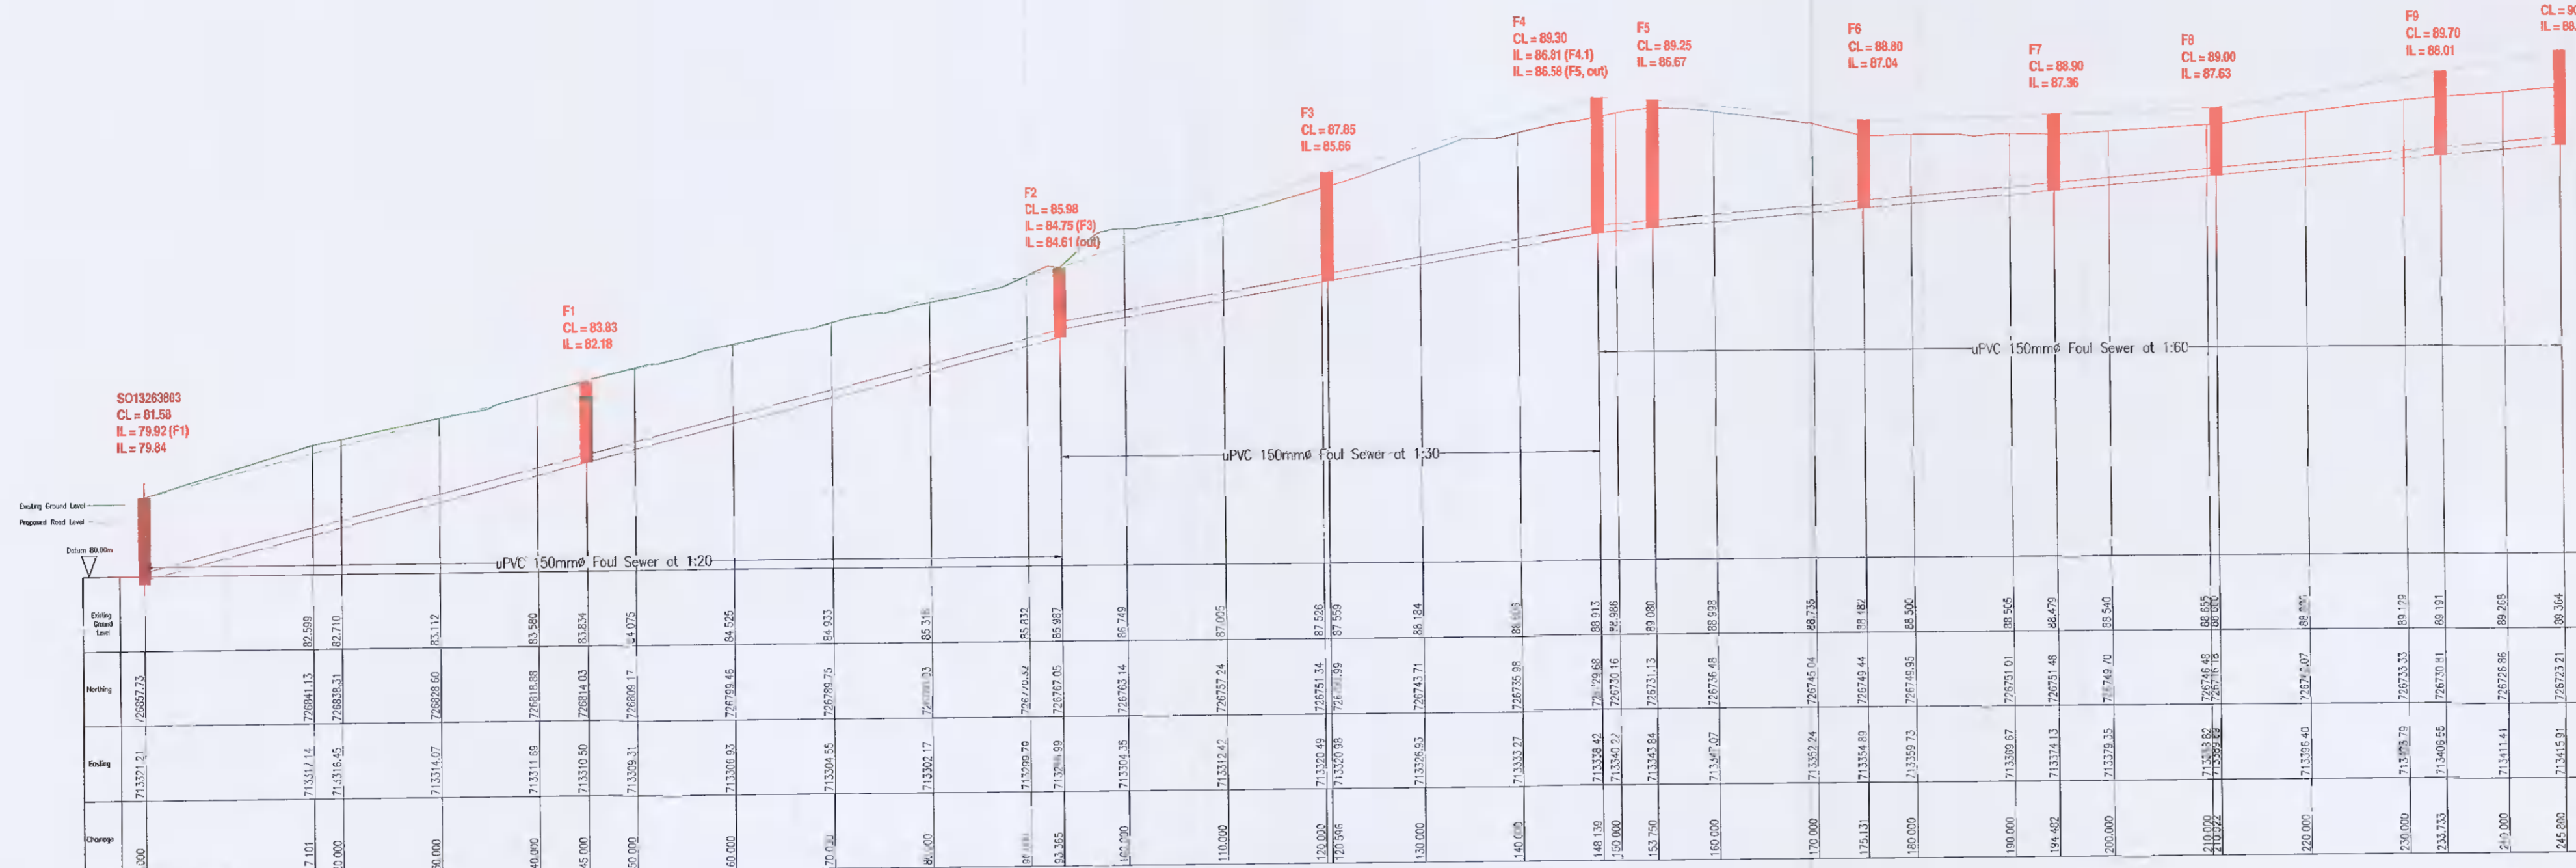

FOUL SEWER F1 TO F9 LONGITUDINAL SECTION
Scale 1:500 Horizontal, 1:100 Vertical

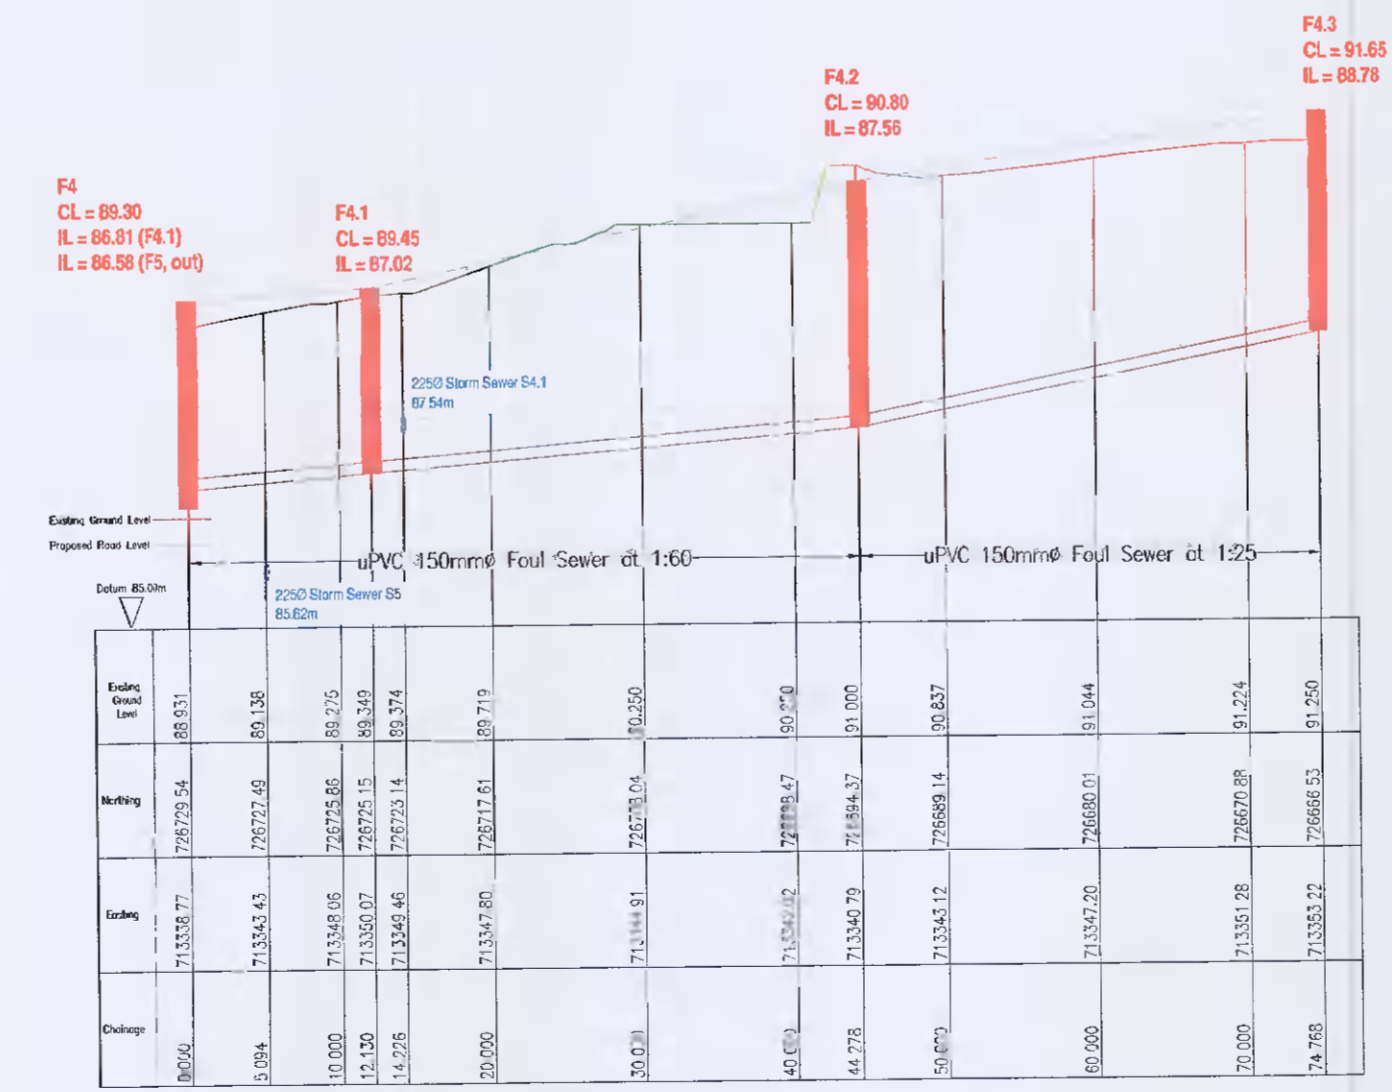

FOUL SEWER F4 TO F4.3 LONGITUDINAL SECTION
Scale 1:500 Horizontal, 1:100 Vertical



OS Ordnance Survey Ireland License No EN0084121
© Ordnance Survey Ireland & Government of Ireland

Rev	Date	By	Reason
1	16/12/20	ML	Foul drainage layout revised

Status
FOR PLANNING

Client / Architect
Ms Brenda Weir

Project
Rookwood, Ballyboden

Drawing Title
Proposed Foul Drainage Longitudinal Sections

THIS DOCUMENT IS THE PROPERTY OF GORDON WHITE CONSULTING ENGINEERS. THE DESIGN INFORMATION CONTAINED HEREIN IS SOLELY FOR THE USE OF THE CLIENT AND IS NOT TO BE REPRODUCED, COPIED, OR CIRCULATED IN WHOLE OR IN PART WITHOUT THE WRITTEN PERMISSION IN EXCESS OF GORDON WHITE CONSULTING ENGINEERS.
© PROPERTY OF GORDON WHITE CONSULTING ENGINEERS

GORDON WHITE
CONSULTING ENGINEERS
1st Floor, 8 Riverwalk, Lake Drive,
Citywest Business Campus,
Dublin 24, D24 V6CF
Tel: (01) 479 6396 Mobile: (086) 230 6216
e-mail: mail@gwce.ie web: www.gwce.ie

Drawn By	ML	Scale	As shown
Latest Rev. by	ML	Date	20 Nov. '20
Eng. No.	G1162-21		B