


Approvals:

Client: Microsoft
 Microsoft Ireland
 Microsoft Ireland Engineer: David O'Donnell
 Microsoft Ireland Engineer: Alan Malyon
 Microsoft Ireland Engineer: Alan Malyon
 Electrical Manager: David O'Donnell
 Project Manager: Michael O'Donnell
 Designer: Alan Malyon

General Notes:

- This is not an installation drawing and shows the proposed locations of equipment only.
- All dimensions are in millimetres (mm) unless noted otherwise.
- Do not scale. Work to figured dimensions only.
- Check all dimensions against the approved building services documents and other relevant contract documents.
- Contractors should ensure that all proposed equipment is installed in accordance with the given constraints and load information will be provided for the equipment.
- All services crossing the movement joints shall be detailed to accommodate the movement as detailed in the approved drawings.
- Contractors should ensure that the proposed installation drawings meet the requirements of the relevant standards.
- Approval of this drawing is not a guarantee that the proposed installation drawings meet the requirements of the relevant standards.

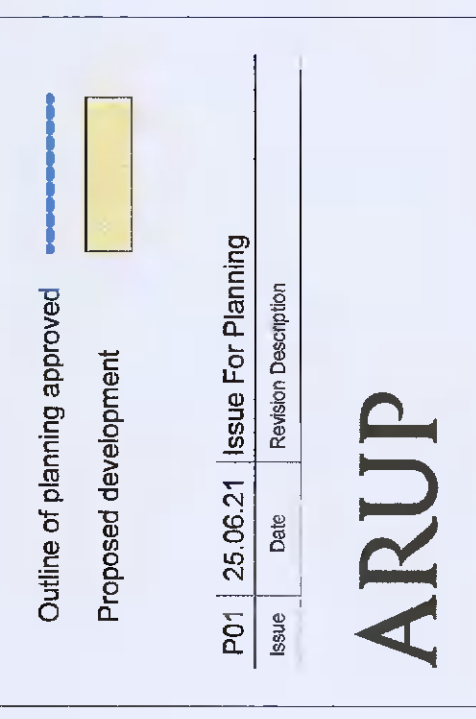


Microsoft

DUB 14/15
 Proposed Modifications to Previously Approved Scheme SD2/04/0263

Plot No.	Area (sqm)	Area (sqft)
11100 01 000	11100 01 000	11100 01 000
11100 02 000	11100 02 000	11100 02 000
11100 03 000	11100 03 000	11100 03 000
11100 04 000	11100 04 000	11100 04 000
11100 05 000	11100 05 000	11100 05 000
11100 06 000	11100 06 000	11100 06 000
11100 07 000	11100 07 000	11100 07 000
11100 08 000	11100 08 000	11100 08 000
11100 09 000	11100 09 000	11100 09 000
11100 10 000	11100 10 000	11100 10 000



2- Plan - Keyplan
 Scale 1:5000

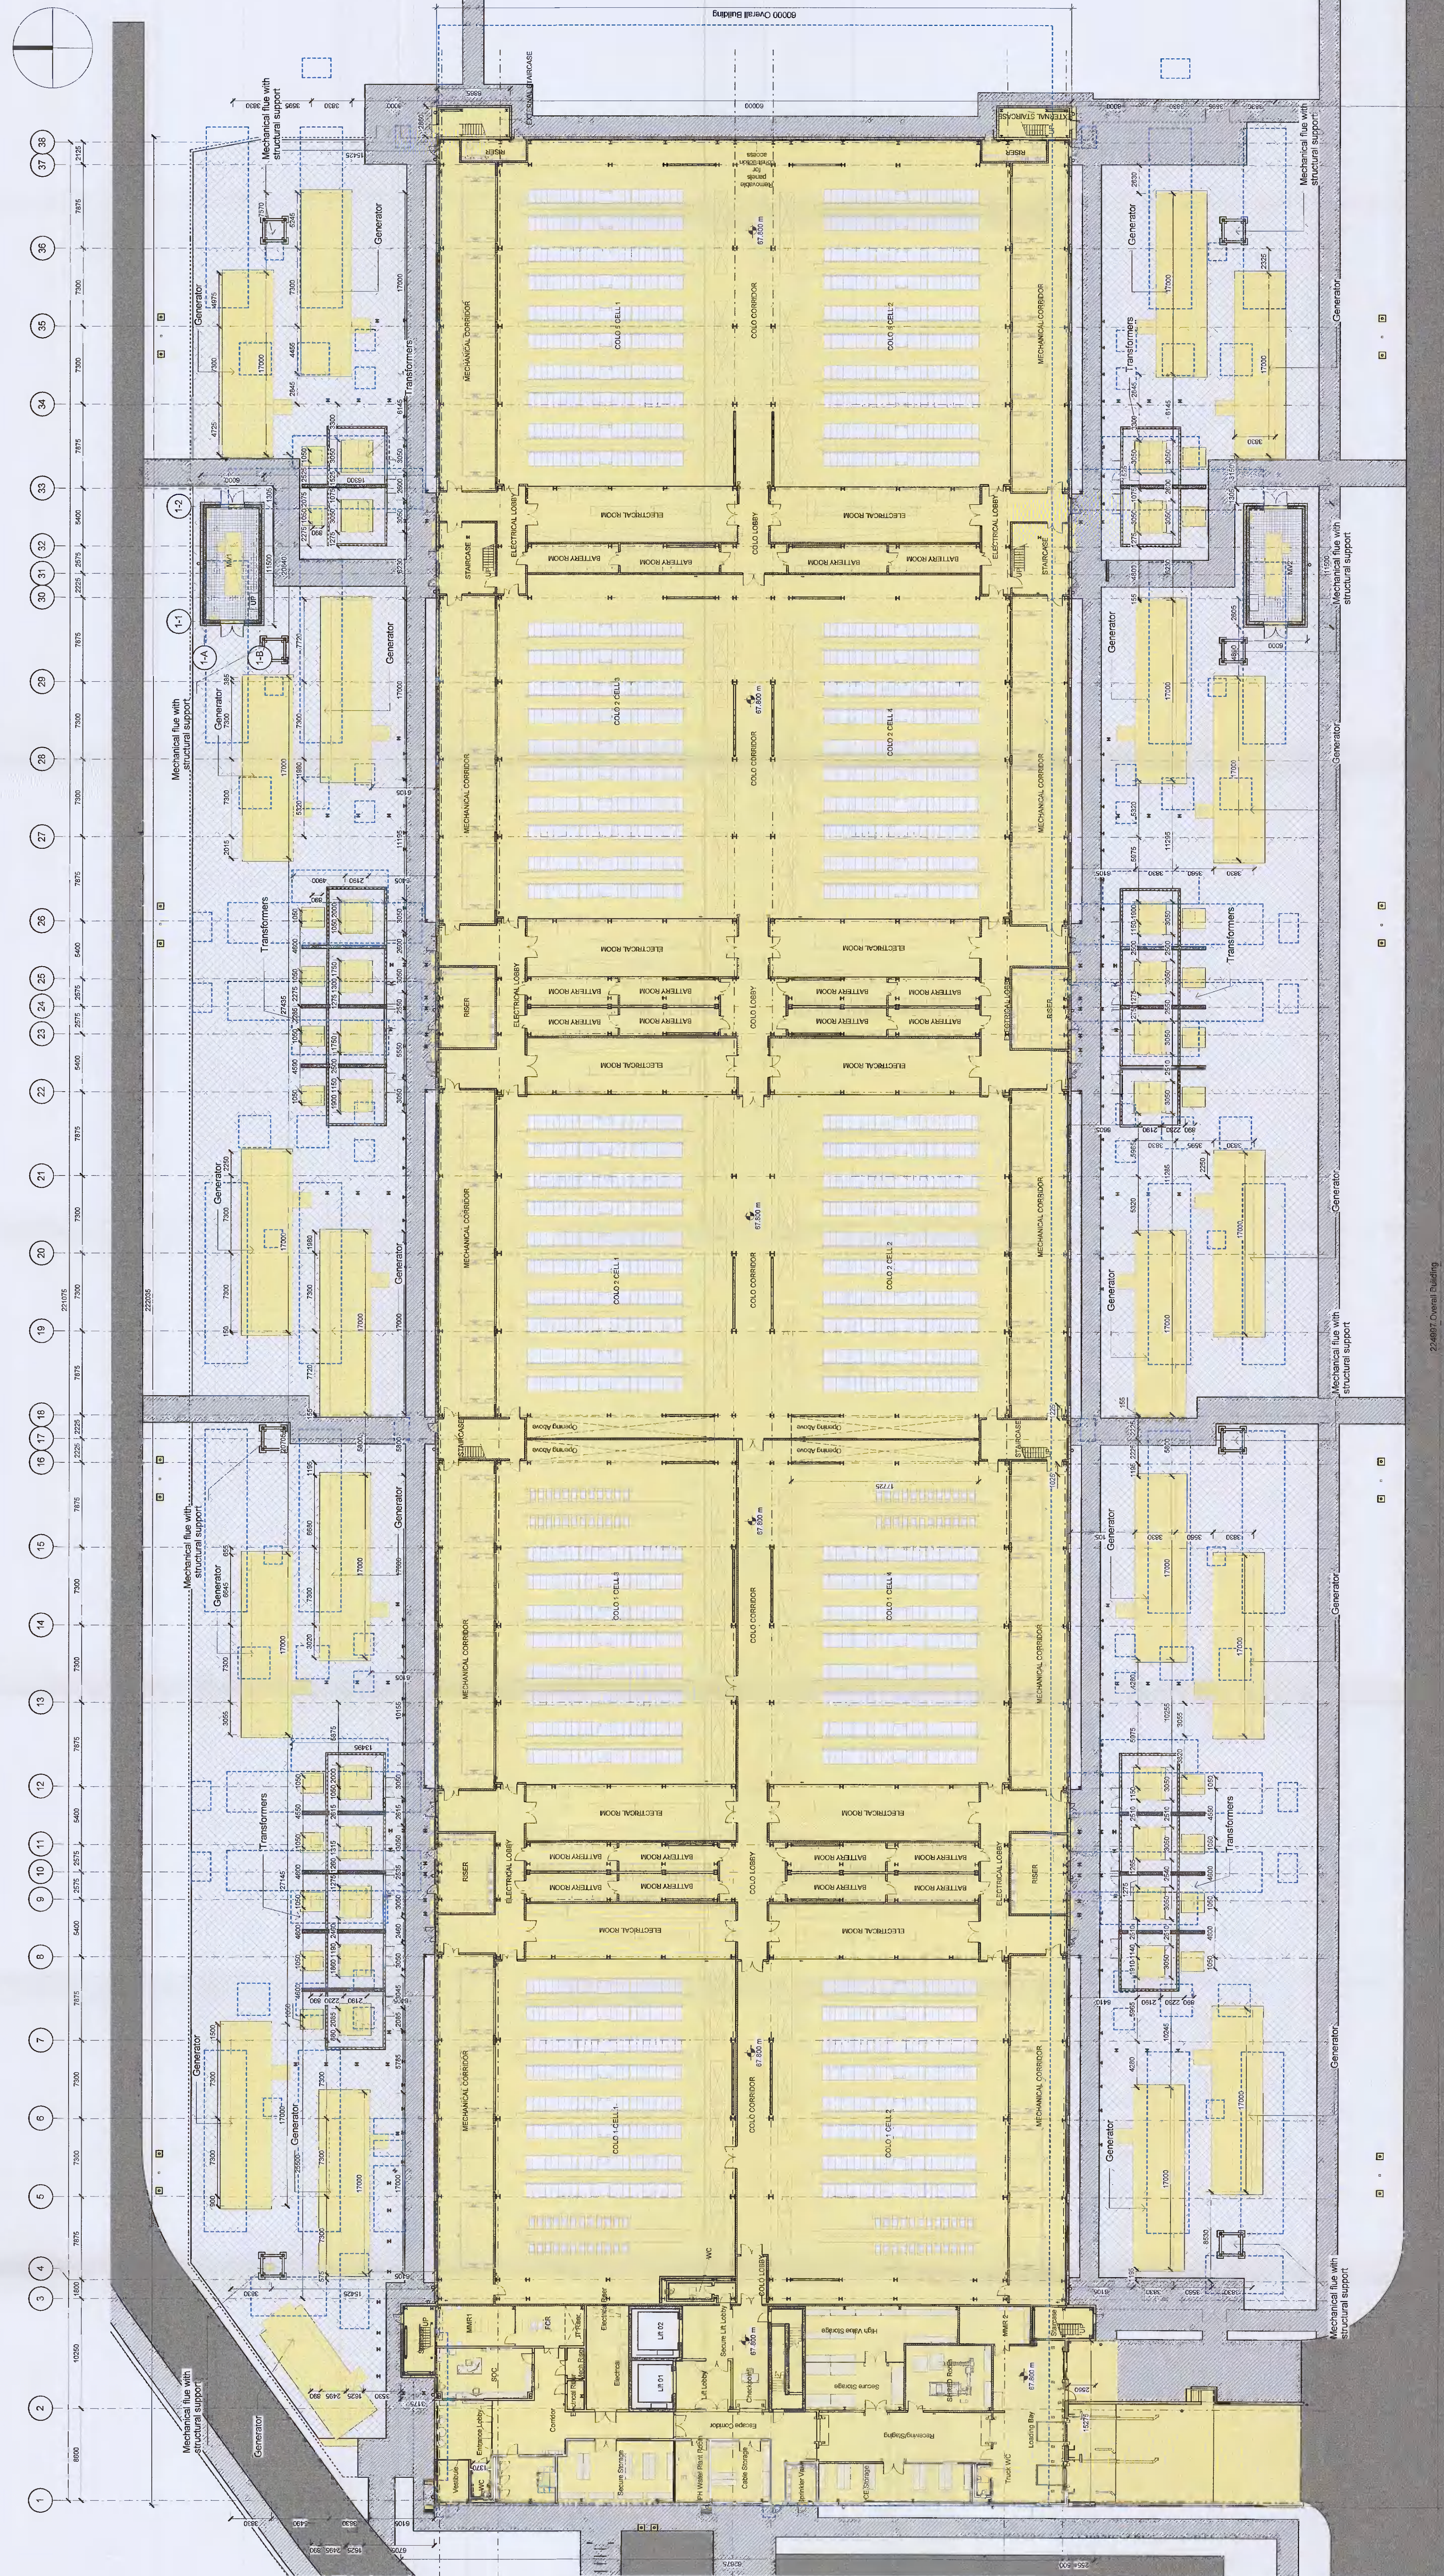

1- Plan - 01 - Proposed Ground Floor Plan
 Scale 1:250