




1 03023 Generator Compound - Ground Floor Plan
1 : 200

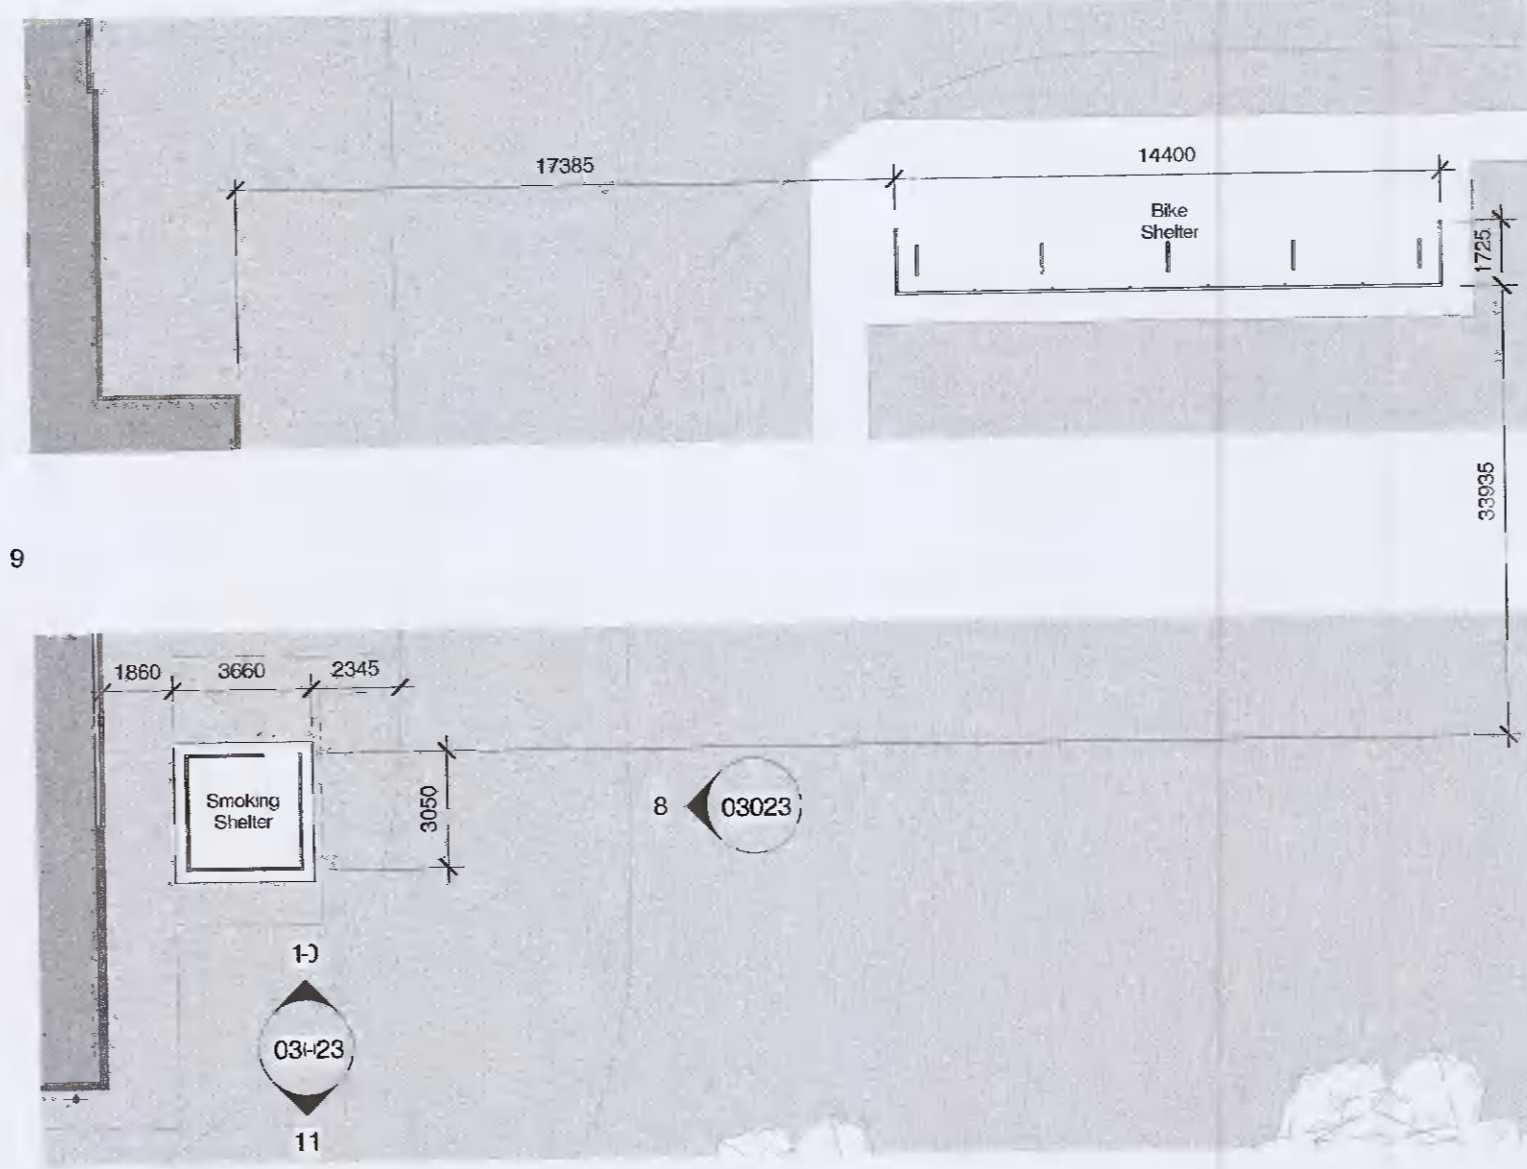

7 03023 Bike & Smoking Shelter - Ground Floor Plan
1 : 200

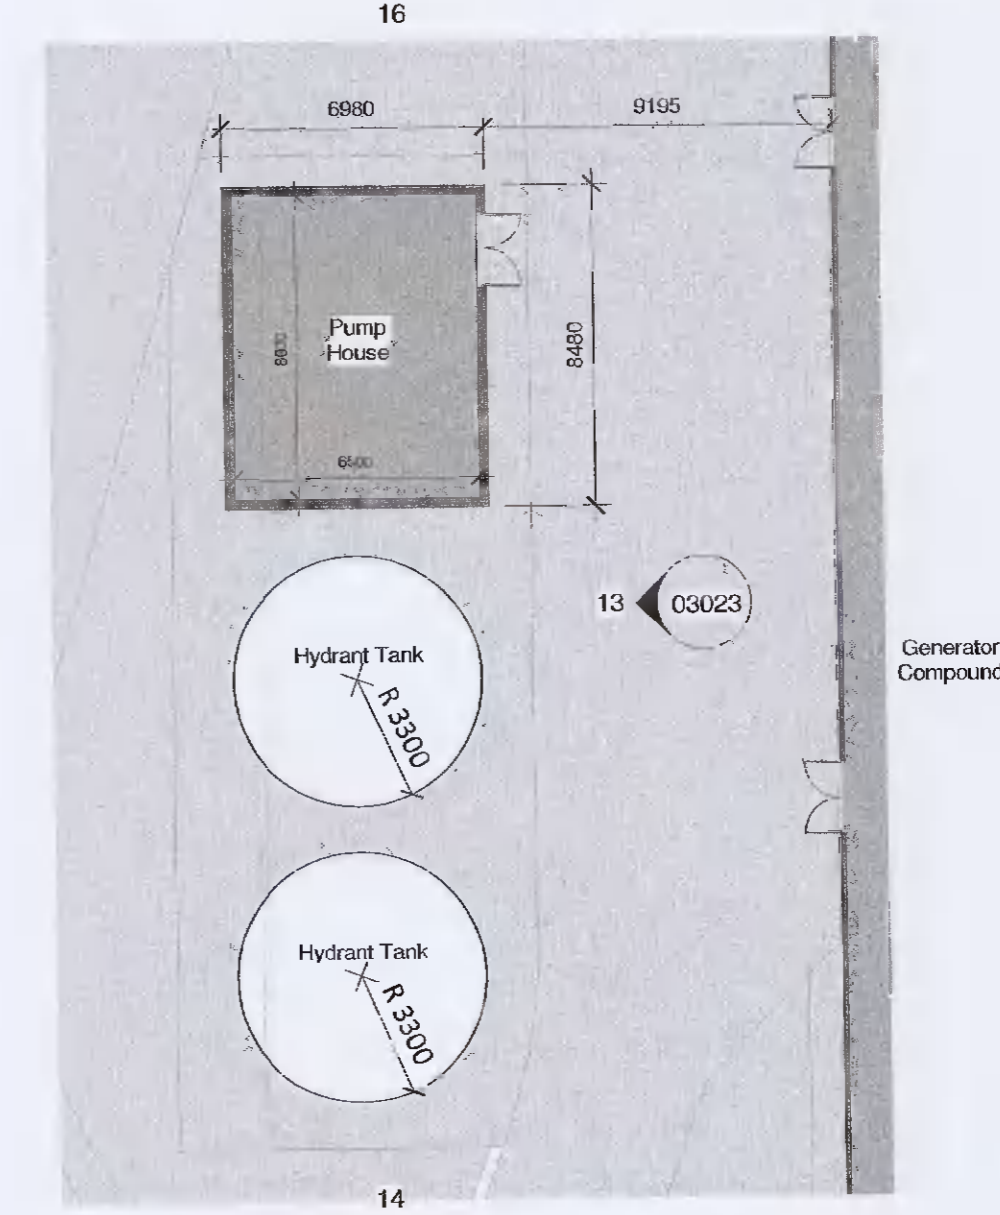


12 03023 Pump House - Ground Floor Plan
1 : 200

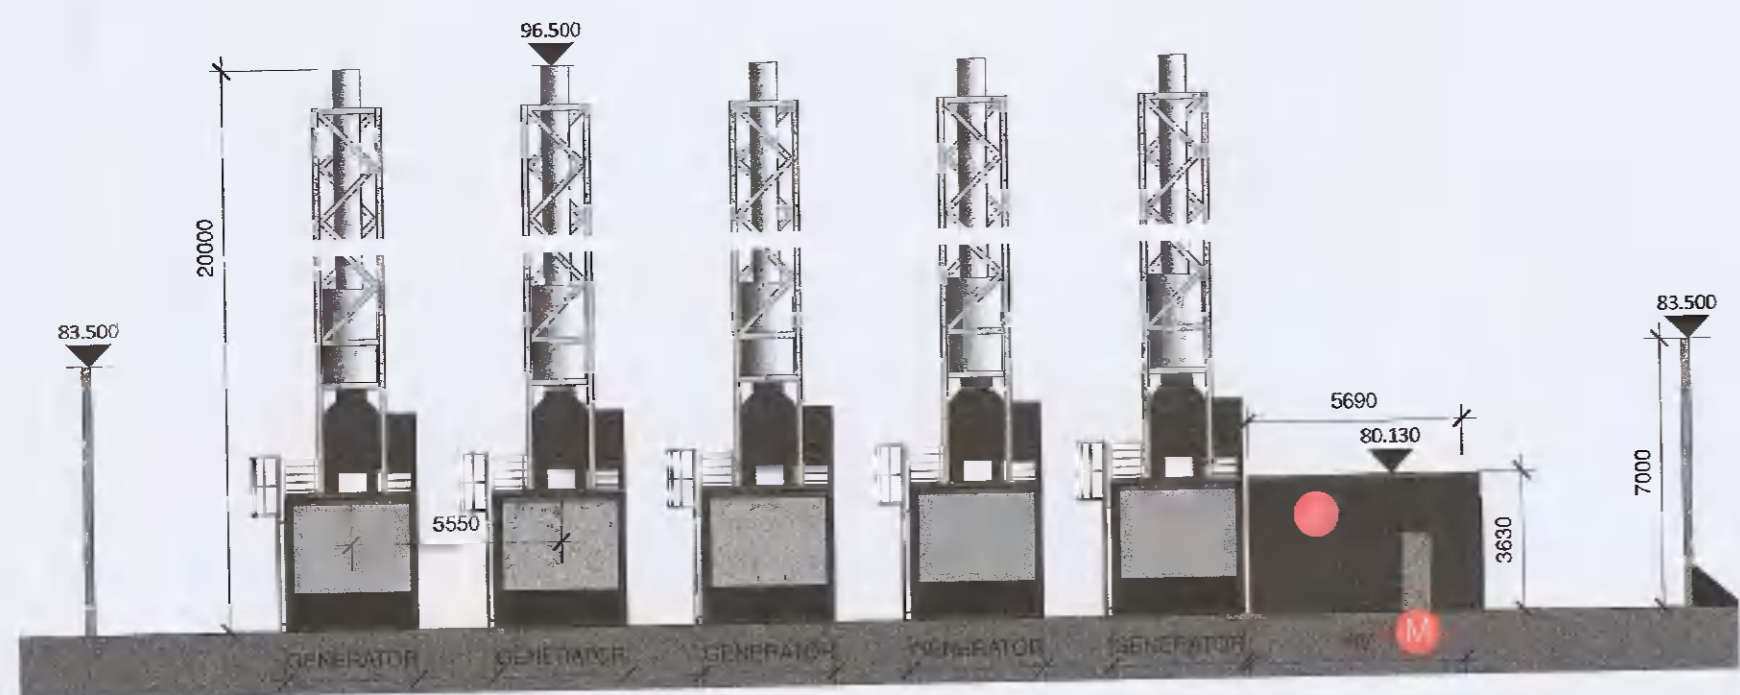


2 03023 Generator Compound - East Elevation
1 : 200




8 03023 Bike & Smoking Shelter - North Elevation
1 : 200

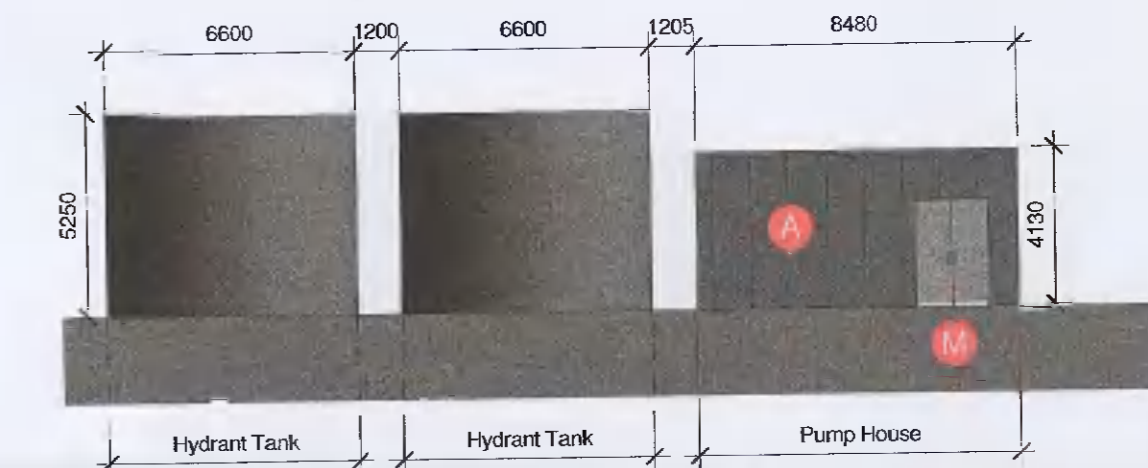


13 03023 Pumphouse - North Elevation
1 : 200

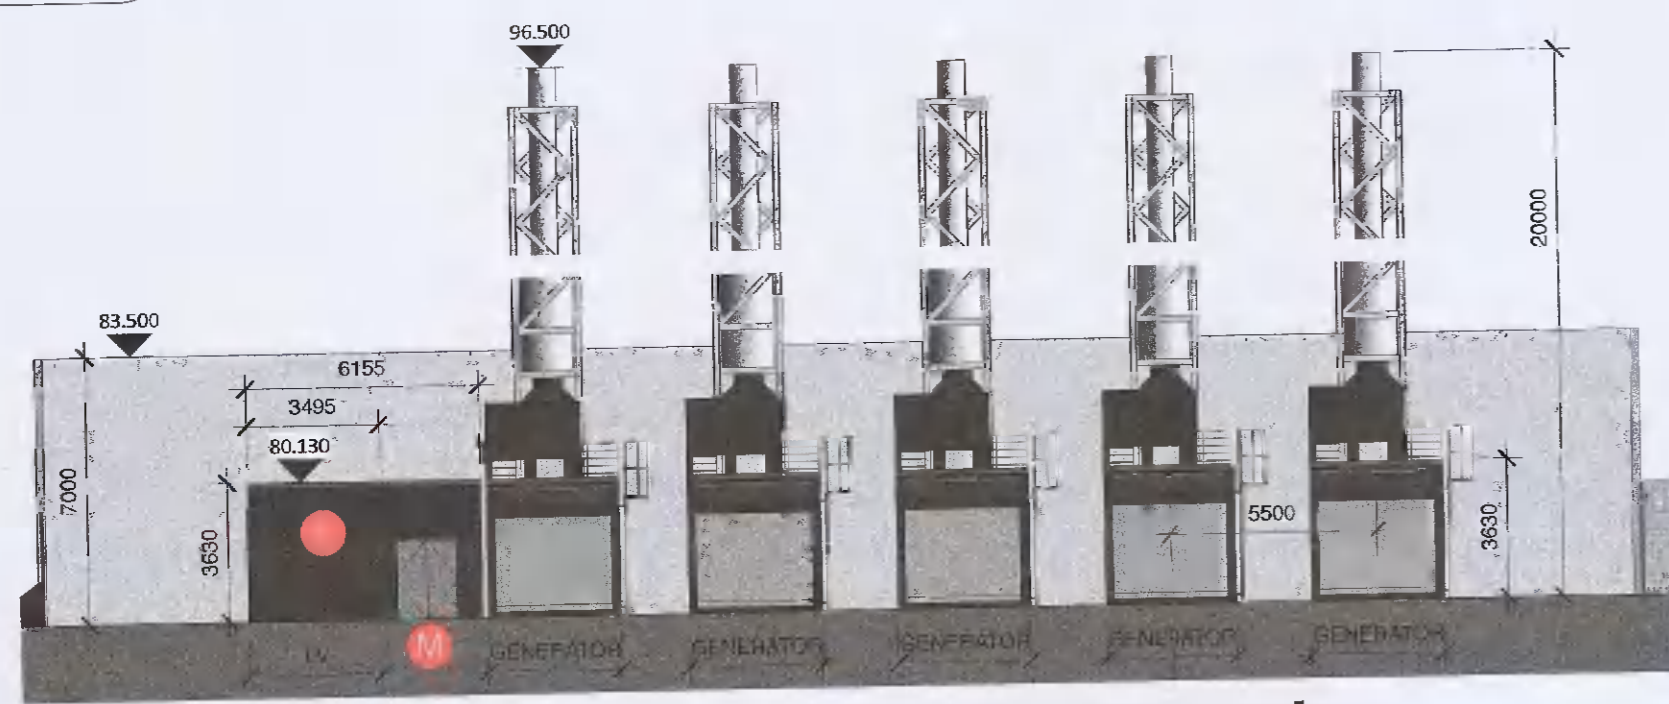


3 03023 Generator Compound - West Elevation
1 : 200

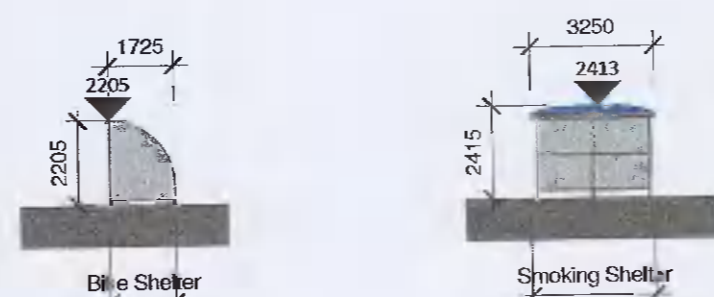


9 03023 Bike & Smoking Shelter - South Elevation
1 : 200

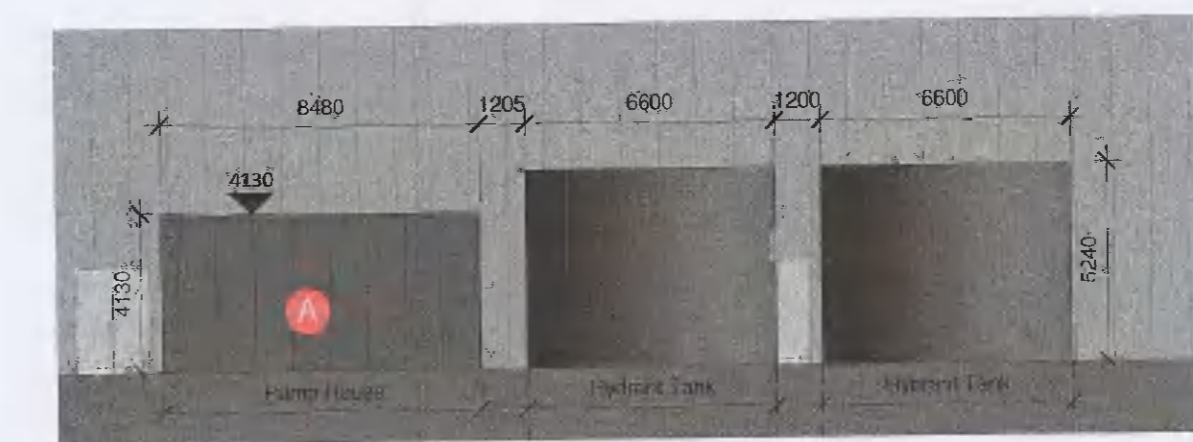


15 03023 Pumphouse - South Elevation
1 : 200

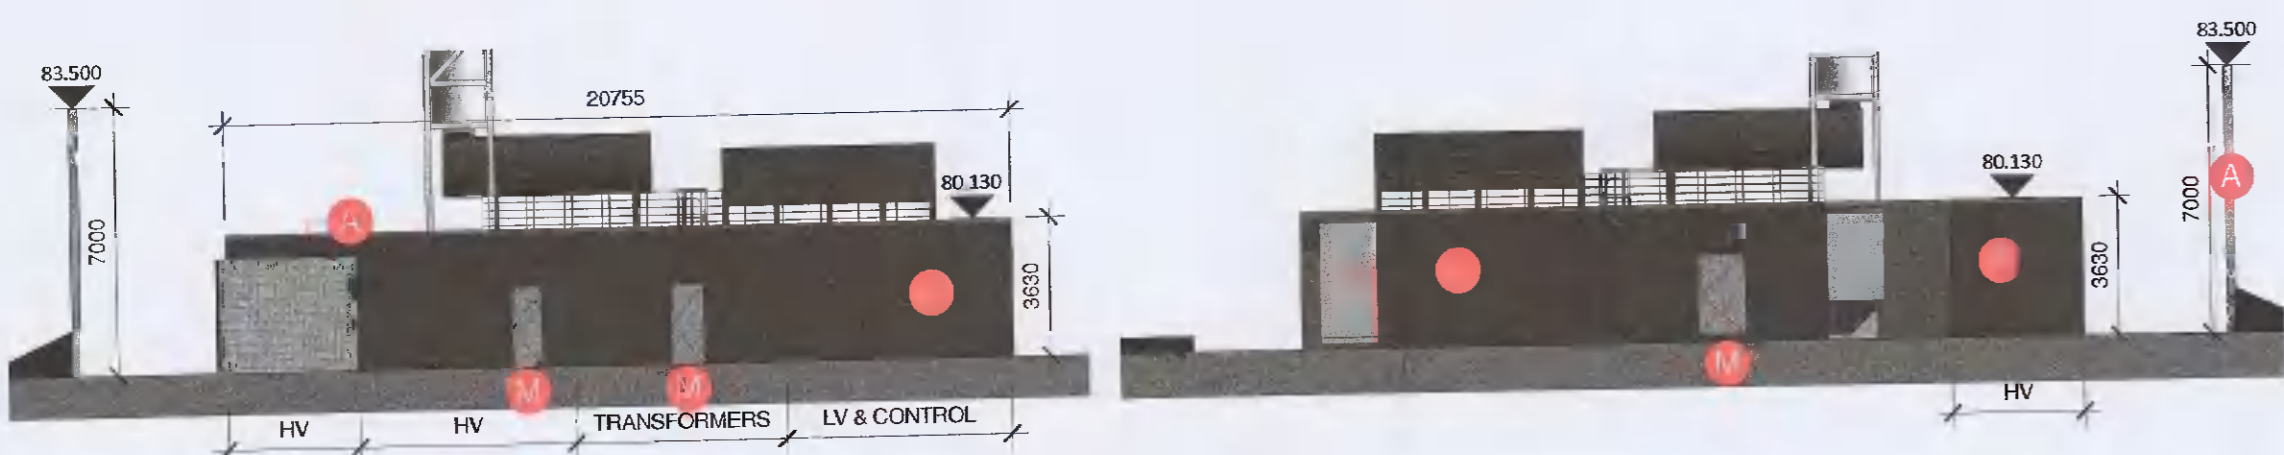


4 03023 Generator Compound - North & South Elevation
1 : 200

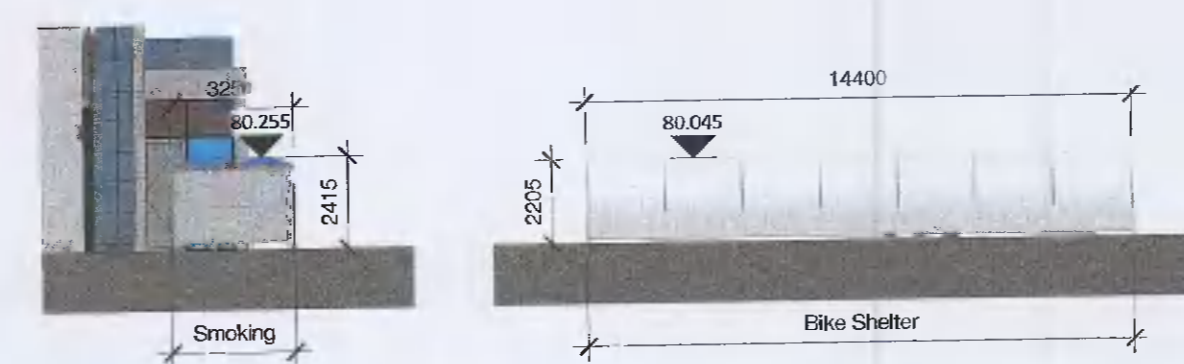


10 03023 Bike & Smoking Shelter - East Elevation
1 : 200

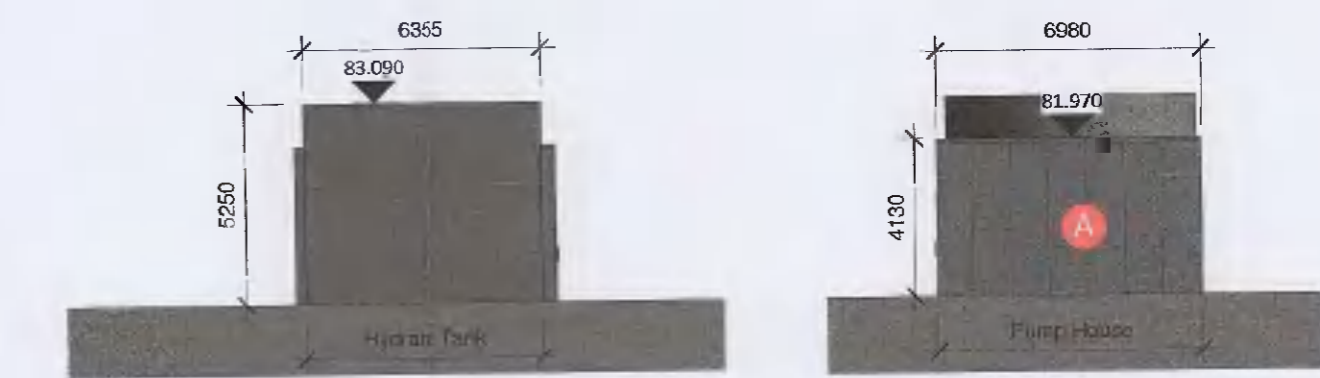


14 03023 Pumphouse - East & West Elevation
1 : 200

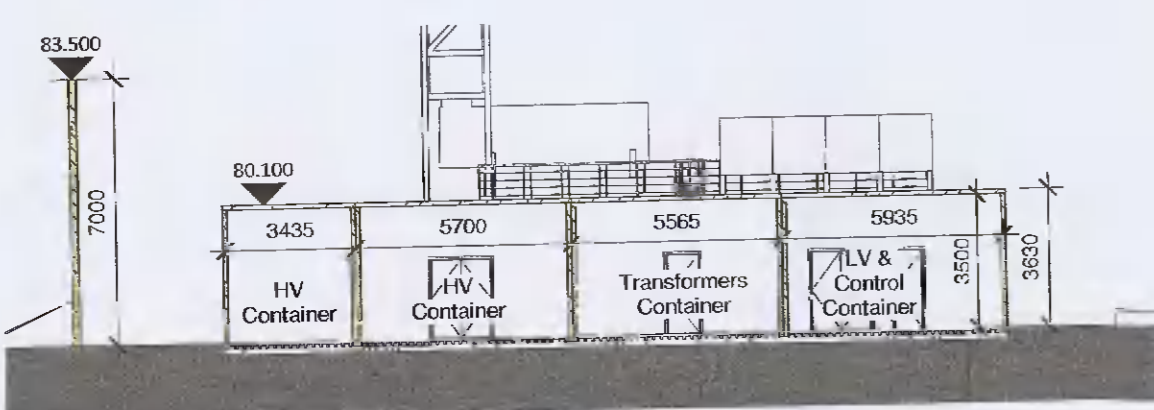

6 03023 Generator Compound - Section
1 : 200

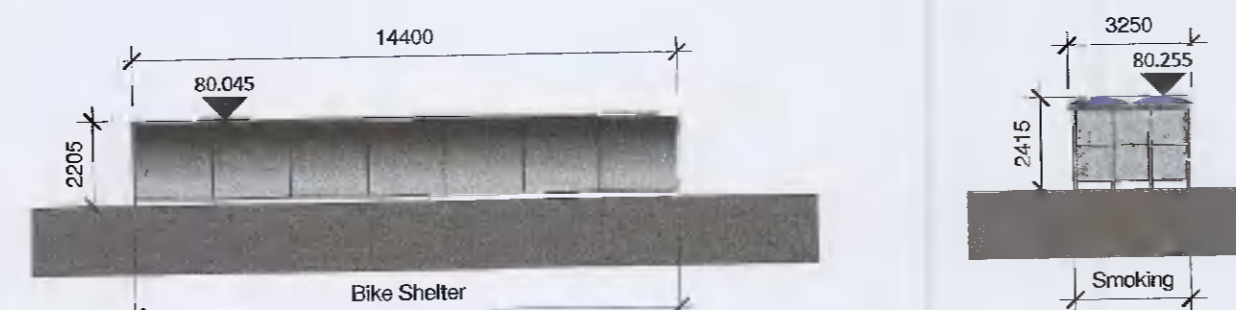

11 03023 05. Bike & Smoking Shelter - West Elevation
1 : 200

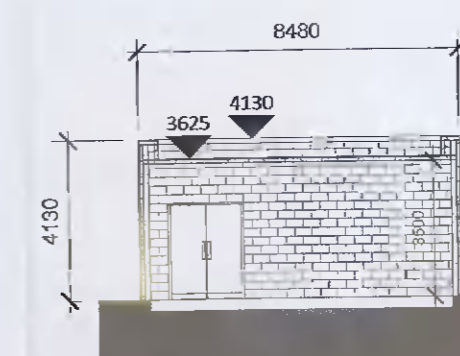

17 03023 Pumphouse - Section
1 : 200

A1

All dimensions to be checked on site. Figured dimensions take preference over scaled dimensions. Any errors or discrepancies to be reported to the Architects. The drawing may not be edited or modified by the recipient.

Copyright and ownership of this drawing is vested in RKD Architects, whose prior written consent is required for its use, reproduction or for publication to any third party. All rights reserved by the law of copyright and by International copyright conventions are reserved to RKD Architects and may be protected by court proceedings for damages and/or injunctions and costs. RKD Architects' Quality Management Systems are certified to ISO 9001:2015.

ENERGY CENTRE COMPOUND KEYPLAN 1:2500

SITE KEYPLAN 1:5000

LEGEND:

- A** POWDER COATED VERTICAL PROFILED METAL CLADDING PANEL TYPE A - MERLIN GREY
- M** SERVICE / ESCAPE DOOR - TO MATCH CLADDING

SUPPORTING BUILDINGS GFA SCHEDULE	
NAME	AREA
DISTRIBUTION GAS COMPOUND	27 m ²
HEAT RECOVERY BUILDING	27 m ²
HV CONTAINER	40 m ²
LV & CONTROL CONTAINER	21 m ²
MV SWITCH ROOMS	644 m ²
PUMP ROOM	52 m ²
PREFUSE	25 m ²
TRANSFORMERS	19 m ²
GRAND TOTAL	856 m ²

Rev.	Date	Description
A	20/10/2021	Planning Issue

STATUS: PLANNING
PROJECT: INXN DUB15 & DUB 16
PROJECT ADDRESS: Profile Park, Nangor Road, Clondalkin, Dublin 22
DWG TITLE: Proposed Ancillary Buildings - Sheet 2 of 2
DWG NO.: IE-DUBZZ-SUBZ-E0-RKD-DR-A-03023
REV. STATUS: PROJECT NO.: 20245
A SCALE: As Indicated
DATE: 28-06-2021 DFN: SL CHK: MK

RKD
50 Northumberland Rd, Ballsbridge, Dublin 4, D06 W190, Ireland
+353 1 608 1000
info@rkd.ie