



CONTIGUOUS ELEVATION C-
Scale 1:300

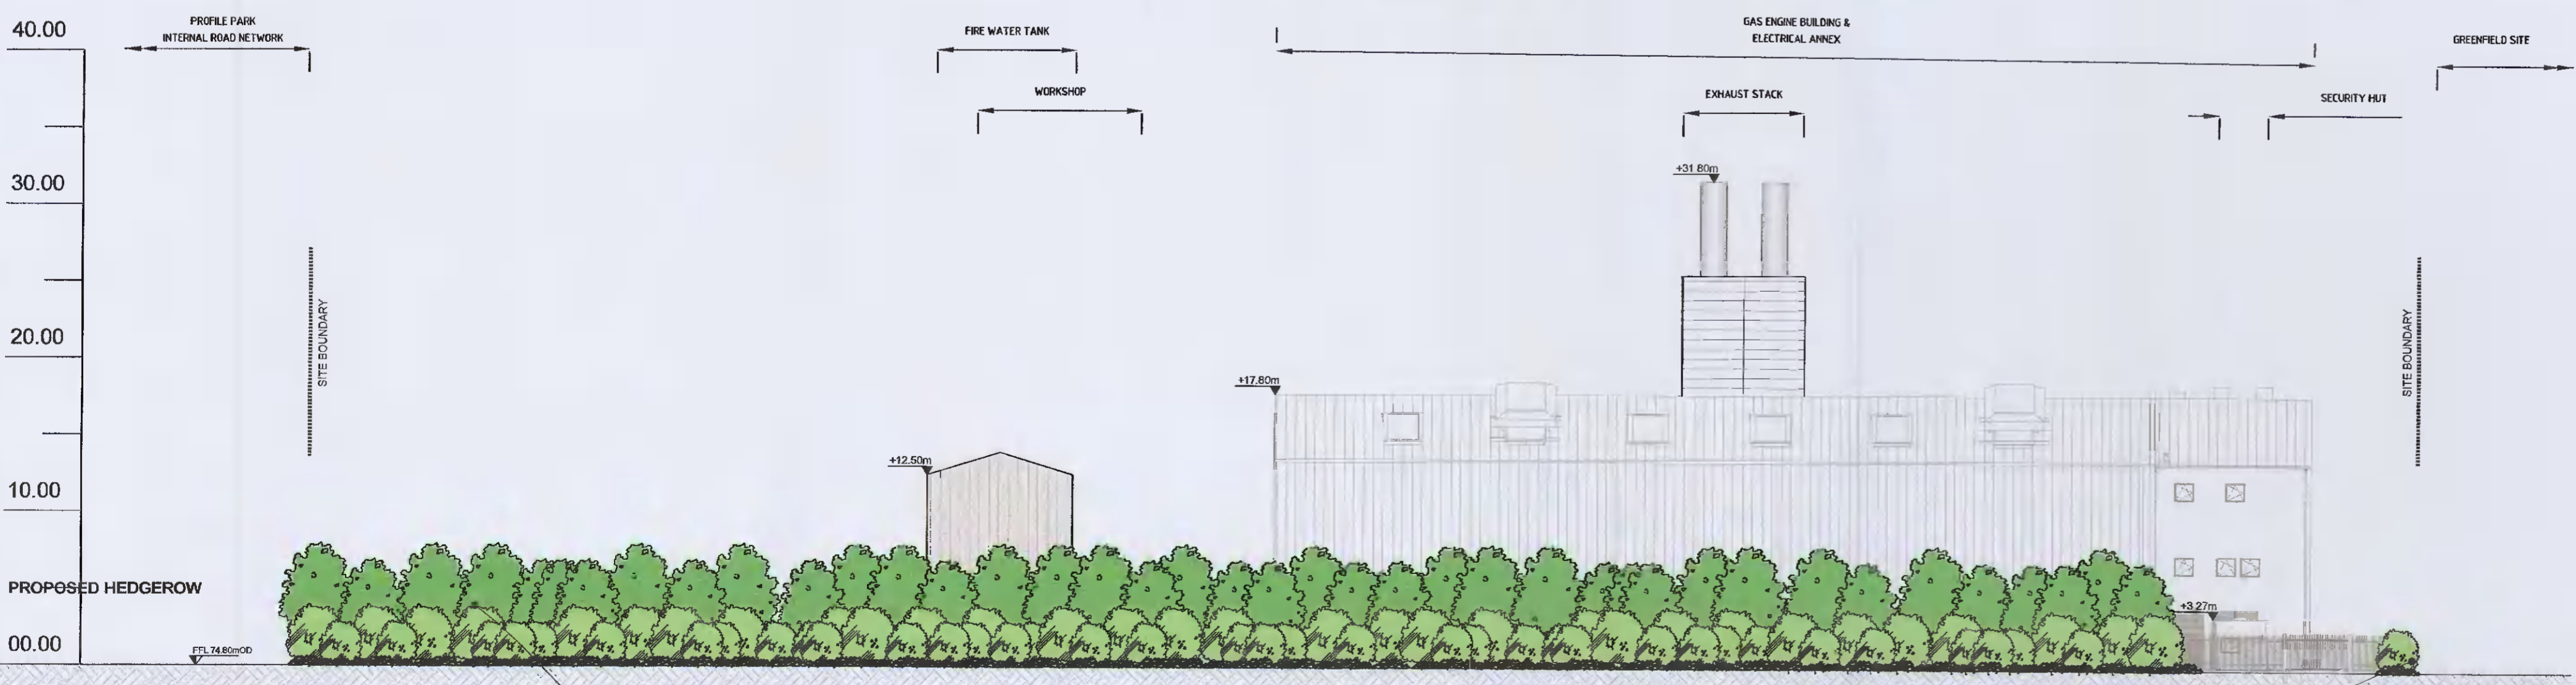

PROPOSED NATIVE WOODLAND MIX
Comprising of a native whip planting mix and advanced nursery stock

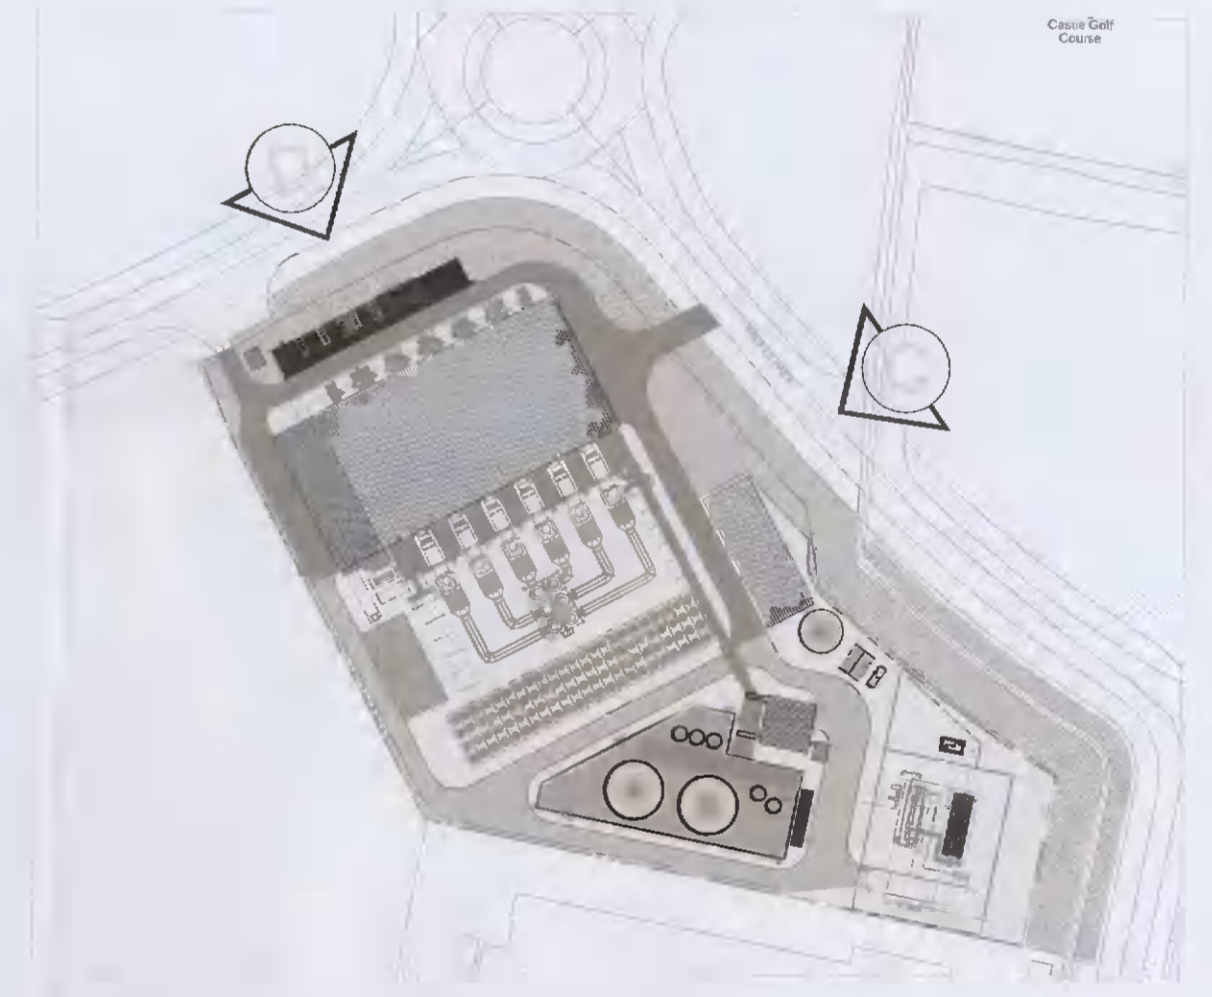

CONTIGUOUS ELEVATION D-
Scale 1:300

PROPOSED NATIVE WOODLAND MIX
Comprising of a native whip planting mix and advanced nursery stock

PROPOSED NATIVE HEDGEROW
Hedgerow to comprise of a native whip planting mix and advanced nursery stock and to be managed at a height of 3-4m

 	
Prepared by: MACRO WORKS, HIBERNIA HOUSE, CHERRYWOOD BUSINESS PARK, LOUGH LINSTOWN, DUBLIN 10 00353 (01) 2300565 info@macroworks.ie	
Site location: KILCARRERY, COUNTY DUBLIN	
Drawing Title: LANDSCAPE SECTIONS	
Project: PROFILE PARK POWER PLANT	
Drawn by: CD	Checked by: RB
Drawing Ref: LD.PRFLEPRK 1.1	
Scale: 1:500 @ A1	Date: JUNE 2021
DRAFT	