 
 





LEGEND

- PROPOSED SURFACE DRAIN AND MANHOLE 
- PROPOSED FOUL DRAIN AND MANHOLE 
- EXISTING FOUL DRAIN AND MANHOLE 
- PROPOSED PERMEABLE PAVING 

NOTE: ALL PIPES TO BE RIGID UPVC.



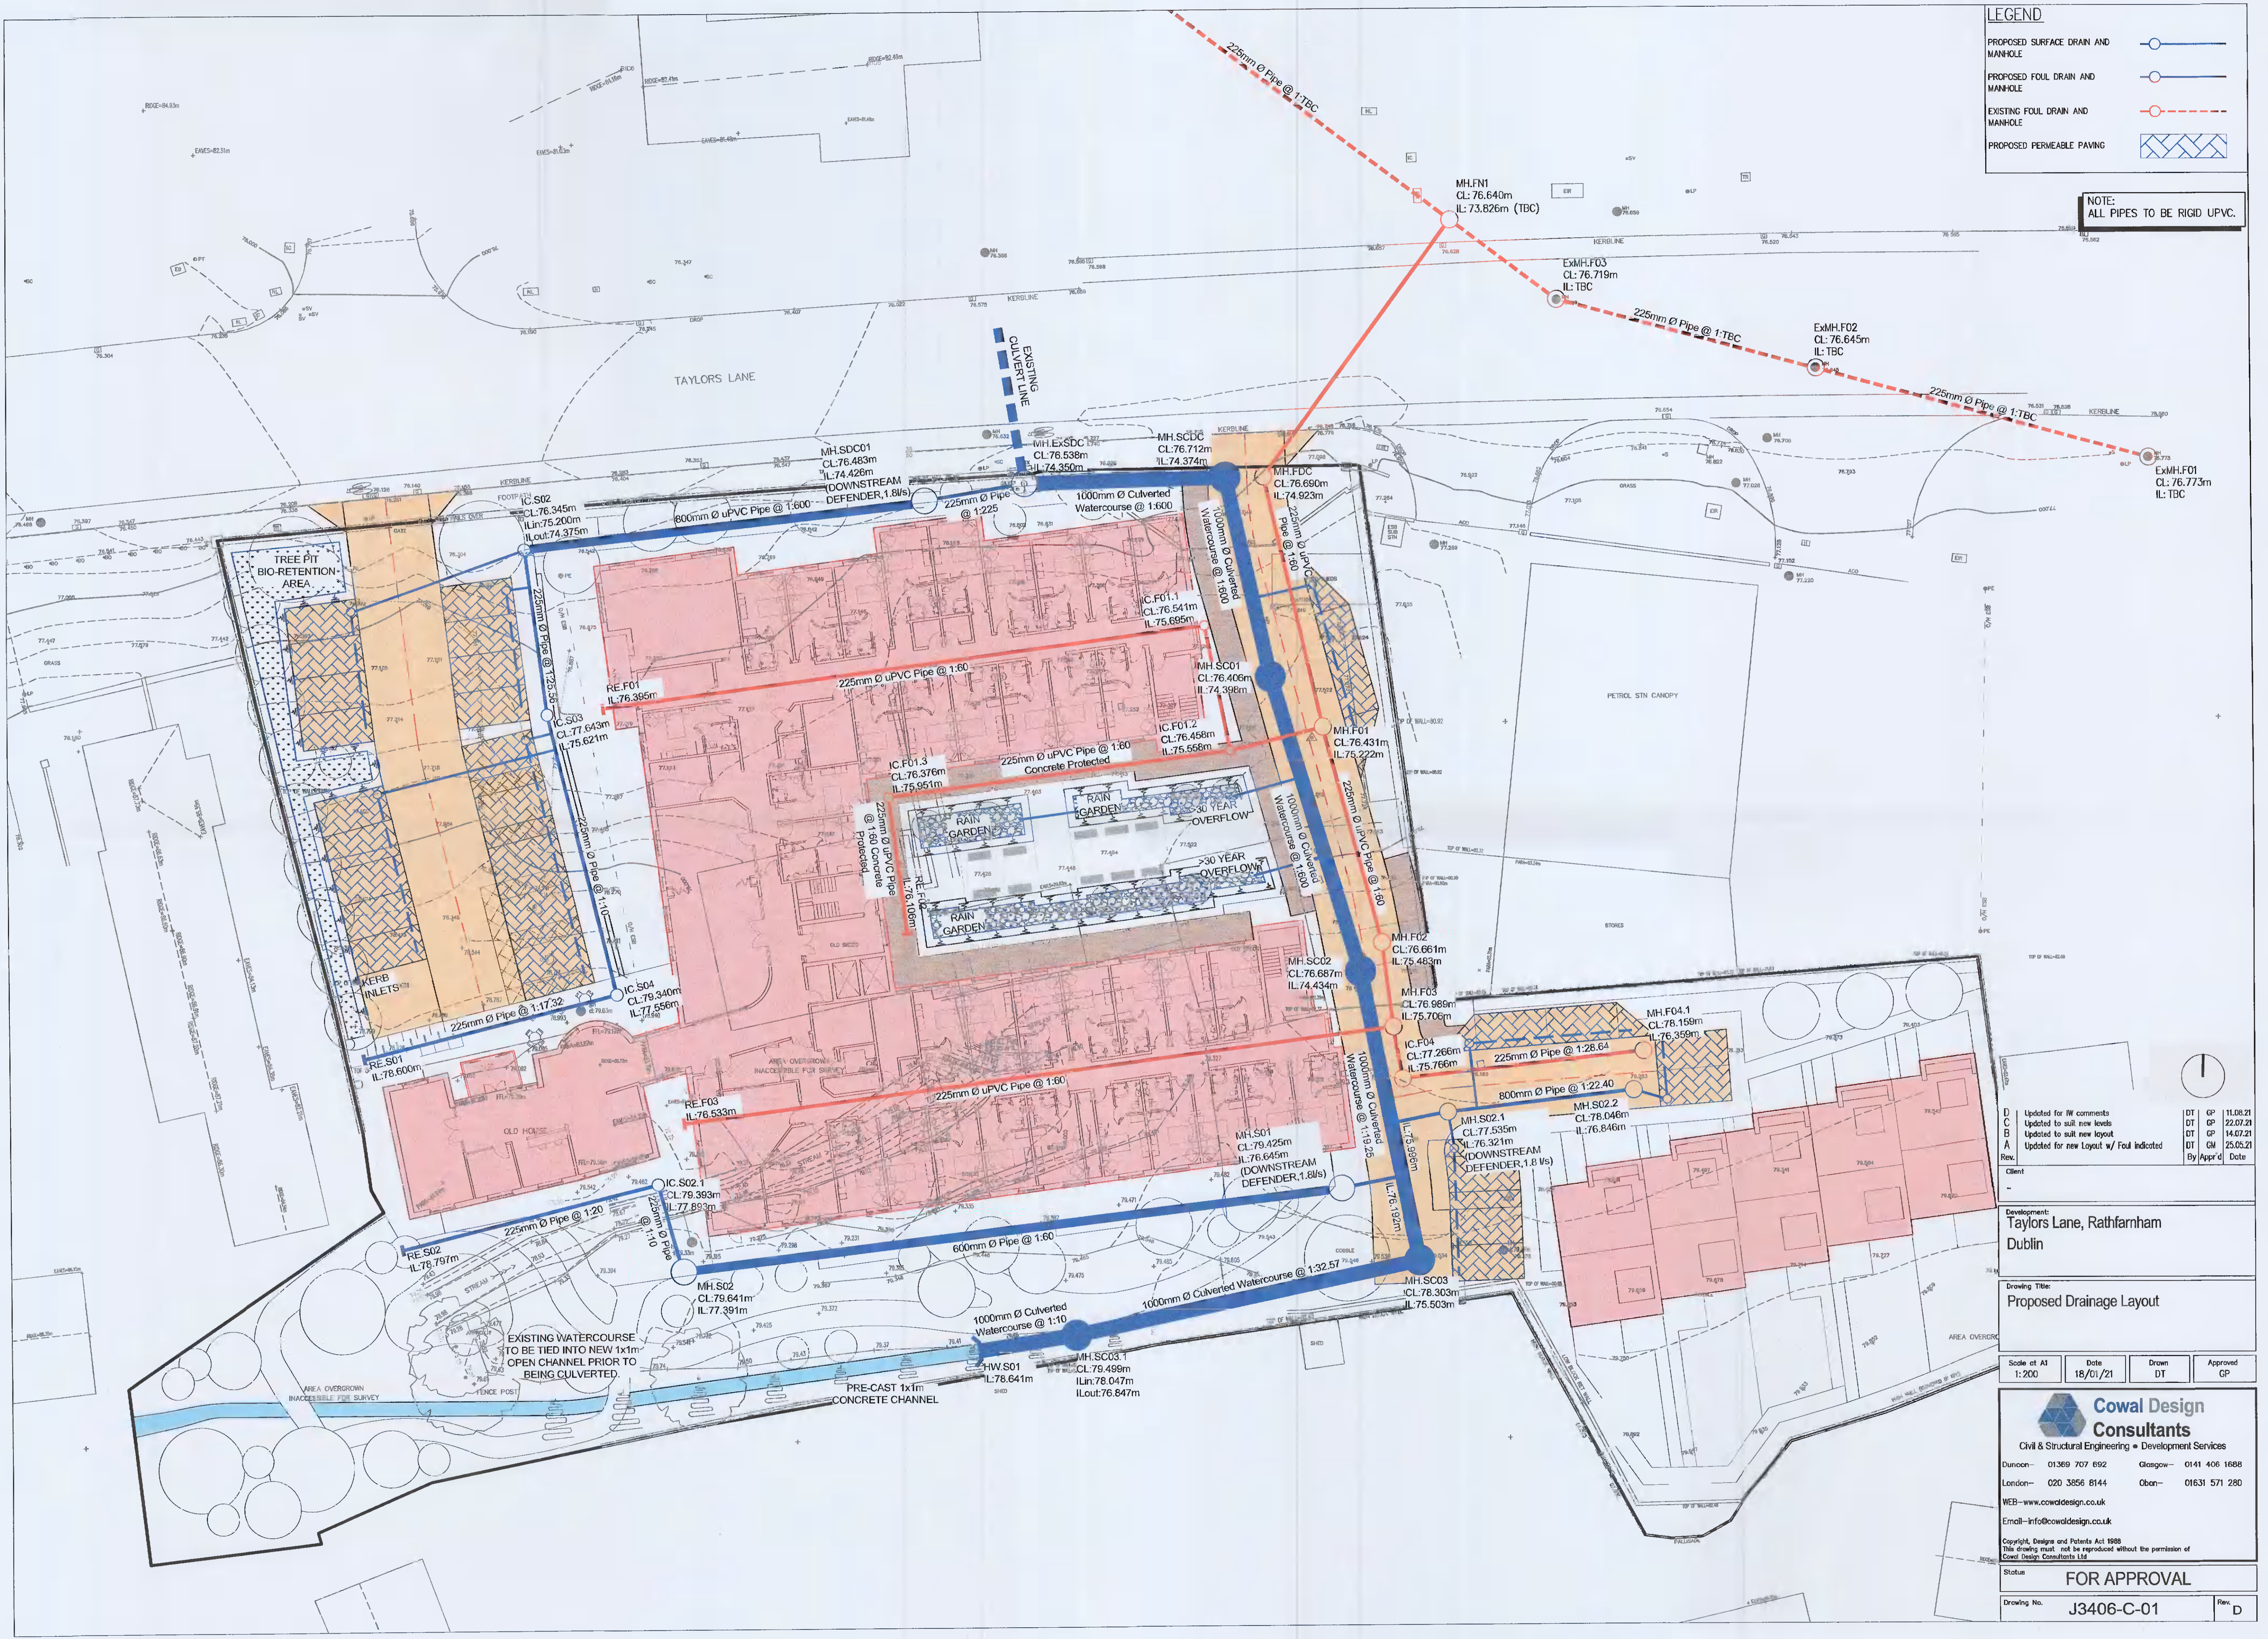Rev.	Description	By	Date
D	Updated for IW comments	GP	11.08.21
C	Updated to suit new levels	DT	22.07.21
B	Updated to suit new layout	DT	14.07.21
A	Updated for new Layout w/ Foul Indicated	DT	25.05.21

Client:
Development:
**Taylor Lane, Rathfarnham
Dublin**

Drawing Title:
Proposed Drainage Layout

Scale of A1	Date	Drawn	Approved
1:200	18/01/21	DT	GP

Cowal Design Consultants
Civil & Structural Engineering • Development Services

Dunoon 01369 707 892 Glasgow 0141 406 1688
London 020 3856 8144 Oban 01631 571 280
WEB - www.cowaldesign.co.uk
Email - info@cowaldesign.co.uk

Copyright, Designs and Patents Act 1988 This drawing must not be reproduced without the permission of Cowal Design Consultants Ltd	<p>FOR APPROVAL</p> <p>Drawing No. J3406-C-01 Rev. D</p>
---	--