

COPYRIGHT AND OWNERSHIP OF THIS DRAWING IS VESTED IN DRA CONSULTING ENGINEERS. NO PART OF THIS DOCUMENT MAY BE REPRODUCED OR TRANSMITTED IN ANY FORM OR STORED IN ANY RETRIEVAL SYSTEM OF ANY NATURE WITHOUT THE WRITTEN PERMISSION OF DRA CONSULTING ENGINEERS AS COPYRIGHT HOLDER EXCEPT AS AGREED FOR USE ON THE PROJECT FOR WHICH THE DOCUMENT WAS ORIGINALLY ISSUED. ©

ALL RIGHTS RESERVED BY THE LAW OF COPYRIGHT AND BY INTERNATIONAL COPYRIGHT CONVENTIONS ARE RESERVED TO DRA CONSULTING ENGINEERS. ©

ORDNANCE SURVEY MAPS REPRODUCED UNDER LICENCE No. CYAL50173115.
© ORDNANCE SURVEY IRELAND / GOVERNMENT OF IRELAND.

- NOTES:
1. ALL DIMENSIONS ARE IN MILLIMETRES AND LEVELS IN METRES UNLESS NOTED OTHERWISE.
 2. USE FIGURED DIMENSIONS ONLY DO NOT SCALE.
 3. DRAWINGS TO BE READ IN CONJUNCTION WITH ALL RELEVANT ENGINEERS, ARCHITECTS AND SERVICE ENGINEERS DRAWINGS AND SPECIFICATIONS.
 4. ALL WORKS TO BE CARRIED OUT IN ACCORDANCE WITH CURRENT BUILDING REGULATIONS.
 5. ALL DRAINAGE TO COMPLY WITH THE BUILDING REGULATIONS TECHNICAL GUIDANCE DOCUMENT H - DRAINAGE AND WASTE WATER DISPOSAL.
 6. FOUL DRAINAGE TO BE CONSTRUCTED IN ACCORDANCE WITH IRISH WATER'S (IW) 'WASTEWATER INFRASTRUCTURE STANDARD DETAILS' AND 'CODE OF PRACTICE FOR WASTEWATER INFRASTRUCTURE DESIGN' REFER TO IRISH WATER DOCUMENT NO. 1W-CDS-5030-01 AND IW-CDS-5030-03.
 7. SURFACE WATER DRAINAGE TO BE CONSTRUCTED IN ACCORDANCE WITH THE GREATER DUBLIN REGIONAL CODE OF PRACTICE FOR DRAINAGE WORKS.

LEGEND:

	SITE BOUNDARY
	EXISTING SURFACE WATER SEWER
	PROPOSED SURFACE WATER SEWER
	PROPOSED ROAD GULLY
	1000 SW @ MINIMUM 1:100
	FLOW CONTROL DEVICE MAX DISCHARGE = 5 l/s (RAIN-FALL BENCHES AS PER MANUFACTURERS REQUIREMENTS)
	ATTENUATION TANK (STORAGE VOLUME = 110 m³)
	EXISTING FOUL SEWER
	PROPOSED FOUL INSPECTION CHAMBER AS PER PART H (600-1000mm DEEP, 2450mm)
	PROPOSED FOUL A1 AS PER PART H (400-600mm DEEP, 2300mm)
	1000 FOUL @ MINIMUM 1:60
	PROPOSED ROAD LEVELS
	EXISTING LEVELS

2	ADDED PROPOSED NEW ROOFED AREA, PROPOSED TOILET LOCATION ALTERED	GM	BMcG	AD	21/07/2021
1	ISSUED FOR PLANNING	STR	EMcG	AD	30/06/2021
REV	DESCRIPTION	PROD.	VERIF.	APPR.	DATE

PLANNING



DUBLIN 01-216-2856 LIMERICK 061-310-701 WEXFORD 053-915-2814 E: info@drc consulting.ie W: www.drc consulting.ie

ARCHITECT: RDF ARCHITECTS & PLANNING UNIT 19, CHARLEVILLE TOWN CENTRE, CHARLEVILLE, CO.CORK


PROJECT: EXTENSION TO BUILDING NO. 3 WITH NEW YARD SLAB

TITLE: PROPOSED DRAINAGE LAYOUT

DATE:	17/06/2021	SCALE:	1:250 @ A1
DESIGNER:	SIR	DWG. No:	
PRODUCER:	SIR		
VERIFIER:	EMcG		
APPROVER:	AD		

21194-150

2

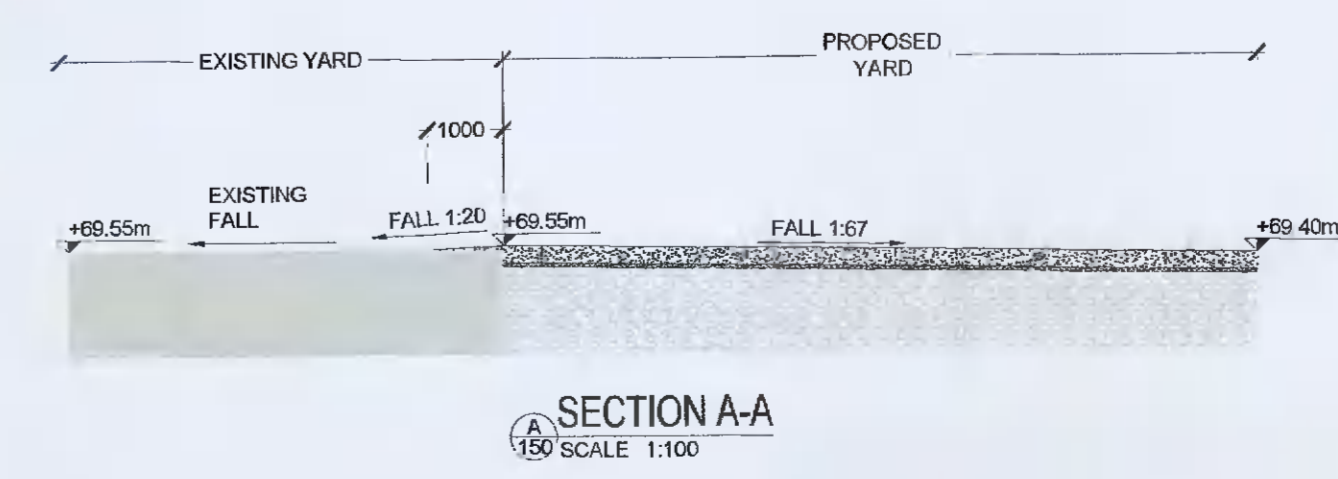

SECTION A-A
SCALE 1:100