




PHASE 1A: TEMPORARY POWER PLANT; TO BE DEMOLISHED IN PHASE 1B

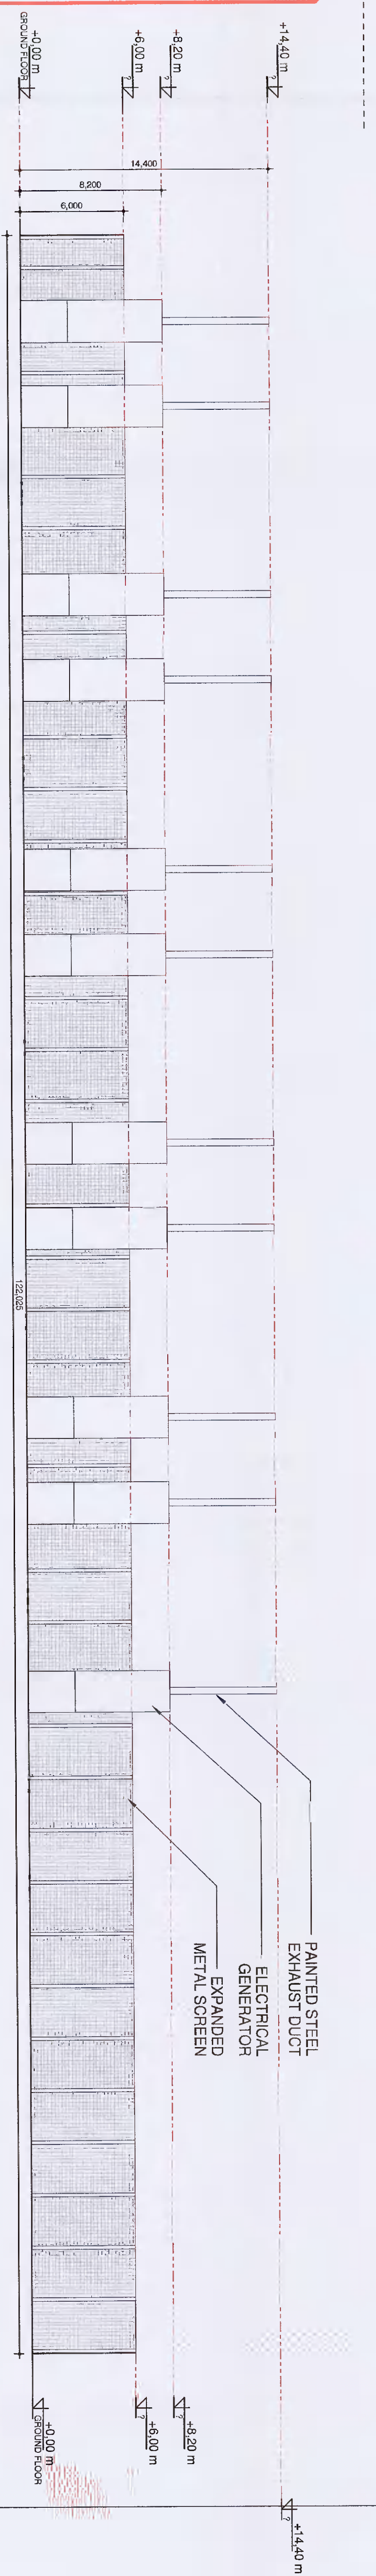


6 Agreikko Plant - Section
SCALE: 1:200

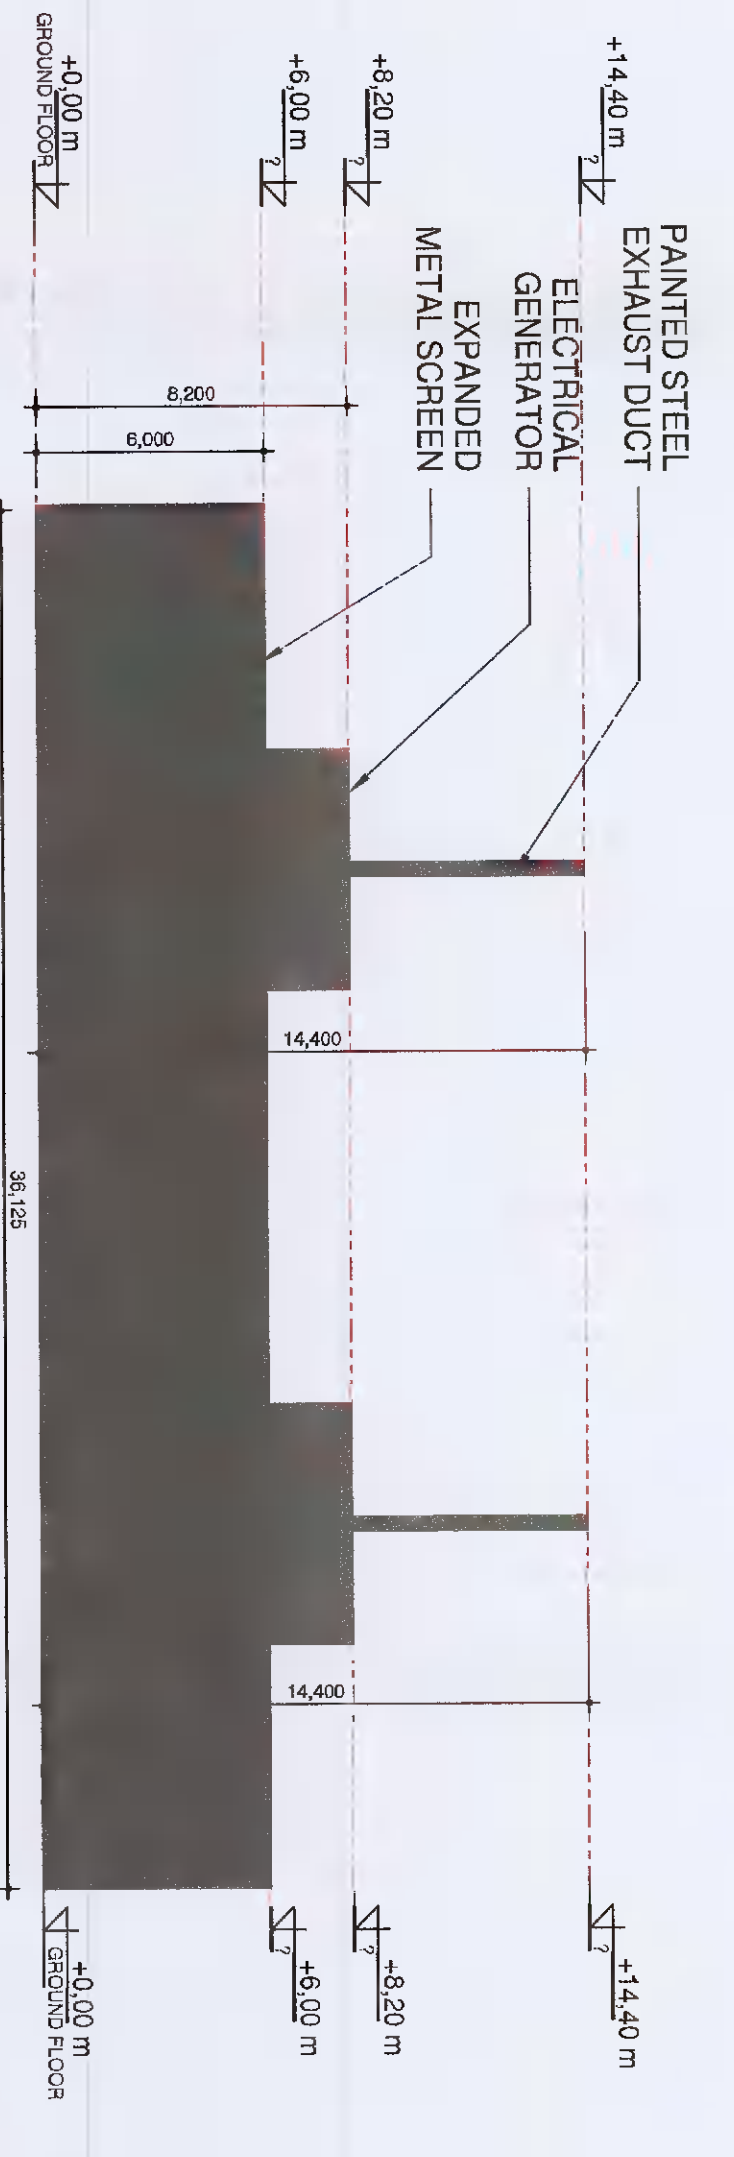


5 Agreikko Plant - North Elevation
SCALE: 1:200

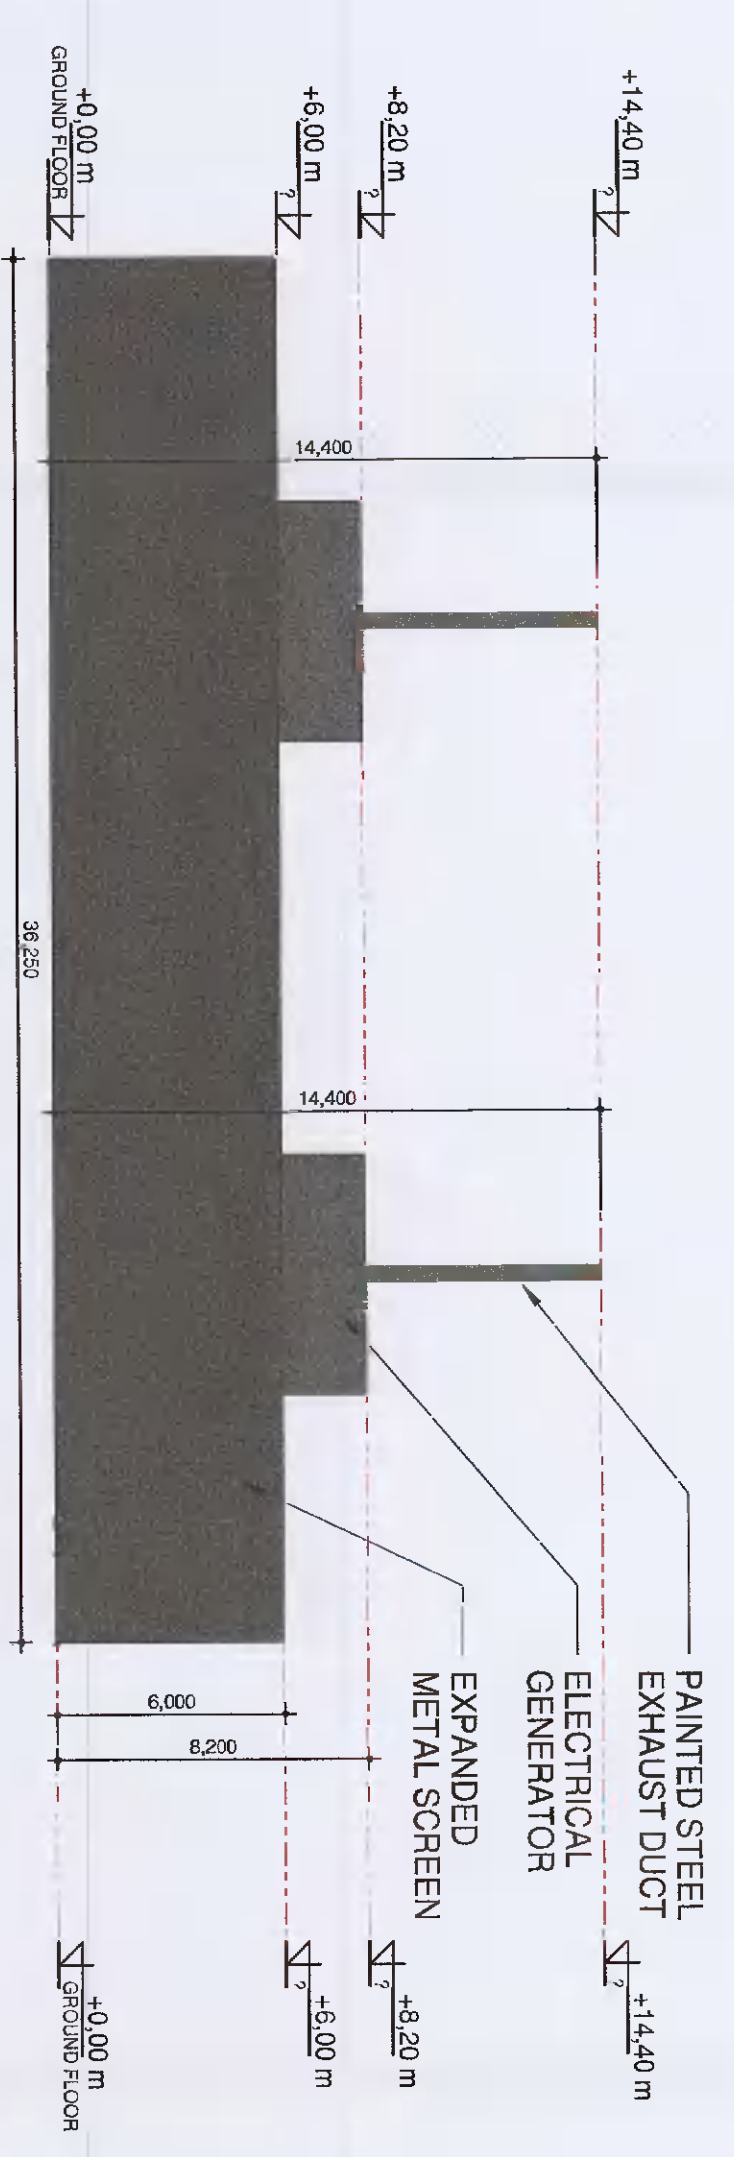

4 Agreikko Plant - South Elevation
SCALE: 1:200

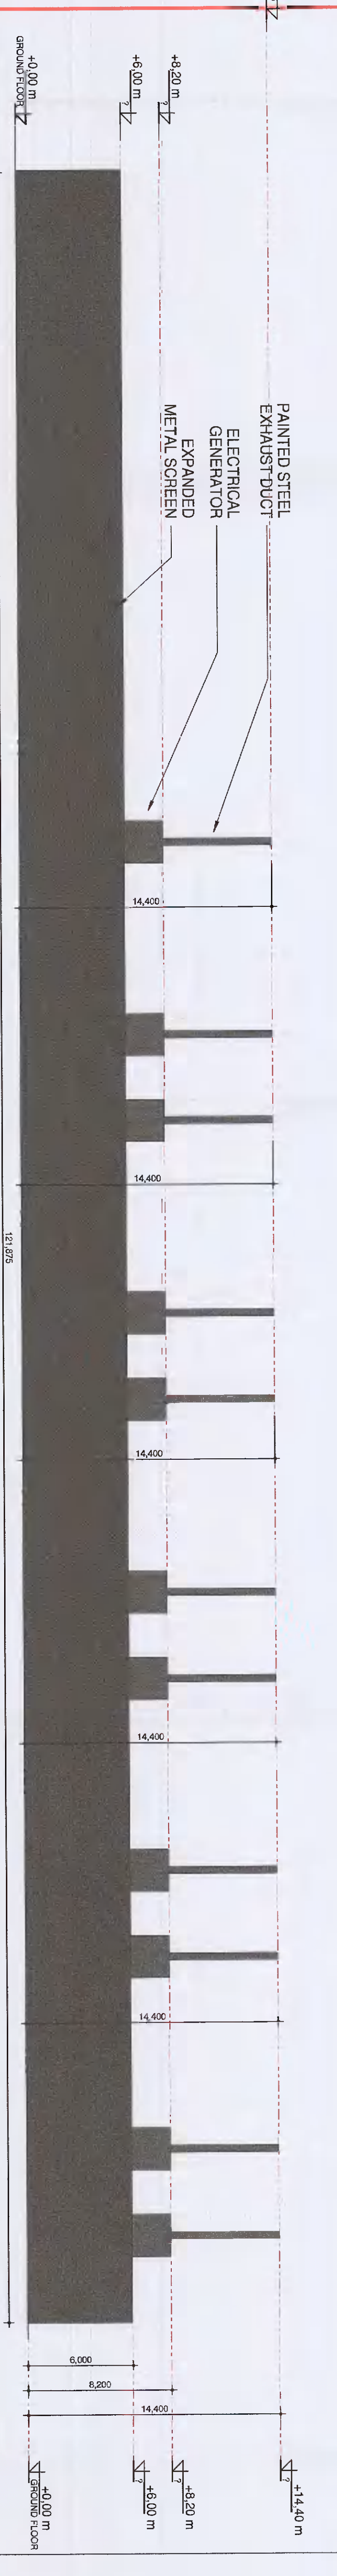


3 Agreikko Plant - East Elevation
SCALE: 1:200

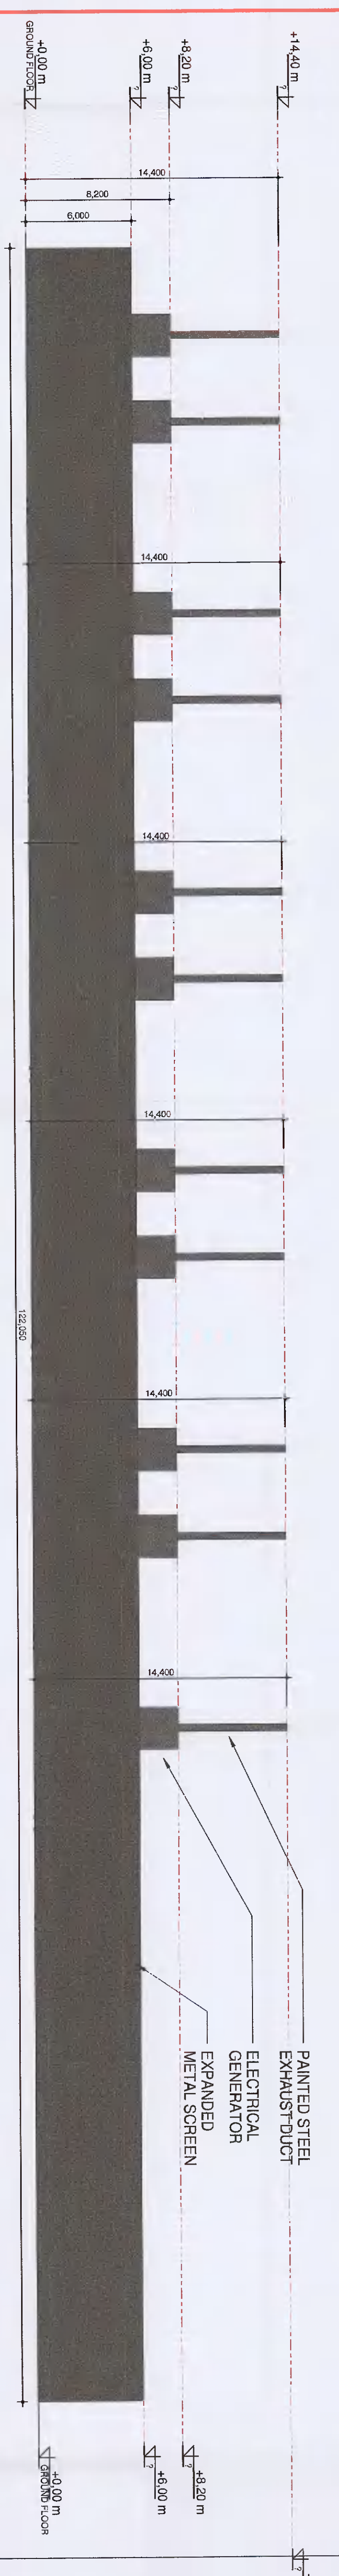

2 Agreikko Plant - West Elevation
SCALE: 1:200

1 AGREIKKO PLANT - TEMPORARY POWER GENERATOR
SCALE: 1:200

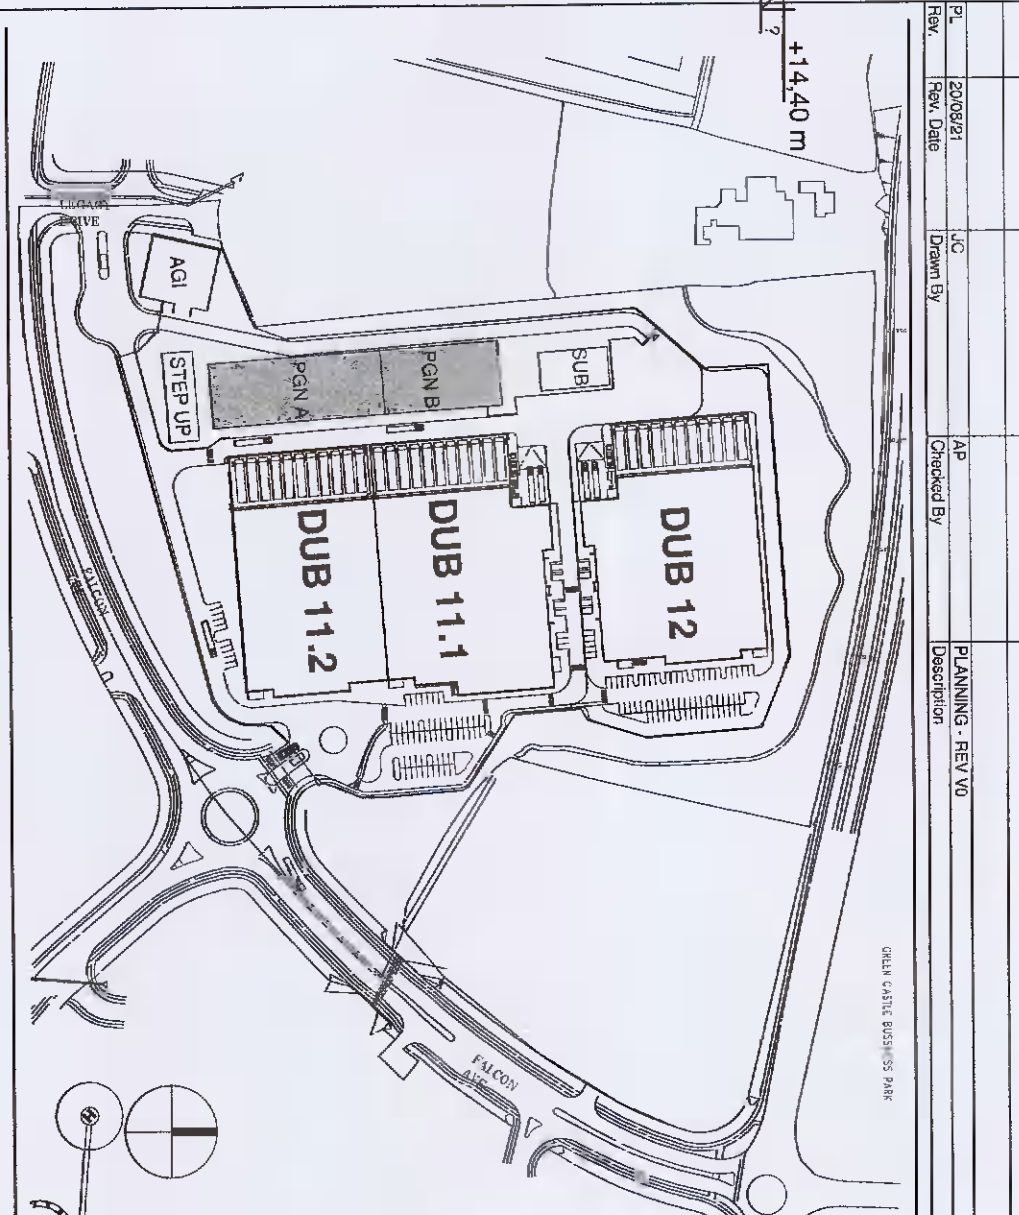

PLANNING SUBMITTAL
NOT FOR
CONSTRUCTION

<p>Hyphen</p> <p>Architectural Power Generator Power Generator Elevations Agreikko Plant</p>		<p>Project No: 1300</p> <p>Scale: 1:200</p> <p>Date: 18/08/21</p> <p>Project Name: DUB11-DR-00-014-V0-P1-C-BMD</p>	
<p>Client: Vantage Data Systems</p> <p>Project Name: Agreikko Plant</p> <p>Site: 1300</p> <p>Scale: 1:200</p>	<p>Author: J. Maher</p> <p>Checked: J. Maher</p> <p>Approved: J. Maher</p>	<p>Author: J. Maher</p> <p>Checked: J. Maher</p> <p>Approved: J. Maher</p>	<p>Author: J. Maher</p> <p>Checked: J. Maher</p> <p>Approved: J. Maher</p>