


- NOTES:**
- REFER TO DRAWING NO. 202252-PUNCH-XX-XX-DR-C-0100 FOR DRAINAGE LAYOUT.
 - REFER TO DRAWING NO. 202252-PUNCH-XX-XX-DR-C-0200 FOR WATERMAIN LAYOUT.

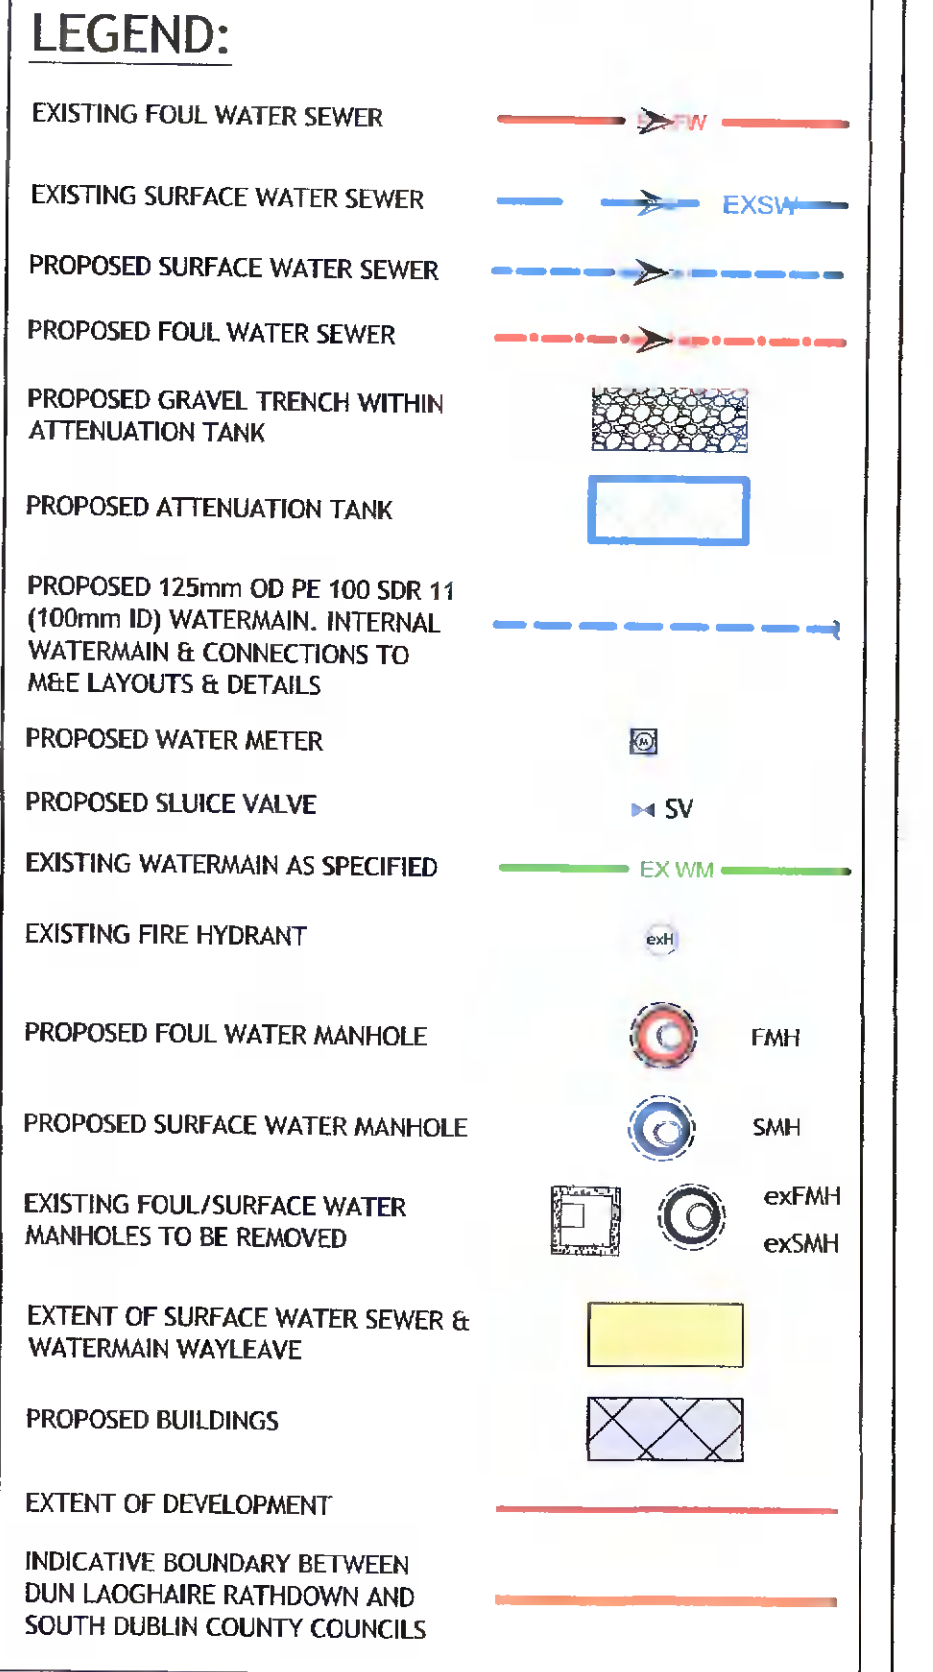

Ordnance Survey Ireland Licence No. EN 0003720
© Ordnance Survey Ireland/Government of Ireland

© PUNCH Consulting Engineers
This drawing and any design herein is the copyright of the Consultants and must not be reproduced without their written consent.
All drawings remain the property of the Consultants.
Figured dimension only to be taken from this drawing.
Consultants to be informed immediately of any discrepancies before work proceeds.
COLOUR DRAWING



Rev	Amendment	By	Date	Rev	Amendment	By	Date
C01	PLANNING ISSUE	IBS	2021/04/19				
C02	PLANNING FI RESPONSE	DAP	2021/09/16				

Client:
SIRIO HOMES



Project:	RESIDENTIAL DEVELOPMENT, NUTGROVE AVENUE, RATHFARNHAM, DUBLIN						
Title:	COMBINED EXISTING AND PROPOSED DRAINAGE AND WATERMAIN OVERLAY						
Drawn:	IBS	Project Manager:	JANUARY 2021	Technical Director:	IBS	Engineer in Charge:	MR
Project No:	202252	Approval:	202252-PUNCH-XX-XX-H2-C-0102	Drawn Status:	AD	Approval:	PC
Scale @ A1:	1:200	Document No:	202252-PUNCH-XX-XX-DR-C-0102	Revision No:		Revision No:	C02