




1 Underground WTP, Tanks and Generator Plan  
1:200

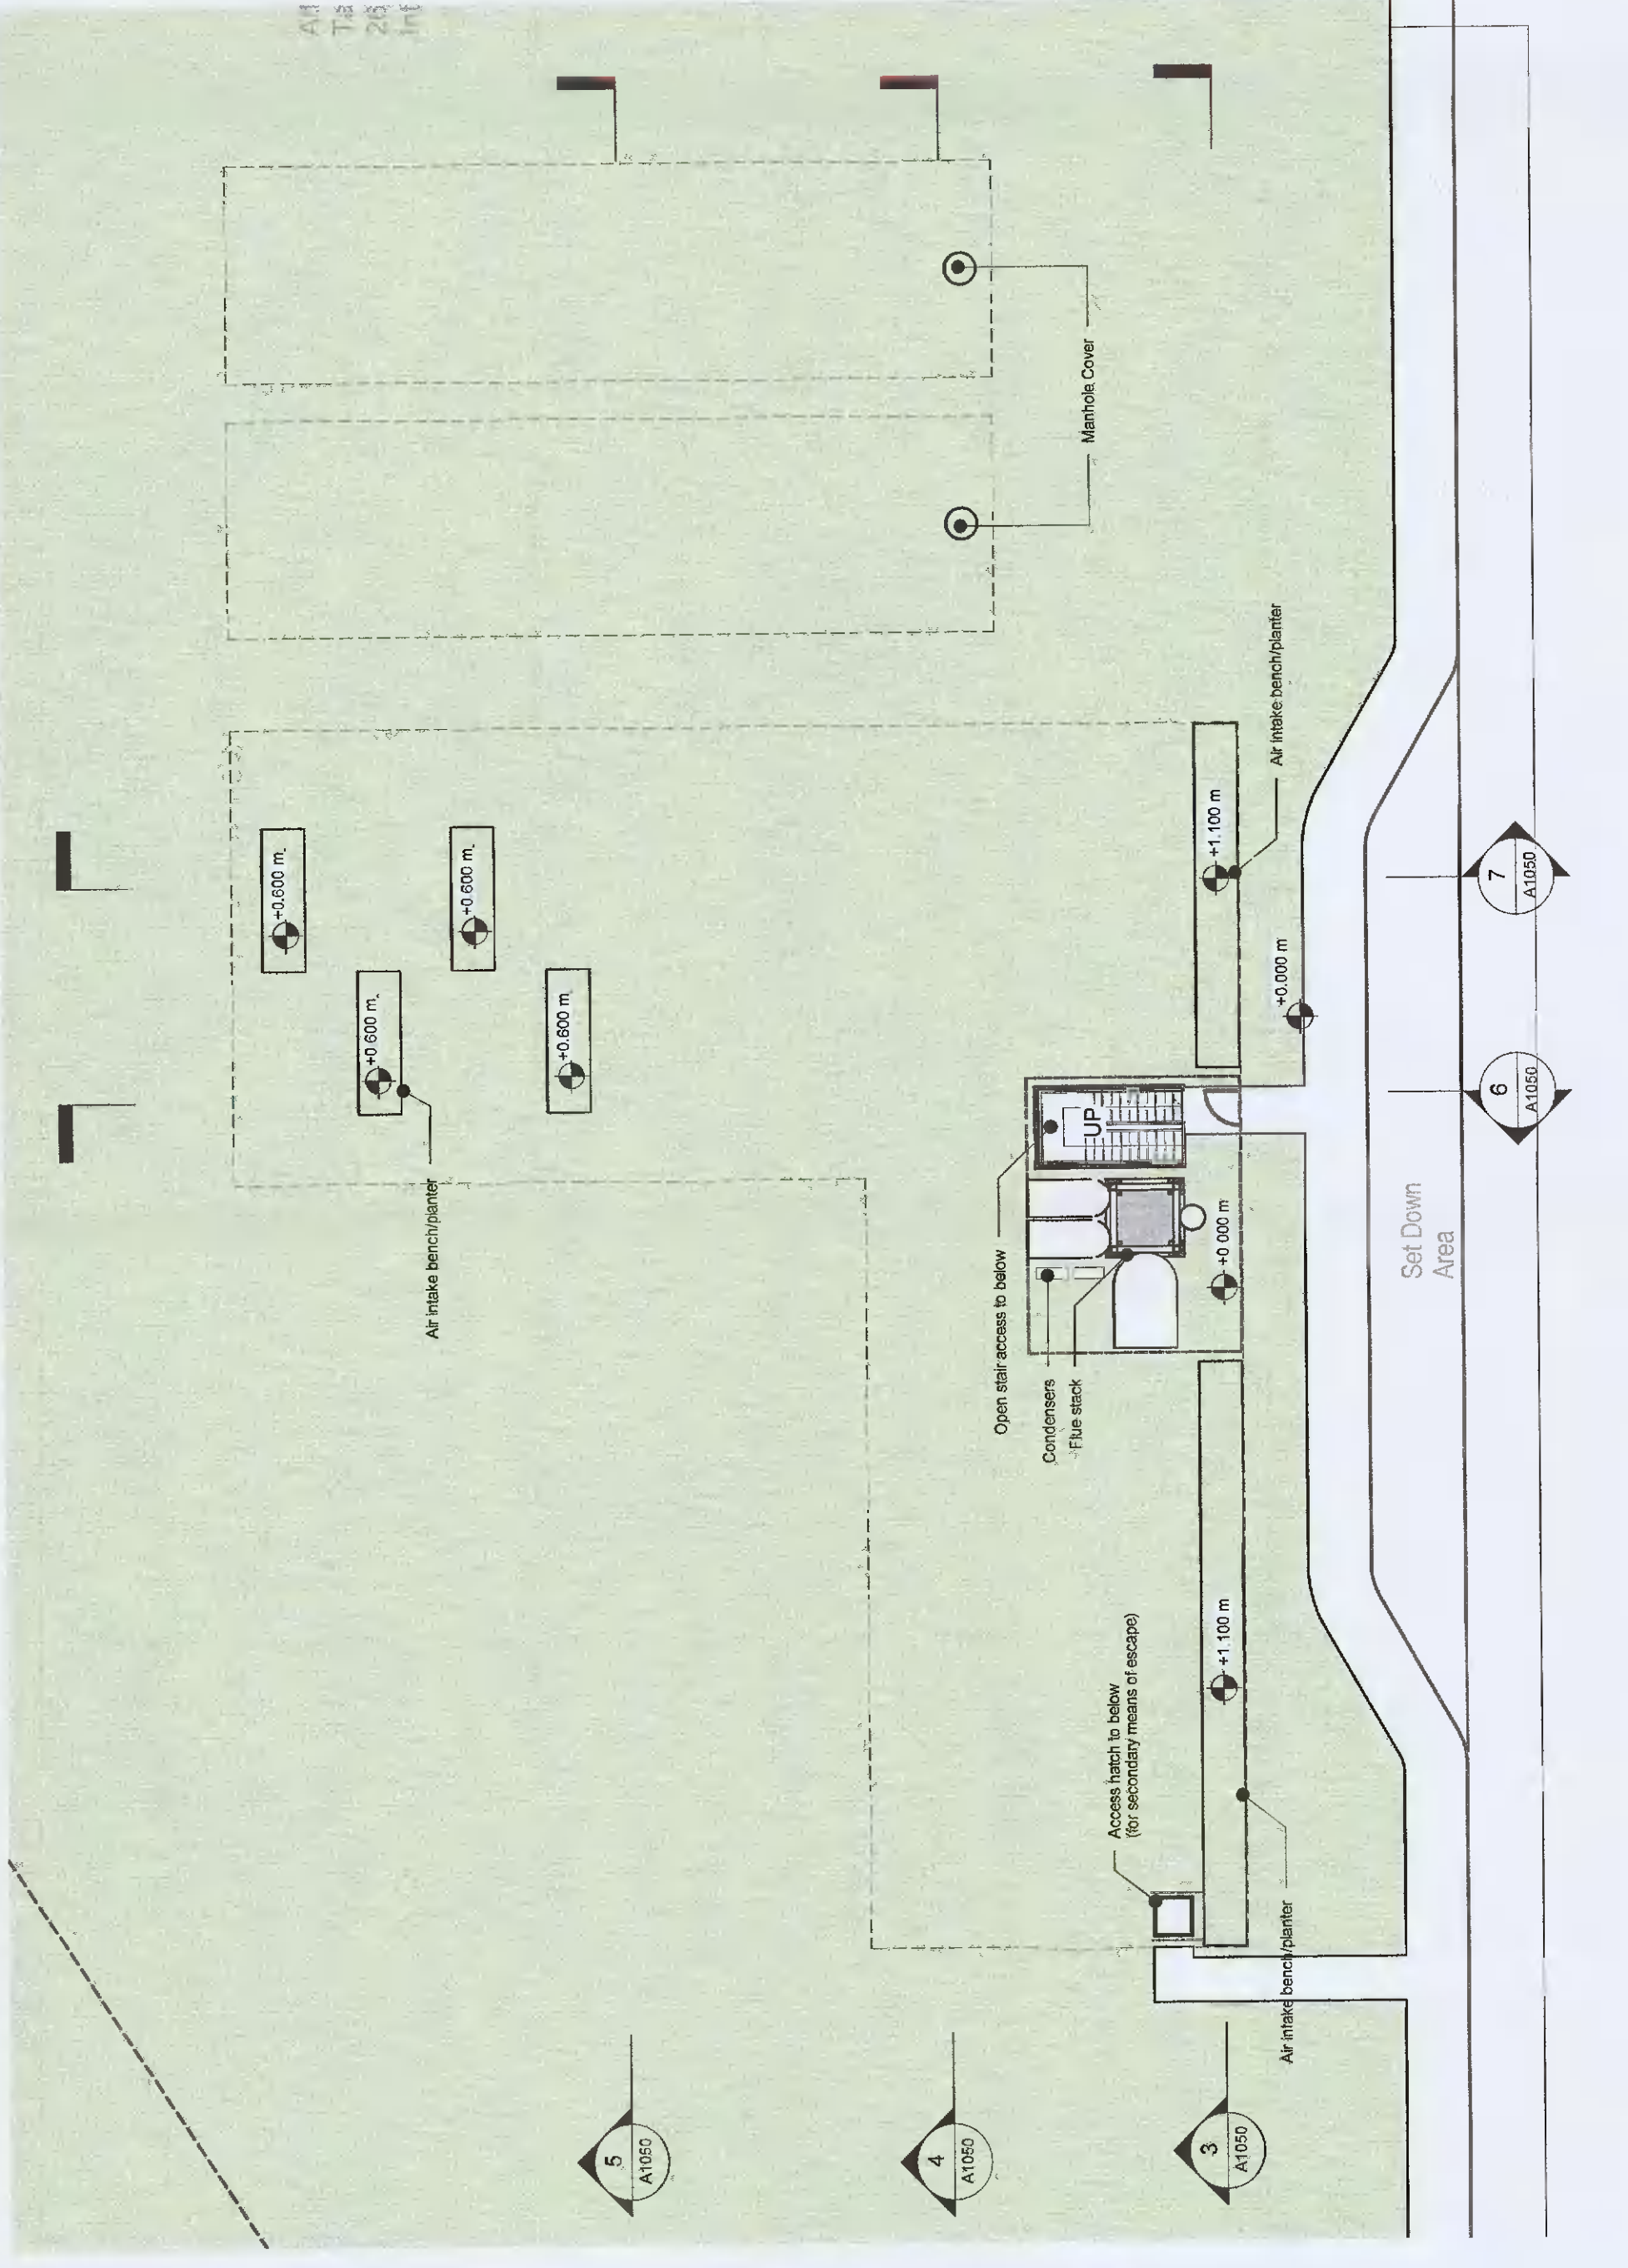


2 Underground WTP, Tanks and Generator Plan  
1:200

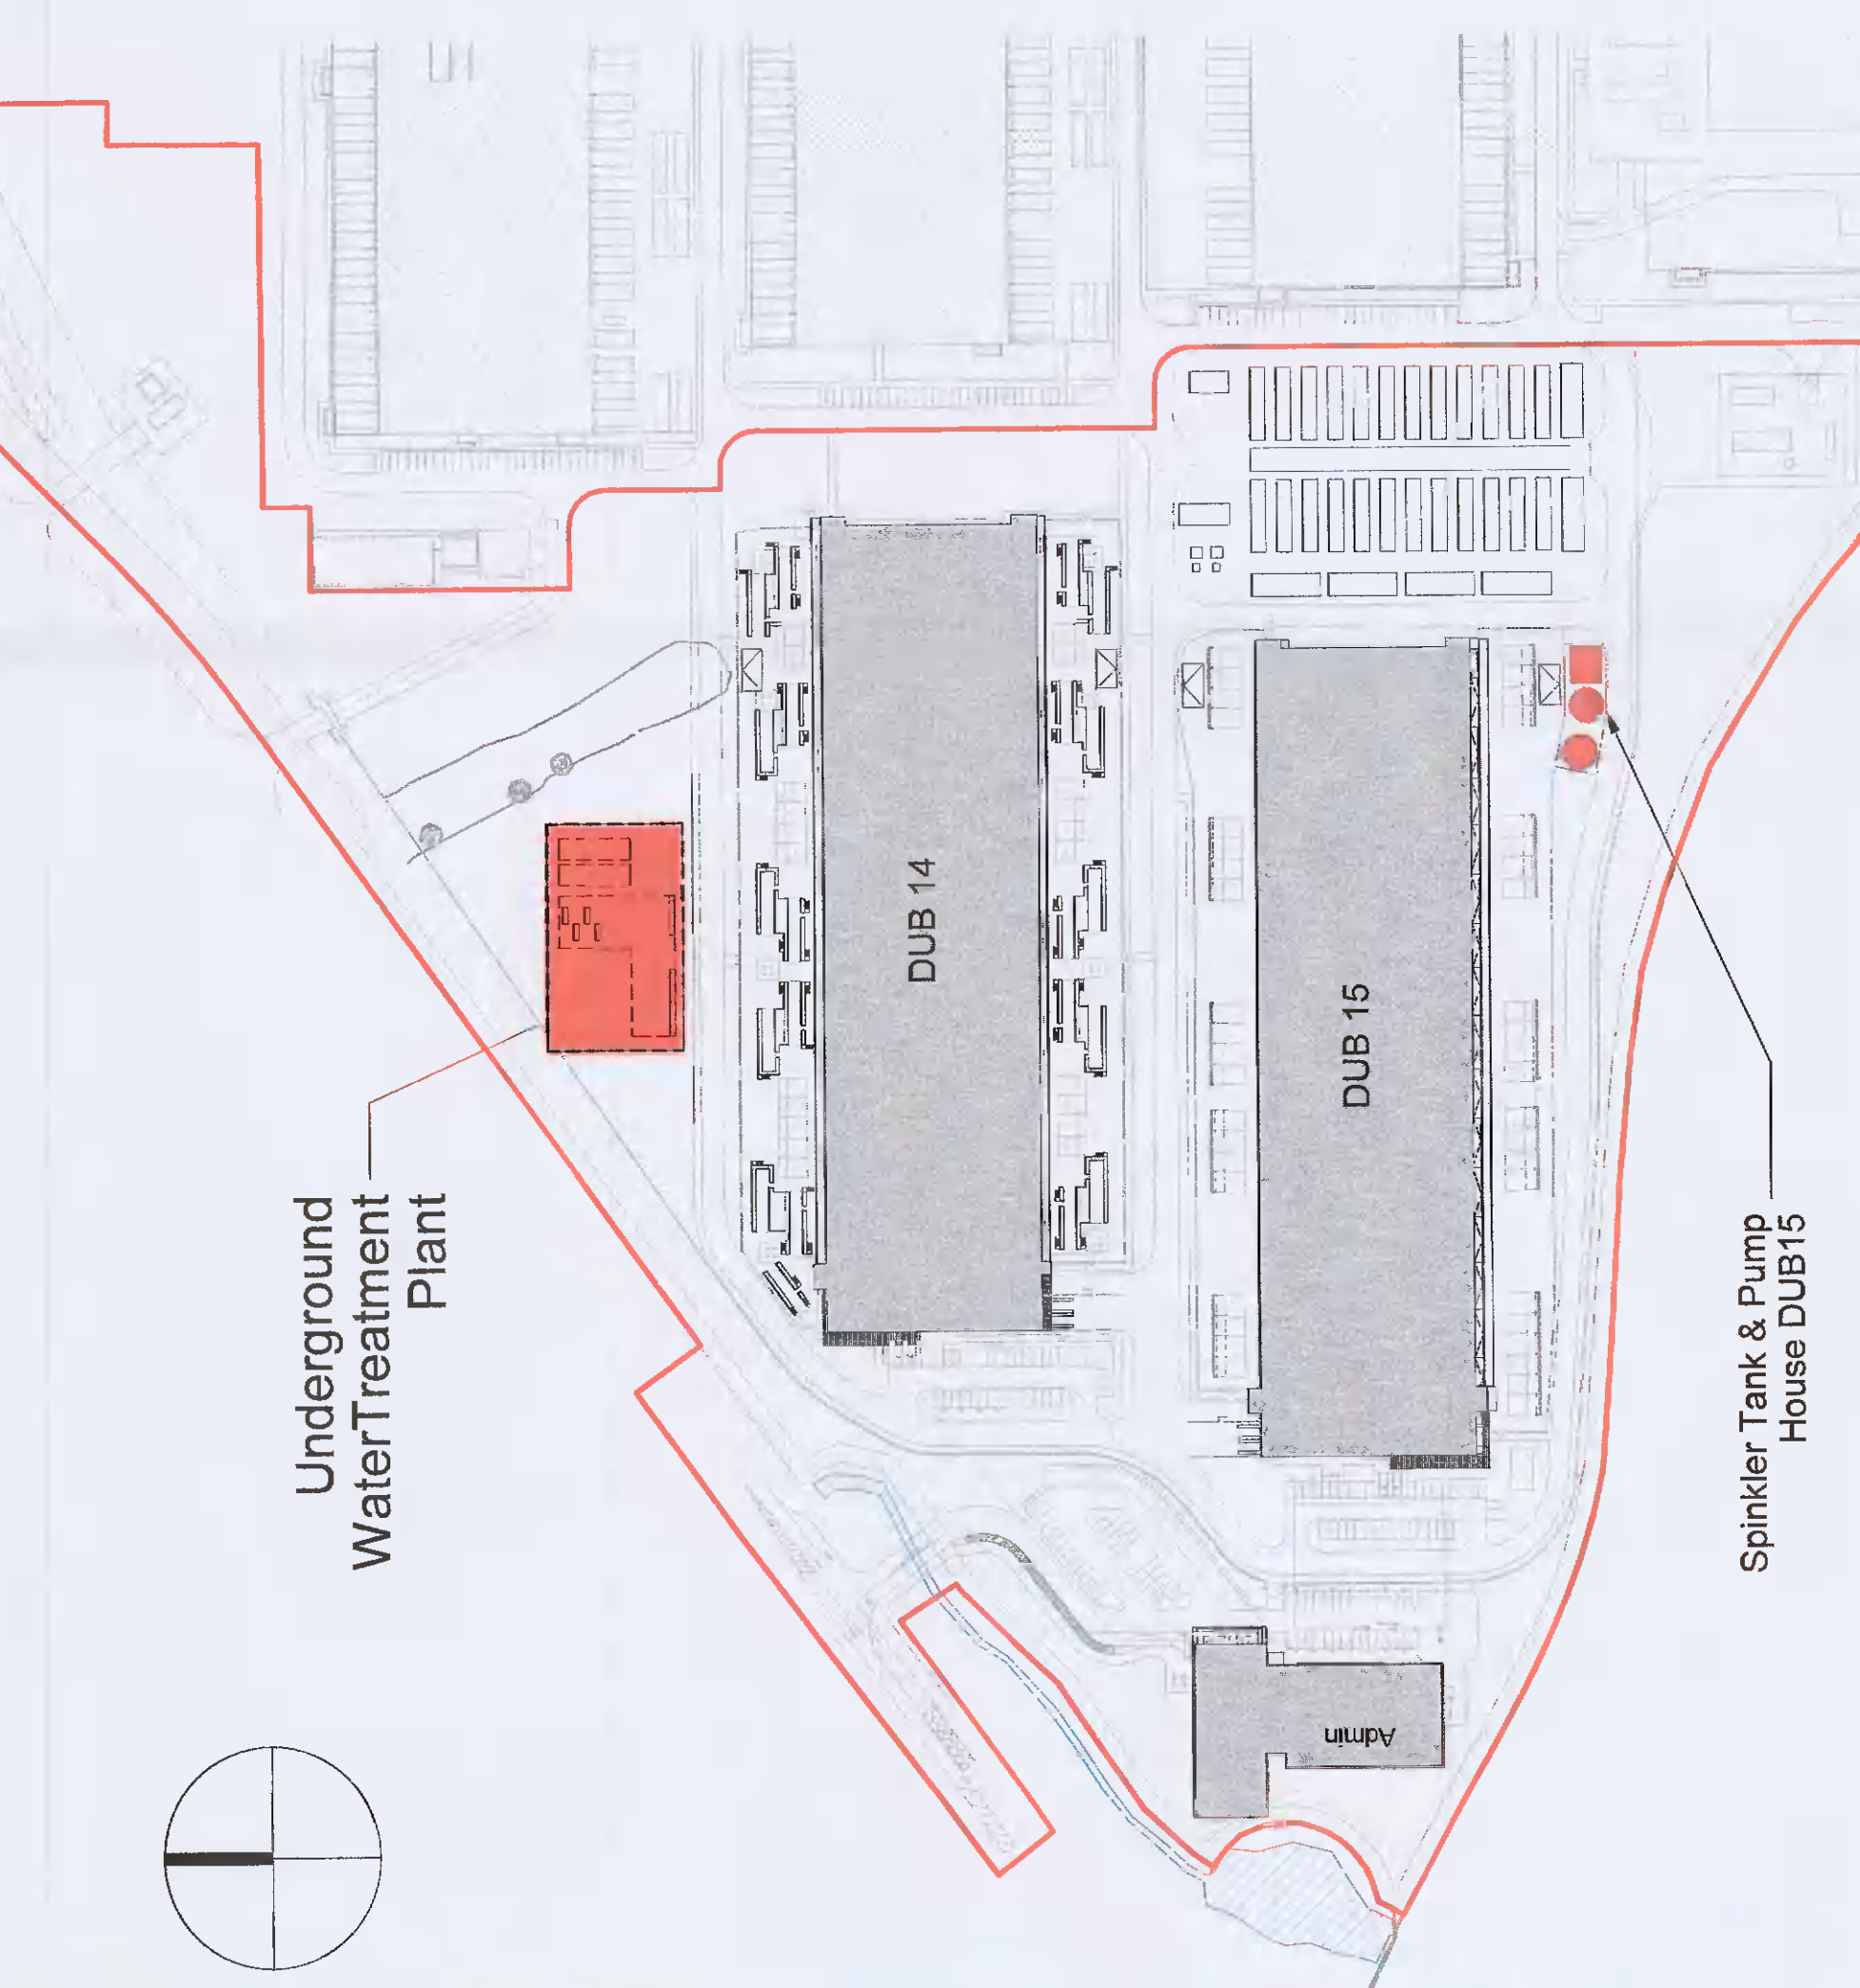


3 Underground WTP, Tanks and Generator Plan  
1:200

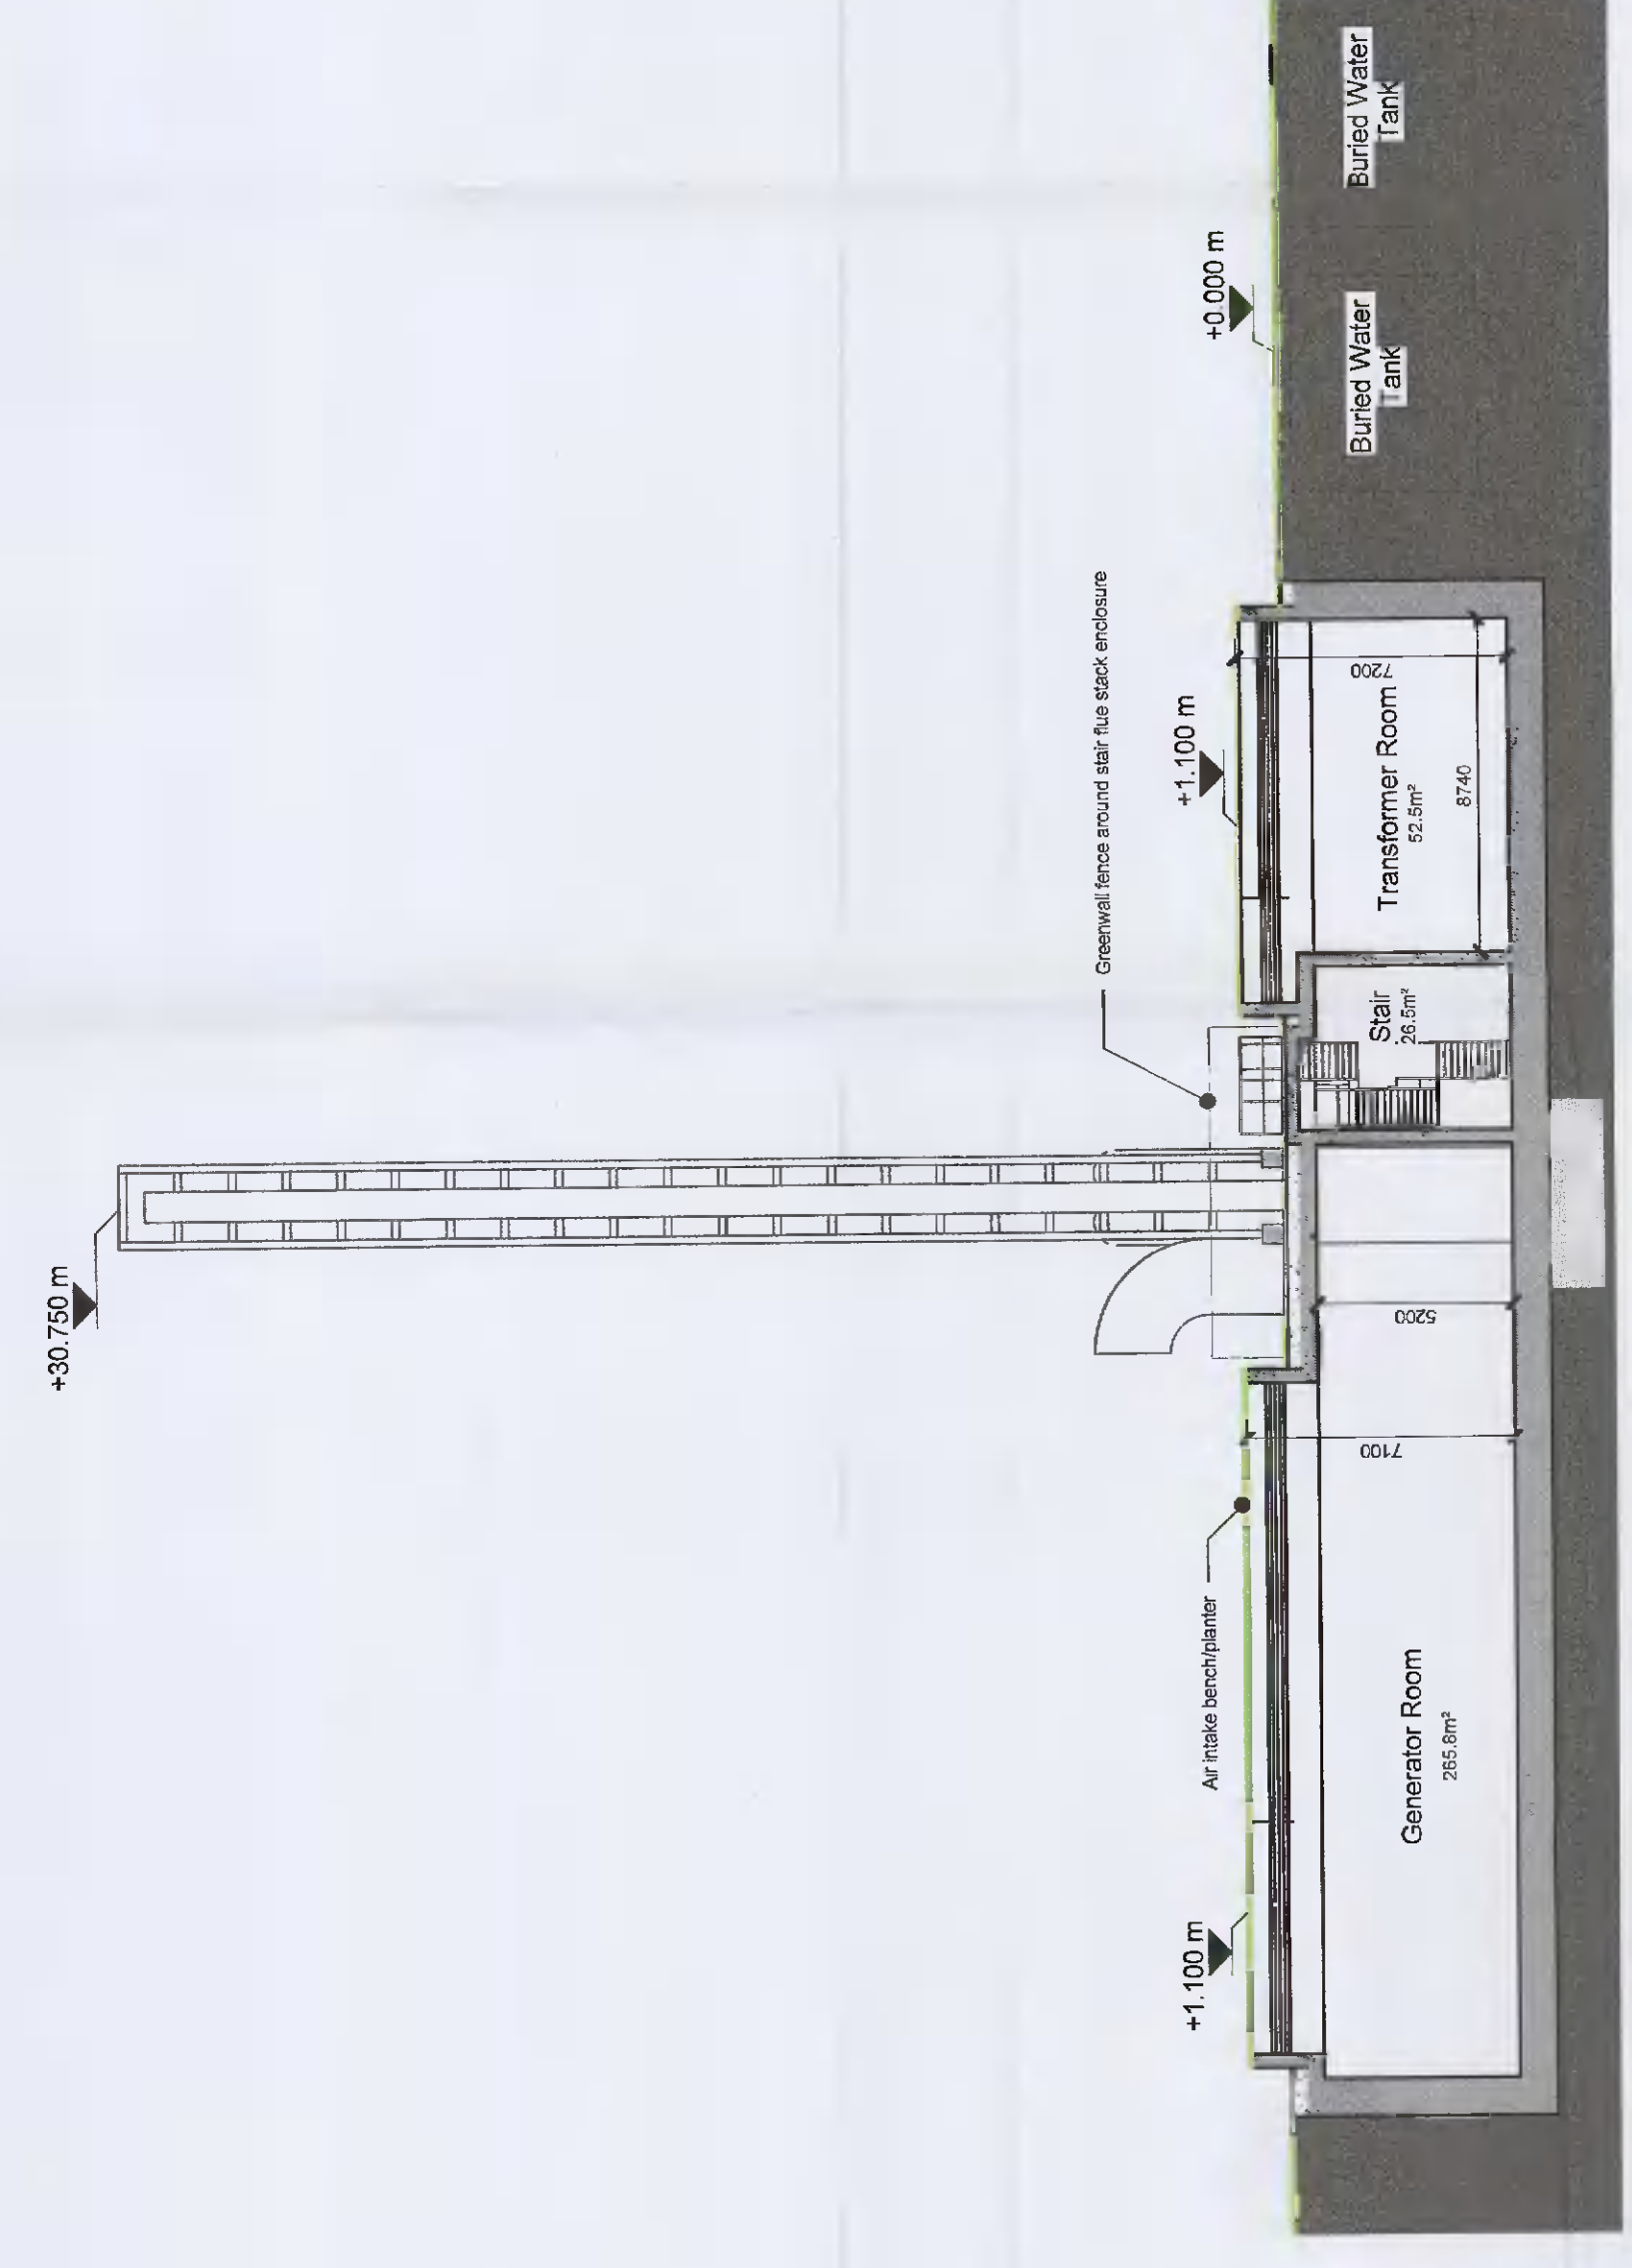


4 Underground WTP, Section 1  
1:200

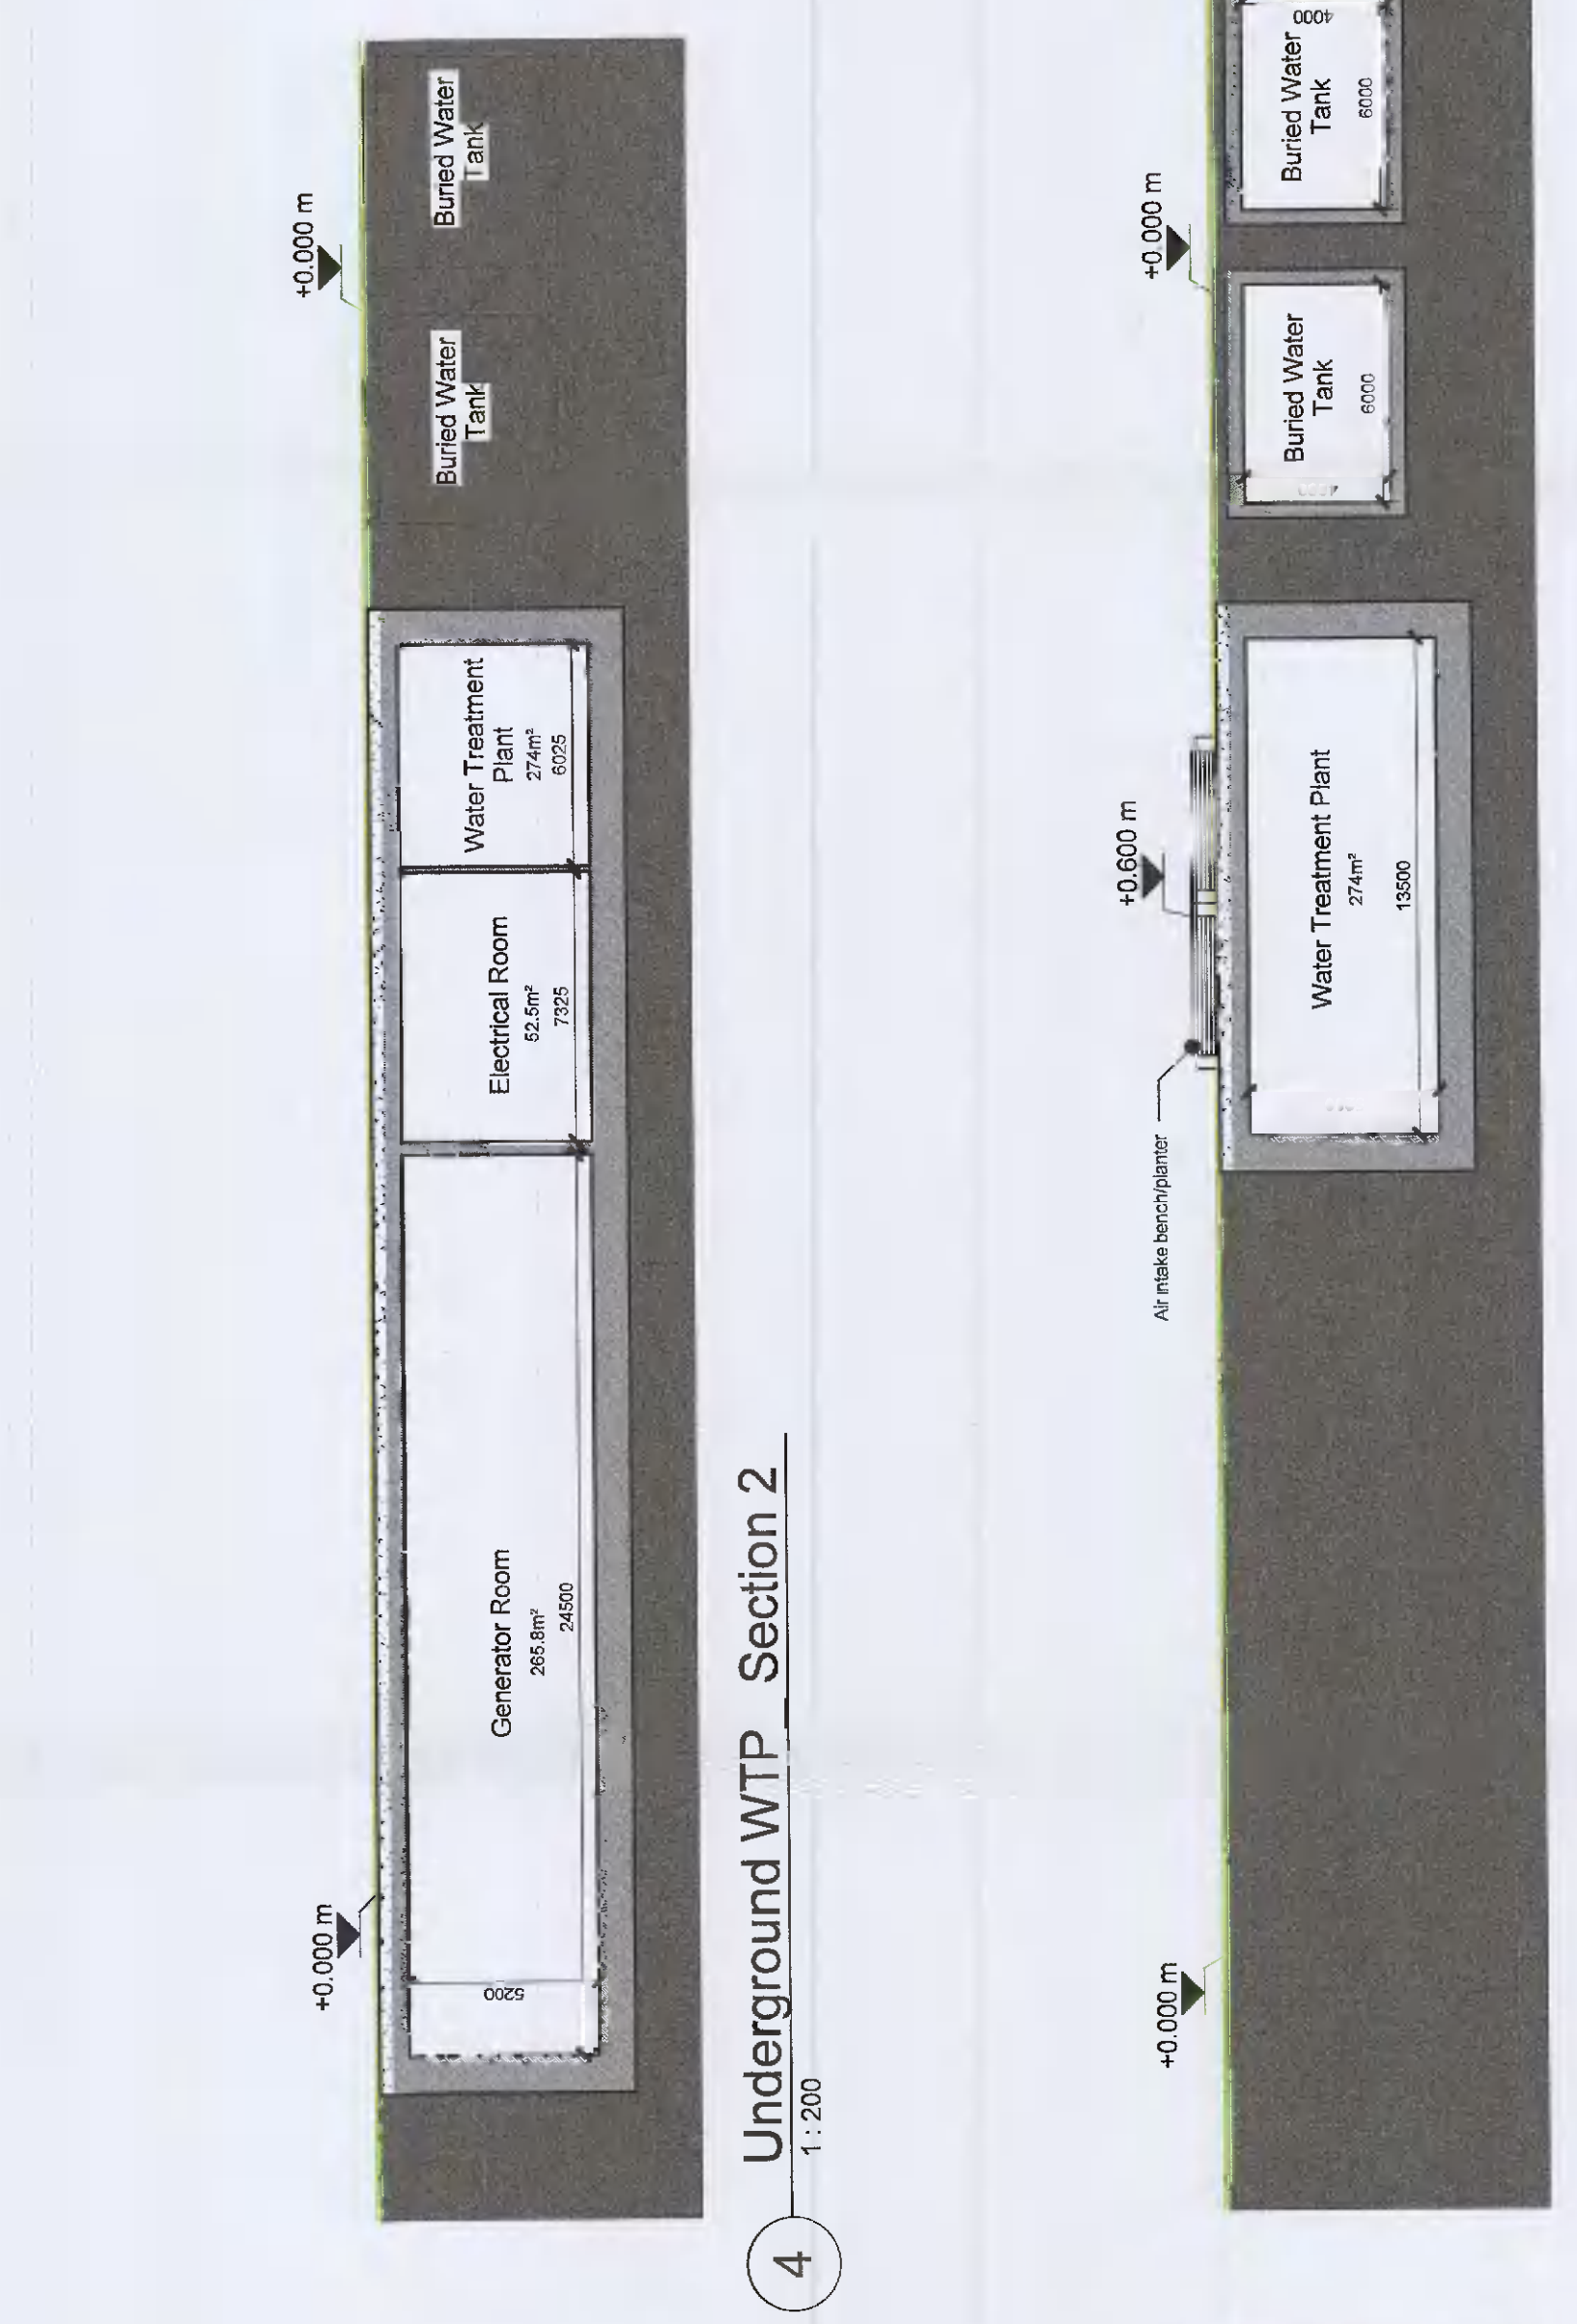

5 Underground WTP, Section 2  
1:200

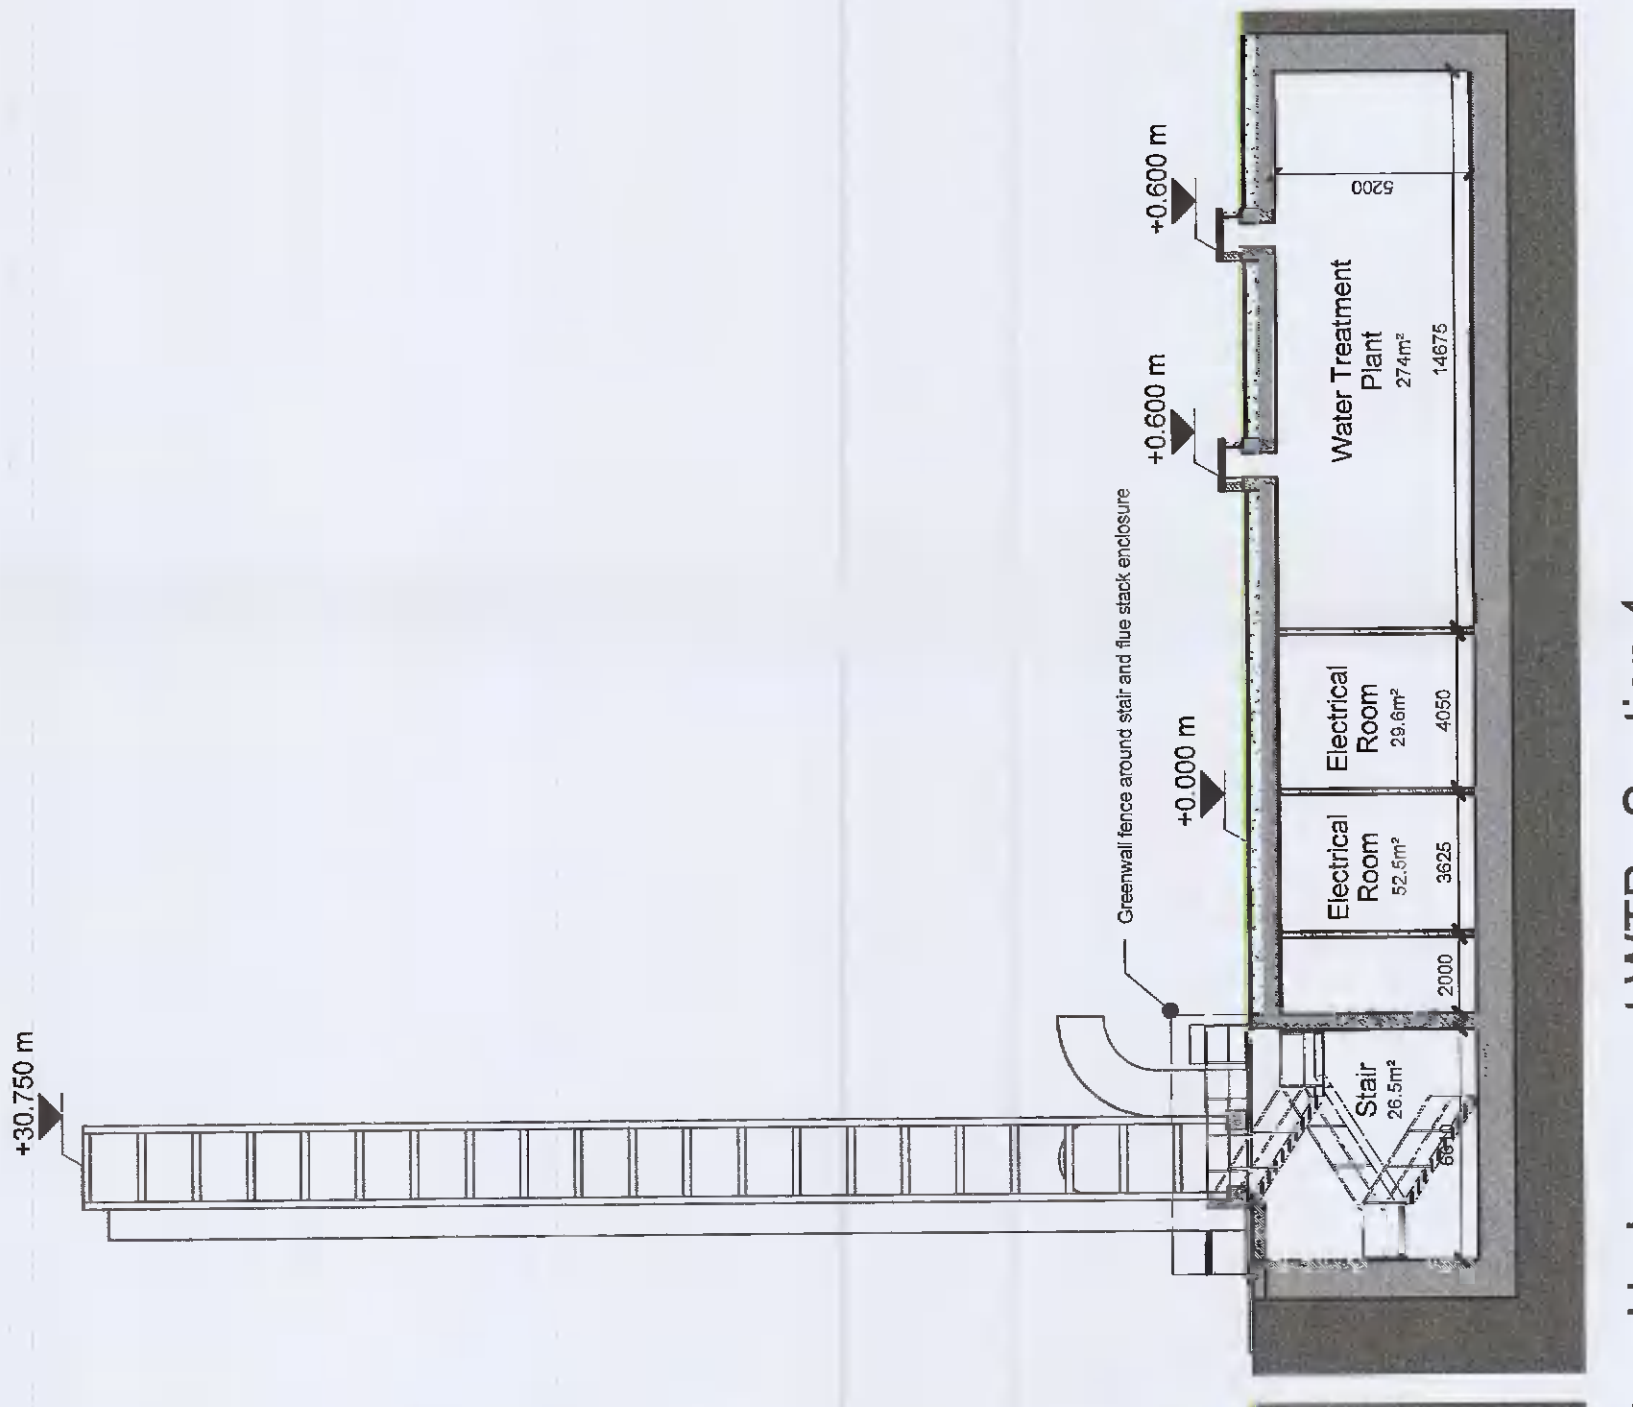

6 Underground WTP, Section 3  
1:200

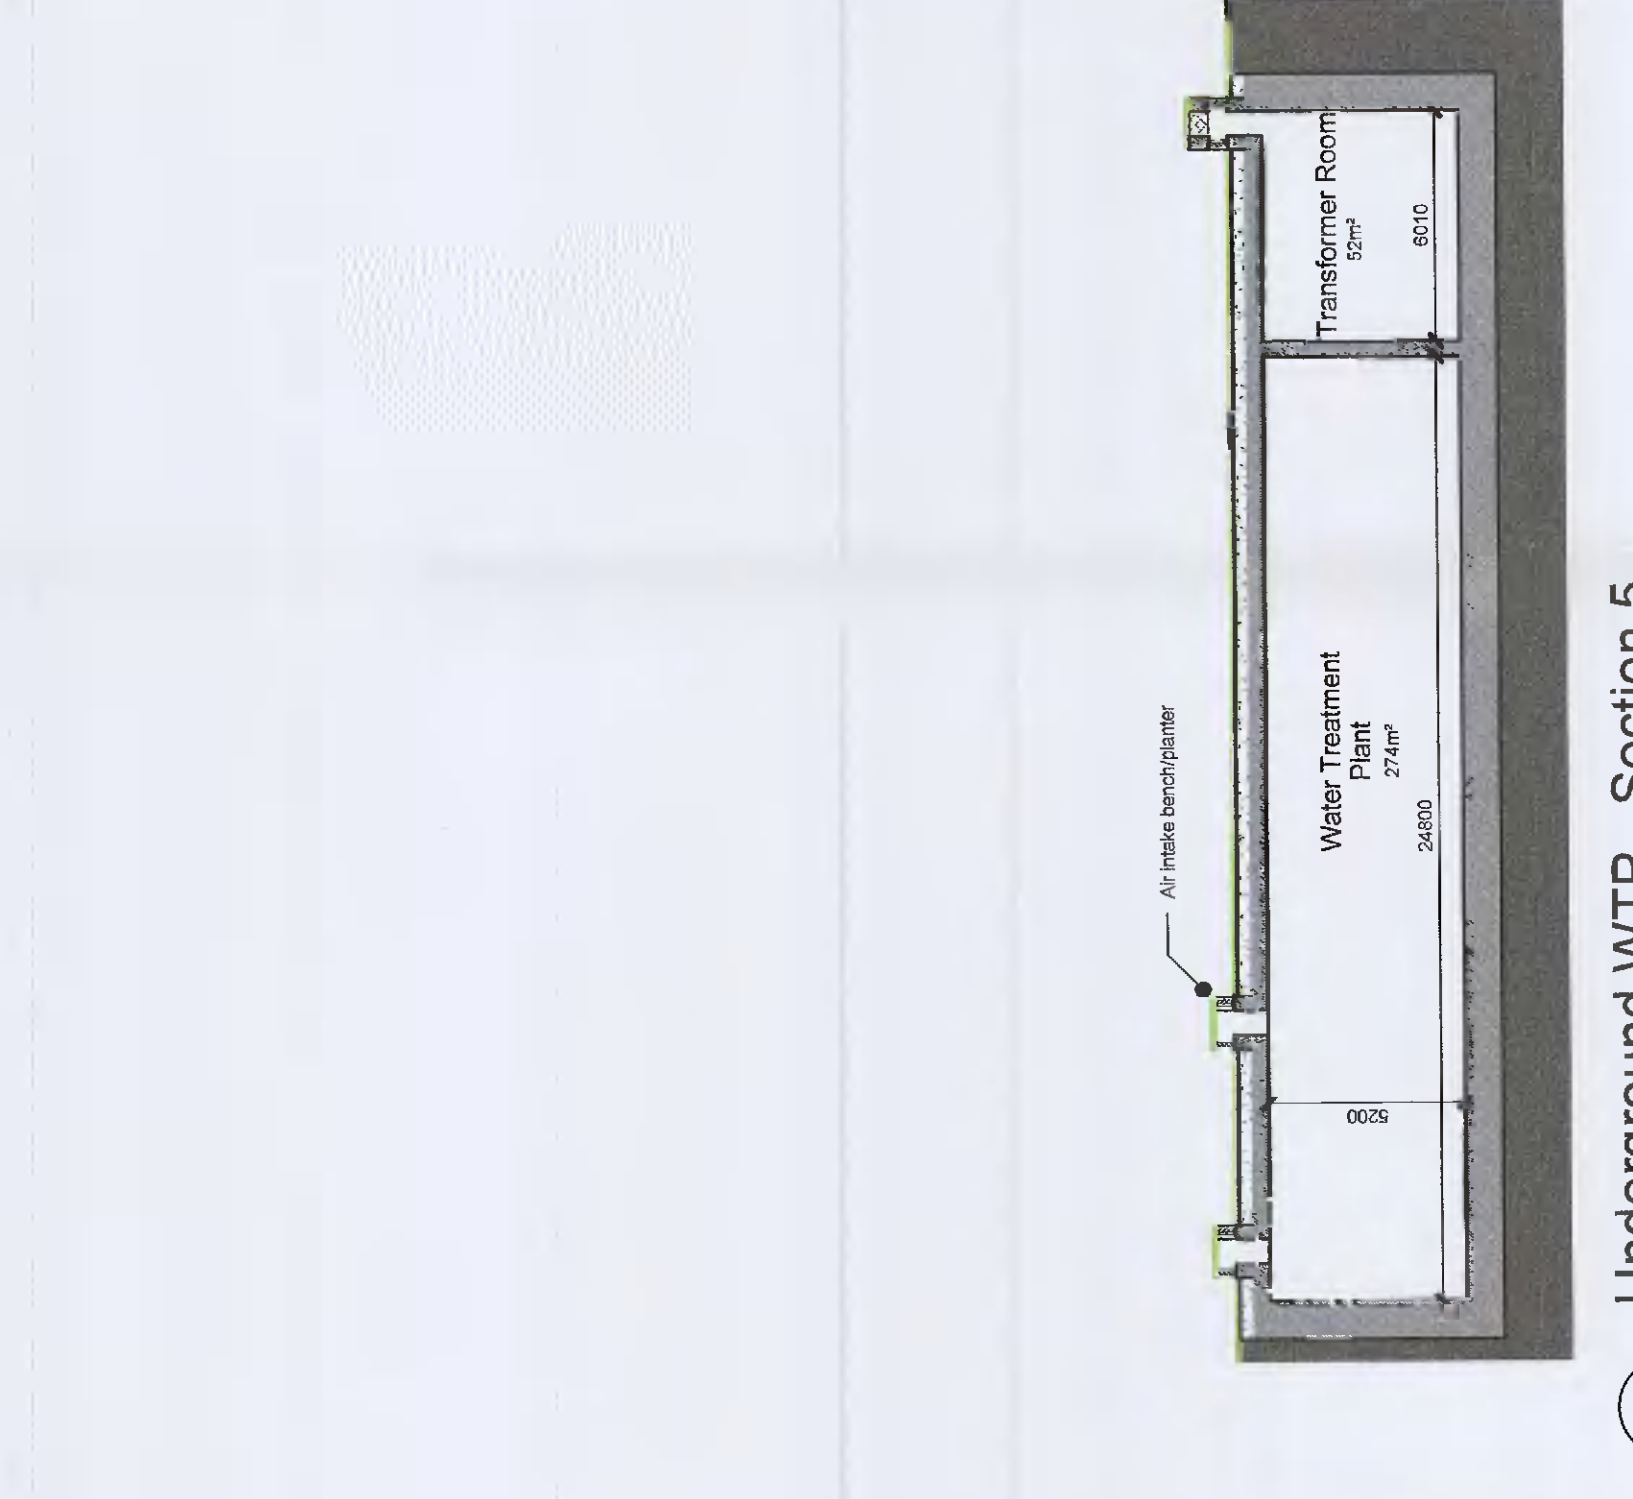


7 Underground WTP, Section 4  
1:200


8 Underground WTP, Section 5  
1:200

9 Underground WTP, Section 6  
1:200

10 Underground WTP, Section 7  
1:200

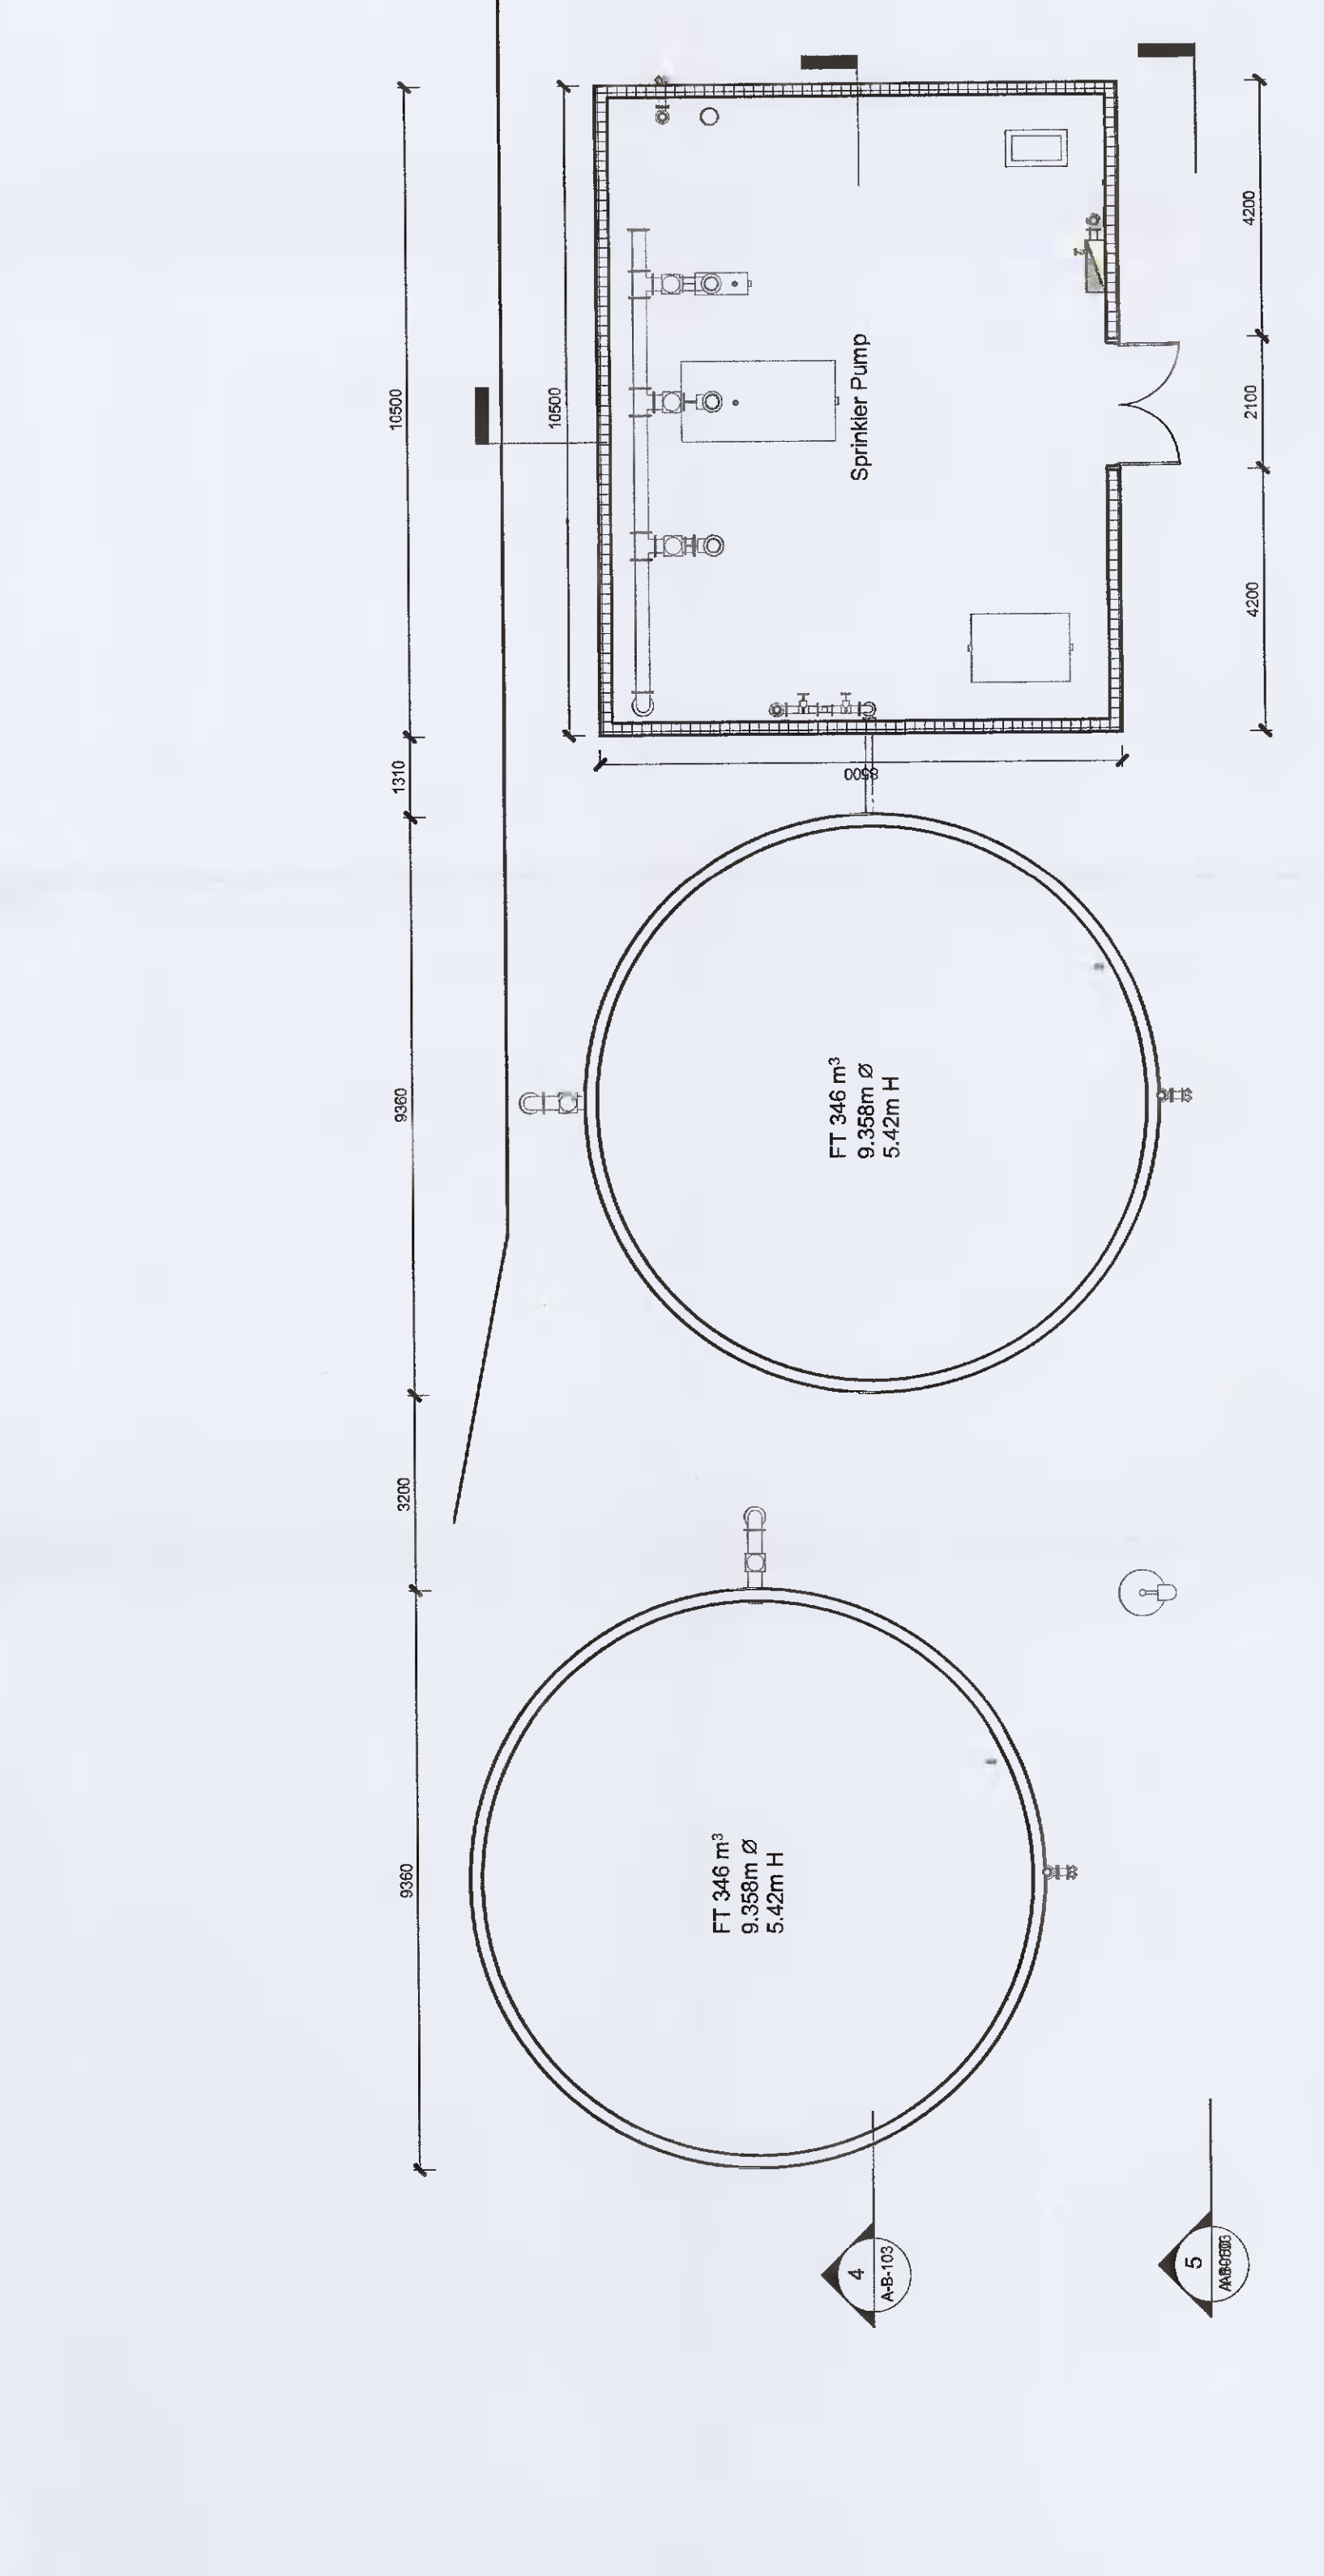

10 Sprinkler Pump and Tank DUB15 Ground Floor  
1:100

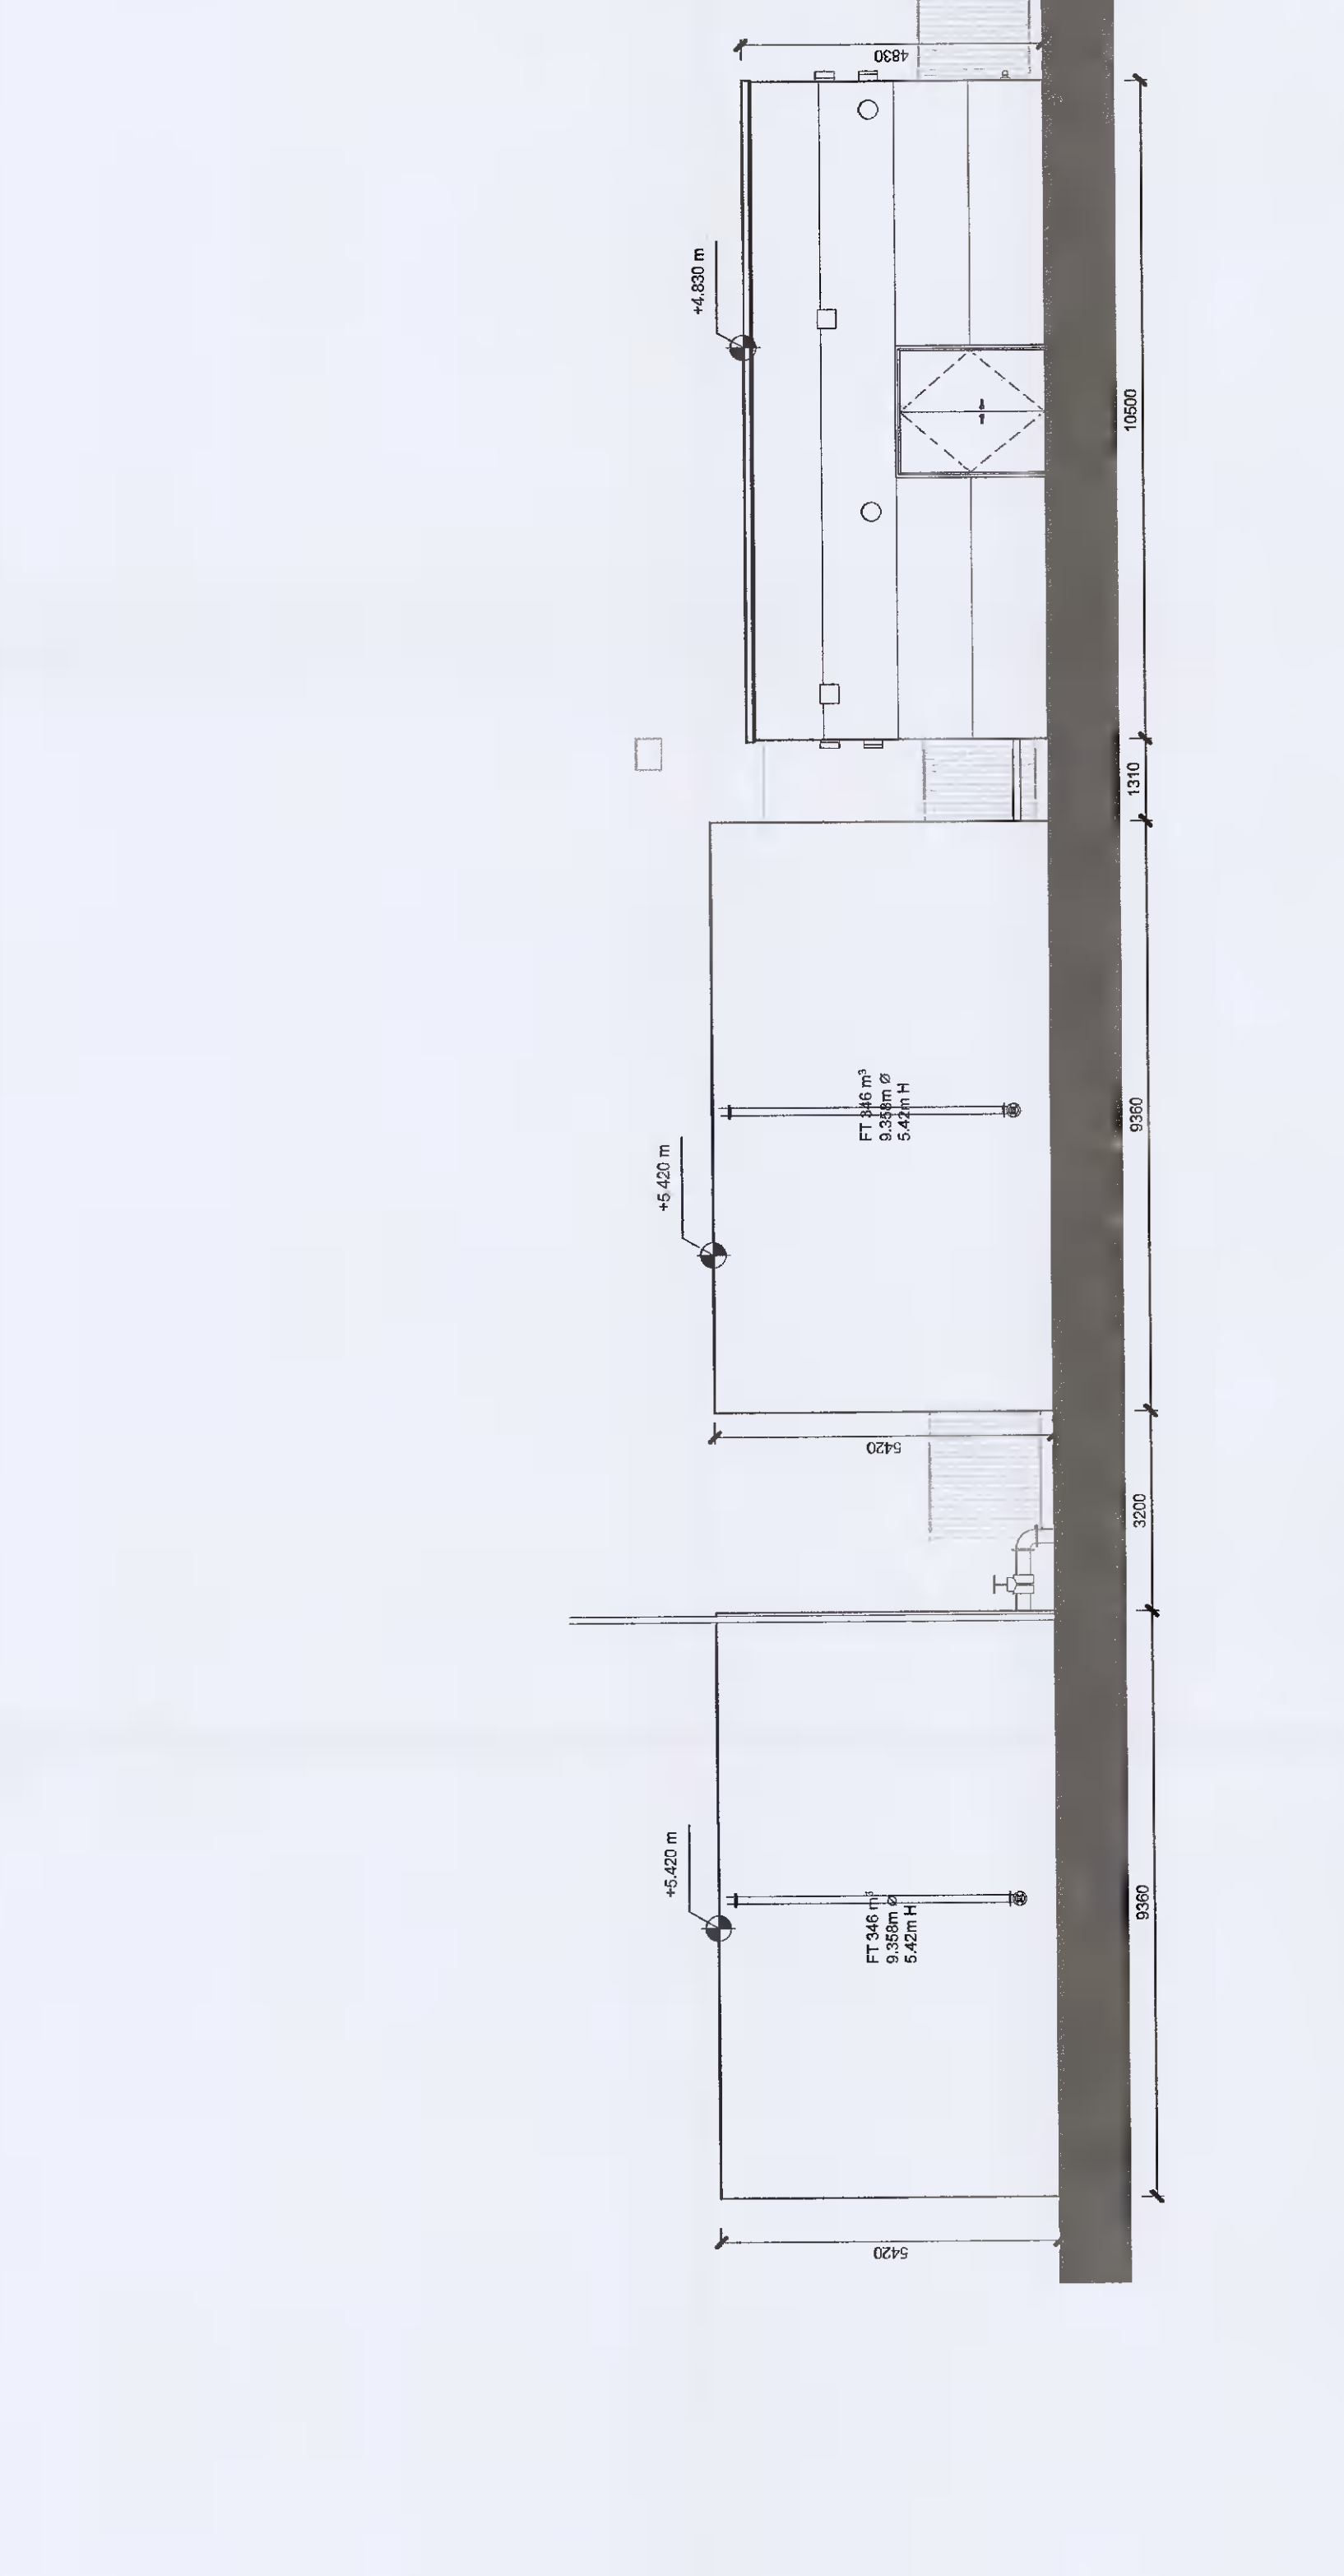

11 Sprinkler Pump and Tank DUB15 South Elevation  
1:100

ARUP  
 Microsoft  
 Project No: DUB 14/15  
 Proposed Modifications to Previously Approved Scheme SDA0283  
 Drawing Title: Proposed Sprinkler Tank and Pump House Details  
 Scale: As Indicated  
 By: COLLEEN S. JAMES  
 Rev: Architecture  
 Status: SD - Stable for Information - Planning -  
 App. Job No: 279225  
 Rev: P02  
 ID: A1050