


**Notes:-**  
 All drawings to be read in conjunction with Architects drawings.  
 Do not scale off these drawings - use figured dimensions only  
 All dimensions to be checked on site  
 All work to comply with the 2014 Building Control (Amendment) Regulations

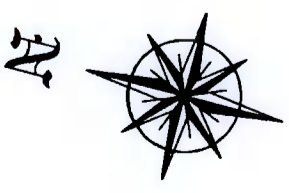

# Planning Drawings

**O'NEILL CONSULTANT ENGINEERING SERVICES**


1 Moat House, Main Street  
 Ratoath, Co Meath  
 (t) 01 697 8260  
 www.oneilles.ie

job 6 Lower Main Street, Lucan,  
 Co Dublin, K78 W0X2

client Finance Solutions

title Drainage Layout

date	drawn by	scale
14.10.21	L.Beggy	1:75 @ A3
dwg no.	rev no.	reference
933-02-003	-	-

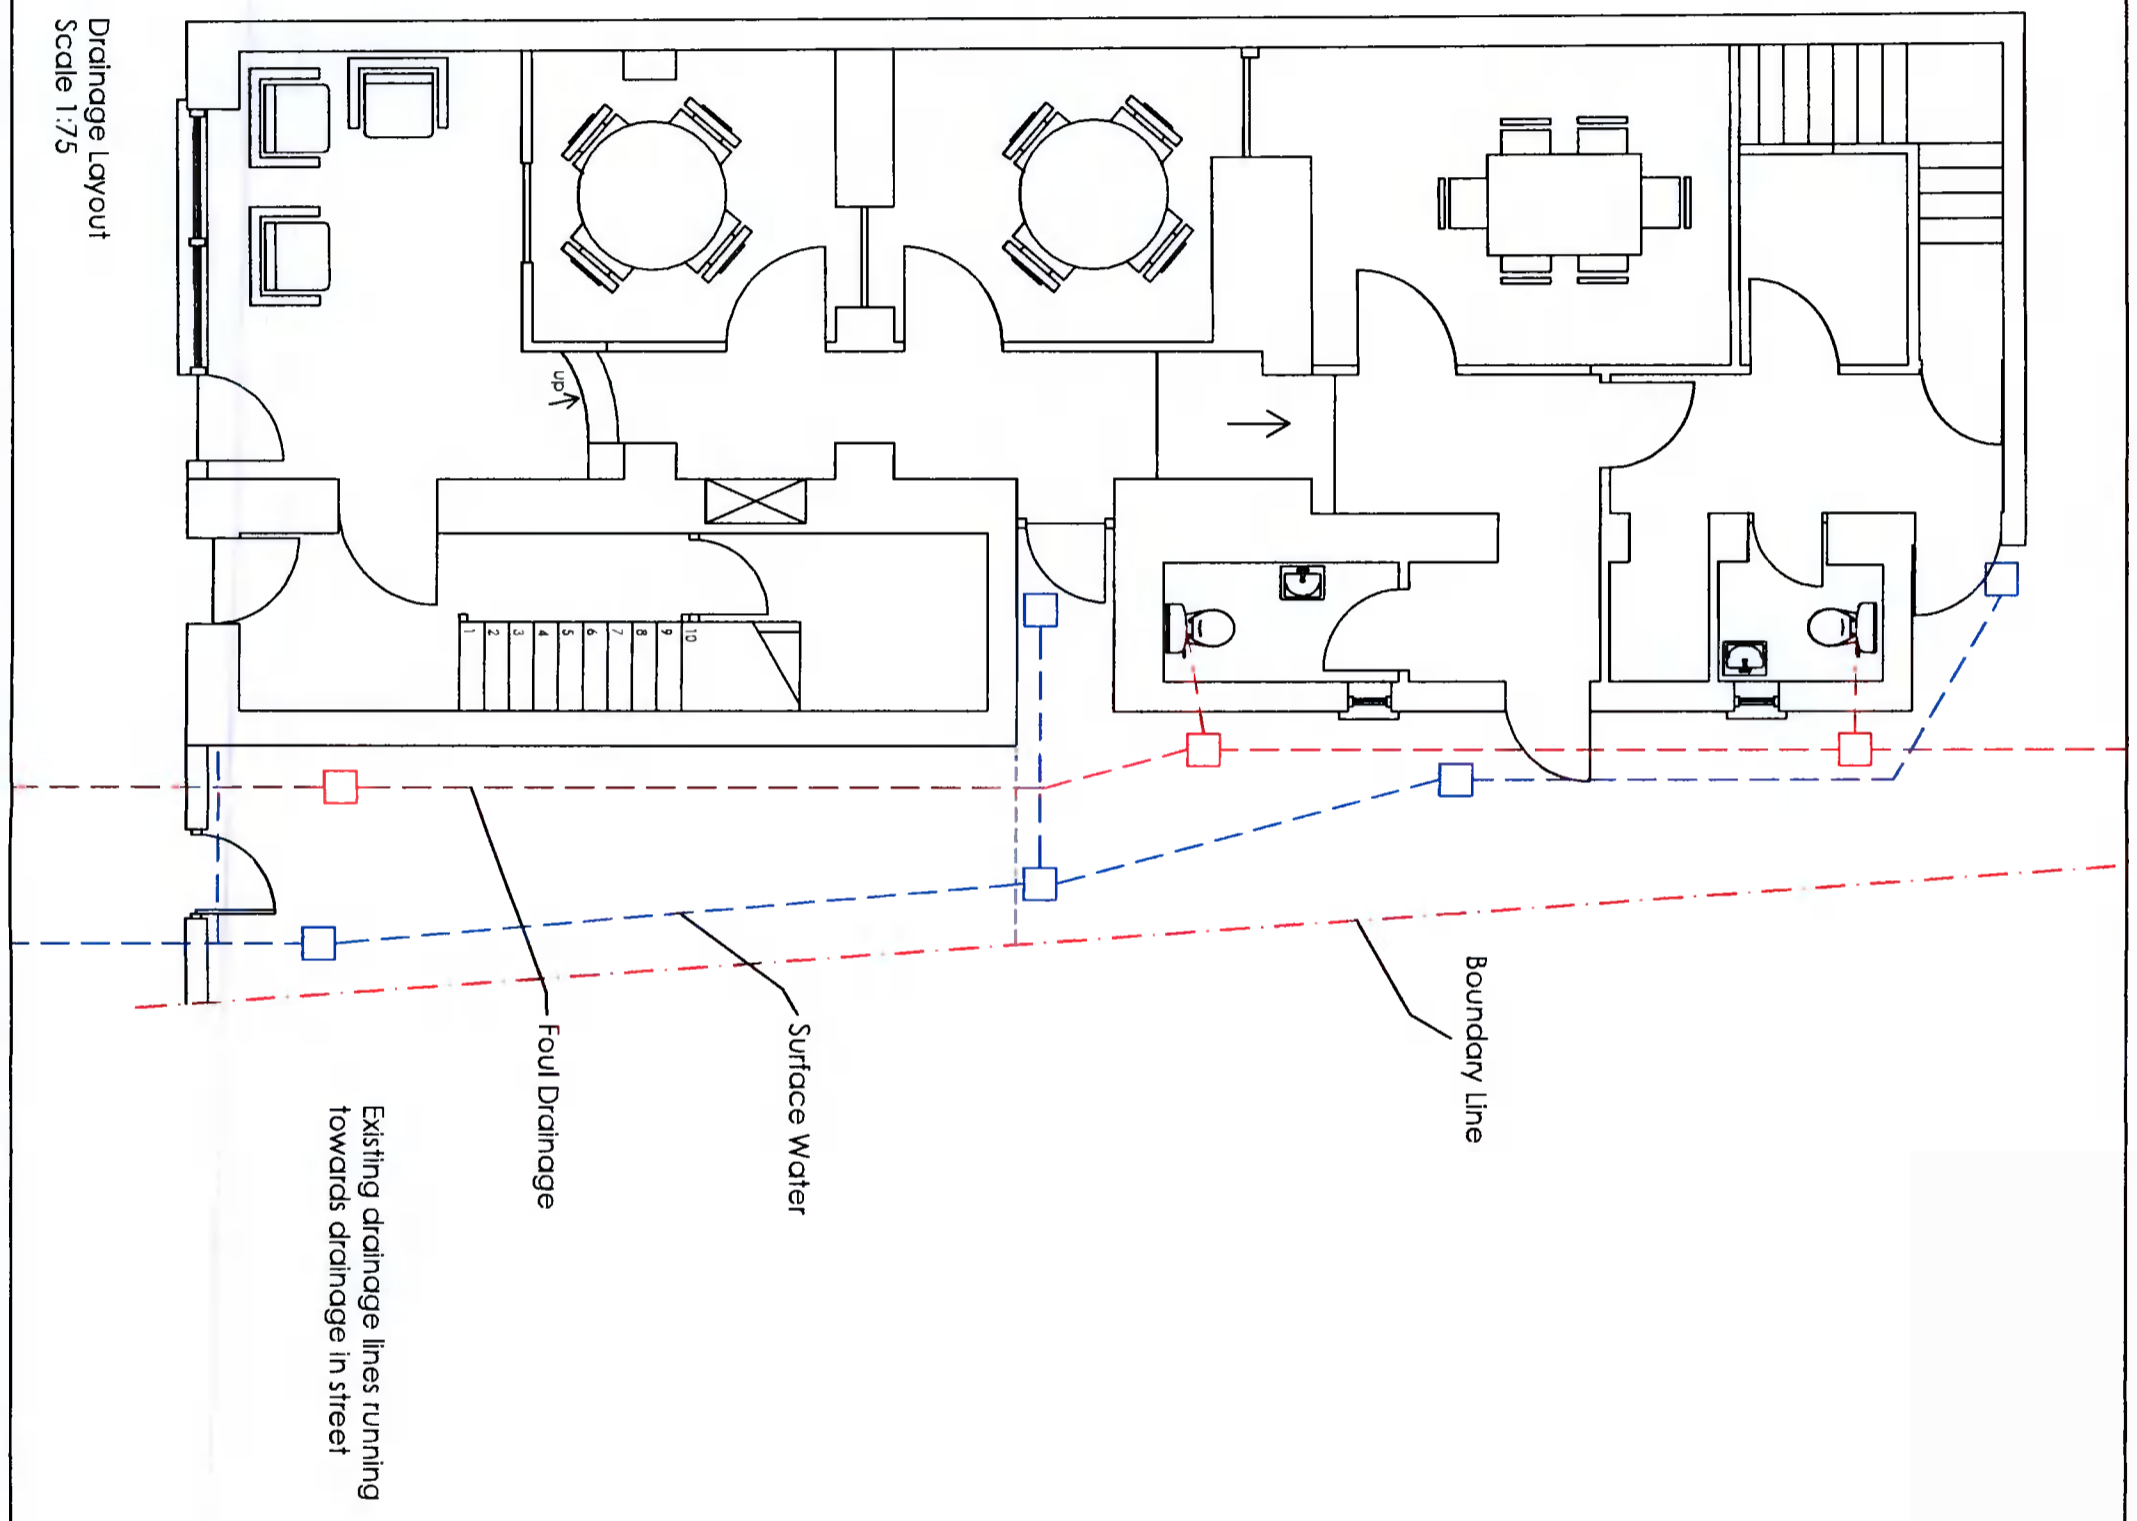

Drainage Layout  
 Scale 1:75