


O.S. SITE LOCATION MAP

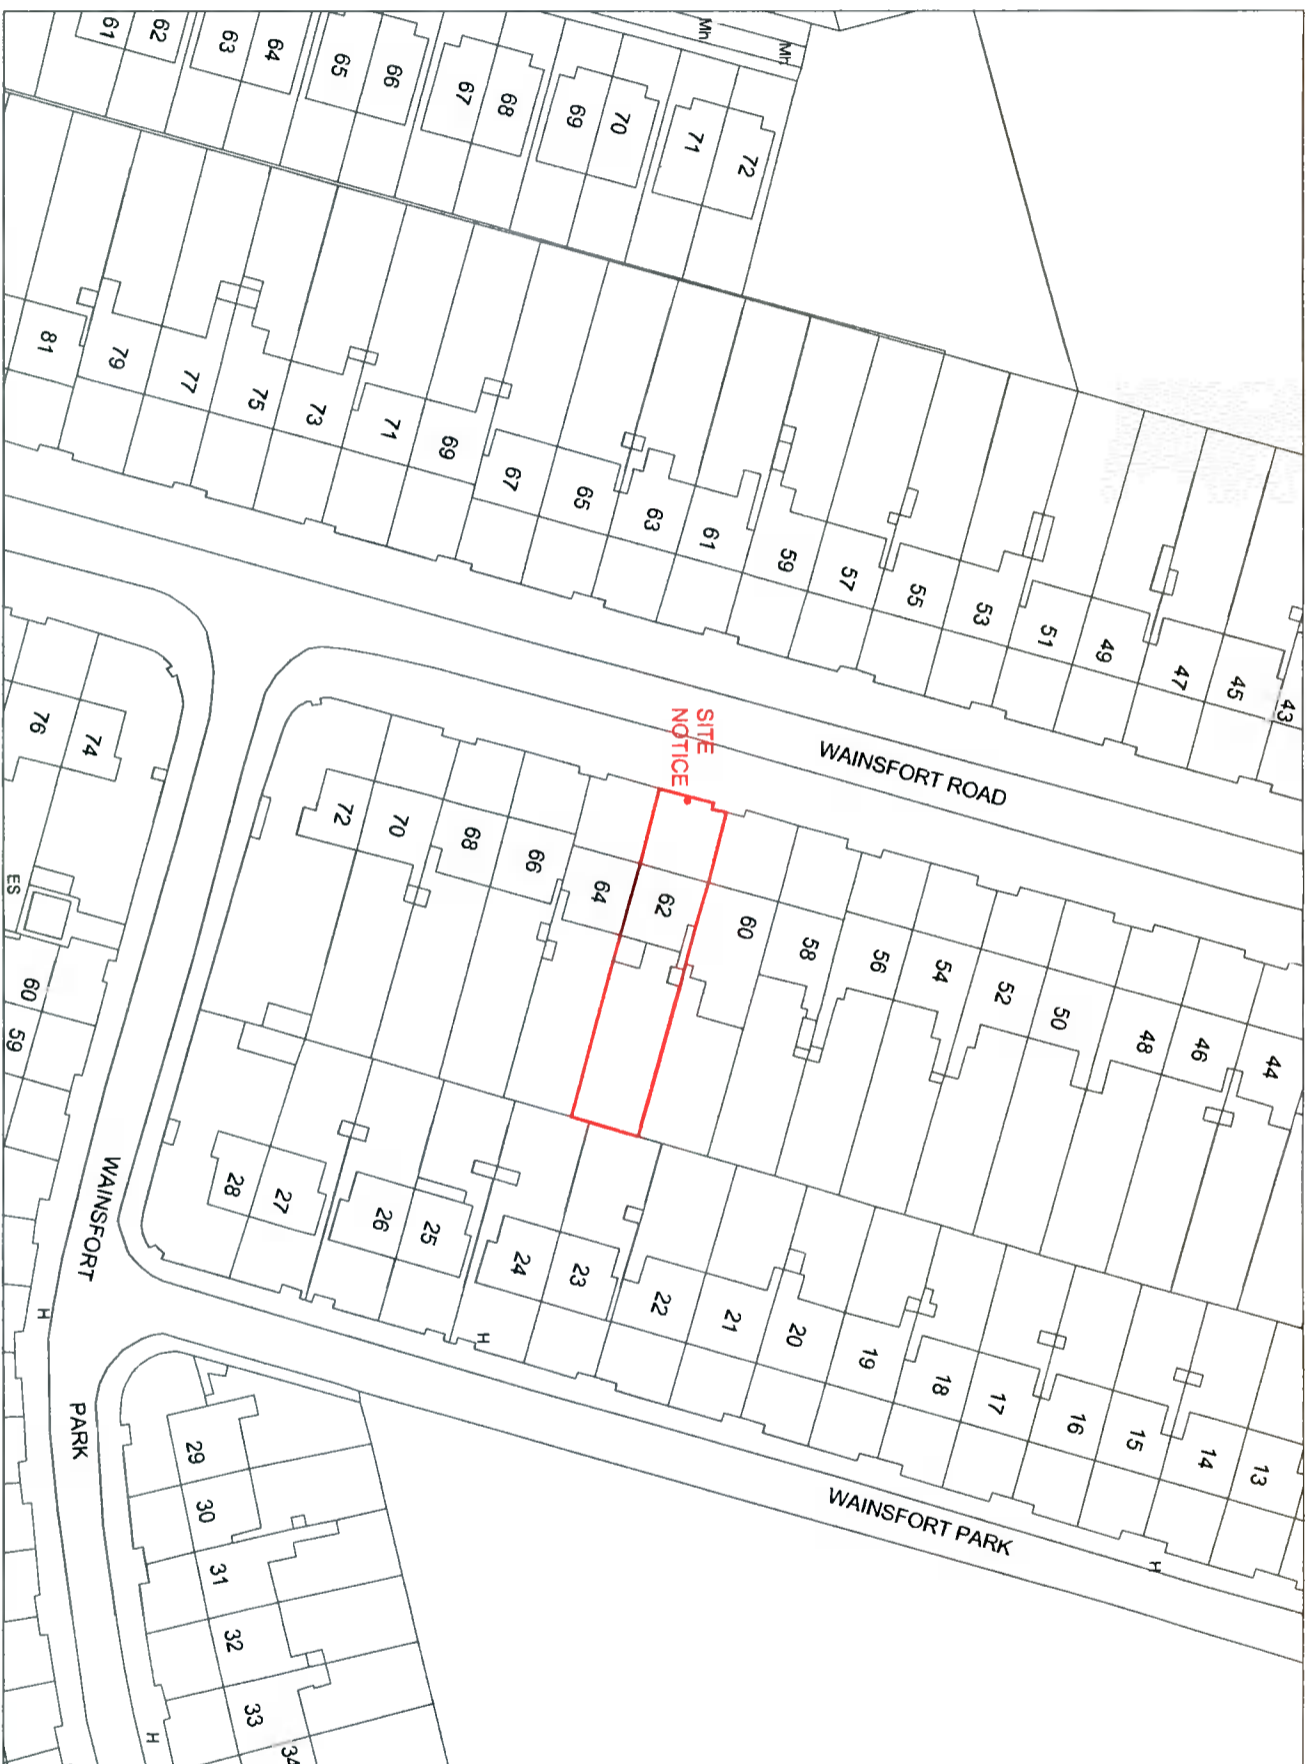

**62 WAINSFORT ROAD,
TERENURE,
DUBLIN 6W,
D6W YY65**

**ITM CENTRE PT COORDS
X,Y= 7112934.34,729925.74
SHEET NUMBER: 3328-17**

Notes

1. Copyright Reserved
2. Work to figure dimensions only. Do not scale drawing.
3. The contractor is responsible for checking all levels and dimensions on site and shall refer all discrepancies to the Architect
4. Where appropriate, for details of c.s. structure, or mechanical and electrical details, see Engineers drawings
5. Proprietary items shall be fixed in strict accordance with manufacturers instructions
6. Sizes of proprietary items shall be checked with manufacturer.
7. The contractor shall be responsible for the coordination of structure, finishes and services.

Project	
ALTERATIONS AND EXTENSION TO 62 WAINSFORT ROAD, TERENURE, D6W YY65	
Drawing Title	O S Site Location Map
Drawing No	21-103/P000
Scale	1:1000@A3
Rev	-
Drawn	JL
Date	OCT 2021



The House Architects
Architecture & Project Management
www.thehousearchitects.ie
79 Merrion Square South, Dublin 2,
D02 TN 27 tel: 01 507 9990