




EXISTING FRONT DRIVEWAY ELEVATION

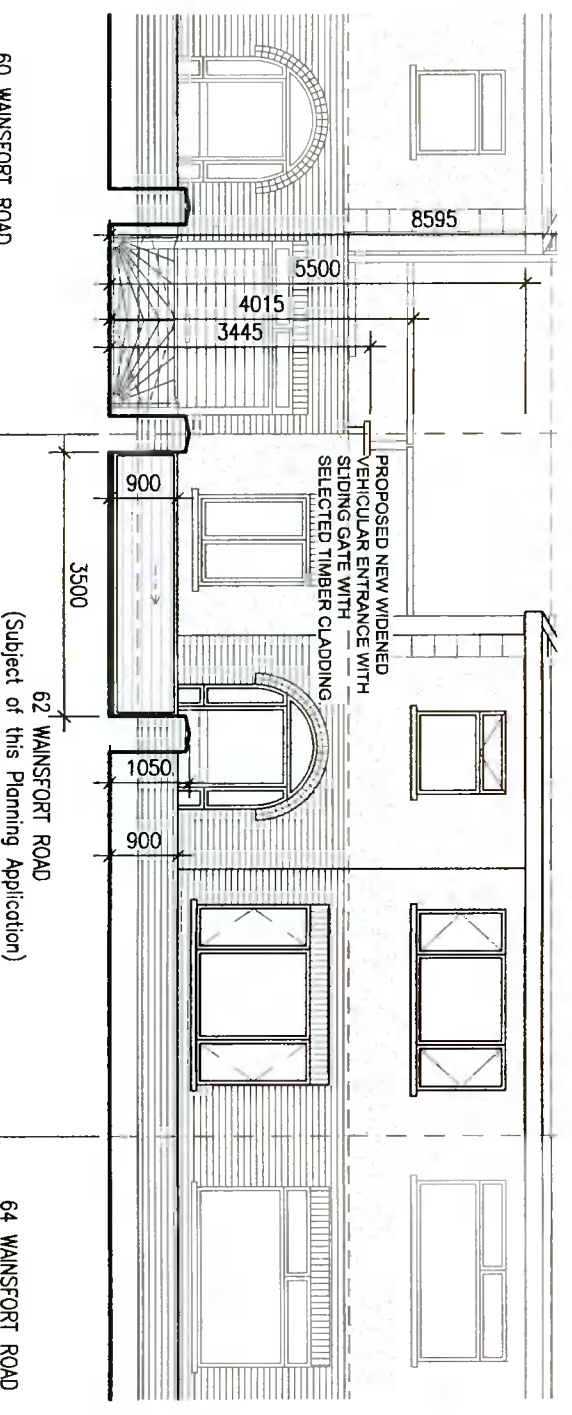

PROPOSED FRONT DRIVEWAY ELEVATION

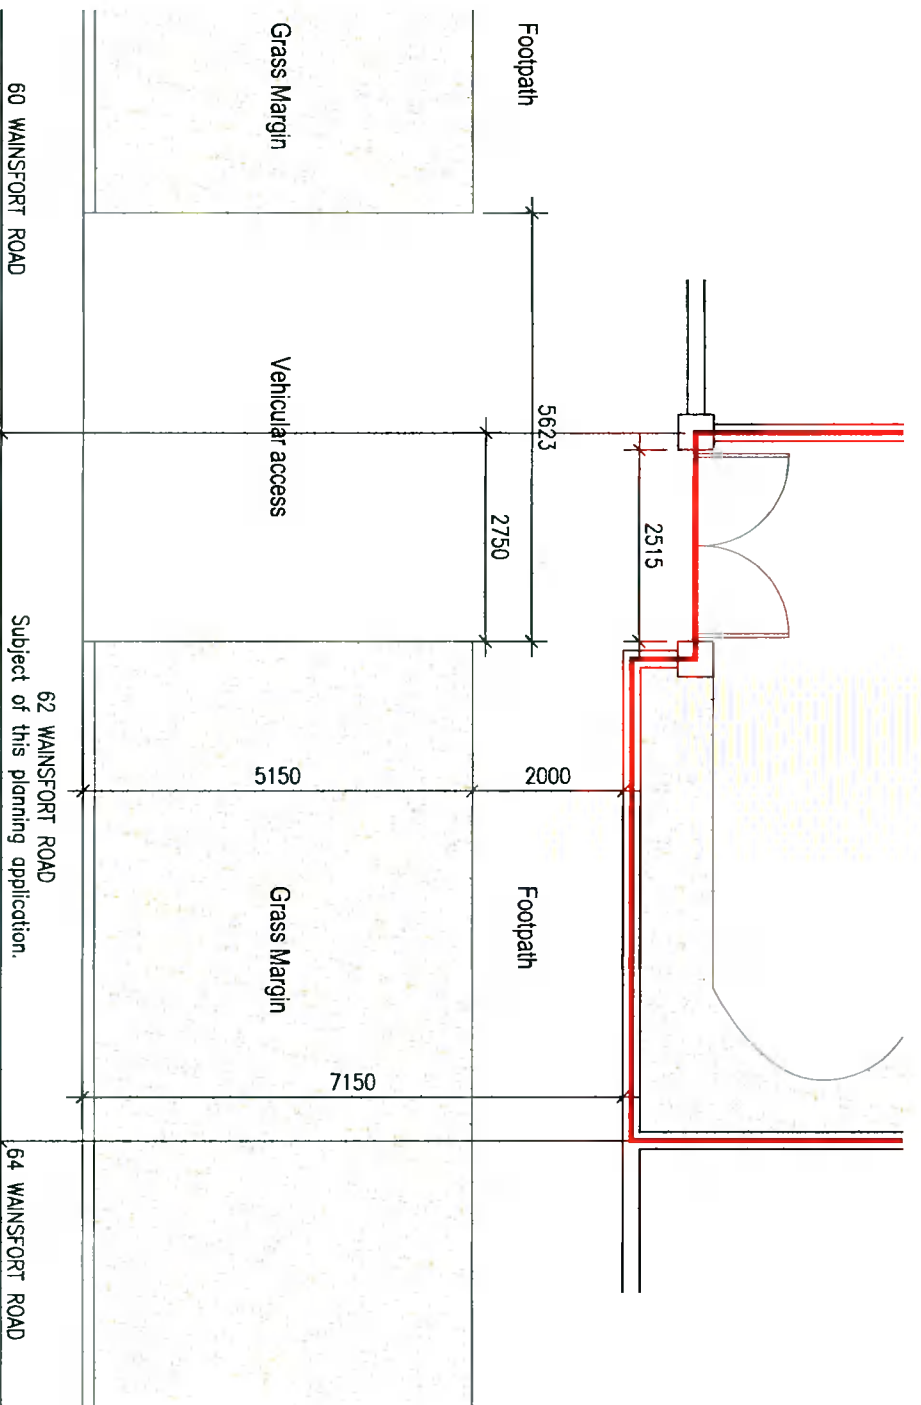

EXISTING DRIVEWAY PLAN LAYOUT

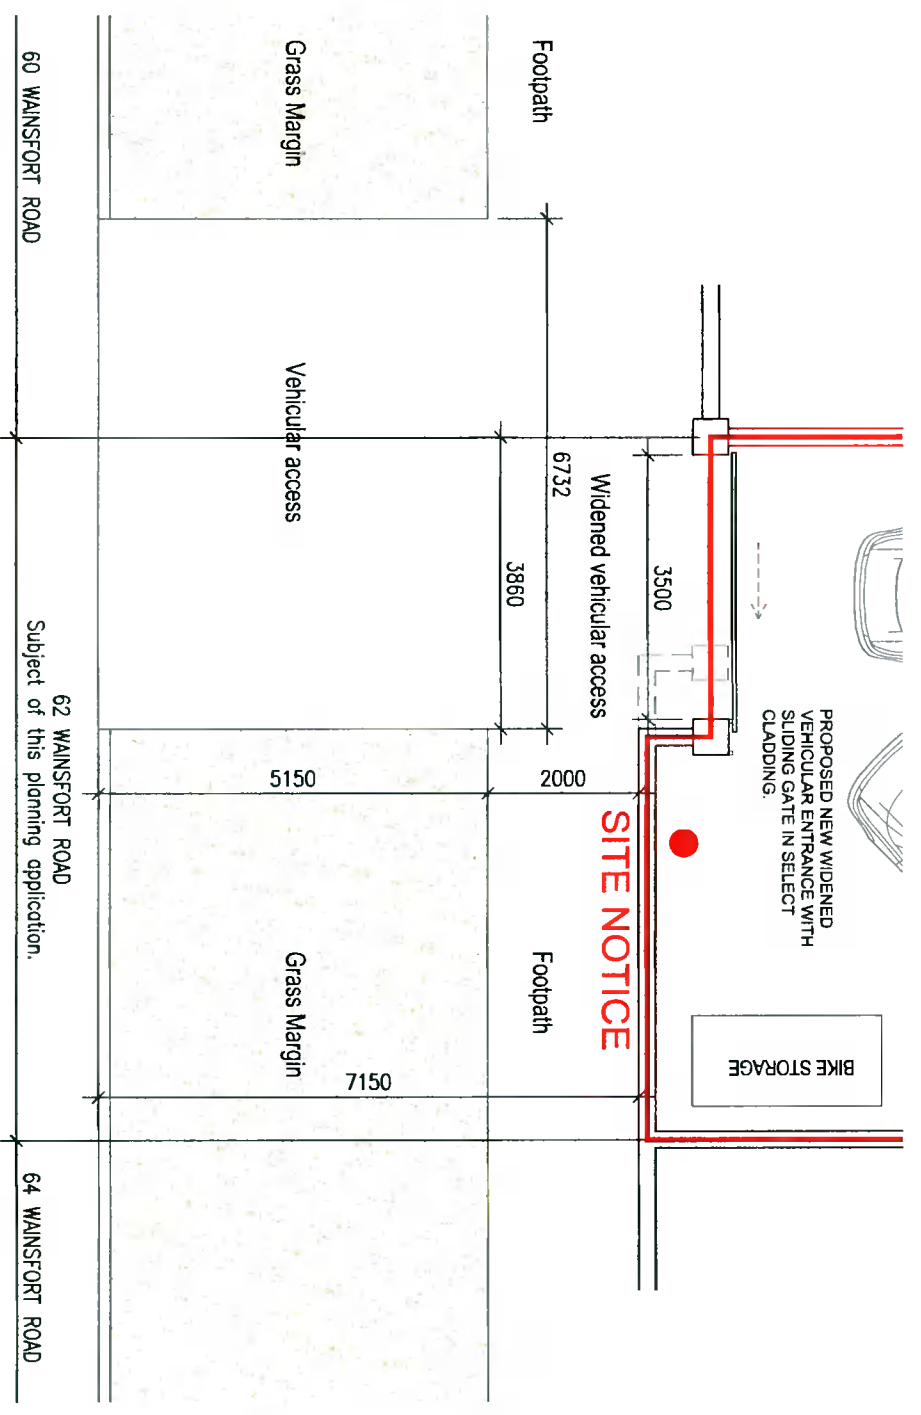

PROPOSED DRIVEWAY PLAN LAYOUT



**PLANNING**

**Notes**

1. Copyright Reserved
2. Work to figured dimensions only. Do not scale drawing.
3. The contractor is responsible for checking all levels and dimensions on site and shall refer all discrepancies to the Architect
4. Where appropriate, for details of c.c. structure, or mechanical and electrical details, see Engineers drawings
5. Proprietary items shall be fixed in strict accordance with manufacturers instructions
6. Sizes of proprietary items shall be checked with manufacturer.
7. The contractor shall be responsible for the coordination of structure, finishes and services

**Project**  
**ALTERATIONS AND EXTENSION TO**  
**62 WAINSFORT ROAD, TERENCE, D6W Y65**

**Drawing Title**  
 Existing & Proposed Driveway Plans & Elevations

**Drawing No**  
 21-103/P007

**Scale**  
 1:100@A3

**Rev**

**Drawn**  
 JL

**Date**  
 OCT 2021



**The House Architects**  
 Architecture & Project Management

[www.thehousearchitects.ie](http://www.thehousearchitects.ie)

79 Merrion Square South, Dublin 2,  
 D02 TN 27 tel. 01 507 9990