


EXISTING SECTION A-A

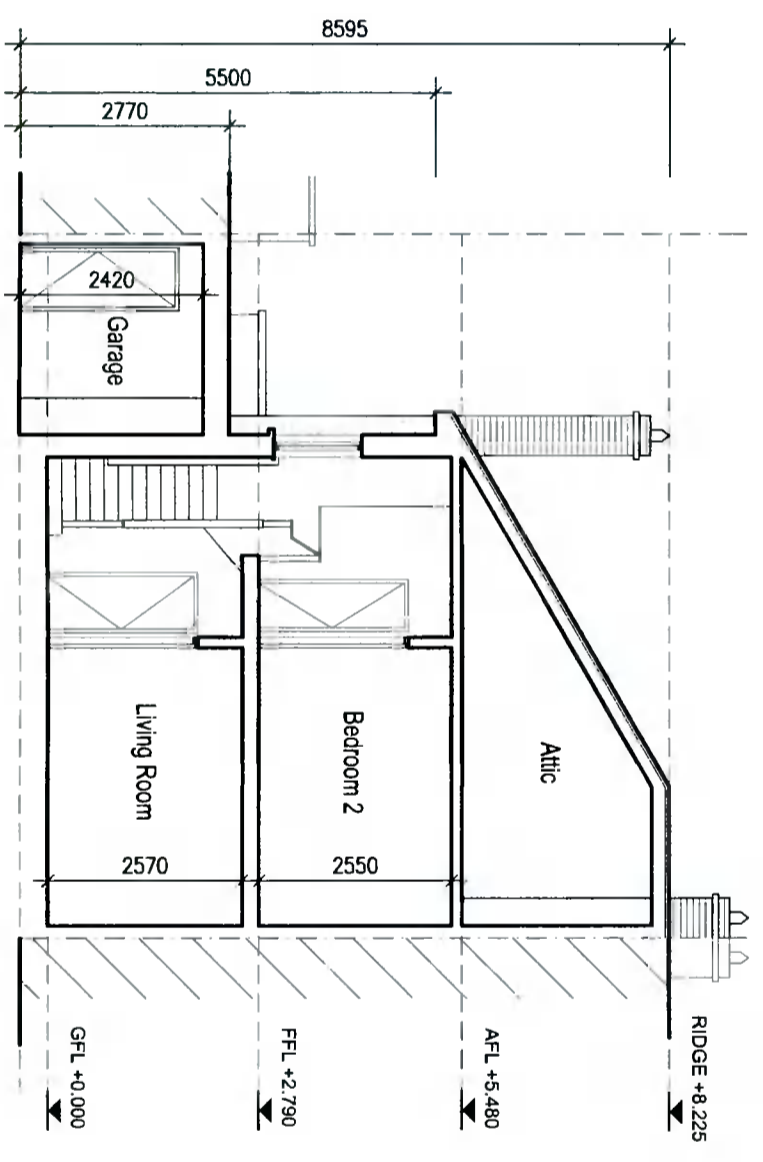


EXISTING SECTION B-B

- Notes
1. Copyright Reserved
 2. Work to figured dimensions only. Do not scale drawing.
 3. The contractor is responsible for checking all levels and dimensions on site and shall refer all discrepancies to the Architect
 4. Where appropriate, for details of r.c. structure, or mechanical and electrical details, see Engineers drawings
 5. Proprietary items shall be fixed in strict accordance with manufacturers instructions
 6. Sizes of proprietary items shall be checked with manufacturer.
 7. The contractor shall be responsible for the coordination of structure, finishes and services.


Project		ALTERATIONS AND EXTENSION TO 62 WAINSFORT ROAD, TERENCE, D6W Y665	
Drawing Title		Existing Sections A-A & B-B	
Drawing No		21-103/S003	
Scale	1:100@A3	Rev	-
Drawn	JL	Date	OCT 2021

The House Architects
 Architecture & Project Management
www.thehousearchitects.ie
 79 Merrion Square South, Dublin 2,
 D02 TN 27 tel. 01 507 9990

SURVEY

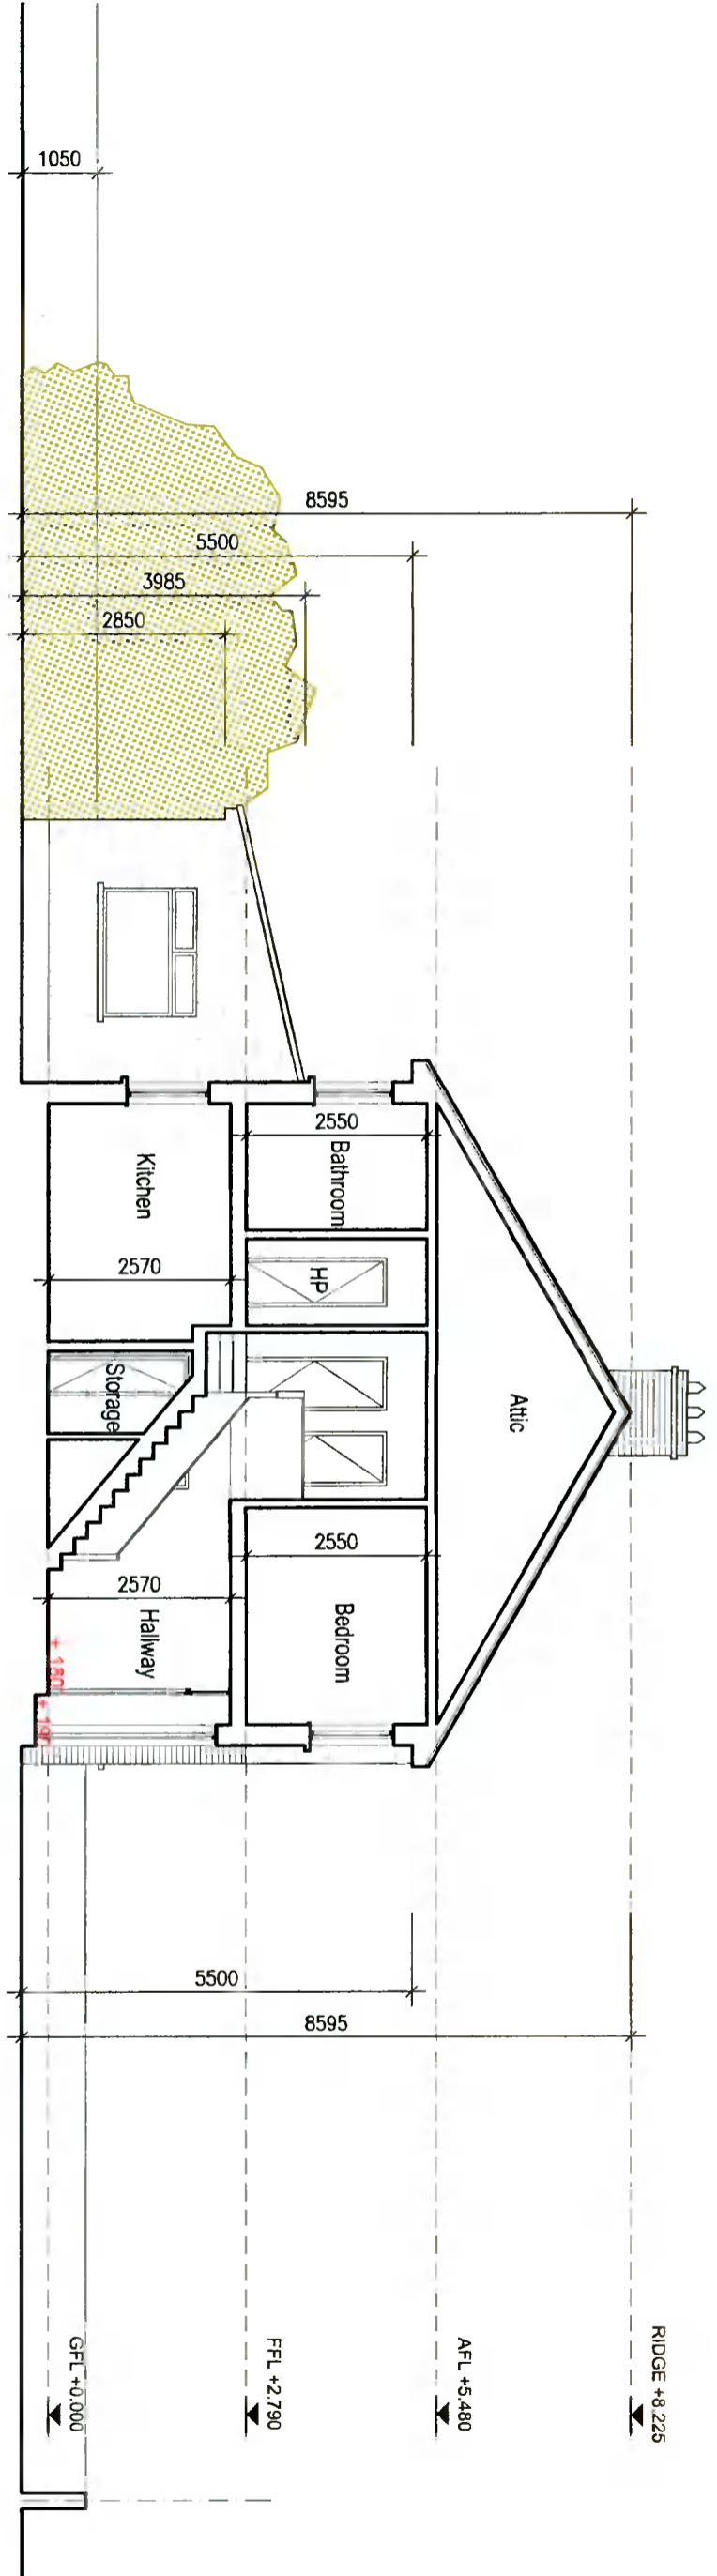

EXISTING SECTION C-C

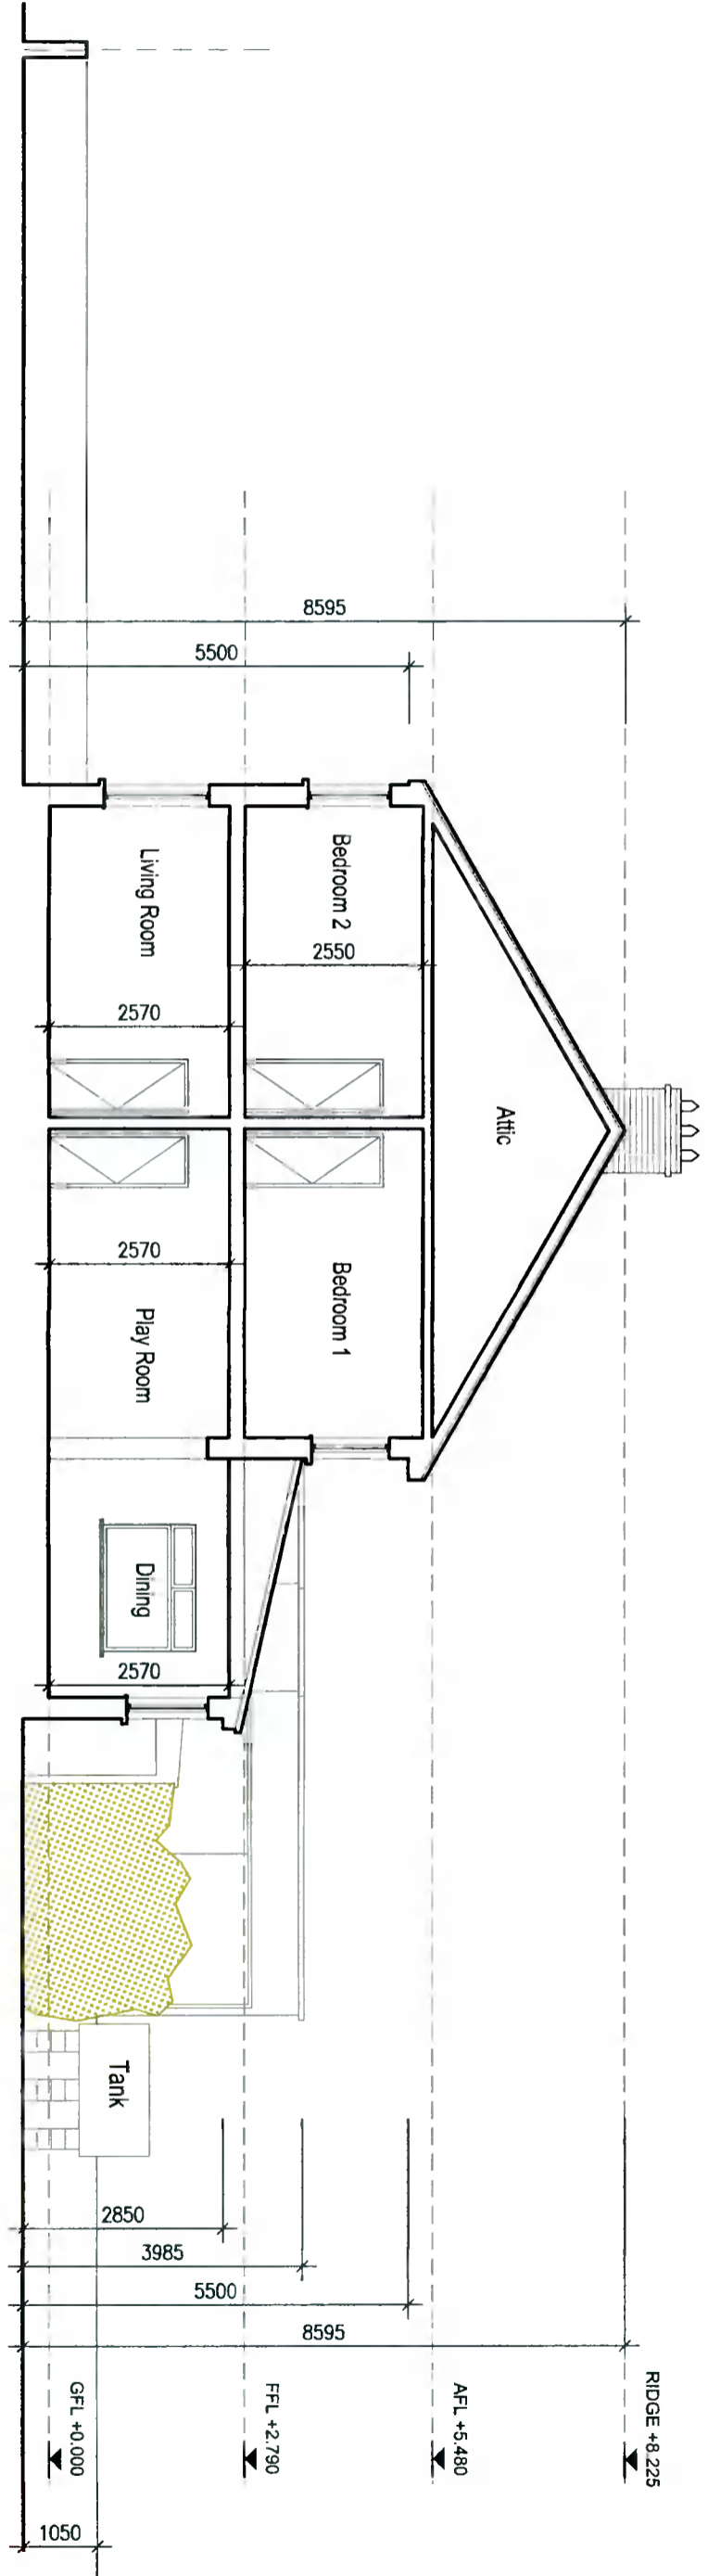

EXISTING SECTION D-D

- Notes
1. Copyright Reserved
 2. Work to figured dimensions only. Do not scale drawing.
 3. The contractor is responsible for checking all levels and dimensions on site and shall refer all discrepancies to the Architect
 4. Where appropriate, for details of r.c. structure, or mechanical and electrical details, see Engineers drawings
 5. Proprietary items shall be fixed in strict accordance with manufacturers instructions
 6. Sizes of proprietary items shall be checked with manufacturer.
 7. The contractor shall be responsible for the coordination of structure, finishes and services.

Project		ALTERATIONS AND EXTENSION TO 62 WAINSFORT ROAD, TERENCE, D6W YY65	
Drawing Title		Existing Sections C-C & D-D	
Drawing No		21-103/S004	
Scale		1:100@A3	
Rev		-	
Drawn		JL	
Date		OCT 2021	

The House Architects
 Architecture & Project Management
www.thehousearchitects.ie
 79 Merrion Square South, Dublin 2,
 D02 TN 27 tel: 01 507 9990

SURVEY