


- Notes
1. Copyright Reserved
 2. Work to figured dimensions only. Do not scale drawing.
 3. The contractor is responsible for checking all levels and dimensions on site and shall refer all discrepancies to the Architect
 4. Where appropriate, for details of r.c. structure, or mechanical and electrical details, see Engineers drawings
 5. Proprietary items shall be fixed in strict accordance with manufacturers instructions
 6. Sizes of proprietary items shall be checked with manufacturer.
 7. The contractor shall be responsible for the coordination of structure, finishes and services.

Project		ALTERATIONS AND EXTENSION TO 62 WAINSFORT ROAD, TERENCE, D6W Y65	
Drawing Title	Existing Elevations in Context		
Drawing No	21-103/S005		
Scale	1:100@A3	Rev	.
Drawn	JL	Date	OCT 2021

The House Architects
 Architecture & Project Management
www.thehousearchitects.ie
 79 Merrion Square South, Dublin 2,
 D02 TN 27 tel. 01 507 9990

SURVEY

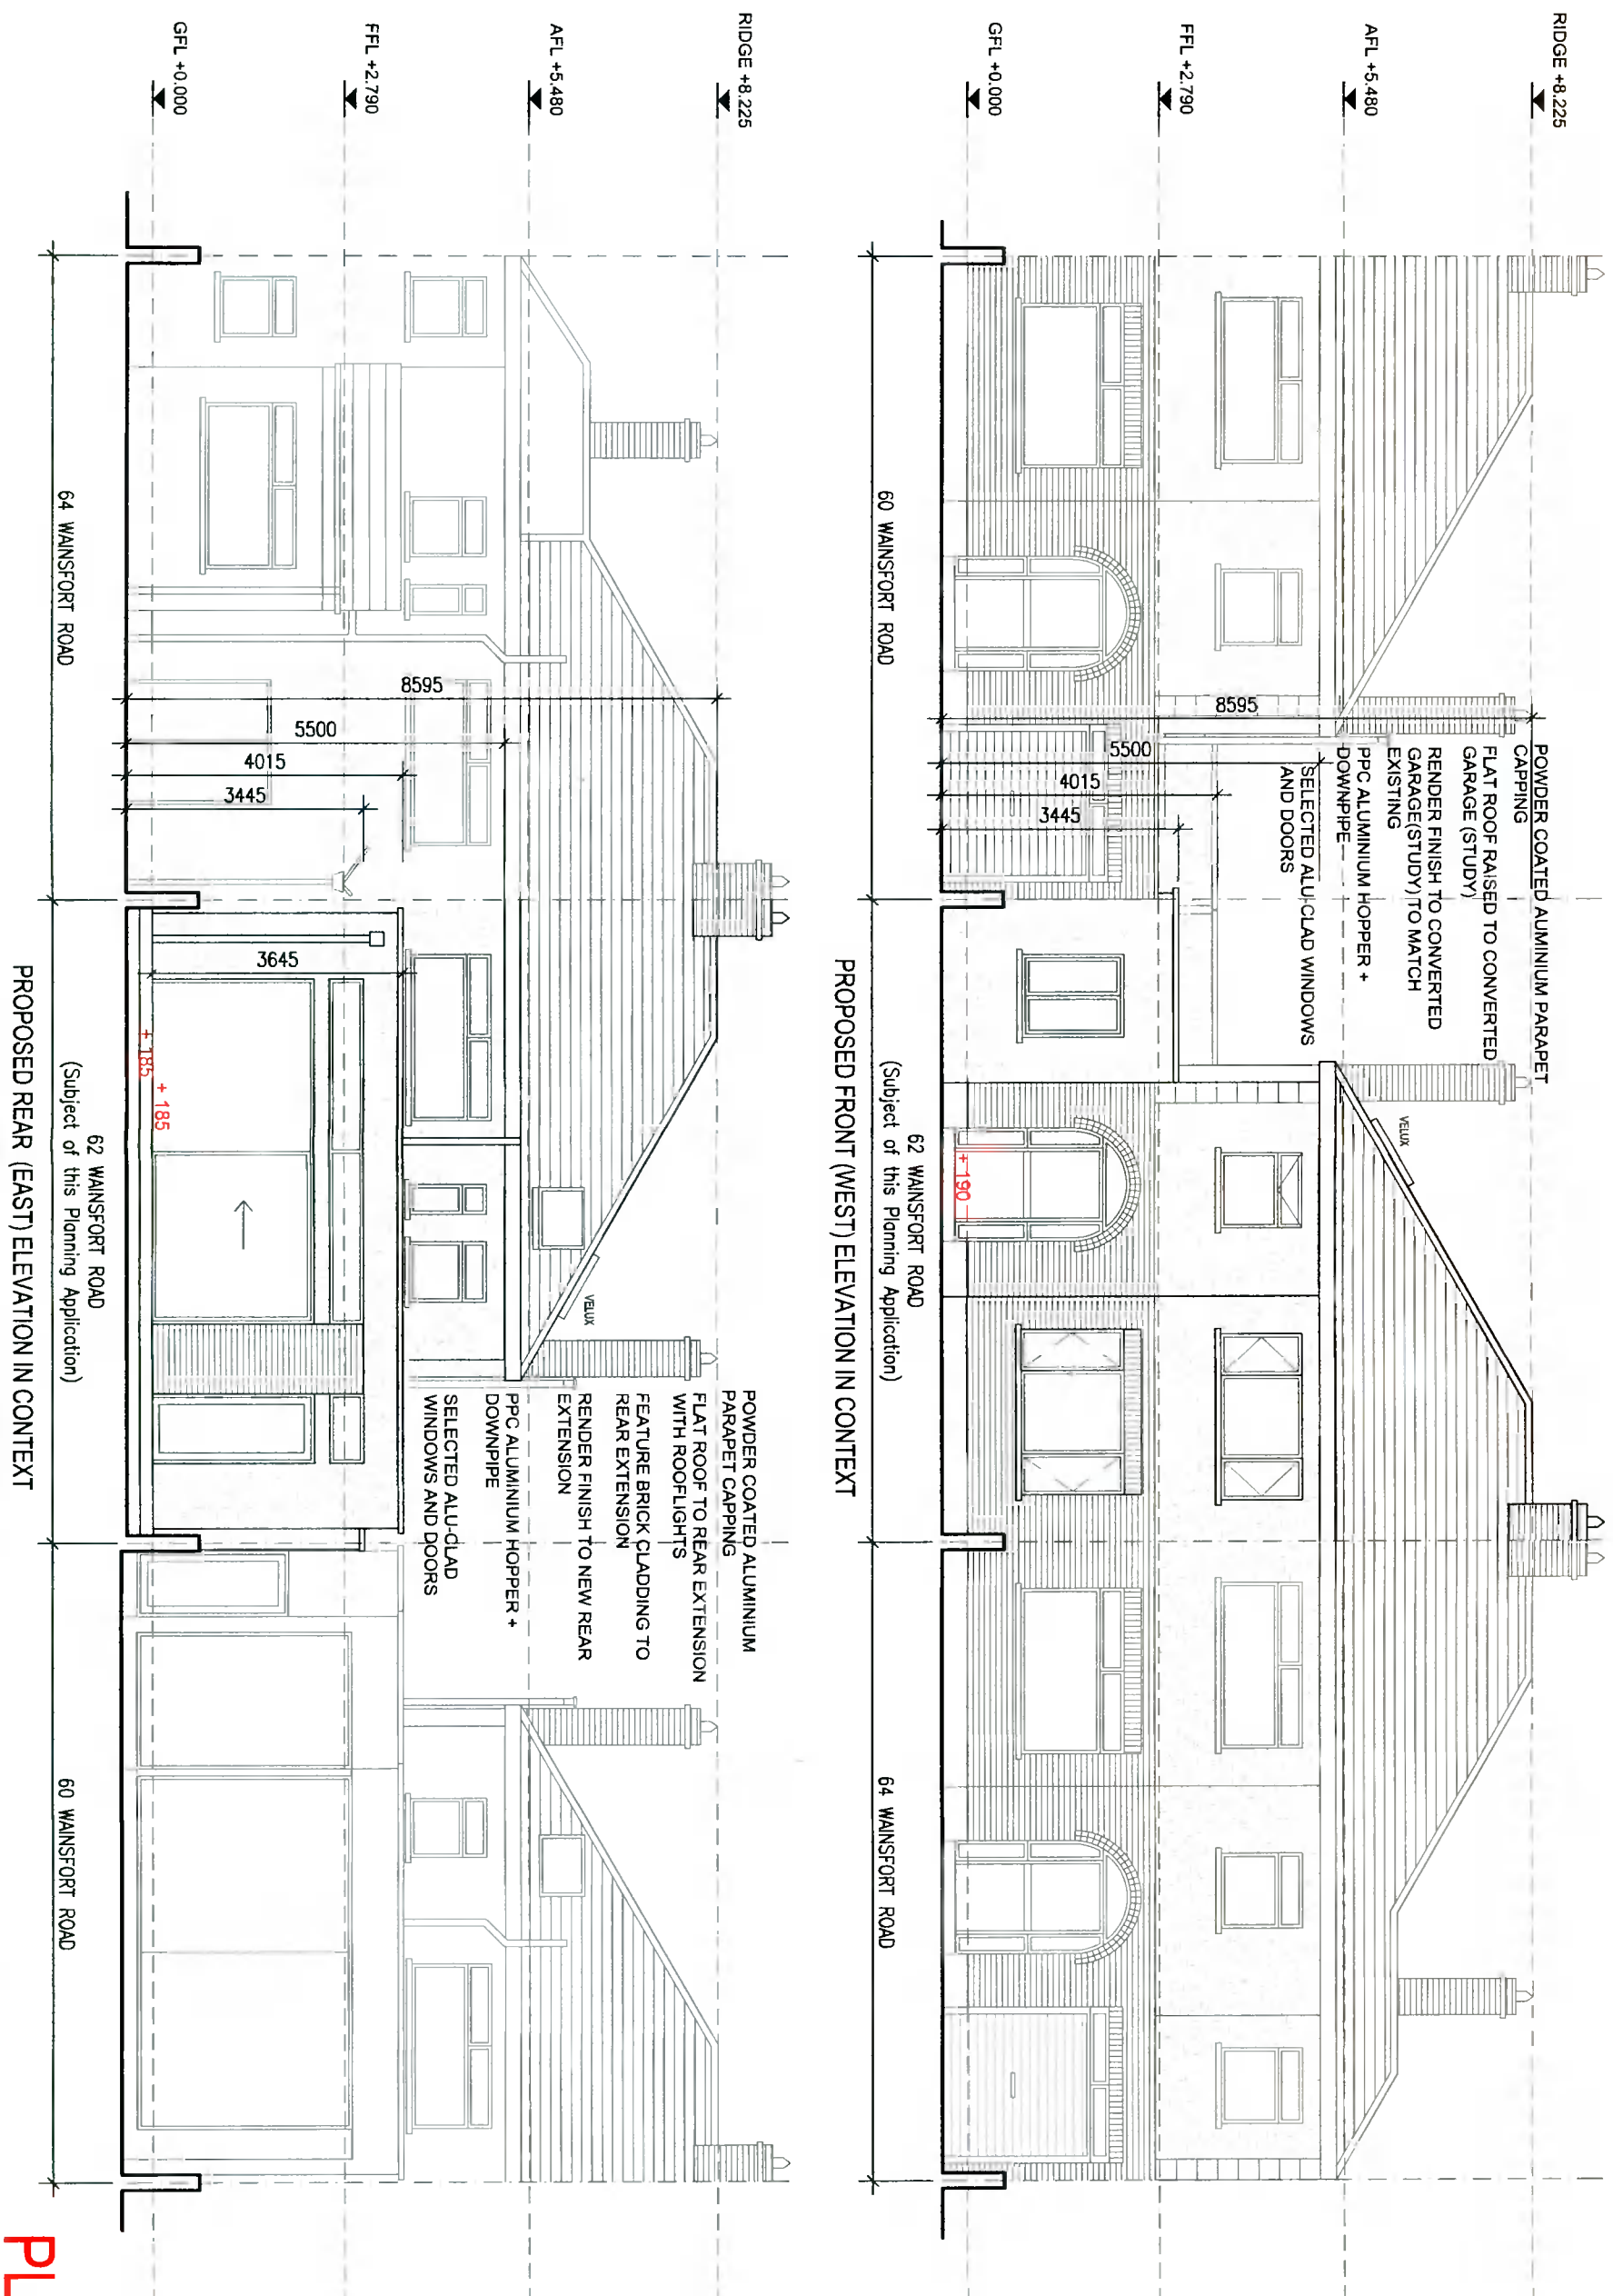

PROPOSED FRONT (WEST) ELEVATION IN CONTEXT

PROPOSED REAR (EAST) ELEVATION IN CONTEXT

PLANNING

- Notes
1. Copyright Reserved
 2. Work to figured dimensions only. Do not scale drawing.
 3. The contractor is responsible for checking all levels and dimensions on site and shall refer all discrepancies to the Architect
 4. Where appropriate, for details of r.c. structure, or mechanical and electrical details see Engineers drawings
 5. Proprietary items shall be fixed in strict accordance with manufacturers instructions
 6. Sizes of proprietary items shall be checked with manufacturer.
 7. The contractor shall be responsible for the coordination of structure, finishes and services.

Project		Drawing Title	
ALTERATIONS AND EXTENSION TO 62 WAINSFORT ROAD, TERENCE, D6W Y665		Proposed Elevations in Context	
Drawing No	21-103/P005	Rev	
Scale	1:100@A3	Drawn	JL
Date	OCT 2021		

The House Architects
 Architecture & Project Management
www.thehousearchitects.ie
 79 Merrion Square South, Dublin 2,
 D02 TN 27 tel: 01 507 9990