

A1




NOTES:

- 1. BUILDING PORTAL FRAME: COLD FORMED, HIGH TENSILE GALVANISED STRUCTURAL STEEL SECTIONS, TRUSS SHOT BLASTED & PRIMED WITH GREY OXIDE.
- 2. FLOOR: REINFORCED CONCRETE GROUND BEARING SLAB PLACED ON STONE SLAB BASE FOUNDED ON GOOD BEARING SOIL FORMATION.
- 3. DRAINAGE CHANNEL SECTIONS TO COLLECT ANY SPILLAGES & DRAIN INTO STORAGE BUND. BUND TO BE PUMPED OUT AS REQUIRED & LIQUID TREATED IN A RESPONSIBLE MANNER.

LEGEND:

- PROPOSED INTERNAL DRAINAGE TO BUND — SD — SD —
- PROPOSED WATER SUPPLY — WATER — WATER —

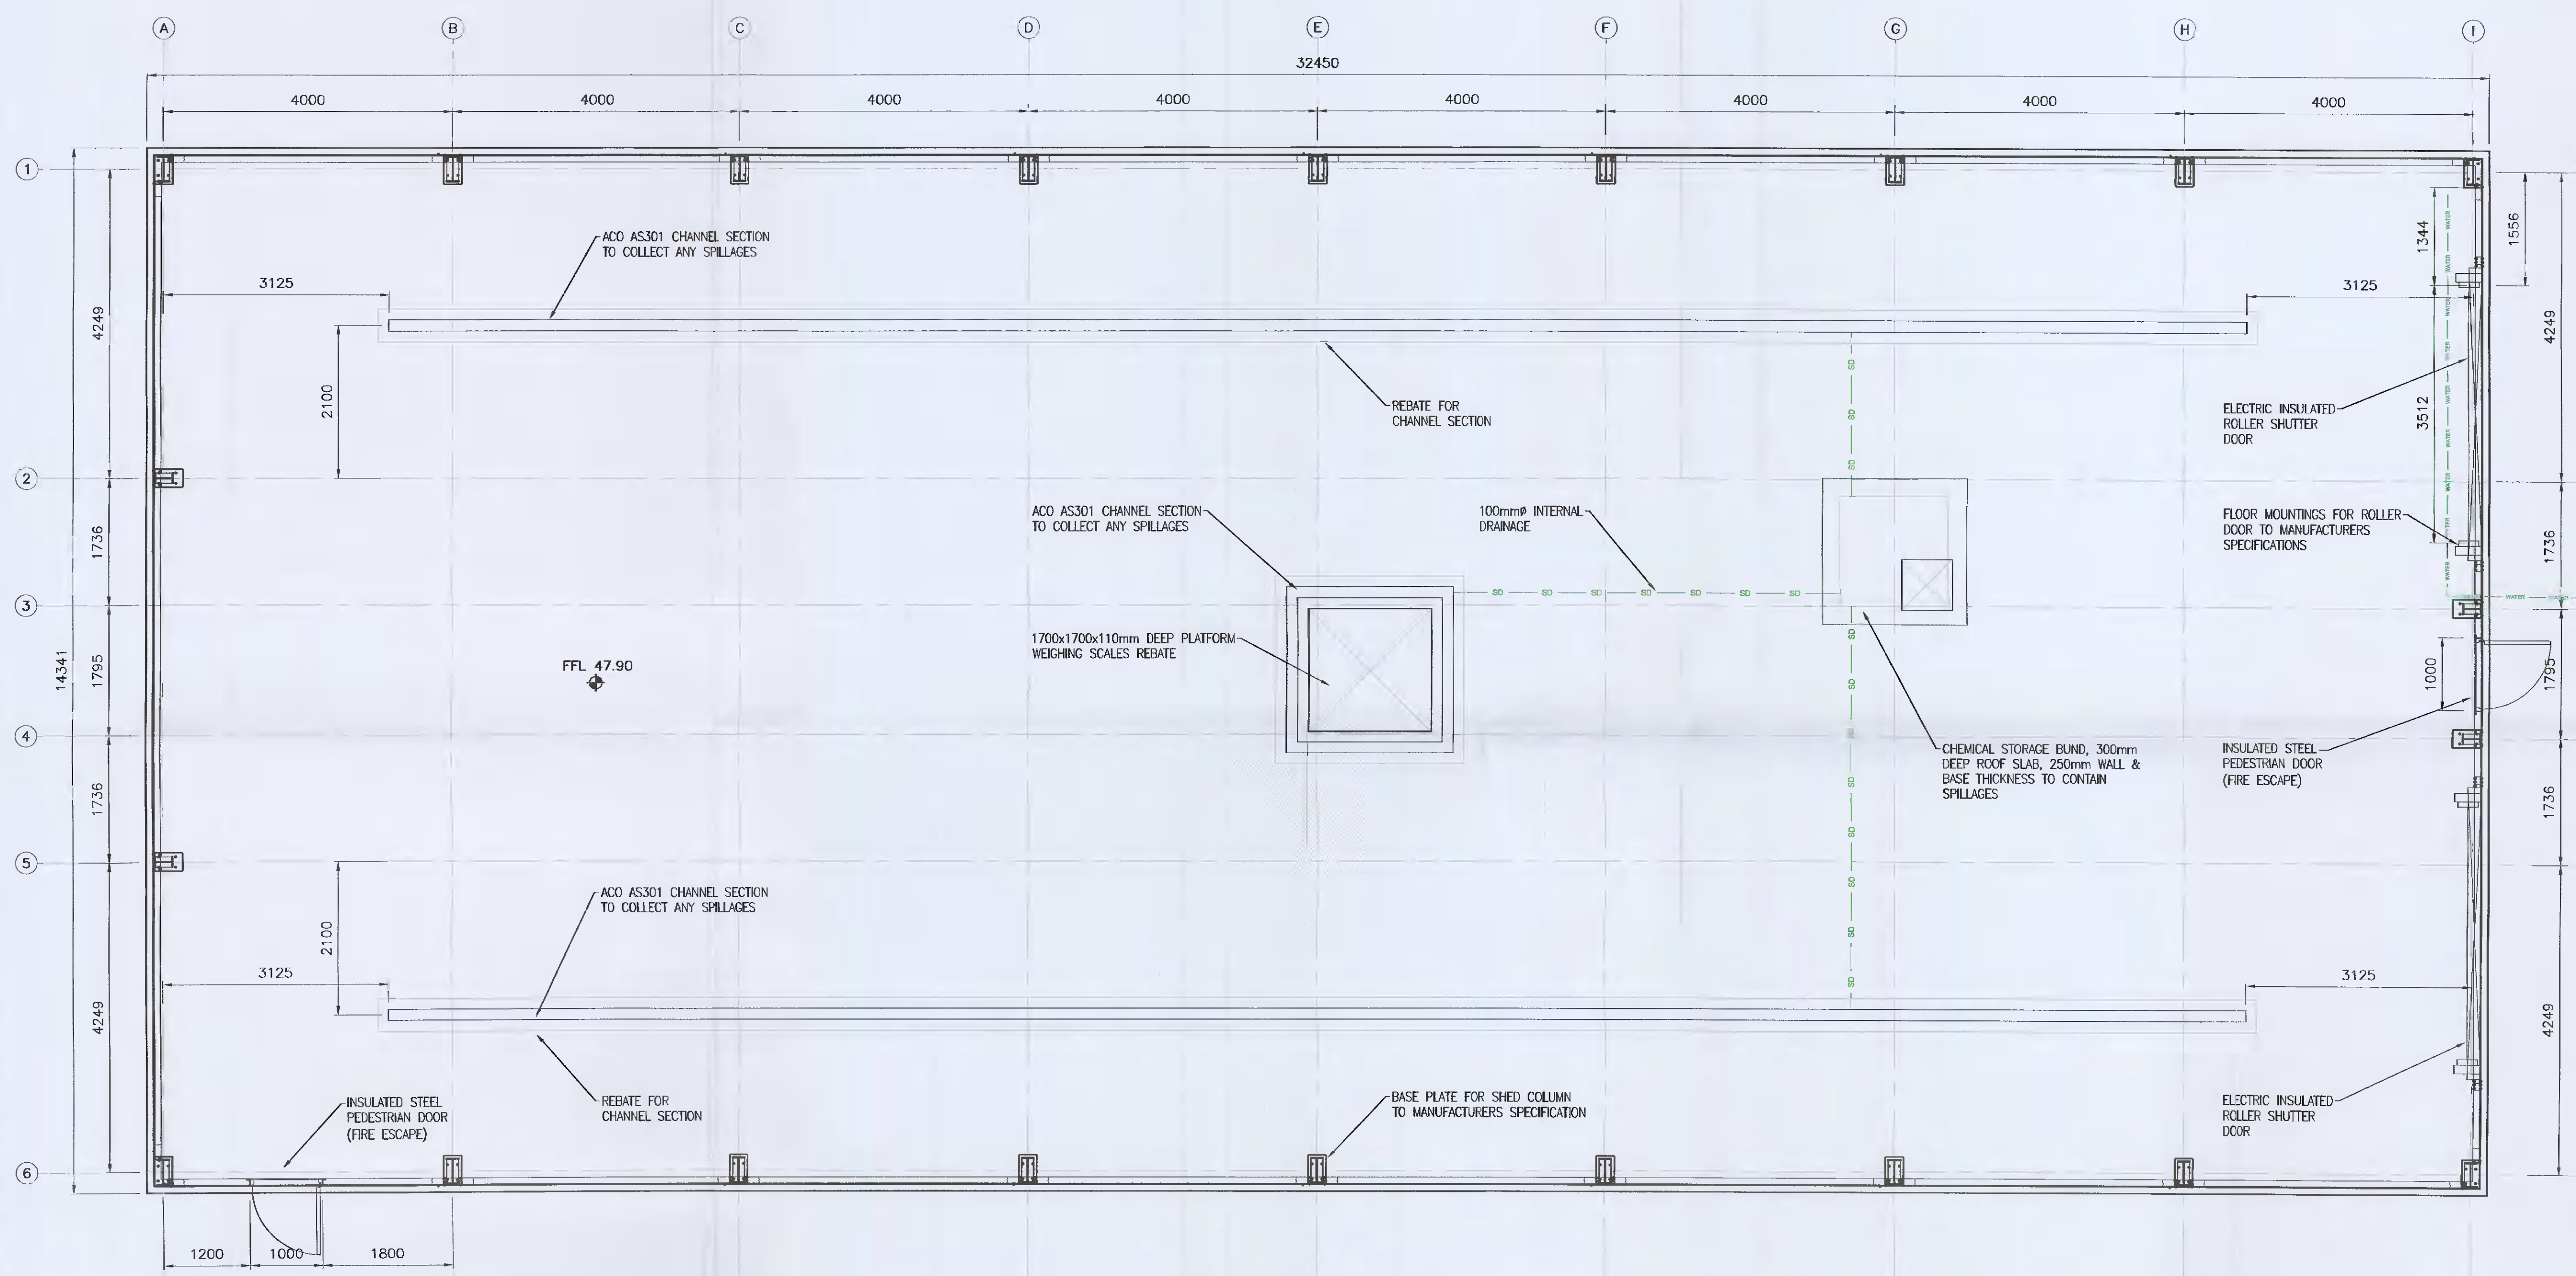

GROUND FLOOR PLAN

Rev	Date	Description	By	Chk	App
00	15.10.21	ISSUE FOR PLANNING			

BYRNE LOOBY
www.ByrneLooby.com
IRELAND | UK | UAE | BAHRAIN | KSA

CLIENT
DIAGEO

PROJECT
BAILEYS PLANT, NANGOR ROAD
DUBLIN UPGRADE WORKS

DRAWING TITLE
PROPOSED FLAVOUR WAREHOUSE
INTERNAL DRAINAGE LAYOUT

STATUS
PLANNING

Date: 15.10.21	Scale: 1:50	Drawn: LH	Chk: LH	App: SC
Project No: W3499	Dwg. No: W34599-1009	Rev: 00		