
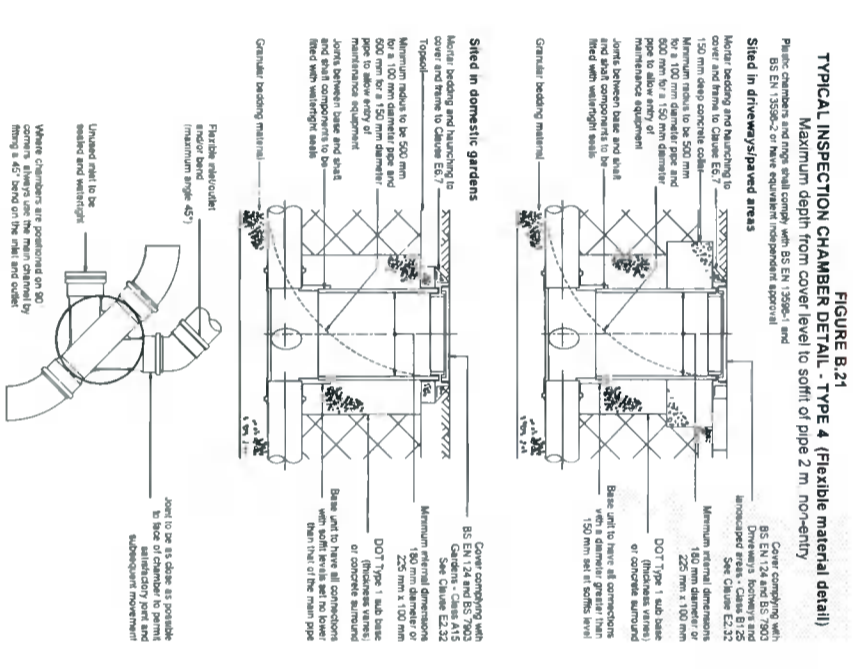
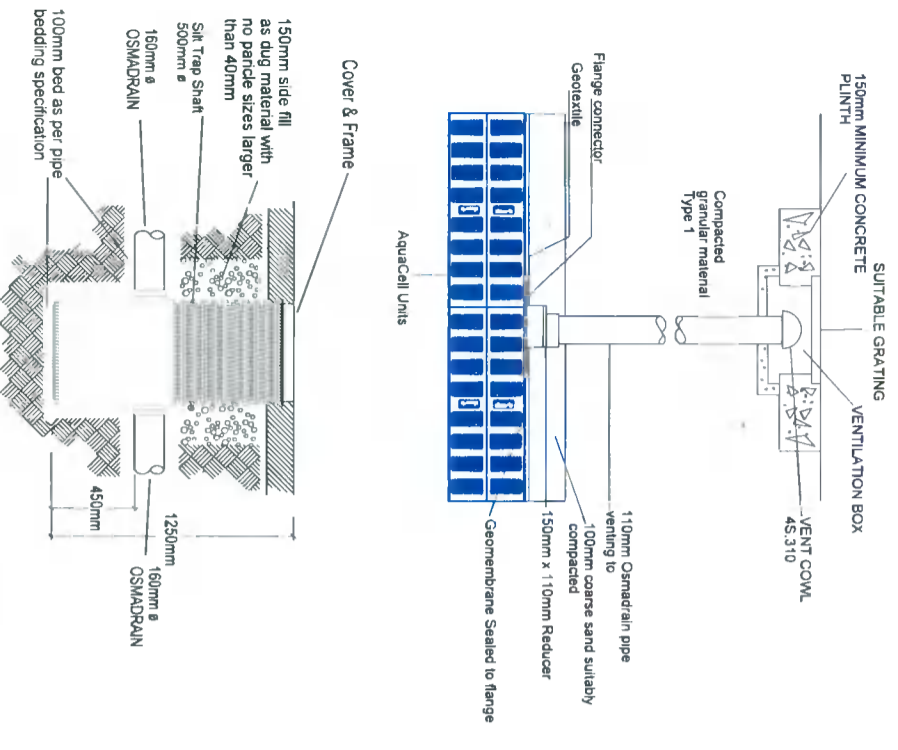


- NOTES:**
- This drawing to be used in conjunction with all relevant Architects and Engineers drawings.
 - Do not scale drawing.
 - All dimensions in millimeters unless otherwise stated.
 - All building works to comply with current Building Regulations.
 - All Foul & Surface Water Drainage To B.S. 4514 / I.S. EN 1329-1
 - All levels to OD Main Head

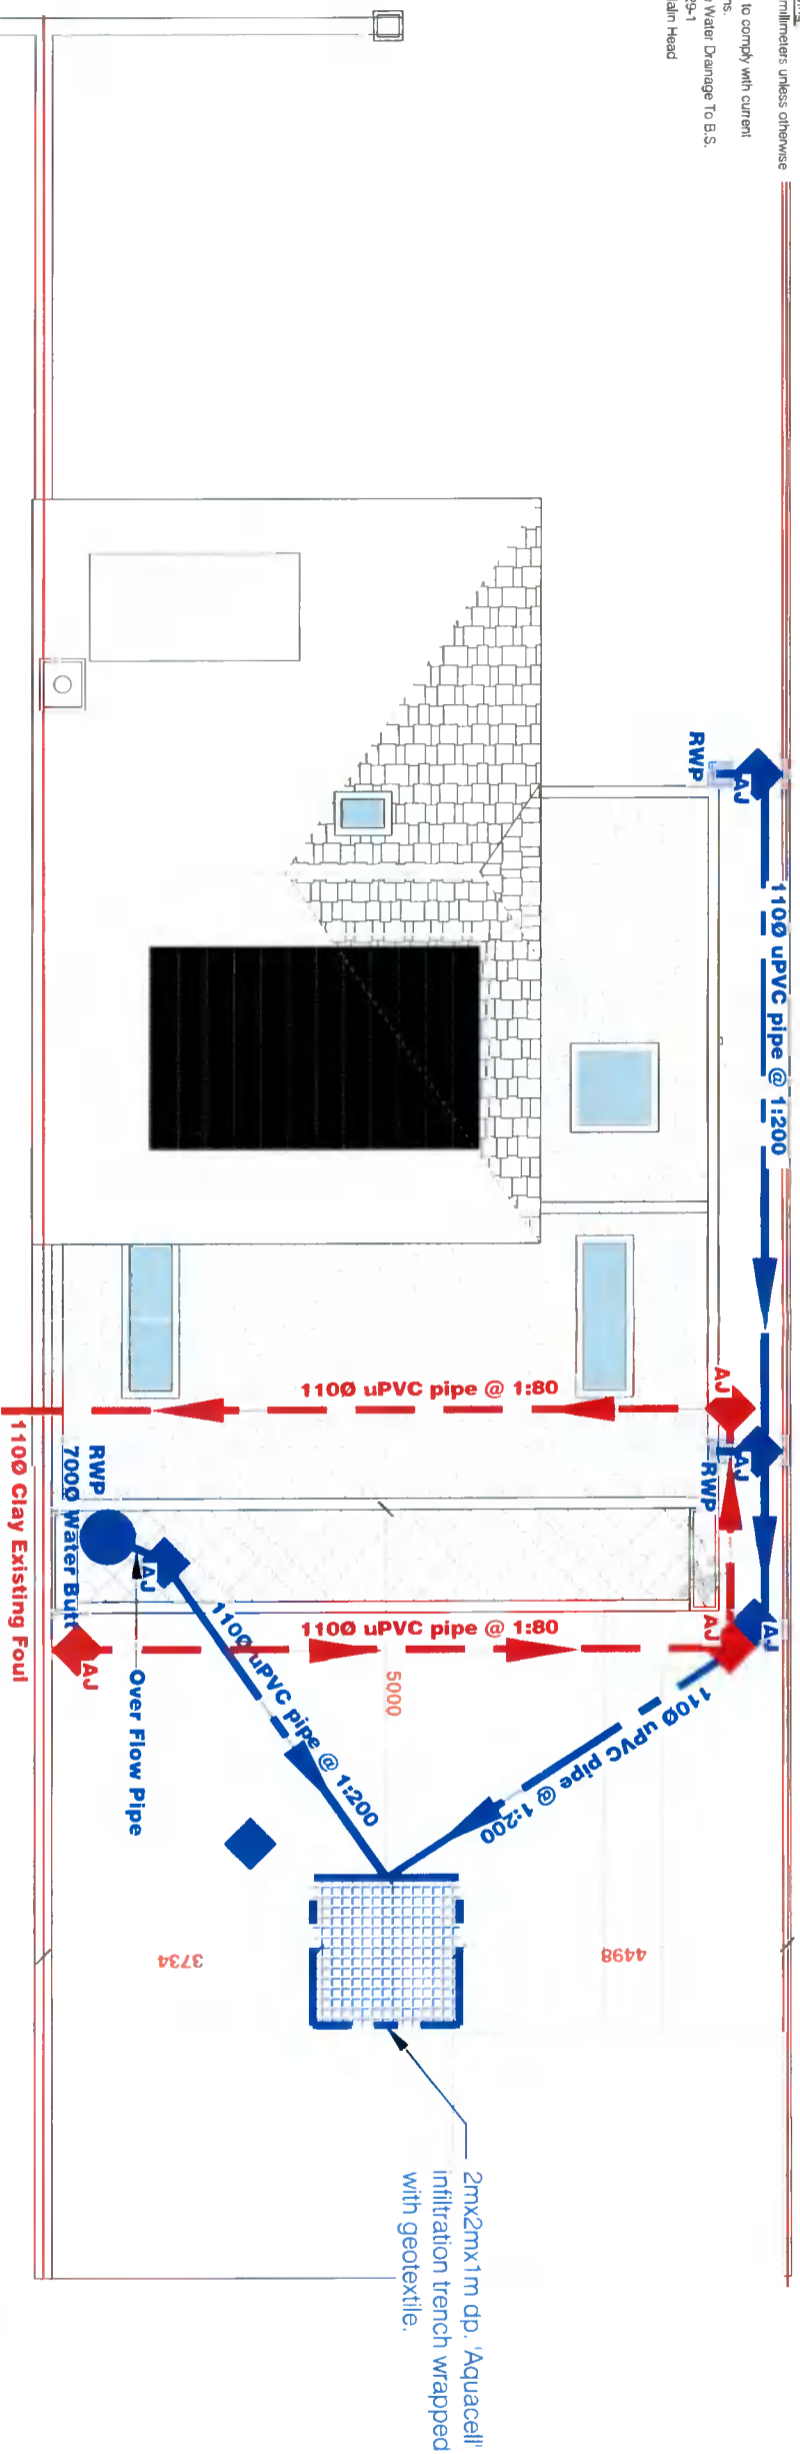

- LEGEND:**
- Denotes new surface water manhole
 - Denotes new surface water access junction
 - Denotes new surface water line
 - Denotes RWP + BSGT
 - Denotes permeable paving interception storage
 - Denotes road gully
 - Denotes new foul water manhole
 - Denotes new foul water access junction
 - Denotes new foul water inspection chamber in accordance with Irish Water STD-WM-13
 - Denotes new foul water line
 - Denotes BSGT
 - Denotes new 1000 P.E. watermain
 - Denotes existing uPVC watermain
 - Denotes new boundary box water meter
 - Denotes sluice valve
 - Denotes duck foot fire hydrant
 - Denotes air valve
 - Denotes washout

once
 consultant engineers

4 Bridgcourt Office Park
 Walkinstown Avenue
 Dublin 12
 Tel / Fax: 01-426 4883 /
 01-429 7971
 email mail@once.co
 www.once.co

Scale: A1 @ 1:50
 Client: John and Roisin Bagnall
 Job Title: 179 Templeville Road
 Date: NOV21
 Drawing number: 5419/01
 Drawing Title: DRAINAGE LAYOUT & TYPICAL DETAILS