


LEGEND:

- NORTH CATCHMENT AREA
- EAST CATCHMENT AREA
- SOUTH CATCHMENT AREA

NOTE:
 1. REFER TO DRAWING NO. 202253-PUNCH-XX-XX-DR-C-0100 FOR GROUND FLOOR DRAINAGE LAYOUT

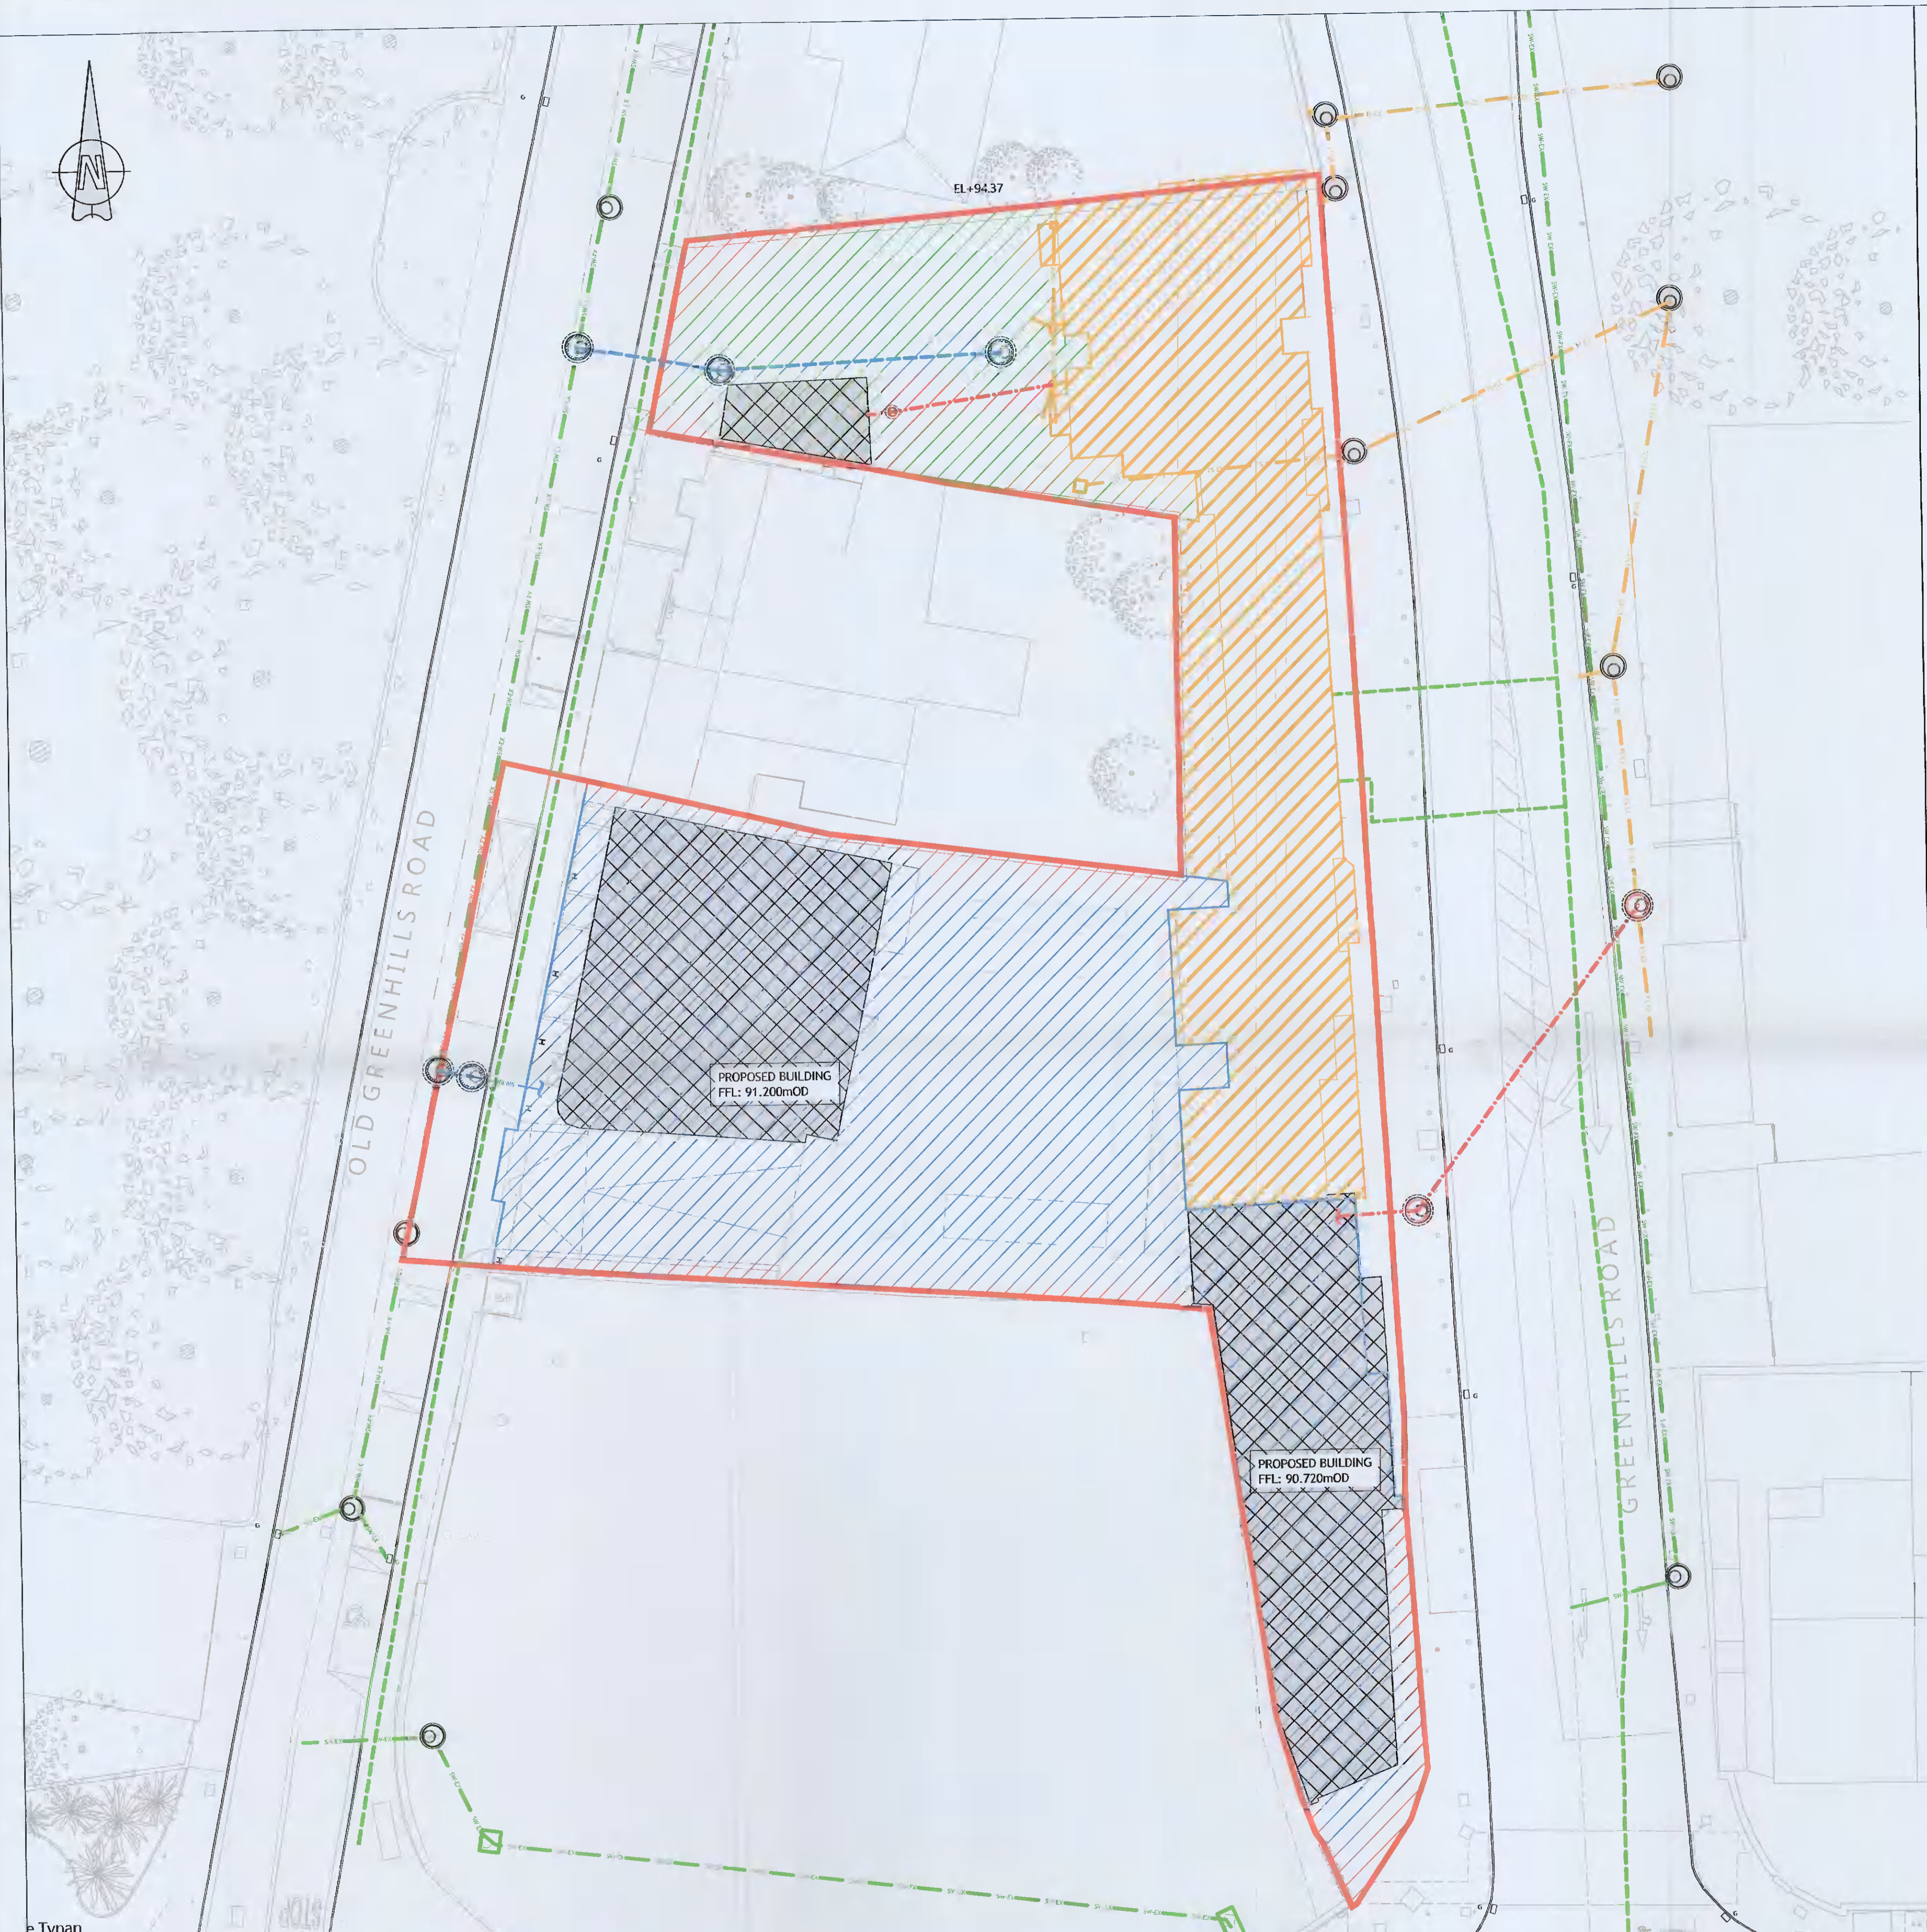

e Tynan
 Plot

© PUNCH Consulting Engineers

This drawing and any design hereon is the copyright of the Consultants and must not be reproduced without their written consent. All drawings remain the property of the Consultants. Figure dimensions only to be taken from this drawing. Consultants to be informed immediately of any discrepancies before work proceeds.



Step	Amendment	By	Date	Rev	Amendment	By	Date	Client:
CO1	PLANNING ISSUE	IBS	14/05/2021					
CO2	FI RESPONSE	DAP	04/11/2021					

PUNCH
 consulting engineers
 Dublin | Limerick | Cork | Galway | Glasgow
 Carnegie House Library Road,
 Dun Laoghaire, Co. Dublin, A96 C7W7
 t +353 1 271 2200 | w punchconsulting.com

Project: GREENHILLS ROAD DEVELOPMENT, TALLAGHT, DUBLIN 24					
Title: PROPOSED DRAINAGE CATCHMENT AREAS LAYOUT					
Drawn: IBS	Issue: MARCH 2021	Technician Check: IBS	Engineer Check: IB	Approved:	
Project No: 202253	Issue No: 202253-PUNCH-XX-XX-A2-C-0102	Drawing Status: NO PLANNING		Revision No:	
Scale: 1:200	Document No: 202253-PUNCH-XX-XX-DR-C-0102			Revision:	C02