



01 EXISTING DRAINAGE PLAN
SCALE: 1:200

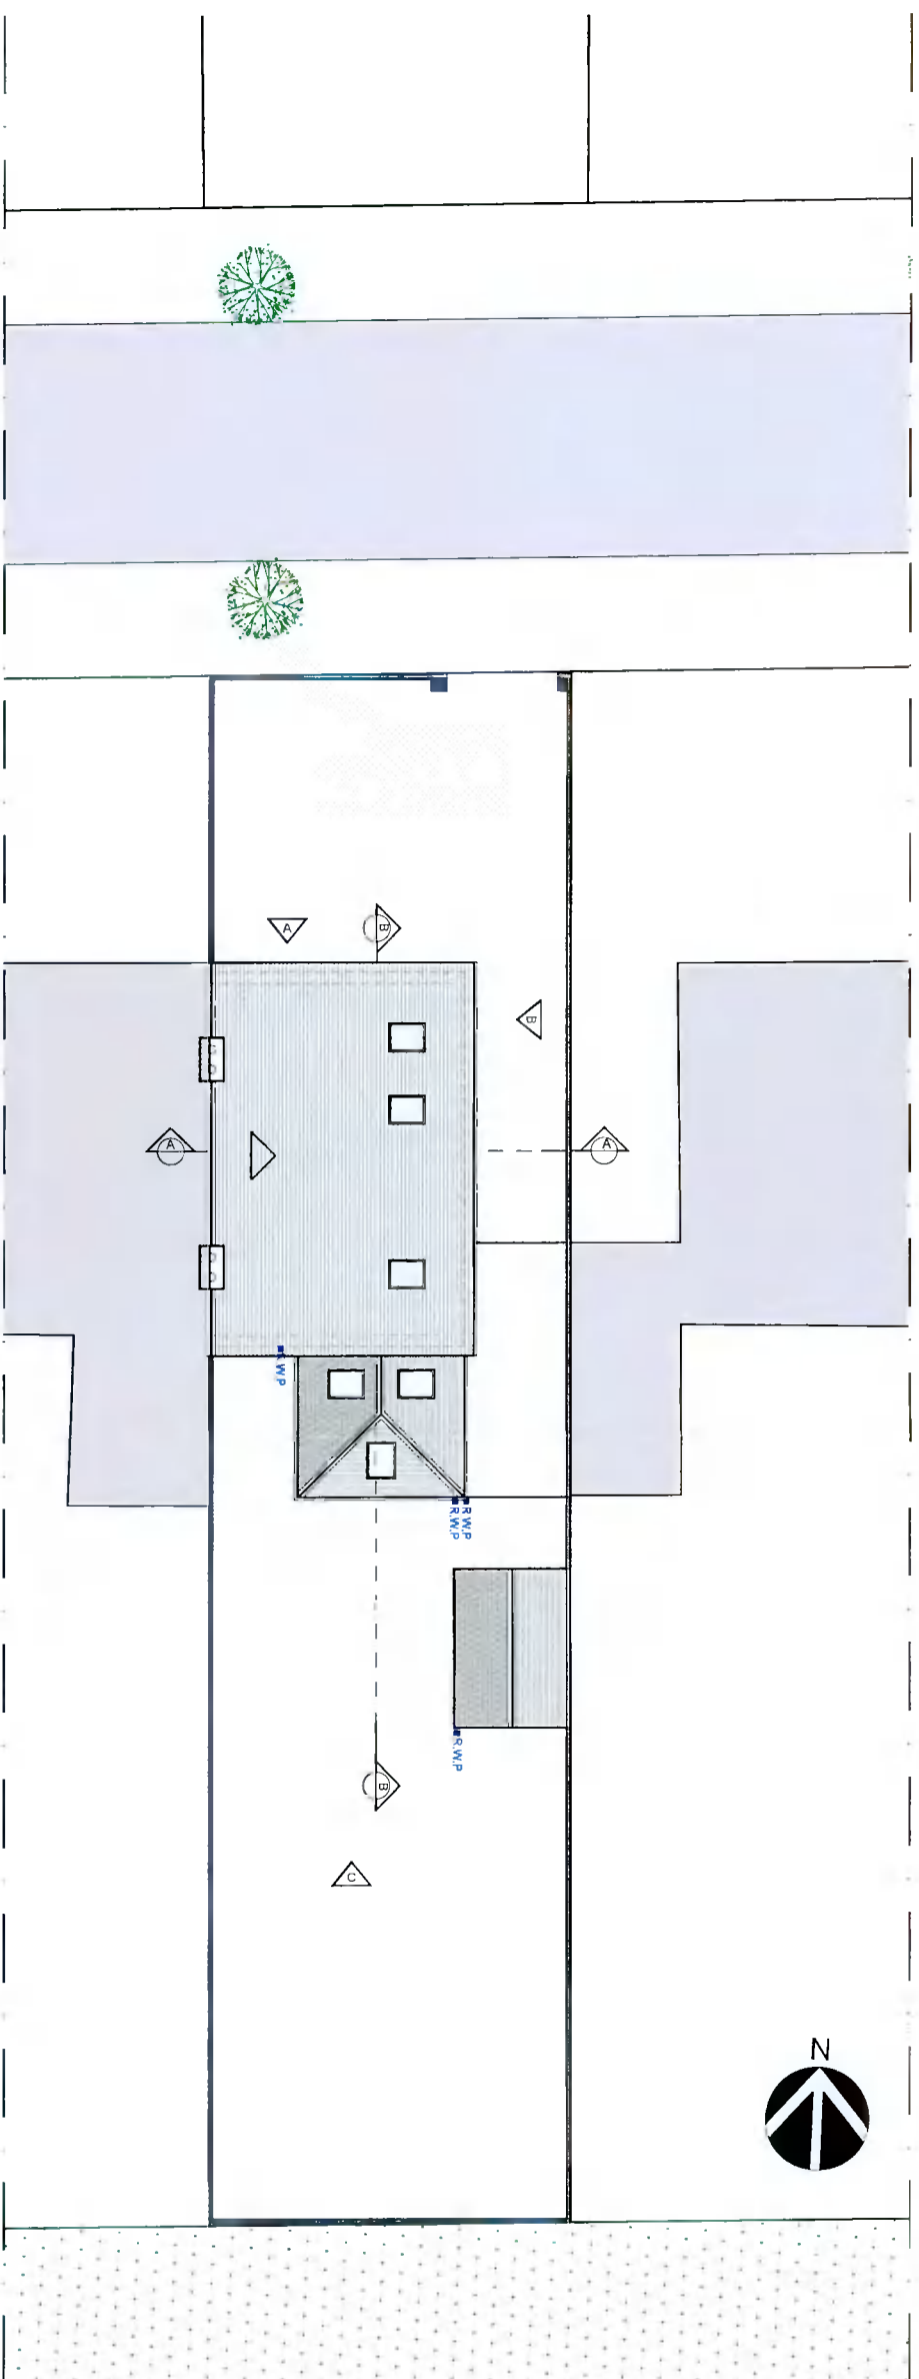

02 PROPOSED DRAINAGE PLAN
SCALE: 1:200

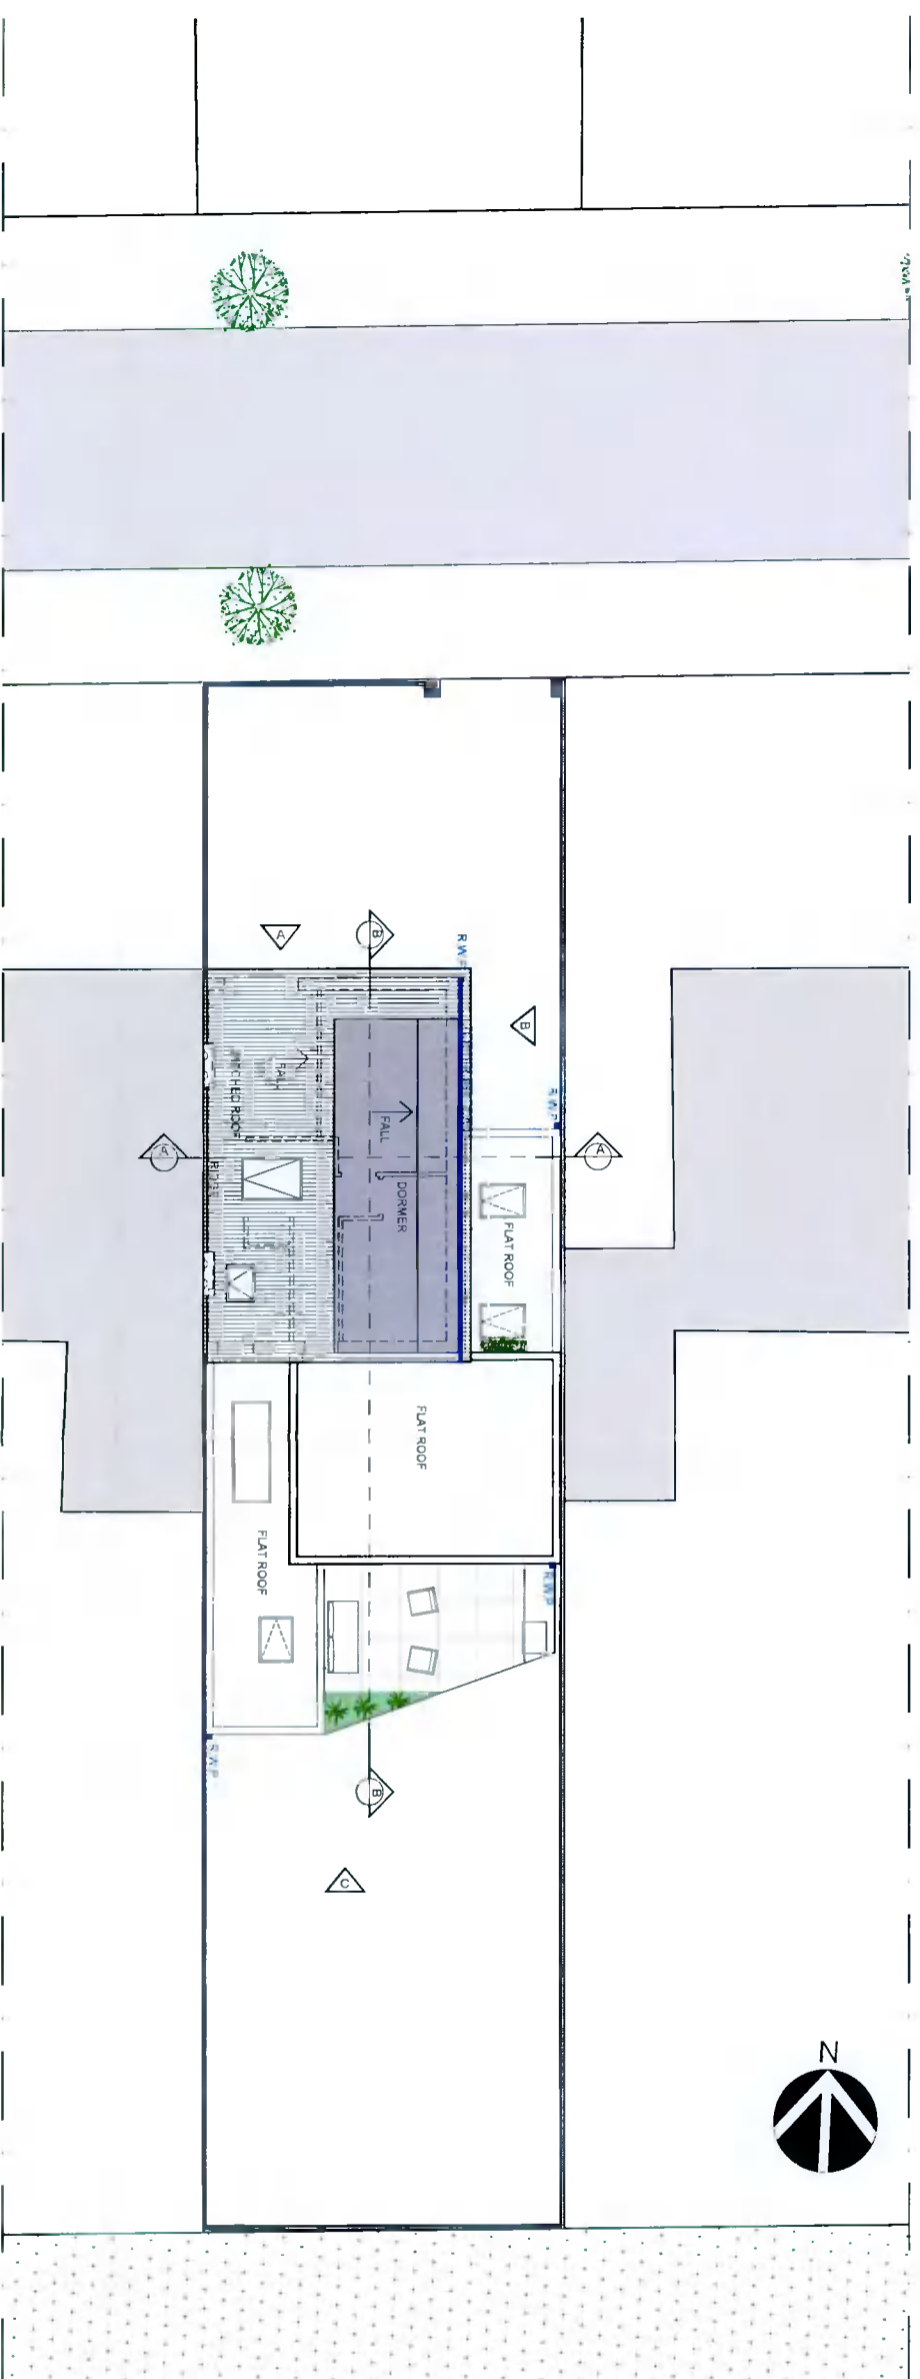

- LEGEND
- EXISTING WALLS
 - PROPOSED WALLS
 - S.V.P
 - R.W.P RAIN WATER PIPE
 - G.T GULLY TRAP
 - A.J ARMSTRONG JUNCTION
 - M.H MAN HOLE
 - F.O.L.W FOLL WATER
 - SURFACE WATER
 - Q.L GROUND LEVEL
 - F.R.L FLAT ROOF LEVEL
 - G.F.L GROUND FLOOR LEVEL
 - F.F.L FIRST FLOOR LEVEL
 - S.F.L SECOND FLOOR LEVEL
 - R.L ROOF LEVEL
 - B.F.L BACKYARD FLOOR LEVEL

REV	DATE	DESCRIPTION

@ This drawing is copyright. Figure dimensions only to be taken from this drawing. All dimensions to be checked on site. Module Design Ltd to be informed immediately of any discrepancies before work proceeds.

PROJECT NO.	SCALE(S)	REV.
20109	1:200	01

MAP SHEETS:
3194-23
3280-03

INCLUDES ORDNANCE SURVEY IRELAND DATA
REPRODUCED UNDER OSI LICENSE NUMBER 1021
UNAUTHORISED REPRODUCTION INFRINGES ORDNANCE SURVEY IRELAND AND GOVERNMENT OF IRELAND
COPYRIGHT ORDNANCE SURVEY IRELAND 2021