
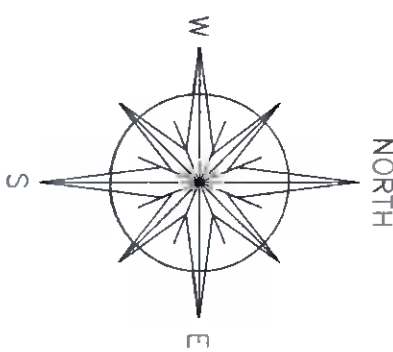


Site Block Plan / Site Drainage Layout

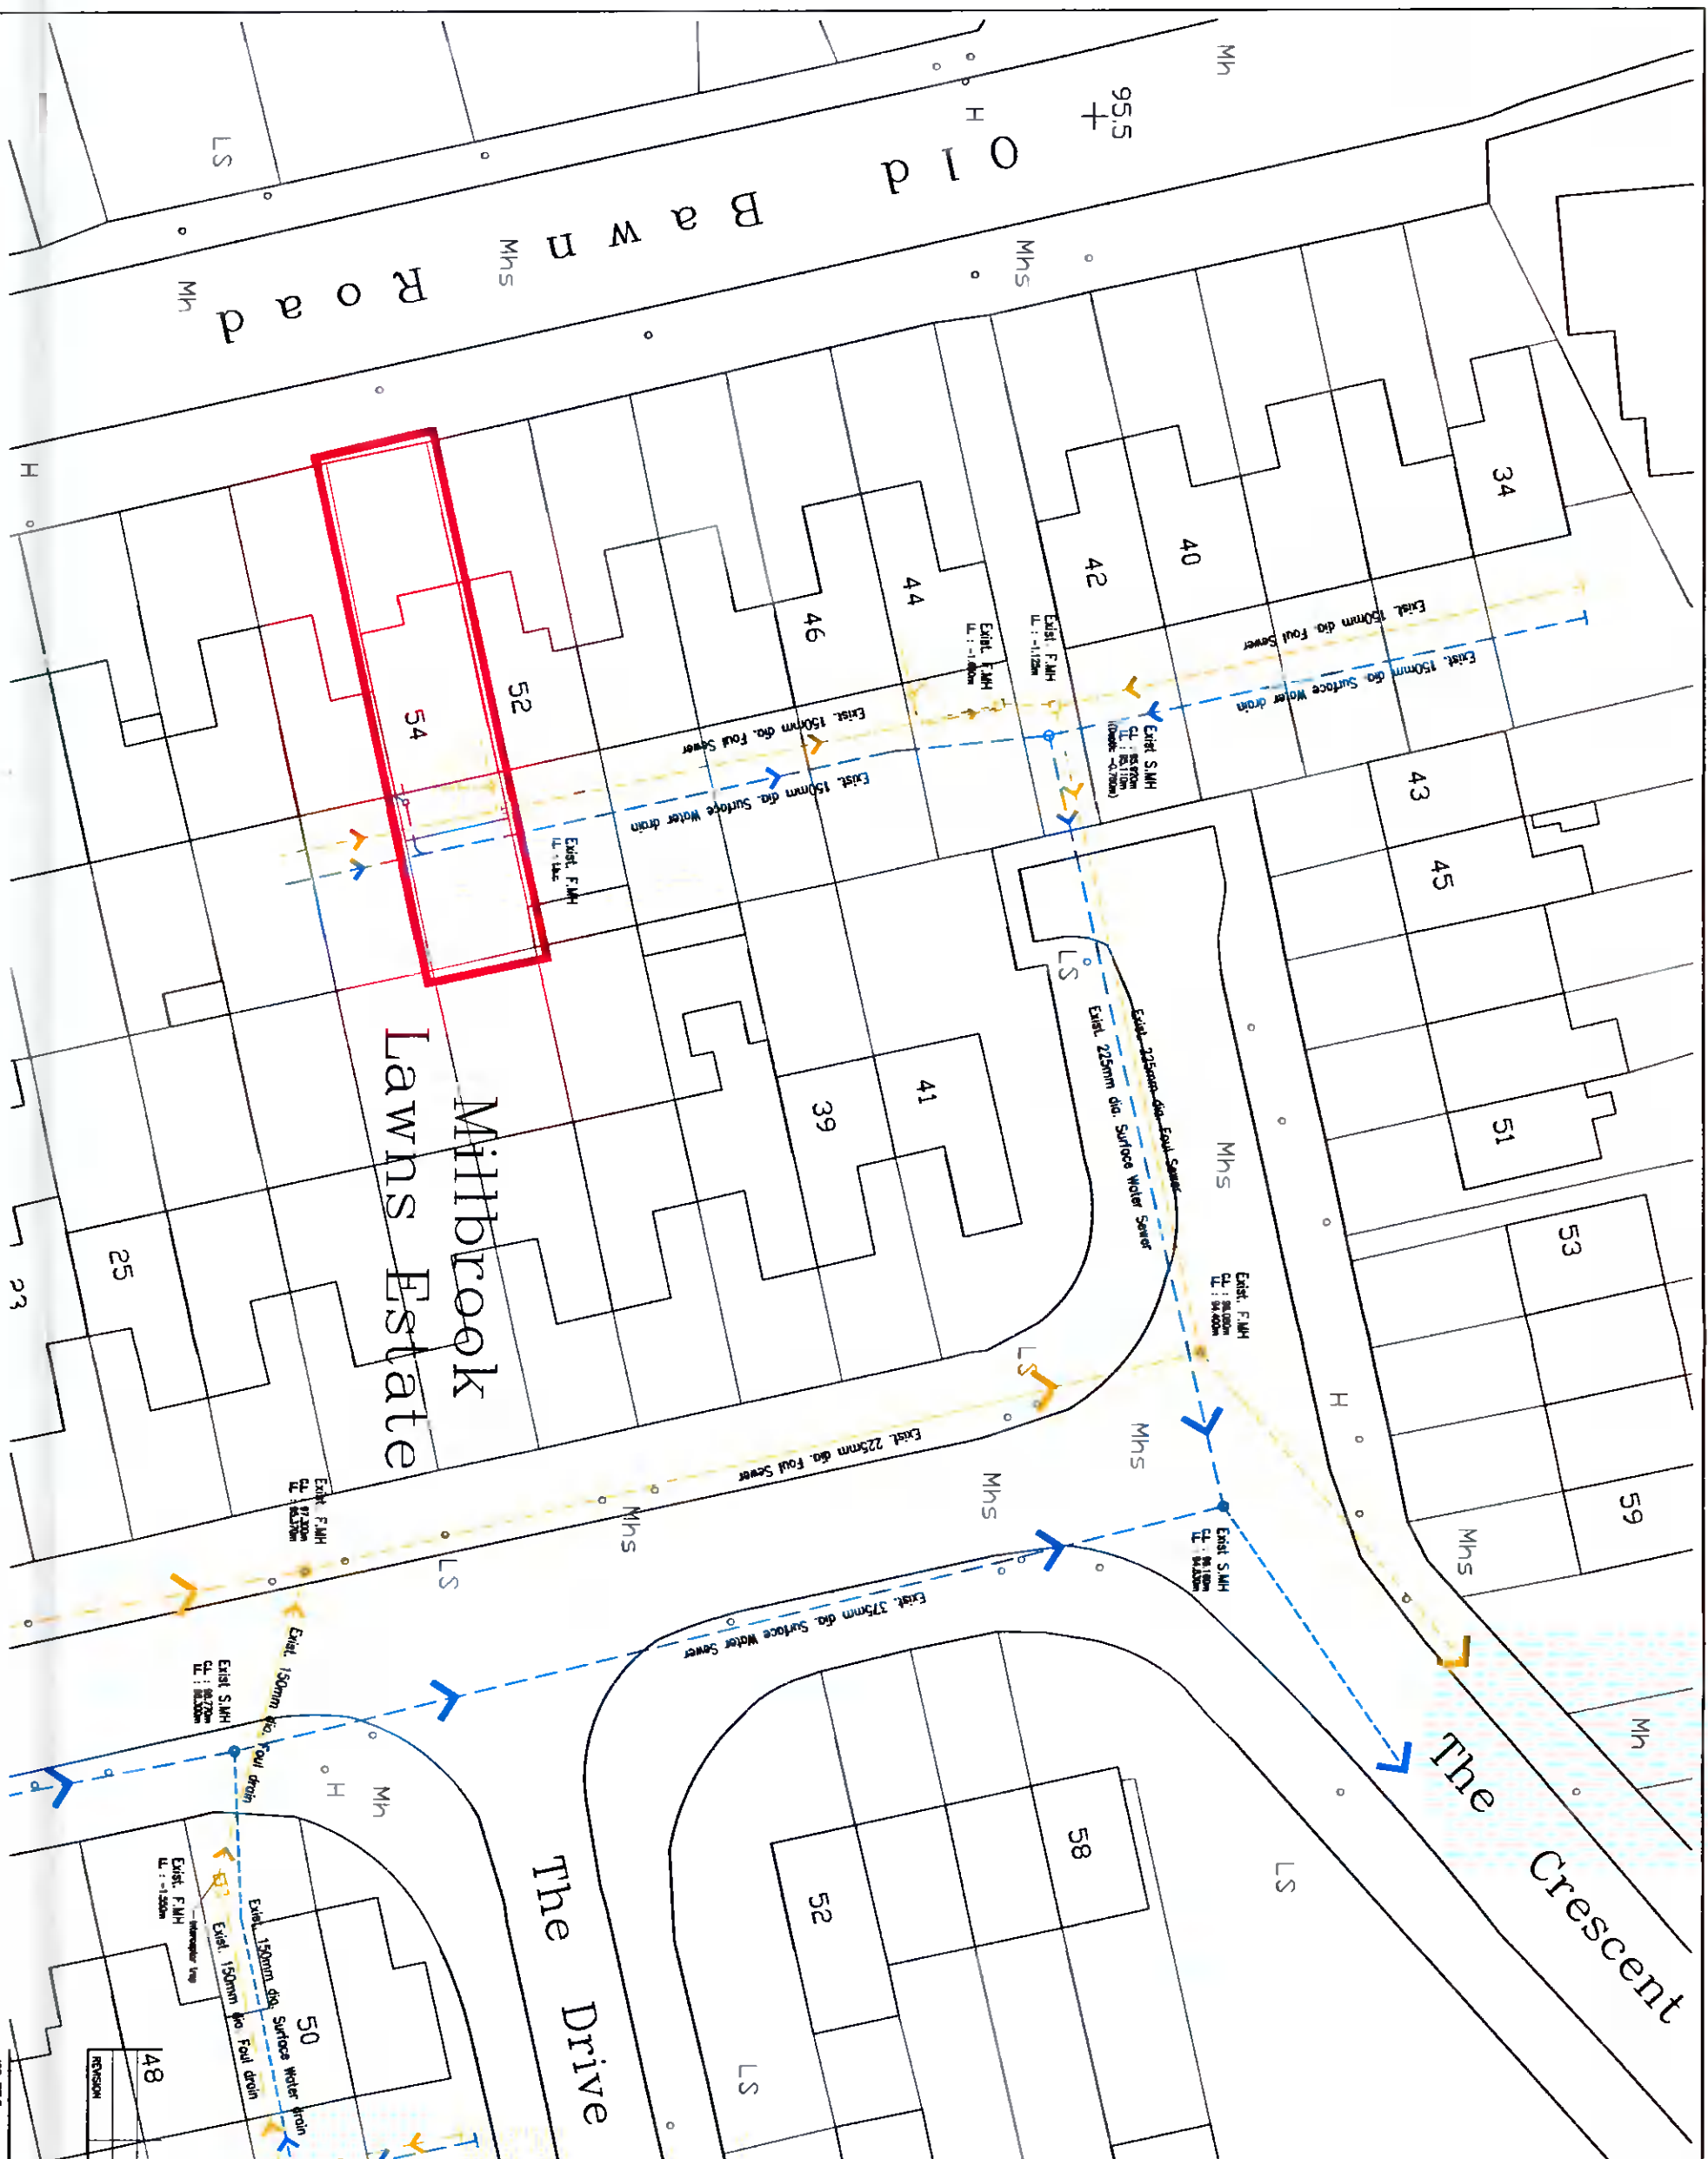

NOTES

All drawings are the copyright of the consultant (NIA Planning Consultants) and they may not be used in any other way without the written consent of the consultant.

Do not scale from the drawings, use written dimensions only.

All dimensions to be checked on site by the contractor and the architect's verifier of any discrepancies.

All levels indicated are approximate unless levels are given and do not relate to Ordnance Datum.

All levels shall be checked on site.

All work to be carried out in accordance with the 1987 Planning Regulations, with all subsequent amendments.

All work shall be the responsibility of the contractor.

**PROPOSED NEW PITCHED ROOF STRUCTURE TO
54 OLD BAWN ROAD, TALLAGHT, DUBLIN 24
FOR LUKE WILSON & KELSEY PHELAN**

Niall Jones & Associates
Planning Consultants

DATE: 21/27/21
JOB NO.: P.07

SCALE: 1:100

DATE: NOV/21

DRAWN BY: N.Jones

CHECKED: N.J.

DATE: 21/27/21

JOB TITLE: PROPOSED NEW PITCHED ROOF STRUCTURE TO 54 OLD BAWN ROAD, TALLAGHT, DUBLIN 24 FOR LUKE WILSON & KELSEY PHELAN

DRAWING TITLE: SITE BLOCK PLAN / SITE DRAINAGE LAYOUT