


# Site Block Plan / Site Drainage Layout

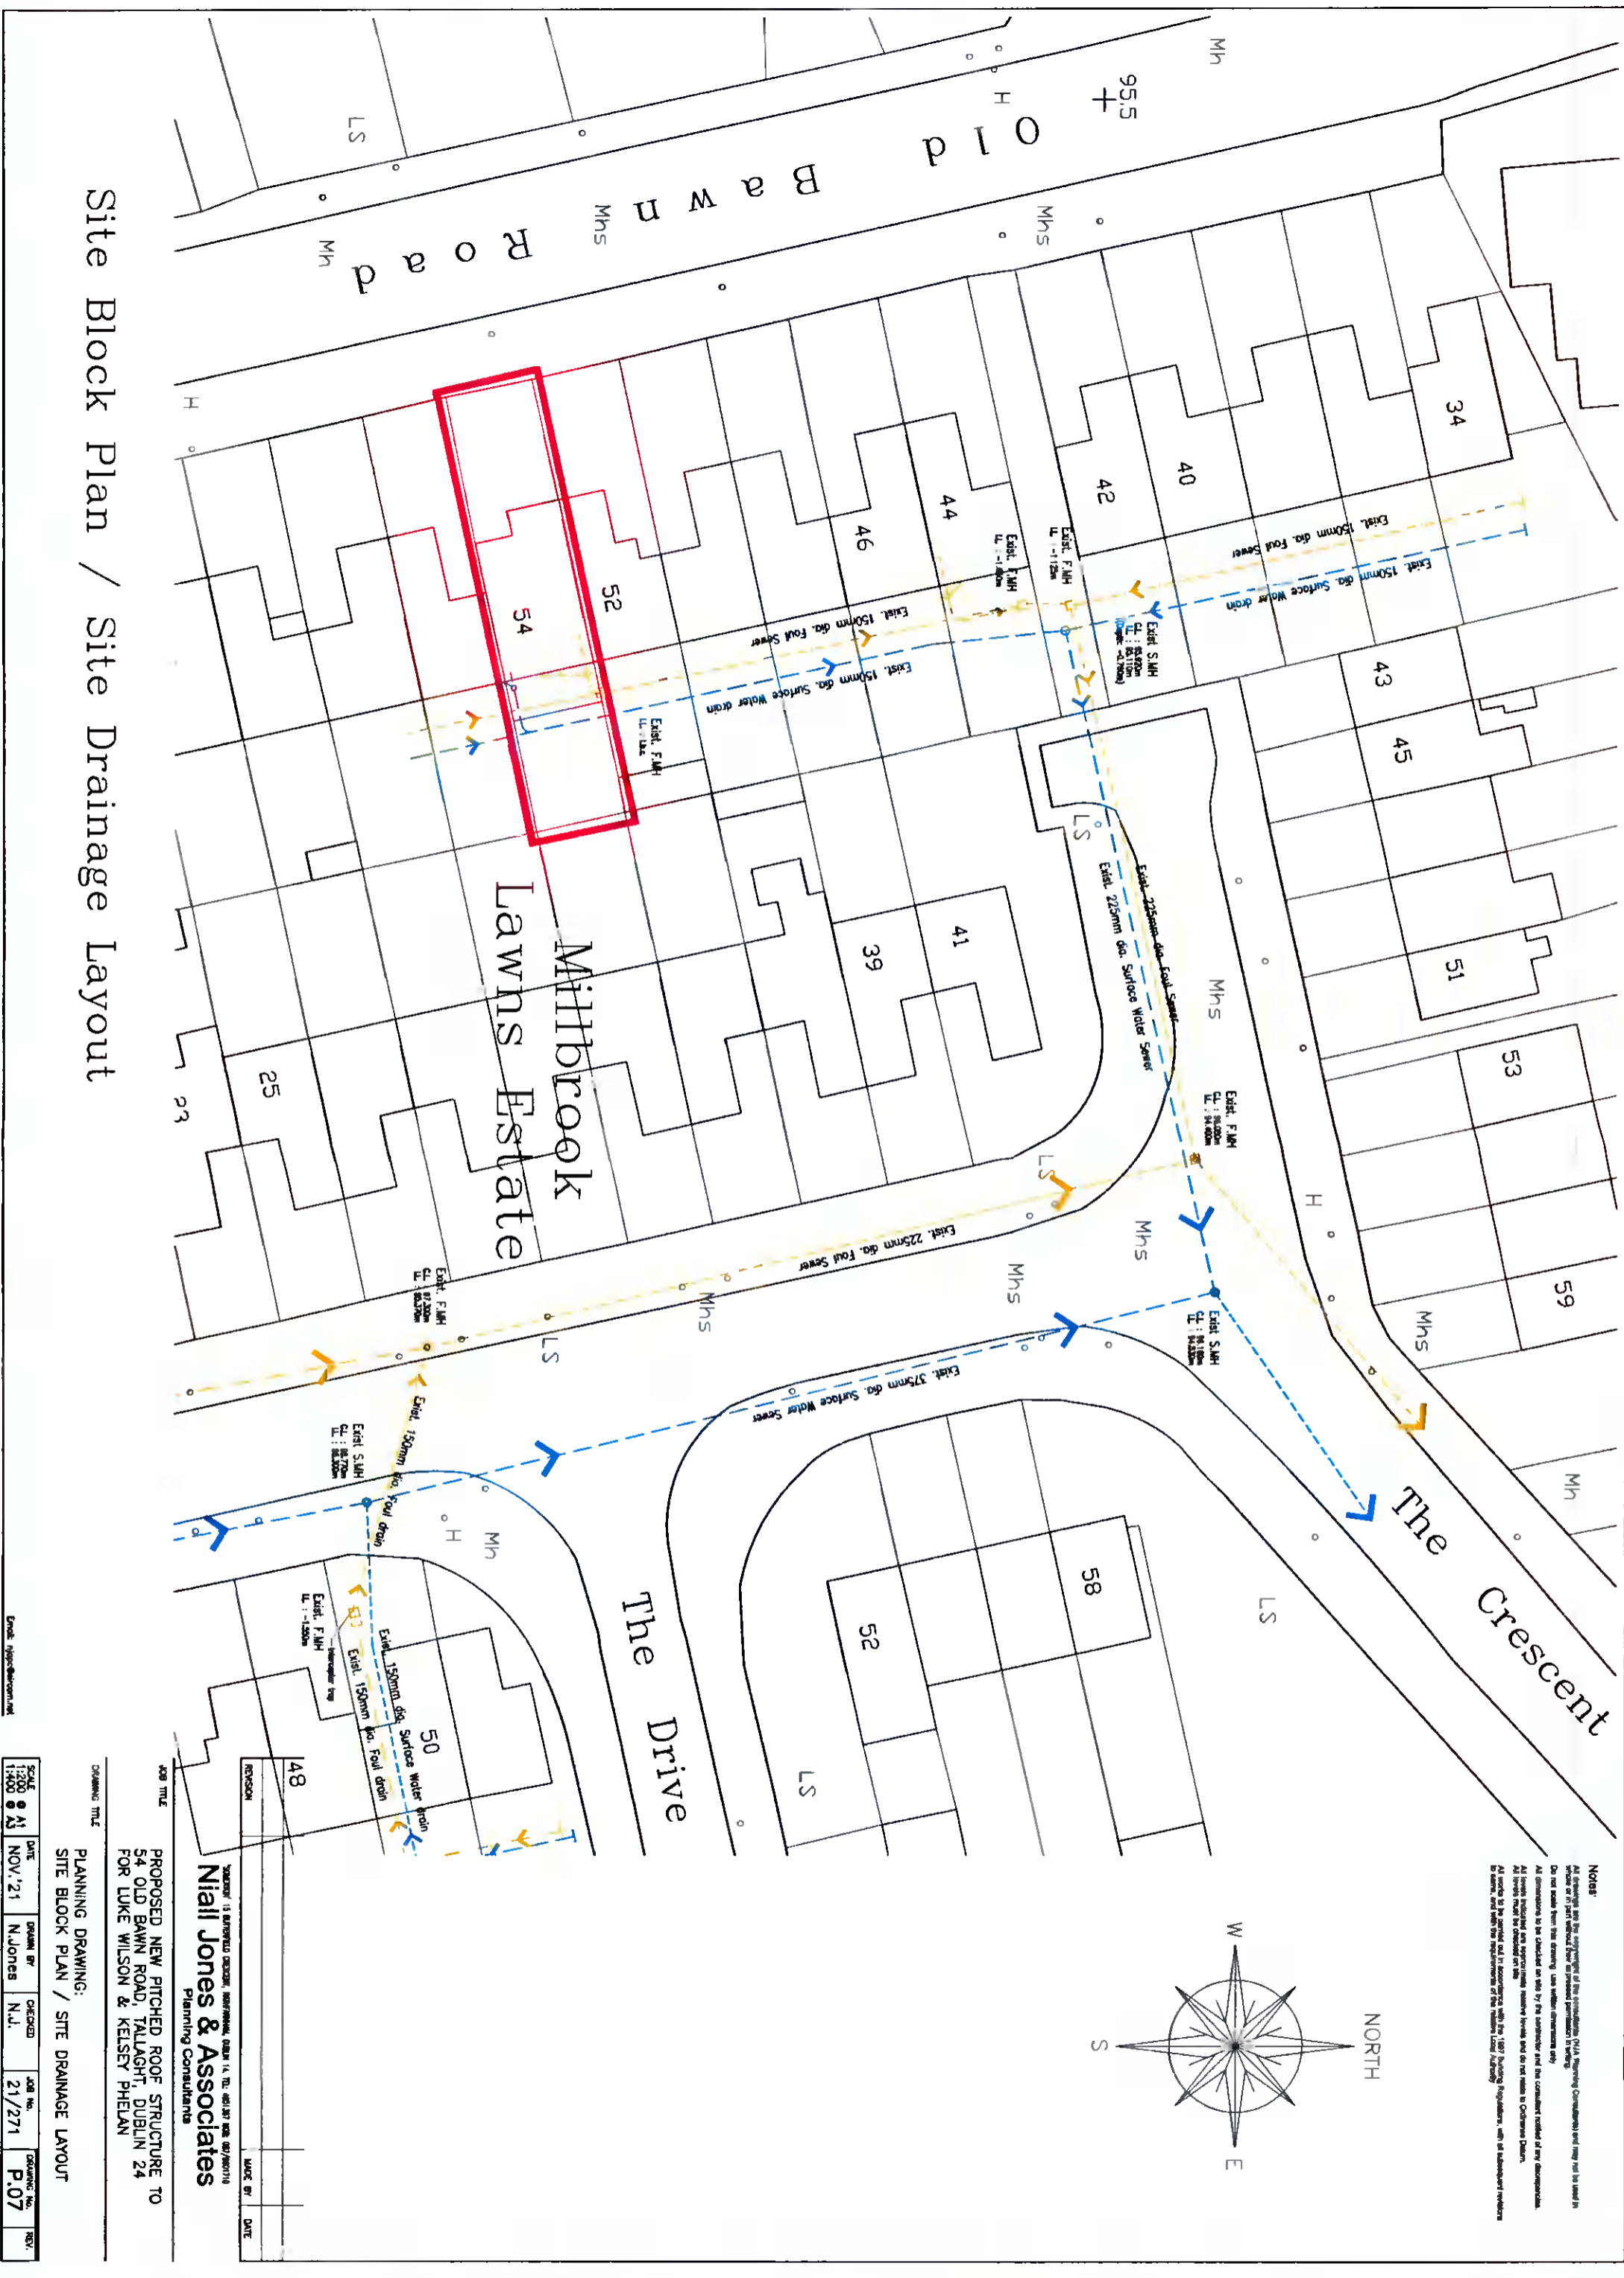

**Notes:**  
 All drawings are the property of the consultants (NIA Planning Consultants) and they will be used in  
 connection with the proposed development only.  
 Do not make any alterations to this drawing without the written consent of the consultants.  
 All drawings are to be submitted to the relevant authorities for their approval.  
 All levels are to be in accordance with the 1987 Building Regulations, with the exception of  
 those levels which are otherwise indicated.  
 All levels are to be in accordance with the 1987 Building Regulations, with the exception of  
 those levels which are otherwise indicated.

**PROPOSED NEW PITCHED ROOF STRUCTURE TO  
 54 OLD BAWN ROAD, TALLAGHT, DUBLIN 24  
 FOR LUKE WILSON & KEISLEY PHELAN**

**Niall Jones & Associates**  
 Planning Consultants

Scale: 1:1000  
 Date: NOV '21  
 Drawn by: N.Jones  
 Checked: N.J.  
 Job No.: 21/271  
 Drawing No.: P.07