

# OSI PLACE Map



National Mapping Agency

730891

707101

730891

707101

730891

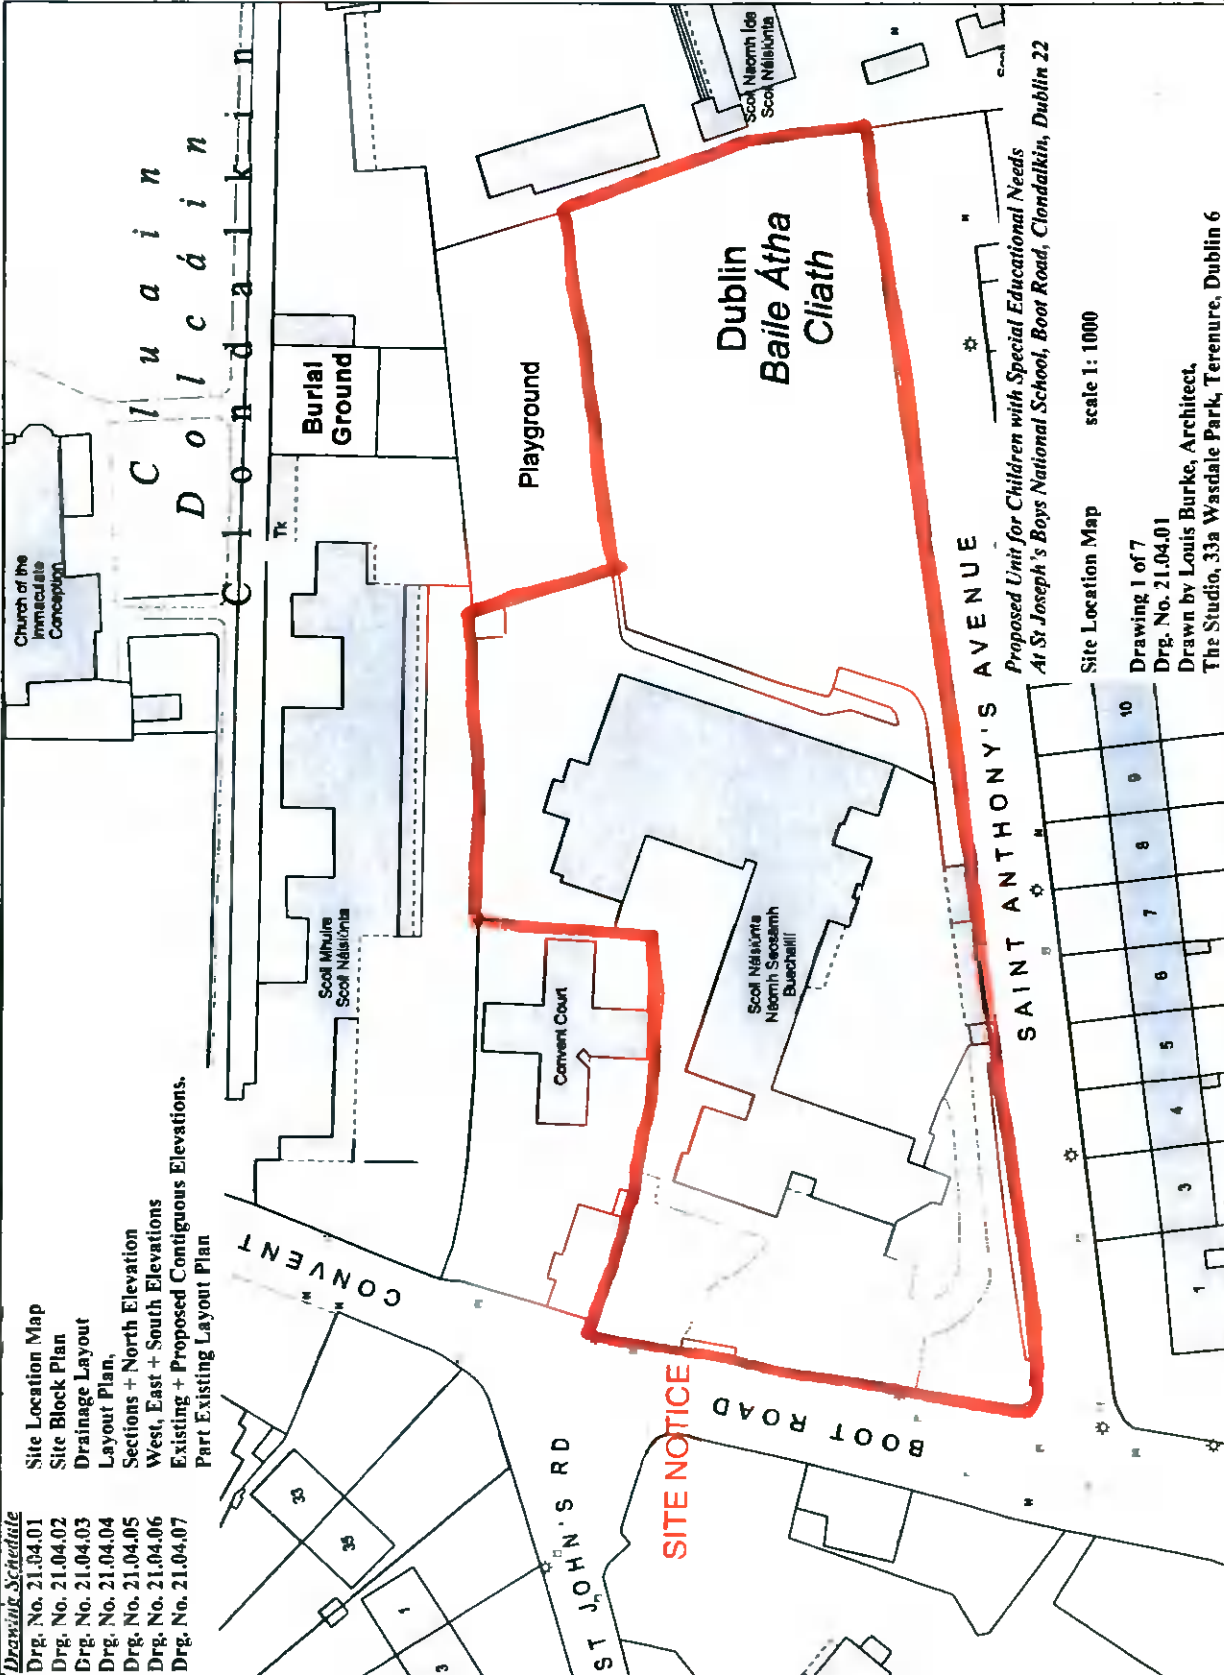
707101

730891

707101

730891

- Drawing Schedule**
- Drng. No. 21.04.01 Site Location Map
  - Drng. No. 21.04.02 Site Block Plan
  - Drng. No. 21.04.03 Drainage Layout
  - Drng. No. 21.04.04 Layout Plan
  - Drng. No. 21.04.05 Sections + North Elevation
  - Drng. No. 21.04.06 West, East + South Elevations
  - Drng. No. 21.04.07 Existing + Proposed Contiguous Elevations, Part Existing Layout Plan



730891

707101

730891

707101

**Ordnance Survey Ireland**  
Licence No. AR 0056503

**COMPILED AND PUBLISHED BY:**  
Ordnance Survey Ireland,  
Phoenix Park,  
Dublin 8,  
Ireland.

Unauthorized reproduction  
infringes Ordnance Survey Ireland  
and Government of Ireland  
copyright.

All rights reserved.  
No part of this publication may  
be copied, reproduced  
or transmitted in any form  
or by any means without the prior  
written permission of  
the copyright owners.

The representation on this map  
of a road, track or footpath  
is not evidence of the existence  
of a right of way

Ordnance Survey maps  
never show legal property  
boundaries, nor do they  
show ownership of  
physical features.

© Suirbhéireacht Ordánais Éireann,  
2021  
© Ordnance Survey Ireland, 2021  
www.osi.ie/copyright

**LEGEND:**  
<http://www.osi.ie>,  
search 'Large Scale Legend'

**Dublin Baile Atha Cliath**

**Proposed Unit for Children with Special Educational Needs**  
At St. Joseph's Boys National School, Boot Road, Clondalkin, Dublin 22

**SAINT ANTHONY'S AVENUE**

**BOOT ROAD**

**ST JOHN'S RD**

**Church of the Immaculate Conception**

**Burial Ground**

**Playground**

**Convent Court**

**Scol Naisiúnta Níomh Seosamh Buechailí**

**Scol Naisiúnta Níomh Ide**

**Scol Naisiúnta**

**Scale 1: 1000**

**Site Location Map**

**Drawing 1 of 7**  
Drng. No. 21.04.01  
Drawn by Louis Burke, Architect,  
The Studio, 33a Wasdale Park, Terenure, Dublin 6

**CAPTURE RESOLUTION:**  
The map objects are only accurate to the  
resolution at which they were captured.  
Output scale is not indicative of data capture scale.  
Further information is available at:  
<http://www.osi.ie>; search 'Capture Resolution'

**OUTPUT SCALE: 1:1,000**

0 10 20 30 40 metres

0 20 40 60 80 100 Feet

730891

707101

730891

707101

730891