



Proposed Block Plan & Drainage Layout
SCALE 1:200

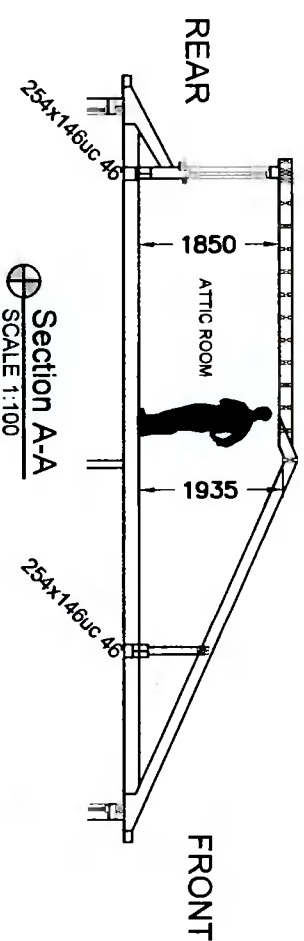

Rafter insulation Kingspan K7 100mm between rafters with Kingspan K18 37.5mm plasterboard backed.
Dormer wall insulation Kingspan K8 80mm wall between timbers & K18 37.5mm plasterboard backed.
Dormer roof insulation Kingspan K7 100mm in joists & K18 37.5mm plasterboard backed.

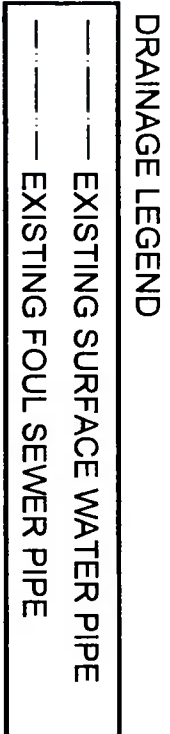

P	ISSUED FOR PLANNING	ND	NOV' 2021
REV:	REVISION TITLE:	DRN:	CHD:
		DATE:	

AA Architecture

4 CARRIGMORE CLOSE, AYLESBURY,
Dublin 24 - Ph: 01 4148358

CATHAL DALY & AIDEEN MURPHY

PROPOSED WORKS AT 48 WOODSTOWN DRIVE, KNOCKLYON, DUBLIN 16

TITLE: PROPOSED BLOCK PLAN, DRAINAGE LAYOUT & SECTION A-A

SCALE:	INITIALS:	DATE:
As shown	ND	NOV' 2021
JOB No:	DRAWING No:	REV:
S483	004	P

THIS DRAWING IS ISSUED FOR PLANNING PERMISSION ONLY, AND IS NOT A CONSTRUCTION DRAWING

NOTES:

This drawing is to be read in conjunction with all relevant Engineers drawings.
Do not scale use figured dimensions ONLY.
All dimensions in millimeters unless otherwise stated.
All dimensions to be checked on site.
All building works to comply with current building regulations & in accordance with Homebond Standards.