


1 Copyright © 2021 Vincent Durkin Design Ltd. 2. Work is prepared for the client and shall not be used for any other purpose without the written consent of Vincent Durkin Design Ltd. 3. The contractor is responsible for checking all levels and dimensions on site and shall inform the architect of any discrepancies. 4. Where appropriate, for details of structure or mechanical and electrical details, see Independent Engineers drawings. 5. Proprietary items shall be checked with manufacturer's instructions. 6. Basis of proprietary items shall be checked with manufacturer's instructions. 7. The contractor shall be responsible for the coordination of structure, fixtures and services.

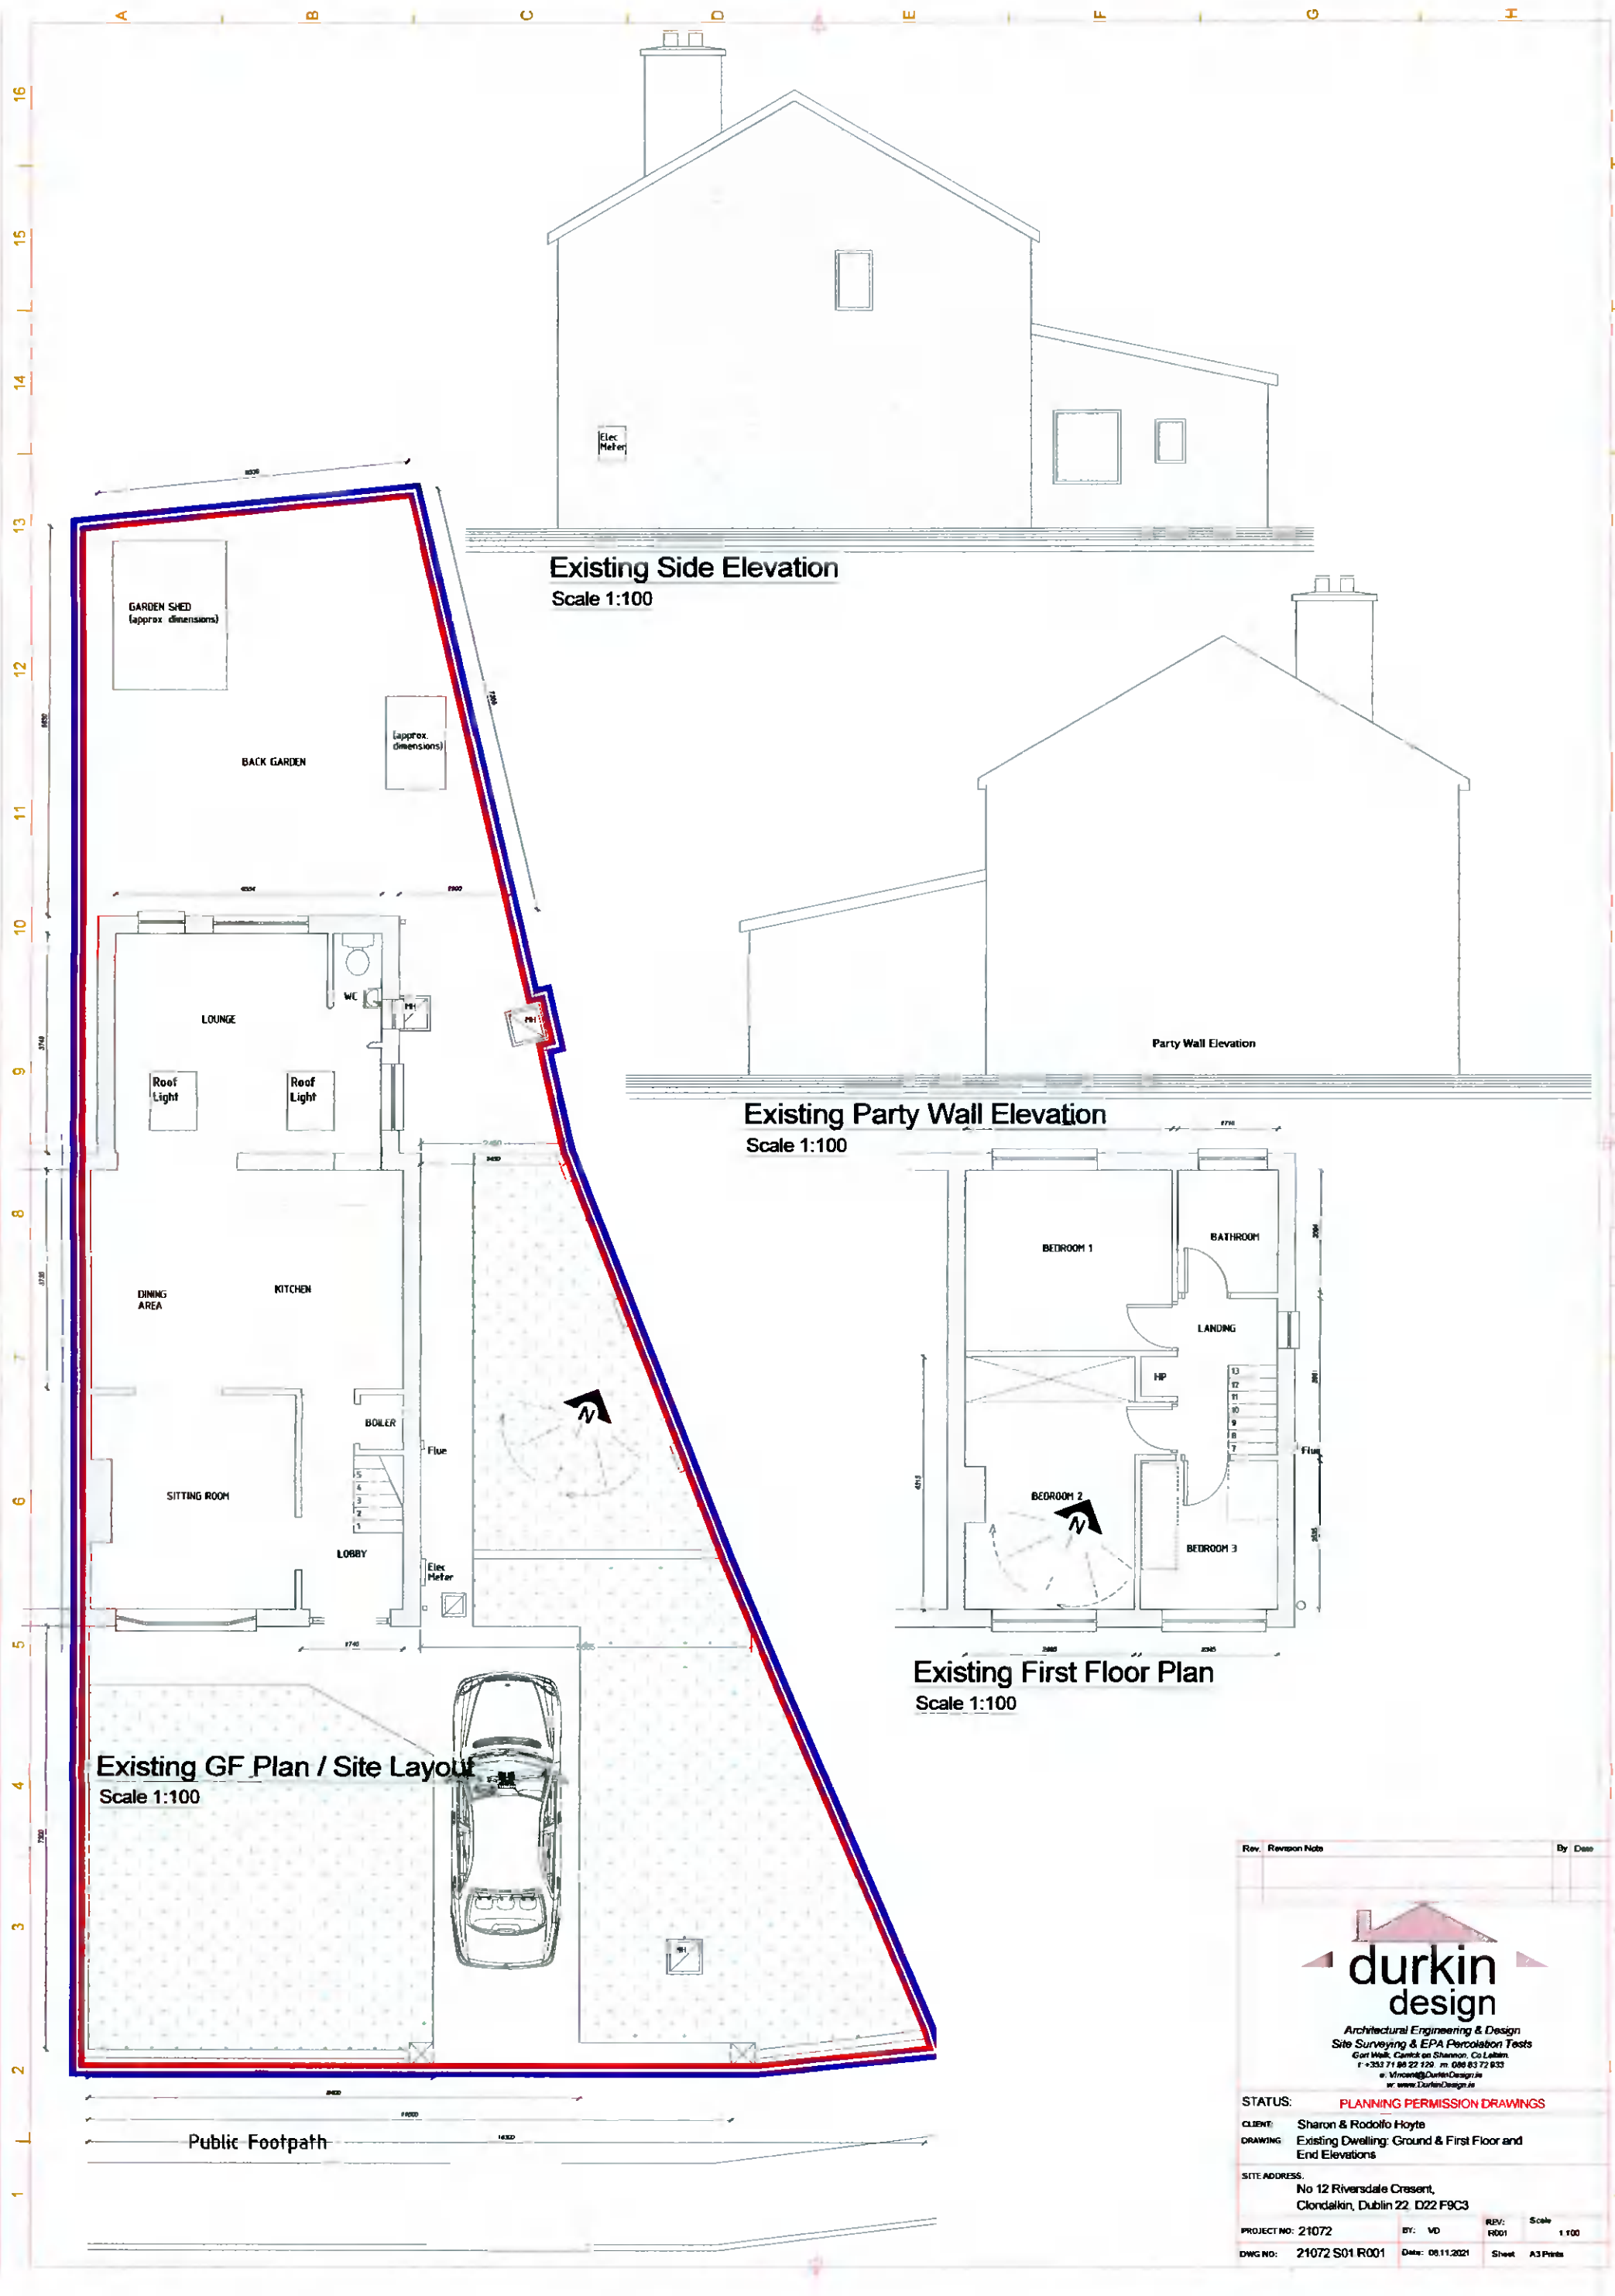

**Existing Side Elevation**  
Scale 1:100

**Existing Party Wall Elevation**  
Scale 1:100

**Existing First Floor Plan**  
Scale 1:100

**Existing GF Plan / Site Layout**  
Scale 1:100

Rev.	Revision Note	By	Date

  
**durkin design**  
 Architectural Engineering & Design  
 Site Surveying & EPA Percolation Tests  
 Gort Walk, Carrick on Shannon, Co. Leitrim  
 T: +353 71 90 22 120, M: 090 83 72 833  
 v: vincent@durkindesign.ie  
 w: www.durkindesign.ie

**STATUS:** PLANNING PERMISSION DRAWINGS  
**CLIENT:** Sharon & Rodolfo Hoyte  
**DRAWING:** Existing Dwelling: Ground & First Floor and End Elevations  
**SITE ADDRESS:** No 12 Riversdale Crescent, Clonsilla, Dublin 22, D22 F9C3  
**PROJECT NO:** 21072     **BY:** VD     **REV:** R001     **Scale:** 1:100  
**DWG NO:** 21072 S01 R001     **Date:** 06.11.2021     **Sheet:** A3 Plans