



**REFERENCE NOTE**  
REFER TO DWG. NO. H657-OCSC-XX-XX-DR-C-0500 FOR PROPOSED DRAINAGE LAYOUT


**SURFACE WATER NETWORK S1.000 - S1.010**

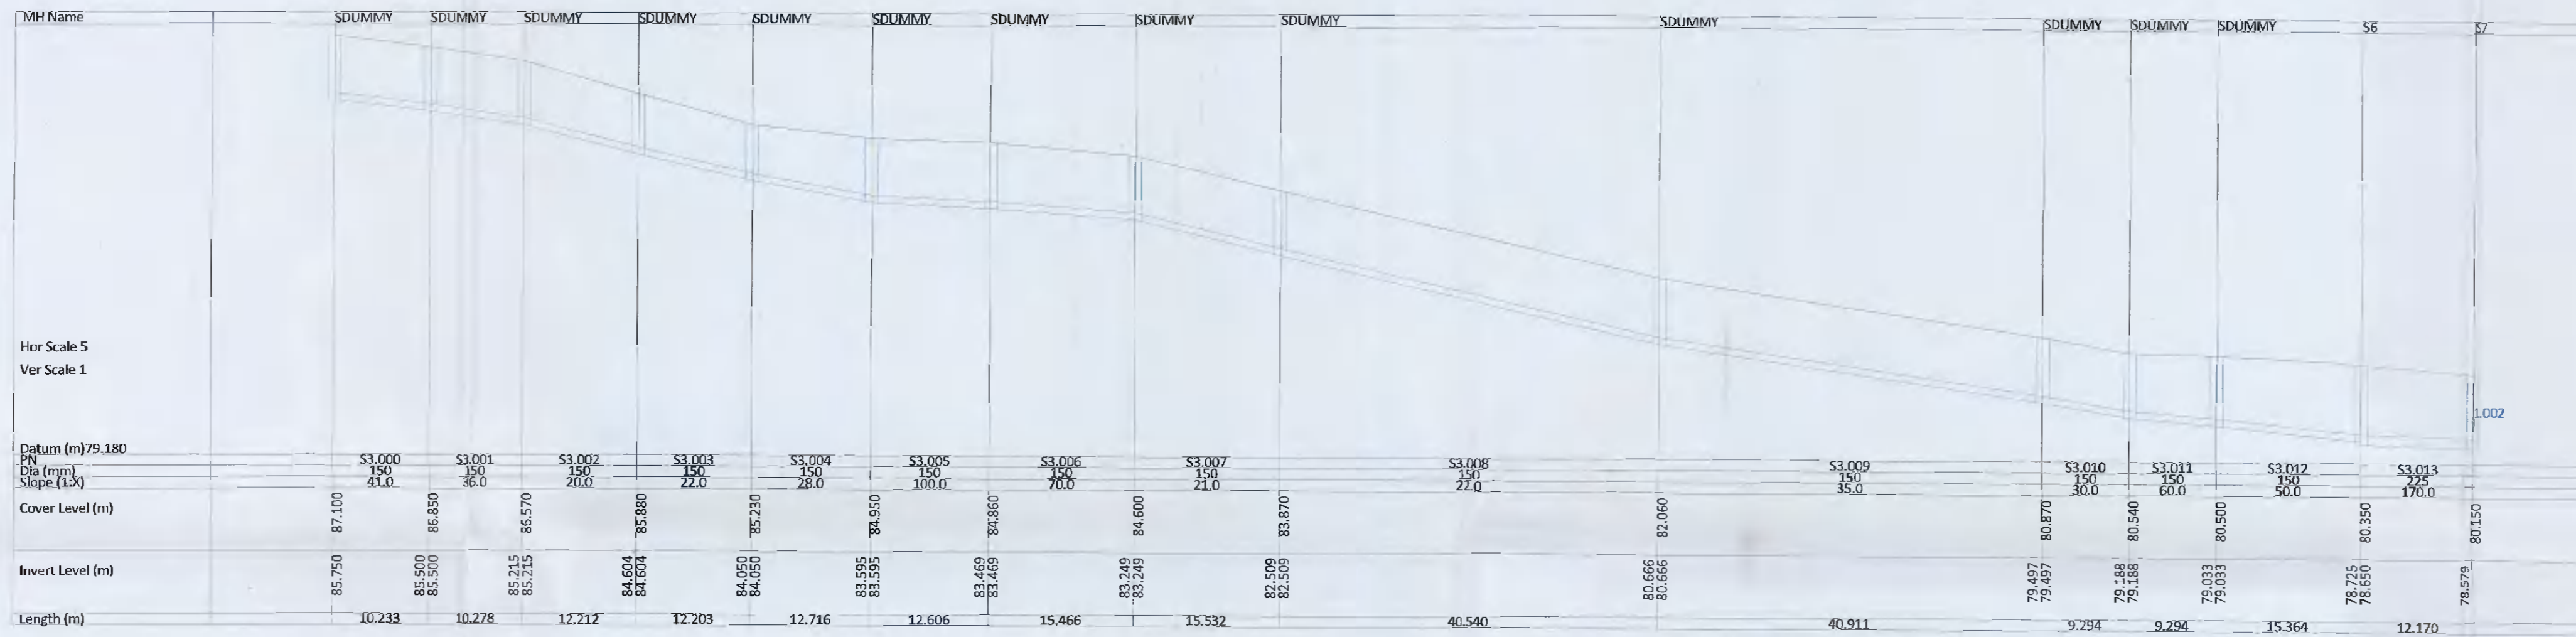


**SURFACE WATER NETWORK S3.000-S3.013**

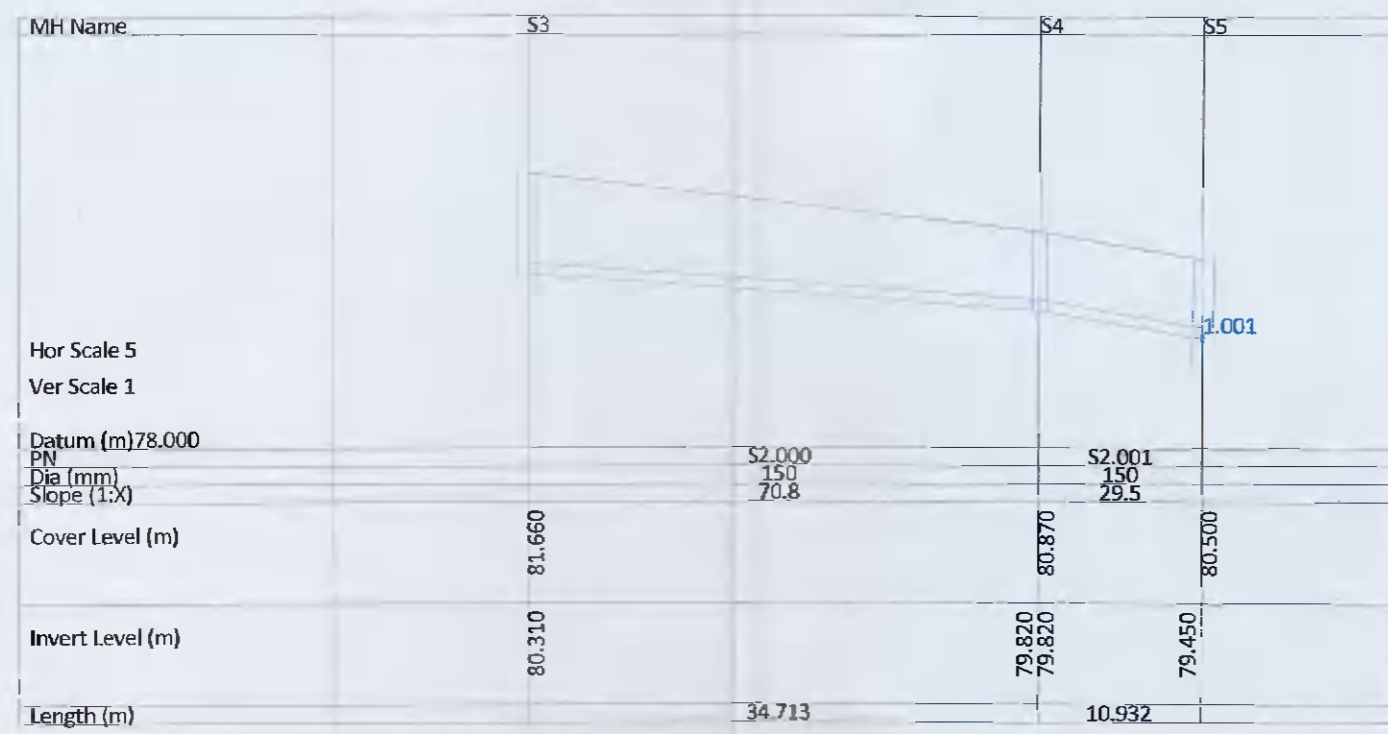

**SURFACE WATER NETWORK S2.000 - S2.001**

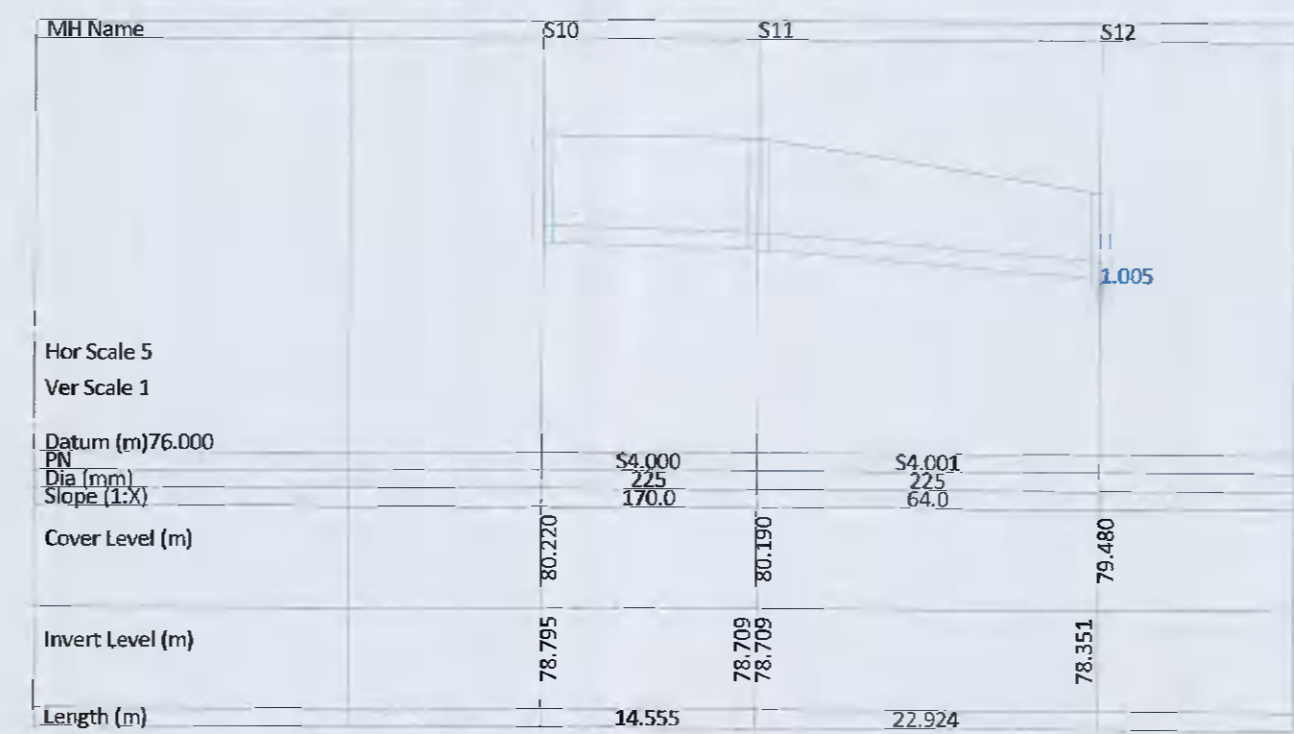

**SURFACE WATER NETWORK S4.000-S4.001**

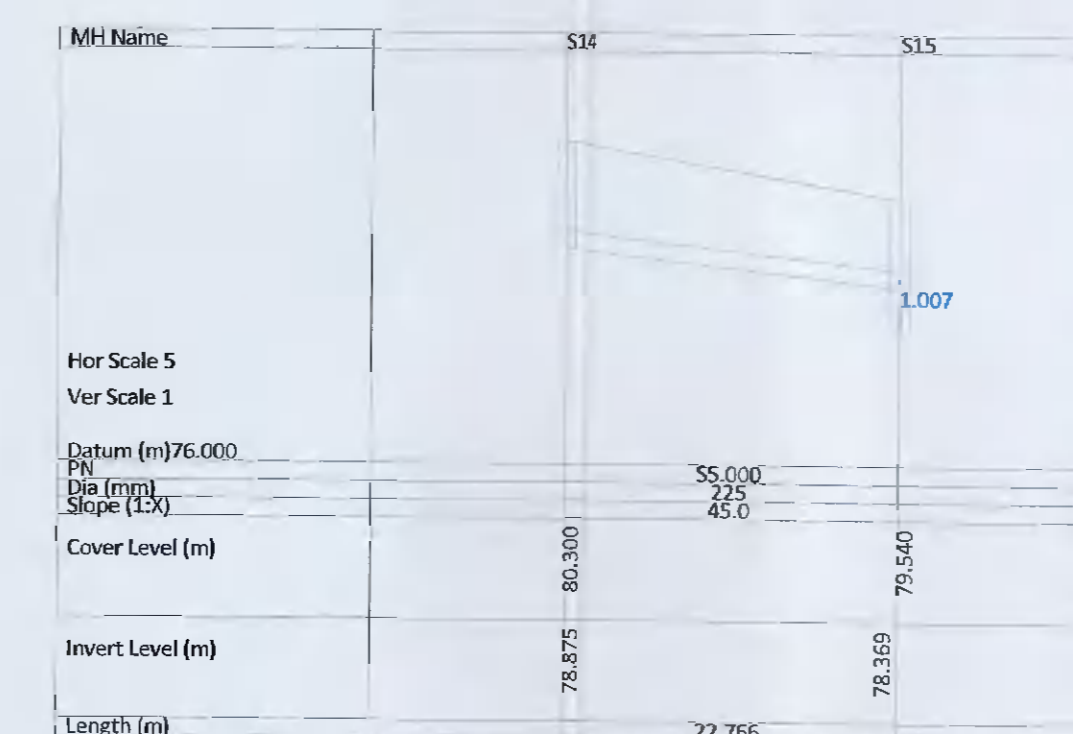

**SURFACE WATER NETWORK S5.000**

**PLANNING DRAWING.**  
NOT FOR CONSTRUCTION.  
ALL LEVELS GIVEN ARE  
RELATIVE TO ORDNANCE DATUM.  
THIS DRAWING HAS BEEN ISSUED FOR INFORMATION  
PURPOSES ONLY AND MUST NOT BE USED  
FOR CONSTRUCTION UNDER ANY CIRCUMSTANCES

ORDNANCE SURVEY OF IRELAND LICENCE NO. EN000821 © GOVERNMENT OF IRELAND

- FOR SETTING OUT REFER TO ARCHITECT'S DRAWINGS.
- THIS DRAWING TO BE READ IN CONJUNCTION WITH ALL OTHER ARCHITECTURAL AND ENGINEERING DRAWINGS AND ALL OTHER RELEVANT DRAWINGS AND SPECIFICATIONS.
- DO NOT SCALE THIS DRAWING. USE FIGURED DIMENSIONS ONLY.
- NO PART OF THIS DOCUMENT MAY BE REPRODUCED OR TRANSMITTED IN ANY FORM OR STORED IN ANY RETRIEVAL SYSTEM OF ANY NATURE WITHOUT THE WRITTEN PERMISSION OF O'CONNOR SUTTON CROININ AS COPYRIGHT HOLDER EXCEPT AS AGREED FOR USE ON THE PROJECT FOR WHICH THE DOCUMENT WAS ORIGINALLY ISSUED.

Rev No.	Date	Revision Note	Drn by	Chkd by	Rev No.	Date	Revision Note	Drn by	Chkd by
P01	01.06.21	STAGE COMPLETE. SUITABLE FOR PLANNING	DOM	MK					
C01	26.11.21	STAGE COMPLETE. SUITABLE FOR PLANNING	EH	MK					



Head Office,  
9 Prussia Street,  
Dublin 7,  
D07 KT57

TEL +353 (0)1 8682000  
E: [contactus@ocsc.ie](mailto:contactus@ocsc.ie)  
W: [www.ocsc.ie](http://www.ocsc.ie)



Client: HIBERNIA REIC LTD  
Project: KATHARINE TYNAN HOUSE

Title: PROPOSED DRAINAGE  
SURFACE WATER LONGSECTIONS

Code	Originator	Zone	Level	Type	Role	Number	Status	Revision
H657-OCSC-XX-XX-DR-C-0510						A1	C01	

Date: JUNE '21 Scale: 1:100 @ A1 Drn by:DOM Chkd by:MK Aprvd by:PH

Dublin London Belfast Galway Cork