



**REFERENCE NOTE**

REFER TO DWG. NO. H657-OCSC-XX-XX-DR-C-0500 FOR PROPOSED DRAINAGE LAYOUT

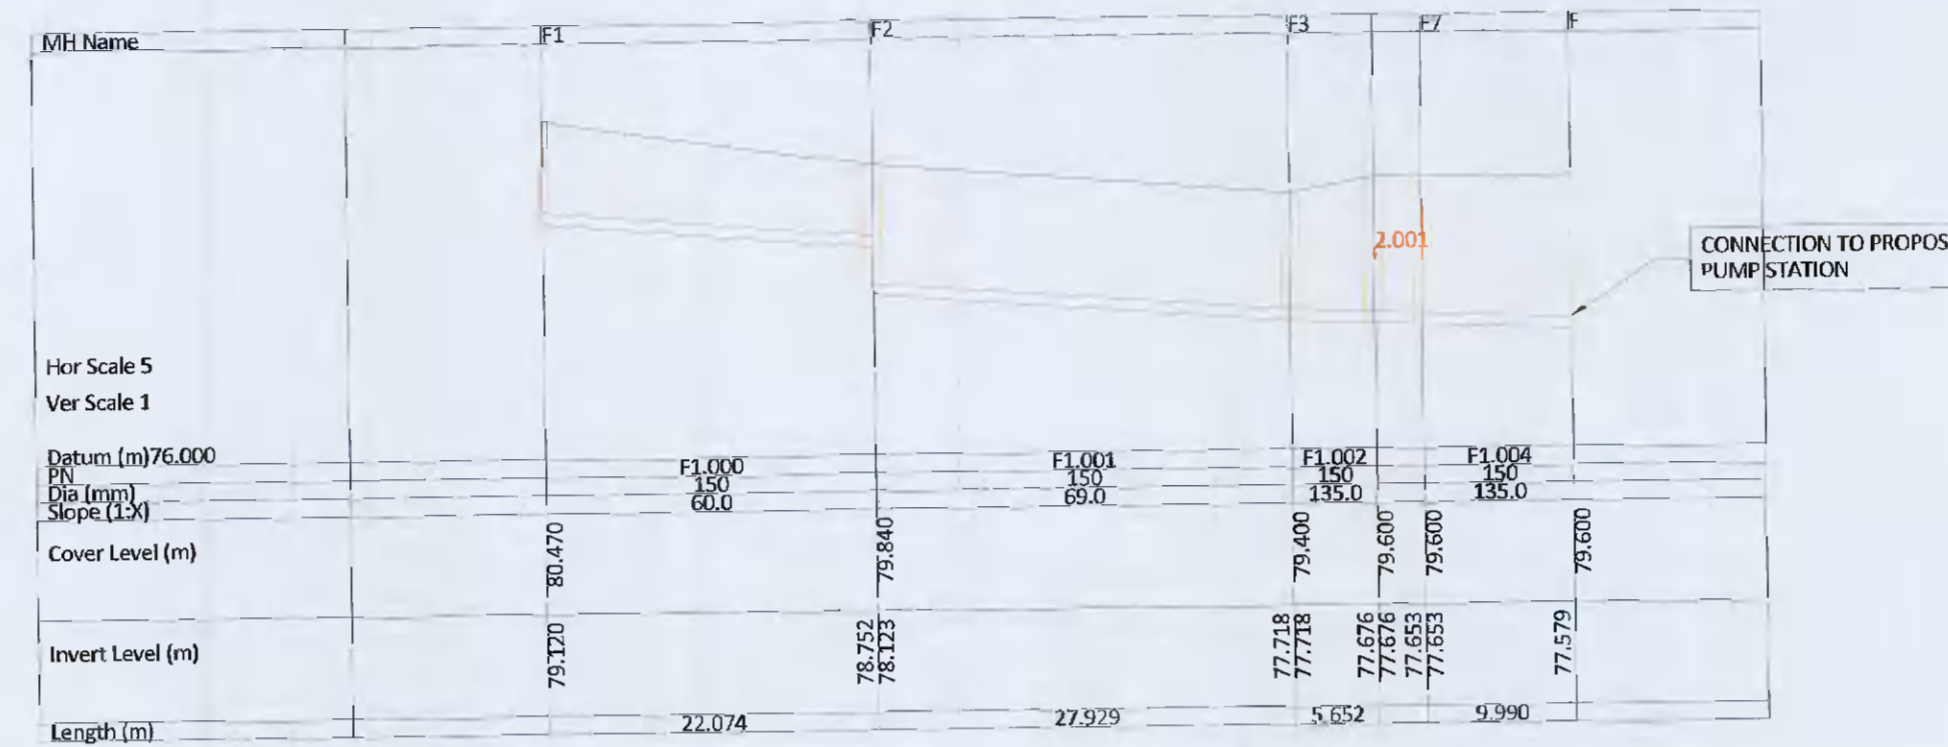

**WASTEWATER NETWORK F1.000 - F1.004**

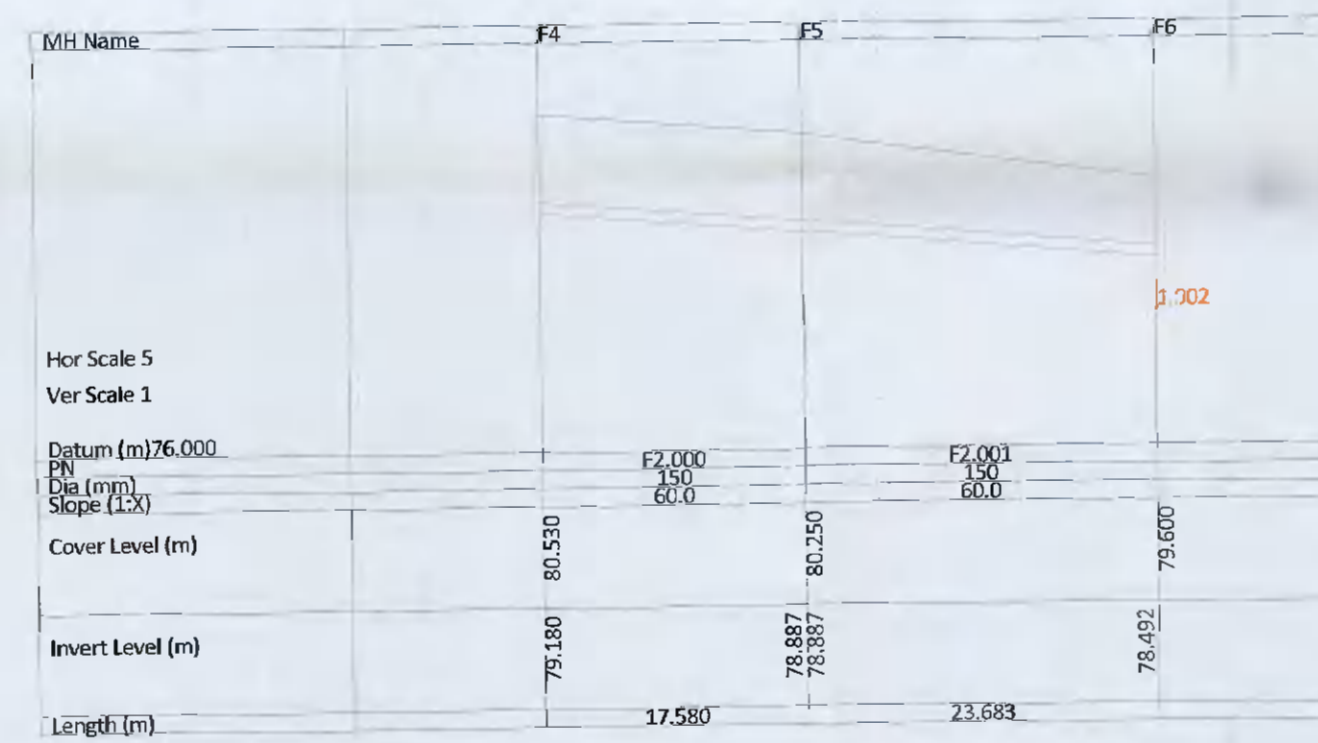

 
**WASTEWATER NETWORK F2.000 - F2.001**

**PLANNING DRAWING.**  
 NOT FOR CONSTRUCTION.  
 ALL LEVELS GIVEN ARE  
 RELATIVE TO ORDNANCE DATUM.  
 THIS DRAWING HAS BEEN ISSUED FOR INFORMATION  
 PURPOSES ONLY AND MUST NOT BE USED  
 FOR CONSTRUCTION UNDER ANY CIRCUMSTANCES

ORDNANCE SURVEY OF IRELAND LICENCE NO. EN0000821 © GOVERNMENT OF IRELAND

- FOR SETTING OUT REFER TO ARCHITECT'S DRAWINGS.
- THIS DRAWING TO BE READ IN CONJUNCTION WITH ALL OTHER ARCHITECTURAL AND ENGINEERING DRAWINGS AND ALL OTHER RELEVANT DRAWINGS AND SPECIFICATIONS.
- DO NOT SCALE THIS DRAWING. USE FIGURED DIMENSIONS ONLY.
- NO PART OF THIS DOCUMENT MAY BE REPRODUCED OR TRANSMITTED IN ANY FORM OR STORED IN ANY RETRIEVAL SYSTEM OF ANY NATURE WITHOUT THE WRITTEN PERMISSION OF O'CONNOR SUTTON CRONIN AS COPYRIGHT HOLDER EXCEPT AS AGREED FOR USE ON THE PROJECT FOR WHICH THE DOCUMENT WAS ORIGINALLY ISSUED.

Rev No.	Date	Revision Note	Drm by	Chkd by	Rev No.	Date	Revision Note	Drm by	Chkd by
P01	01.06.21	STAGE COMPLETE - SUITABLE FOR PLANNING	DOM	MK					
C01	26.11.21	STAGE COMPLETE - SUITABLE FOR PLANNING	EH	MK					



Head Office,  
 9 Prussia Street,  
 Dublin 7,  
 D07 K757

TEL +353 (0)1 8682000

e: [contactus@ocsc.ie](mailto:contactus@ocsc.ie)  
 w: [www.ocsc.ie](http://www.ocsc.ie)

Dublin | London | Belfast | Galway | Cork



Client: HIBERNIA REIC LTD  
 Project: KATHARINE TYNAN HOUSE

Title: PROPOSED DRAINAGE  
 WASTEWATER LONGSECTION

Code | Originator | Zone | Level | Type | Role | Number | Status | Revision  
 H657-OCSC-XX-XX-DR-C-0511 A1 C01  
 Date: JUNE '21 Scale: 1:100 @ A1 Drm by: DOM Chkd by: MK Aprvd by: PH