


# Site Block Plan / Drainage Layout

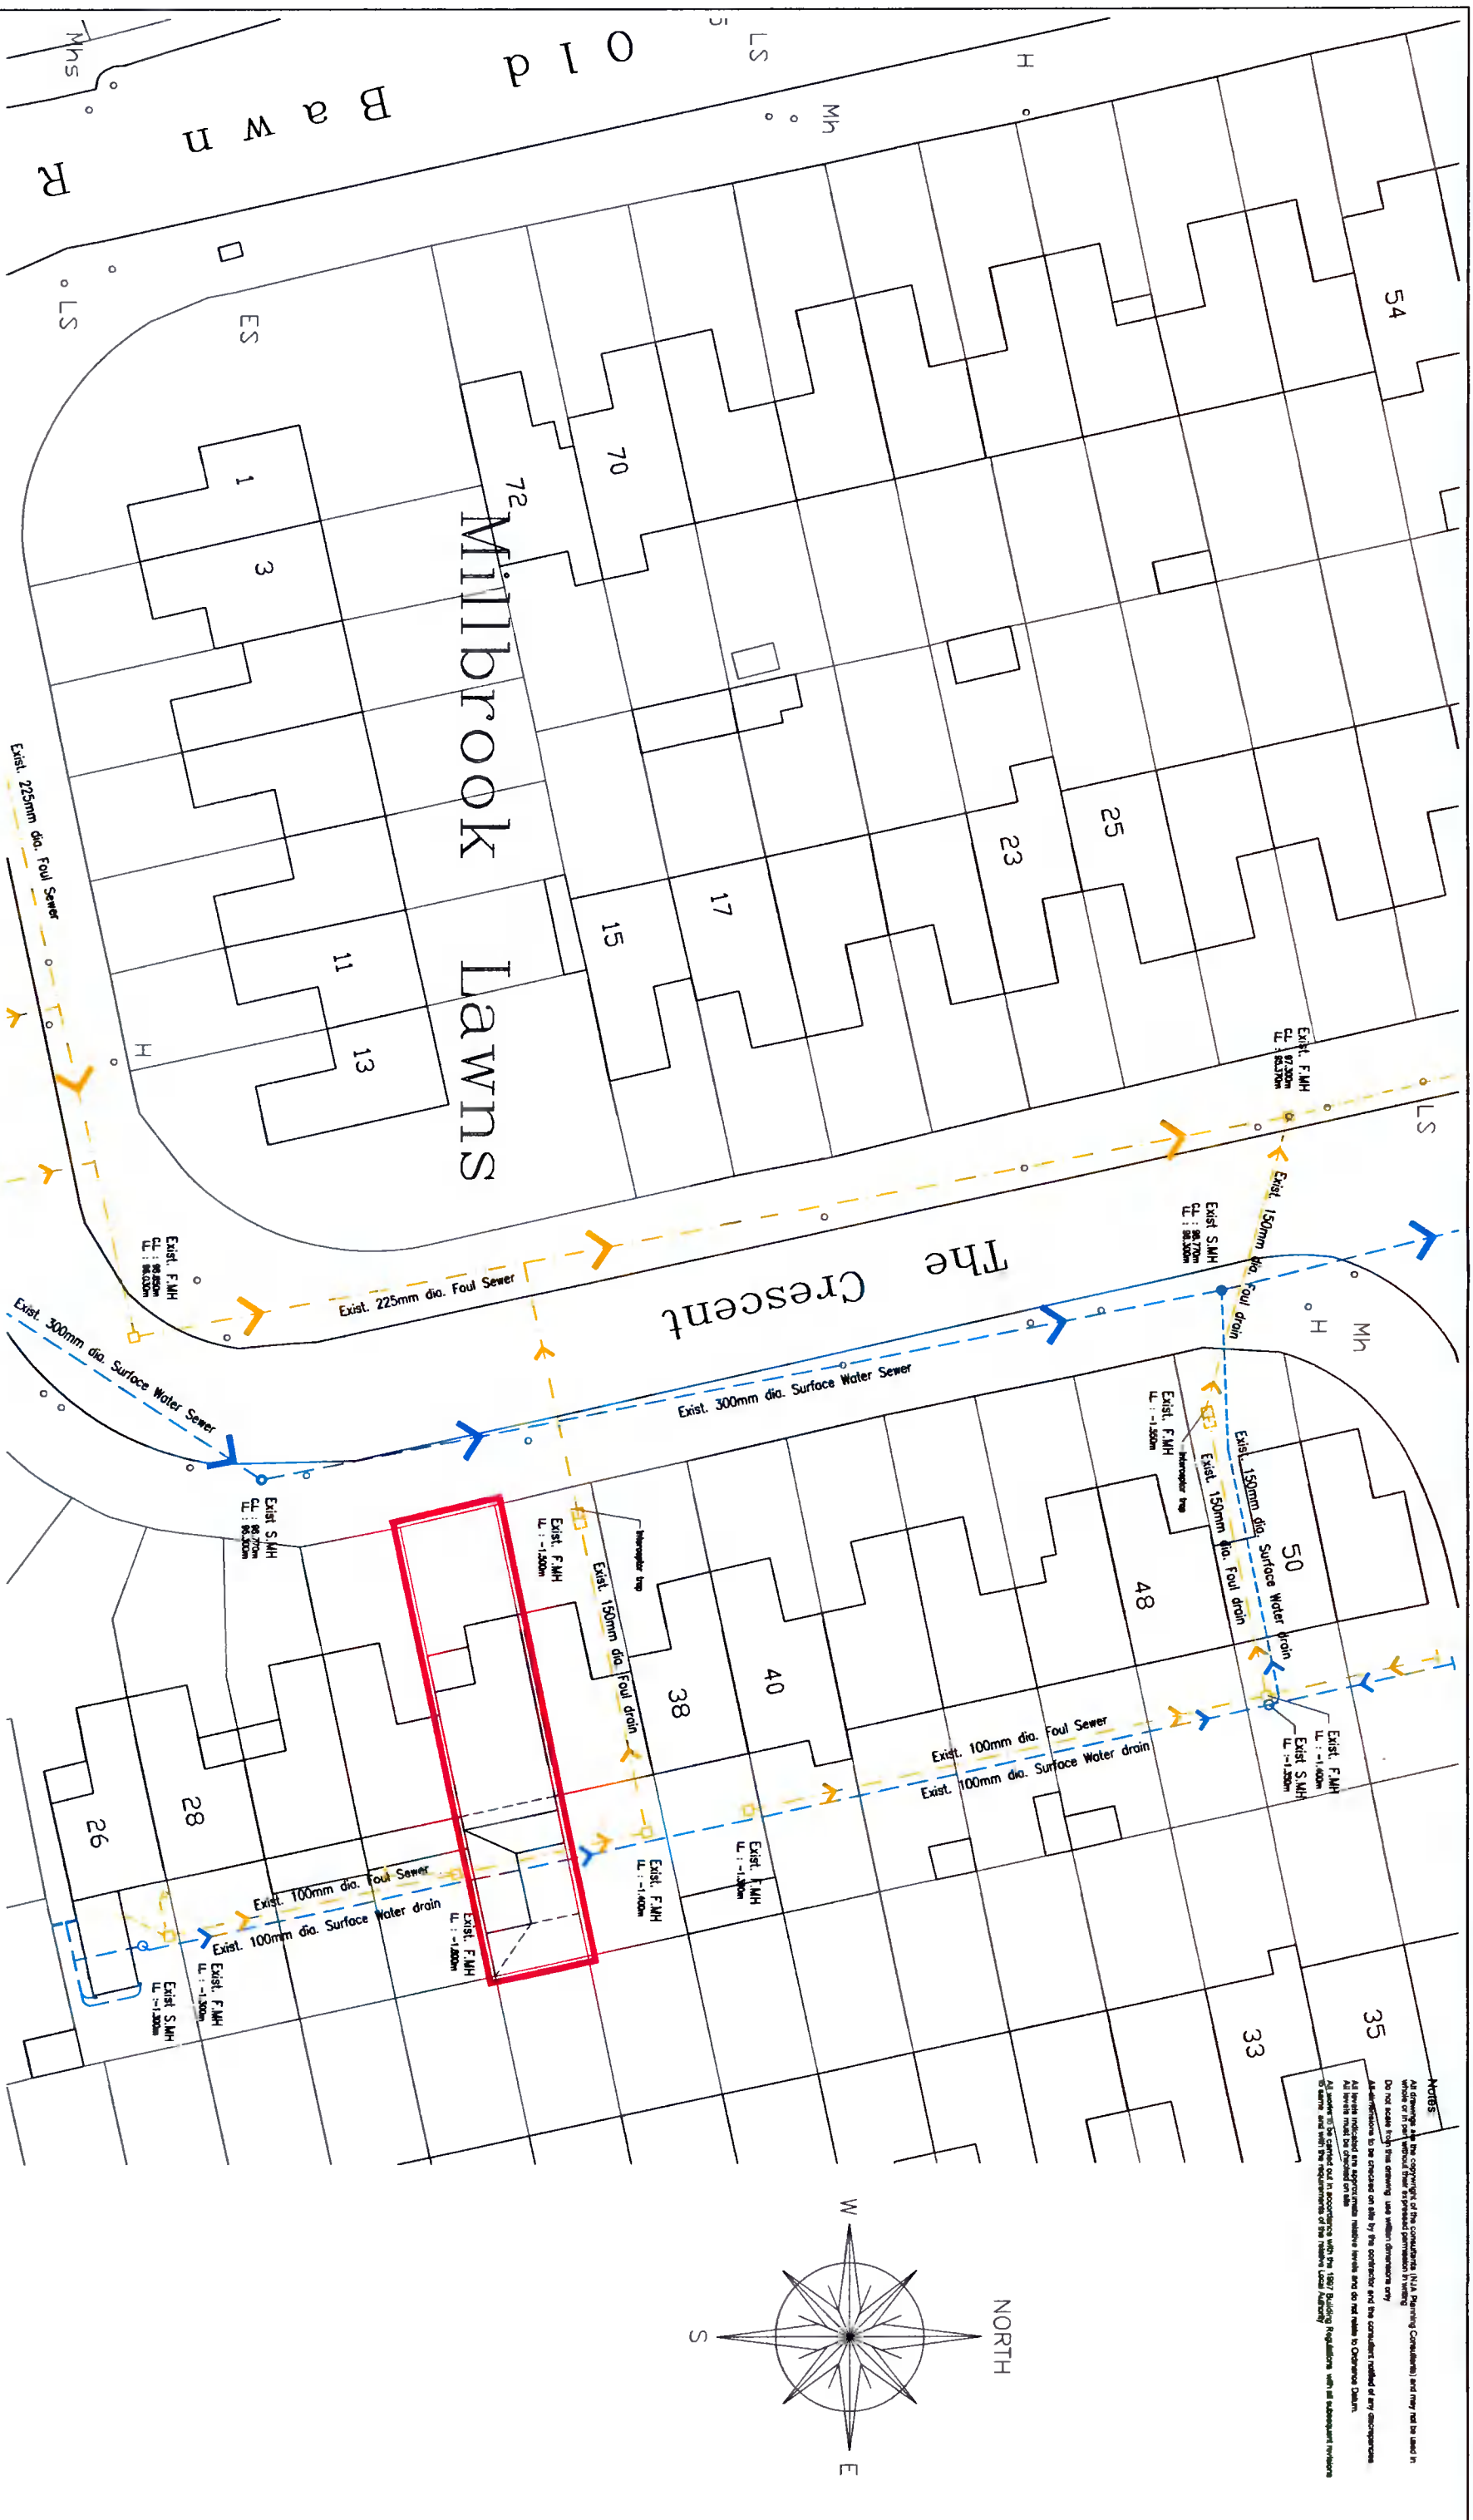

**NOTES**

All drawings are the copyright of the consultant (NIA Planning Consultants) and may not be used in any other project without the written permission of the consultant.

Do not scale any dimensions from this drawing. Use metric dimensions only.

Assumptions to be checked on site by the contractor and the consultant notified of any discrepancies.

All levels indicated are approximate relative levels and do not relate to Ordnance Datum.

All levels shall be checked on site.

All levels shall be checked out in accordance with the 1997 Building Regulations with all subsequent revisions.

All works shall be carried out in accordance with the latest Building Regulations.

REVISION	DATE	BY	DATE

**Niall Jones & Associates**  
 Planning Consultants

**JOB TITLE**  
 PROPOSED NEW PITCHED ROOF STRUCTURE TO  
 34 THE CRESCENT, MILLBROOK LAWNS, TALLAGHT, D-2  
 FOR MR. GER BERRINGHAM

**DRAWING TITLE**  
 PLANNING DRAWING:  
 SITE BLOCK PLAN / DRAINAGE LAYOUT

SCALE	DATE	DRAWN BY	CHECKED	JOB NO.	DRAWING NO.	REV.
1:100	NOV/21	N.Jones	N.J.	21/272	P.07	

Email: nplanning@nialljones.com