


GENERAL NOTES

- DO NOT SCALE THIS DRAWING. WORK ONLY TO FIGURED DIMENSIONS.
- FOR ALL RELEVANT NOTES, REFER TO STRUCTURAL AND CIVIL ENGINEERING PERFORMANCE SPECIFICATION.
- ANY DISCREPANCIES ARE TO BE REPORTED TO PINNACLE CONSULTING ENGINEERS IMMEDIATELY.
- THIS DRAWING IS TO BE READ IN CONJUNCTION WITH ALL OTHER RELEVANT ENGINEERS, ARCHITECTS AND SUB-CONTRACTORS DRAWINGS AND DETAILS.

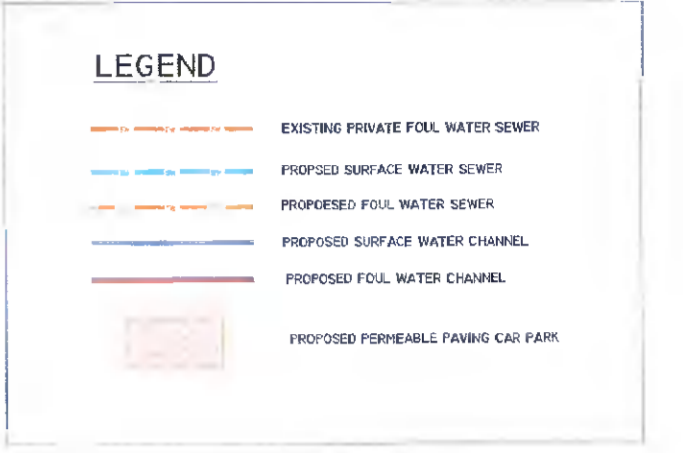

P04	DRAWING UPDATED	FJVR	SCR	NOV '21
P02	DRAWING UPDATED	AB	SO'R	JULY '21
P01	PLANNING	AB	SO'R	DEC '20
REV	DESCRIPTION	BY	CHK	DATE

CLIENT
EDGECONNEX


PROJECT
EDCDUB05 & GAS PLANT

DRAWING TITLE
DRAINAGE LAYOUT ATTENUATION POND AND OUTFALL PLAN

PINNACLE CONSULTING ENGINEERS

GROSVENOR COURT,
 67A PATRICK STREET,
 DUN LAOGHAIRE,
 COUNTY DUBLIN
 IRELAND. TELEPHONE: +353 1231 1041

DRAWING STATUS			
PLANNING			
SCALE @ A1	DATE	DRAWN BY	CHECKED
1:500	DEC '20	JM	JKM
DRG NO.	REVISION		
PIN201107-ZZ-ZZ-DR-DR-0202	P04		

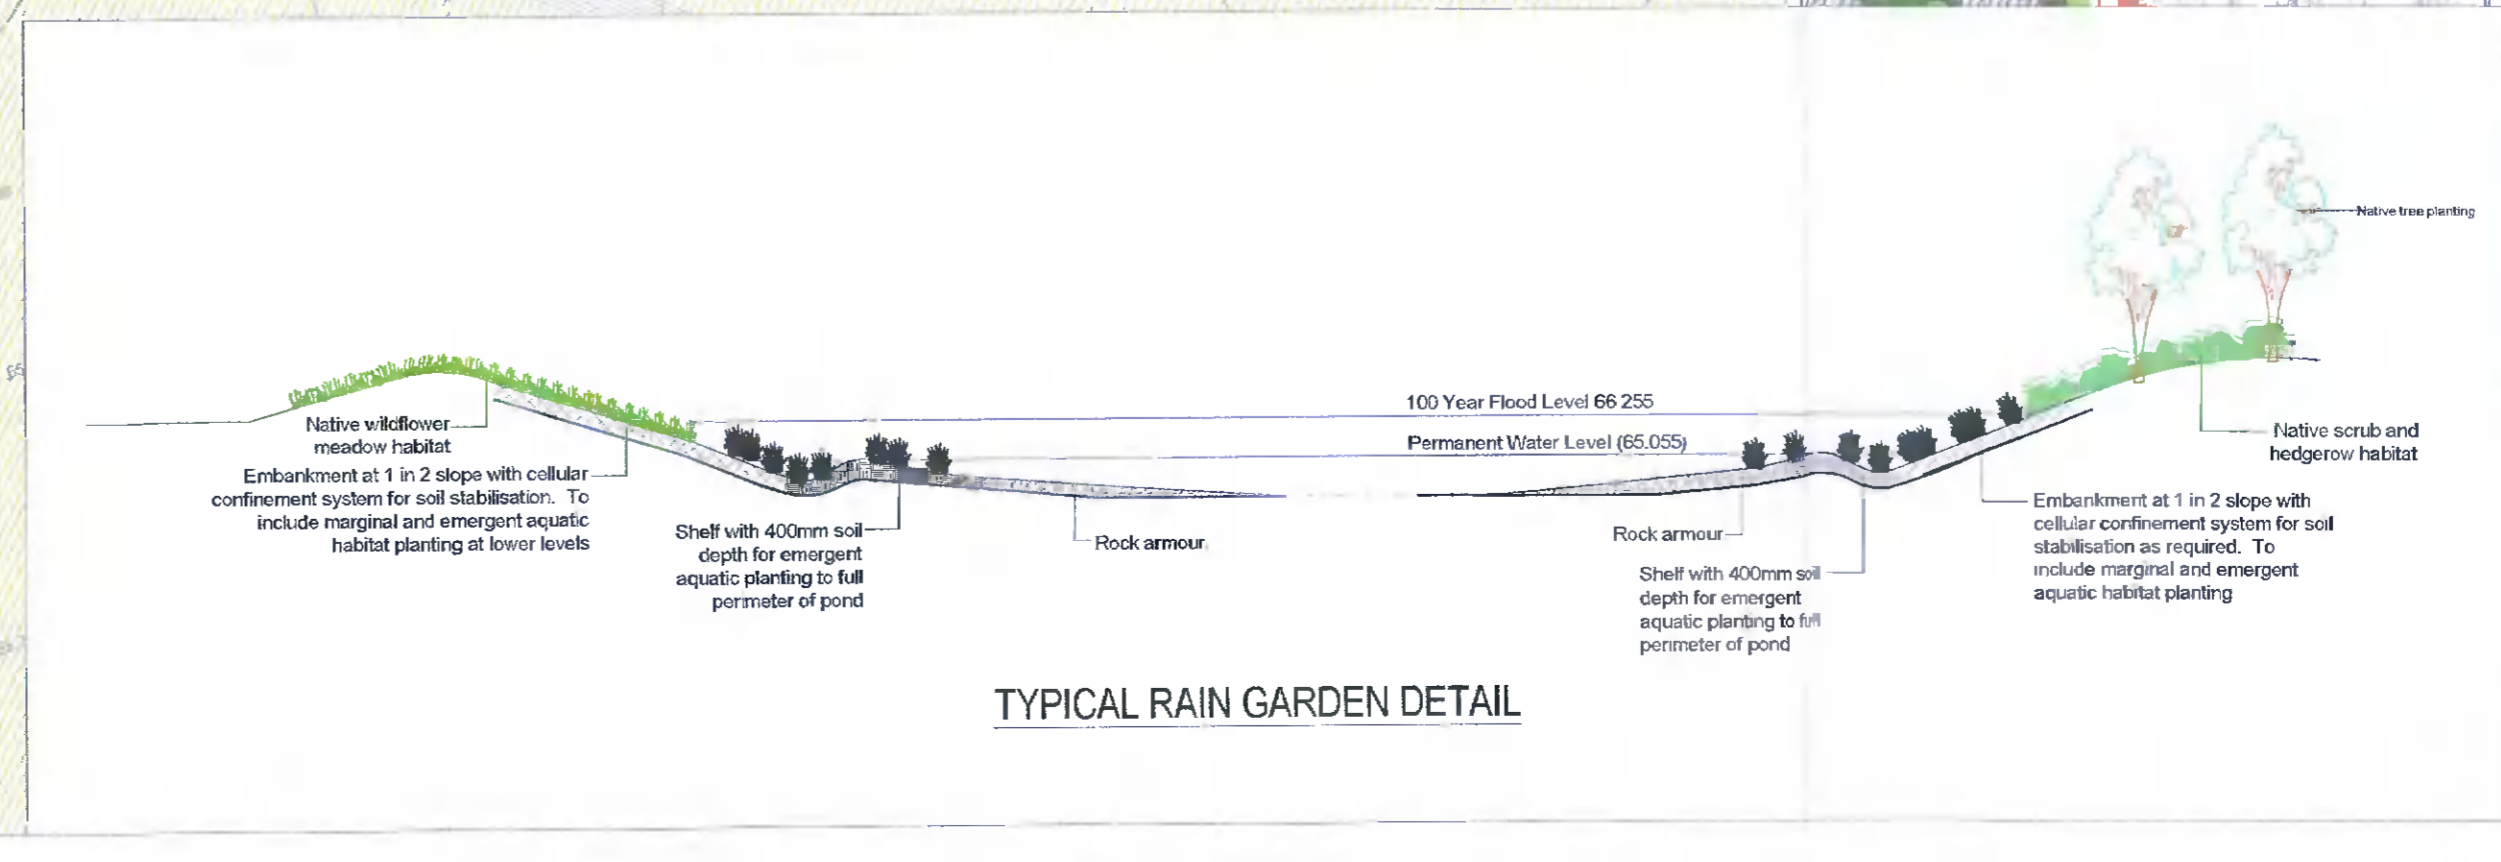

CONTINUE 0201

REF: P201107