


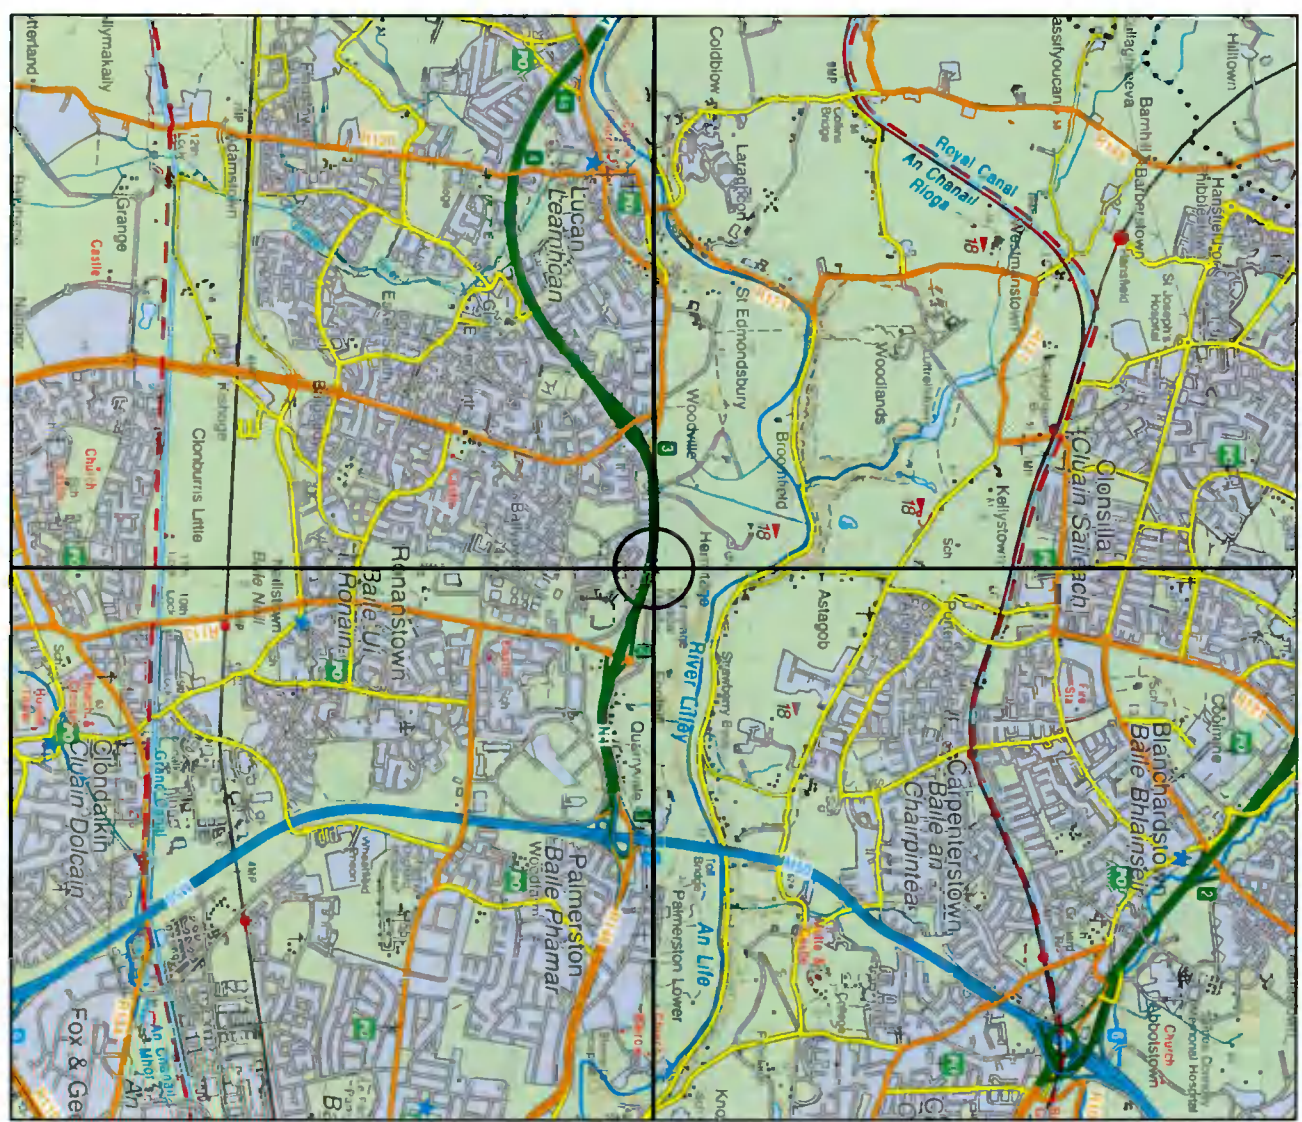

OS LOCATION MAP

Scale 1:50000



Reproduced from the OS Discovery Map Series 1:50000 under licence No. CTAL50167948

Drawing No.	Drawing Title
CIG_02499 / 101 PA	O.S. Location Map & Photos
CIG_02499 / 102 PA	Site Location Map O.S. 1:10560
CIG_02499 / 103 PA	Site Location Map O.S. 1:1000
CIG_02499 / 104 PA	Site Location Plan 1:500
CIG_02499 / 105 PA	Existing Site Layout Plan
CIG_02499 / 106 PA	Proposed Site Layout Plan
CIG_02499 / 107 PA	Existing South-West Elevation
CIG_02499 / 108 PA	Proposed South-West Elevation
CIG_02499 / 109 PA	Structure Elevations
CIG_02499 / 110 PA	Proposed Future Operator (2) Cabinet Details
CIG_02499 / 111 PA	Proposed Future Broadband Operator (3) Cabinet Details
CIG_02499 / 112 PA	Proposed MMU Cabinet Details

SITE PHOTOGRAPHS

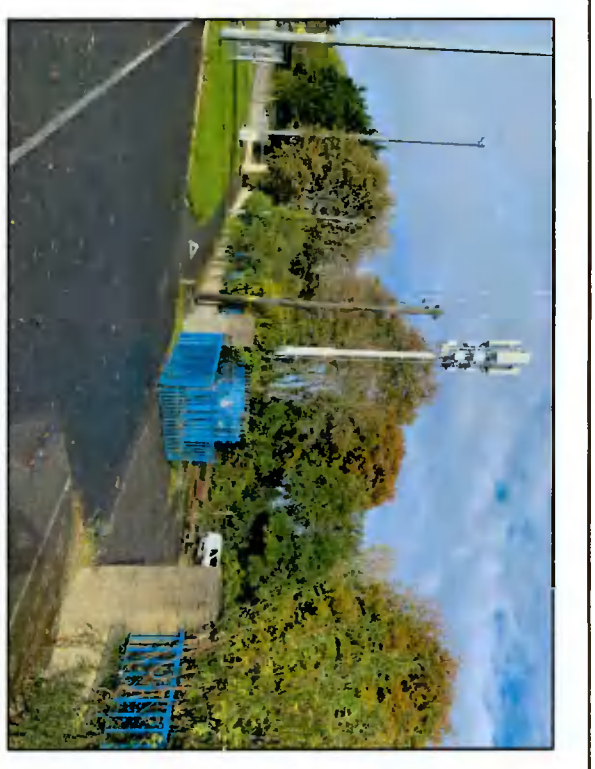


FIG 1. EXISTING ACCESS POINT



FIG 2. EXISTING COMPOUND LOCATION

- GENERAL NOTES**
- Do not scale.
 - All dimensions to be in mm unless specified otherwise.
 - This drawing read in conjunction with the relevant scope of works and all relevant engineers and specialist drawings.
 - All works to be in accordance with the relevant and current health and safety legislation.
 - Specification of the works to be to the appropriate Irish standard or the equivalent British standard.
 - All works to be carried out in strict accordance with project specifications.

No.	Revision	Date	By	Chd
1	EXISTING SITE BOUNDARY IN RED UPDATED AND PROPOSED PLAN & ELEVATION PAGES UPDATED	15/12/2021	SP	ED
2	PLANNING APPLICATION DRAWING	30/11/2021	SM	SMF

celnexus
driving telecom connectivity

Signal Infrastructure Ltd
Suite 311 Q House, 78 Fitzmaurice Road Sandymount
Dublin 18, D18 VY50, IRELAND

INDIGO
ENGINEERING A DIGITAL FUTURE

Coughlekang Avenue,
Rahisken Business Park, Limerick, V94 VJ98,
IRELAND

Site Code	CIG_02499
Structure Height	21m
Structure Type	MONOPOLE
Beam Width	-
Site Name	SUREWELD INTERNATIONAL LTD, FONTHILL, LUCAN, Co. DUBLIN
Title	OS MAP & PHOTOGRAPHS
Author	PLANNING APPLICATION DRAWING
Designed By	LU
Drawn By	SM
Date	29/11/2021
Scale	AS SHOWN
Dwg. No.	CIG_02499 - 101 PA
Rev.	A