



Proposed site plan

Scale 1 to 500

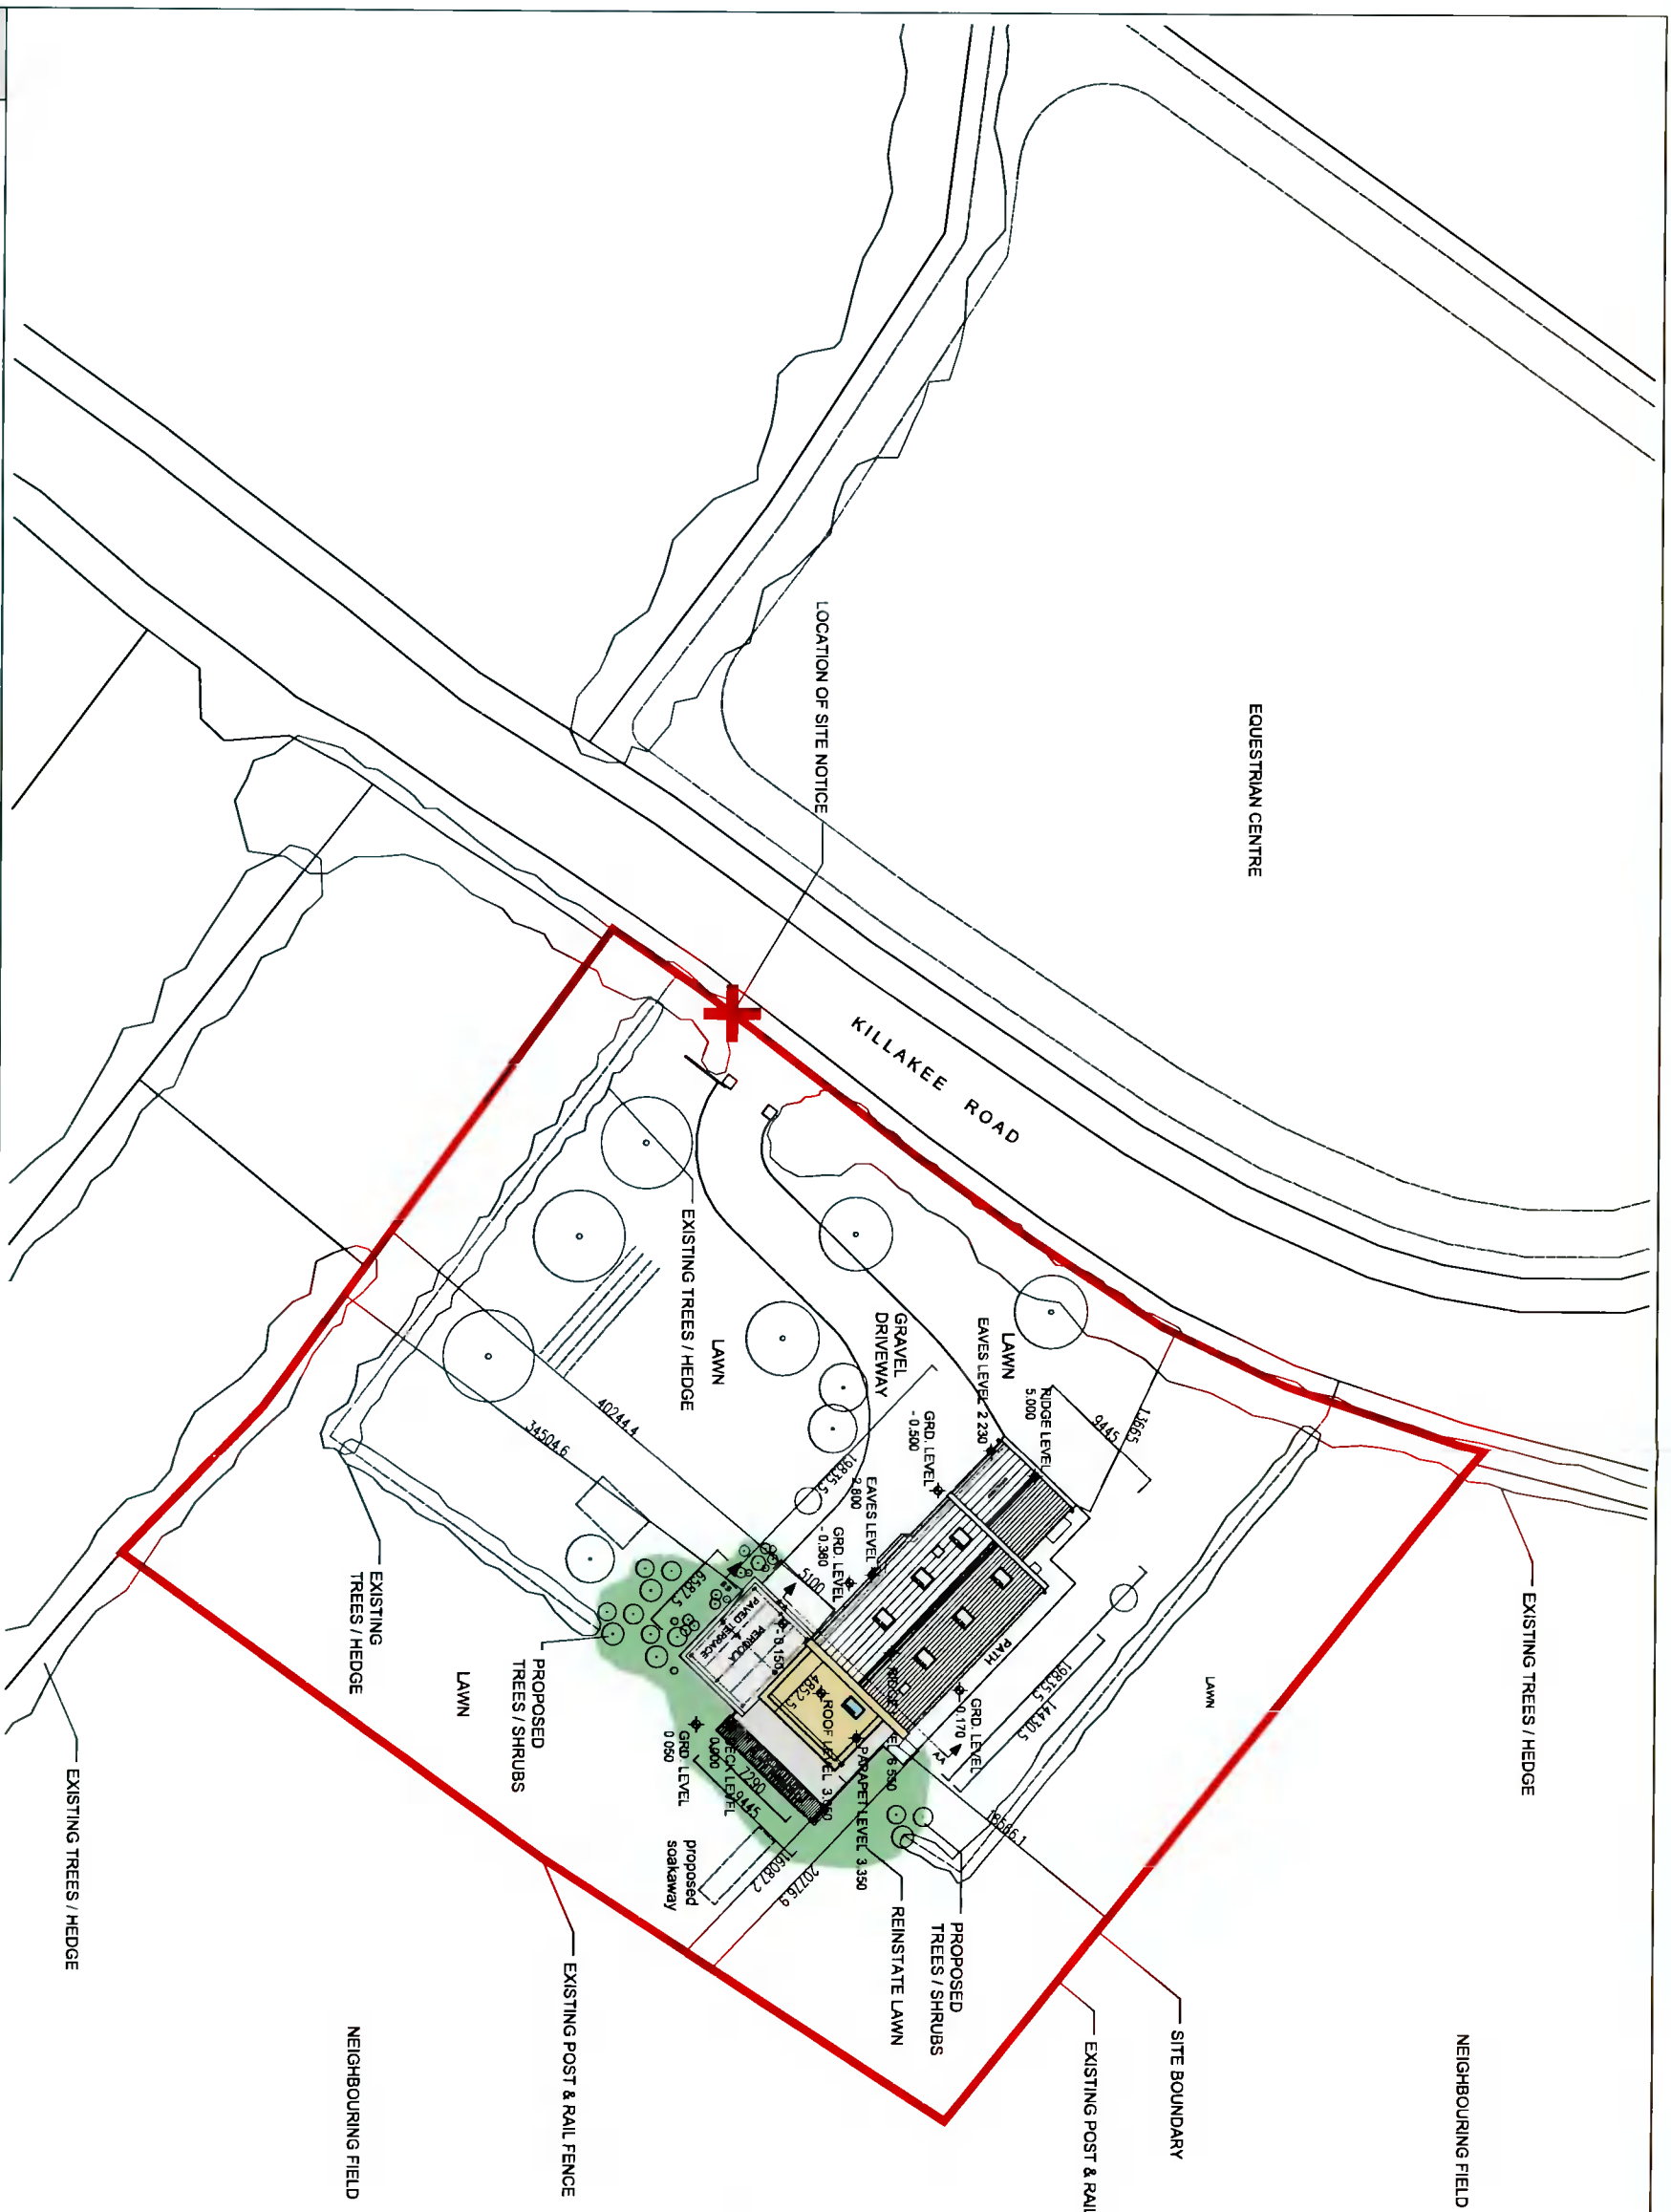

refer to drainage drawing for information on septic tank / percolation area & soakaways

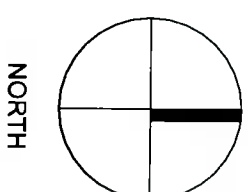

NO	DATE	DESCRIPTION	DRAWN BY	CHECKED BY	APP

PLANNING DRAWING

FOR THE PROPOSED ADDITIONS & ALTERATIONS TO MAISON, KILLAKEE, RATHFRANKHAM DUBLIN 16 A274

CLIENT LYNDA & IAN BRADSHAW-DUNN

TITLE PROPOSED SITE PLAN

DRAWING NO 21002PL1002

SCALE 1:500

DATE 10 DEC 2021

CLIENT EVP ARCHITECT

16, BEDDOOLE ROAD BALLYCULLEN DUBLIN 24

TEL 00353 1 9063327

